


Symbol	Label	QTY	Catalog Number	Description	Number Lamps	Lumens per Lamp	LLF	Wattage	Mounting height	Distribution
○	OA	15	P5675-3130K	5" 17W LED Direct/Indirect Cylinder	1	829	1	33.9	8'	
⊙	OD1	2	DSX0 LED P6 40K T3M MVOLT	DSX0 LED P6 40K T3M MVOLT	1	15508	1	134	20'	TYPE III, MEDIUM, BUG RATING: B3 - U0 - G3
⊙	OD2	1	DSX0 LED P6 40K T5M MVOLT	DSX0 LED P6 40K T5M MVOLT	1	16575	1	134	20'	TYPE VS, BUG RATING: B4 - U0 - G2
⊙	OD3	2	DSX0 LED P6 40K T5M MVOLT	DSX0 LED P6 40K T5M MVOLT	1	16575	1	268	20'	TYPE VS, BUG RATING: B4 - U0 - G2
□	X.09	5	CRUS-SC-LED-LW-50		1	10524	1	73.5	9.5'	

Description	Symbol	Avg	Max	Min	Max/Min	Avg/Min
Parking Lot Area	+	4.0 fc	35.4 fc	0.1 fc	354.0:1	40.0:1
Property Zone	+	0.6 fc	4.5 fc	0.0 fc	N/A	N/A

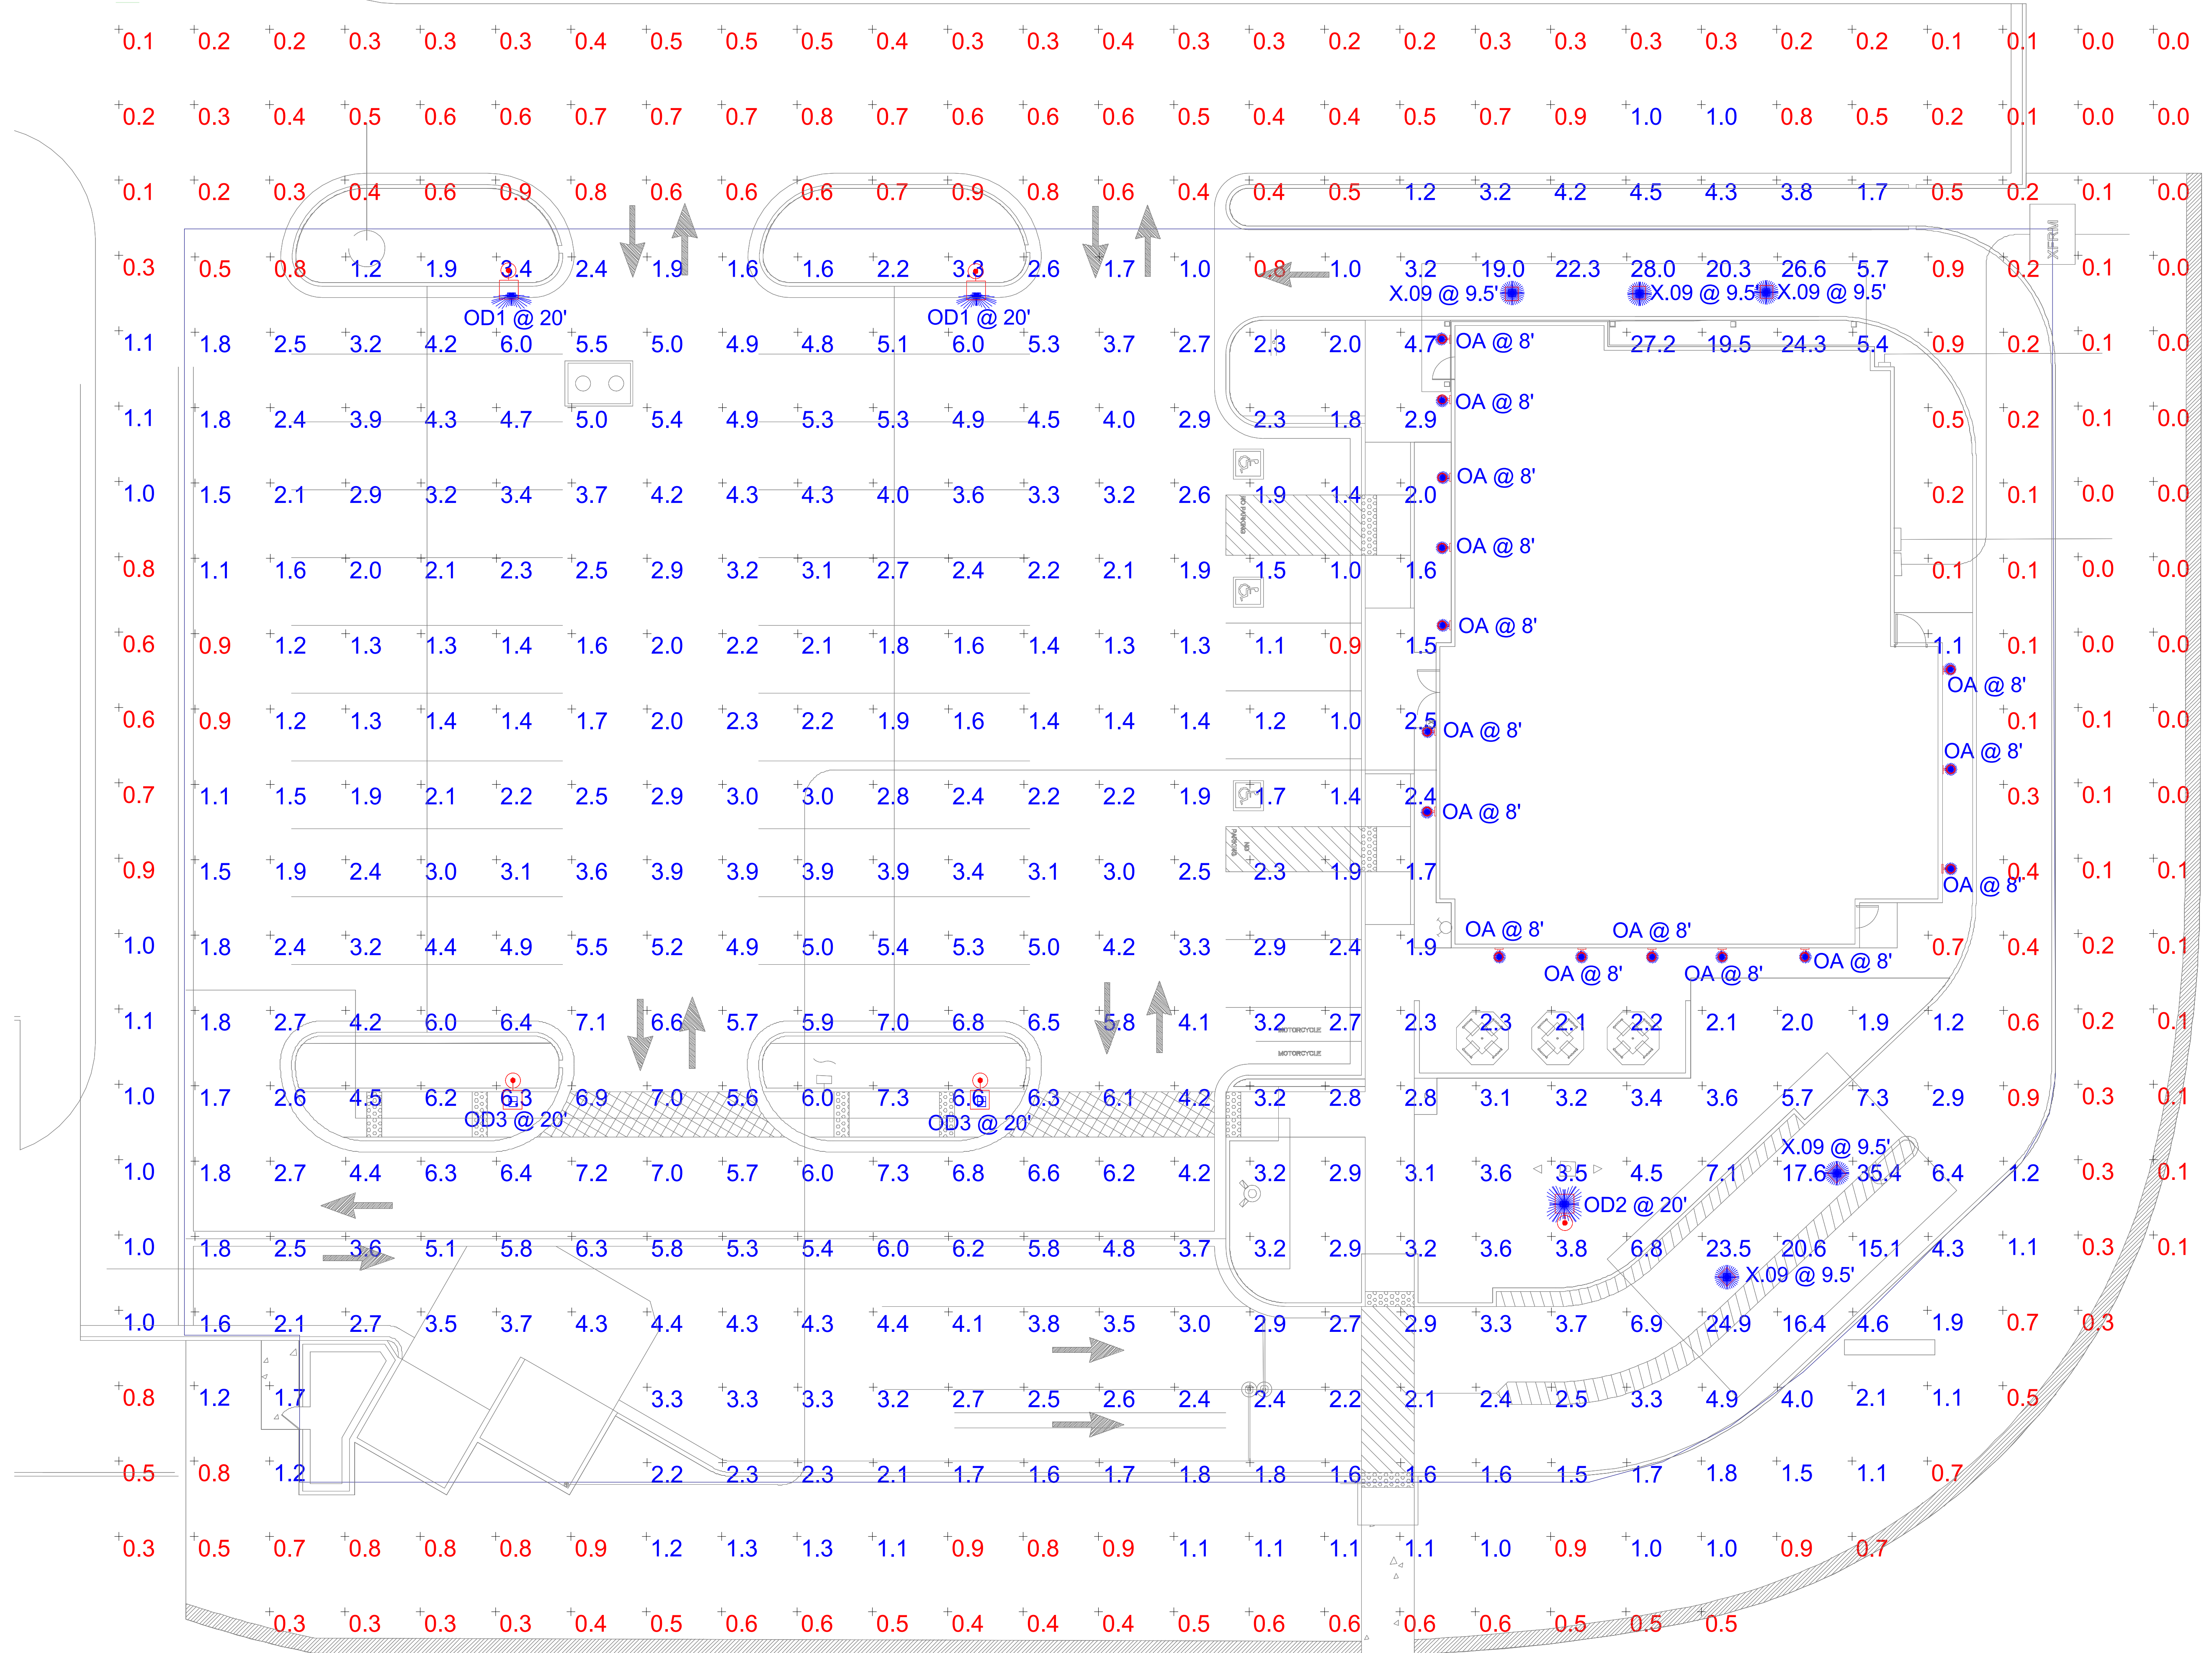

Chick-fil-A
 5200 Buffington Road
 Atlanta, Georgia
 30349-2998



1700 INDUSTRIAL DRIVE
 SUITE B
 ROGERS, AR 72756
 479.986.440
 www.core-eng.com



CHICK-FIL-A
 ALBUQUERQUE, NM
 COORS BLVD AND ST JOSEPH'S DR
 ALBUQUERQUE, NM 87120

FSR#04107
 BUILDING TYPE / SIZE: P12 SE LRG
 RELEASE: v2_18.08

NO.	DATE	DESCRIPTION

CONSTRUCTION DOCUMENTS

CONSULTANT PROJECT # 25779
 PRINTED FOR CONSTRUCTION DOCUMENTS
 DATE 11/05/18
 DRAWN BY K.HUNG

Information contained on this drawing and in all digital files produced for above named project may not be reproduced in any manner without express written or verbal consent from authorized project representatives.
 SHEET: PHOTOMETRICS SITE PLAN
 SHEET NUMBER

E-110

BIM:360/NNM_04107_Coors Blvd_Albuquerque_FSR_P12_SE_LRG4107_Albuquerque NM_P12_SE_ELE_v2_18.08.rvt
 7/26/2019 12:25:24 PM
 50-SE-04107-E-110-PHOTOMETRICS SITE PLAN