

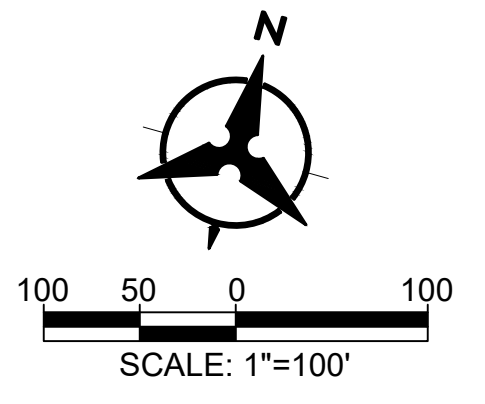


REVISIONS	
△	
△	
△	
△	
△	
△	

DRAWN BY	BO
REVIEWED BY	GSB
DATE	01/17/2020
PROJECT NO.	19-0008
DRAWING NAME	

OVERALL
SITE UTILITY PLAN

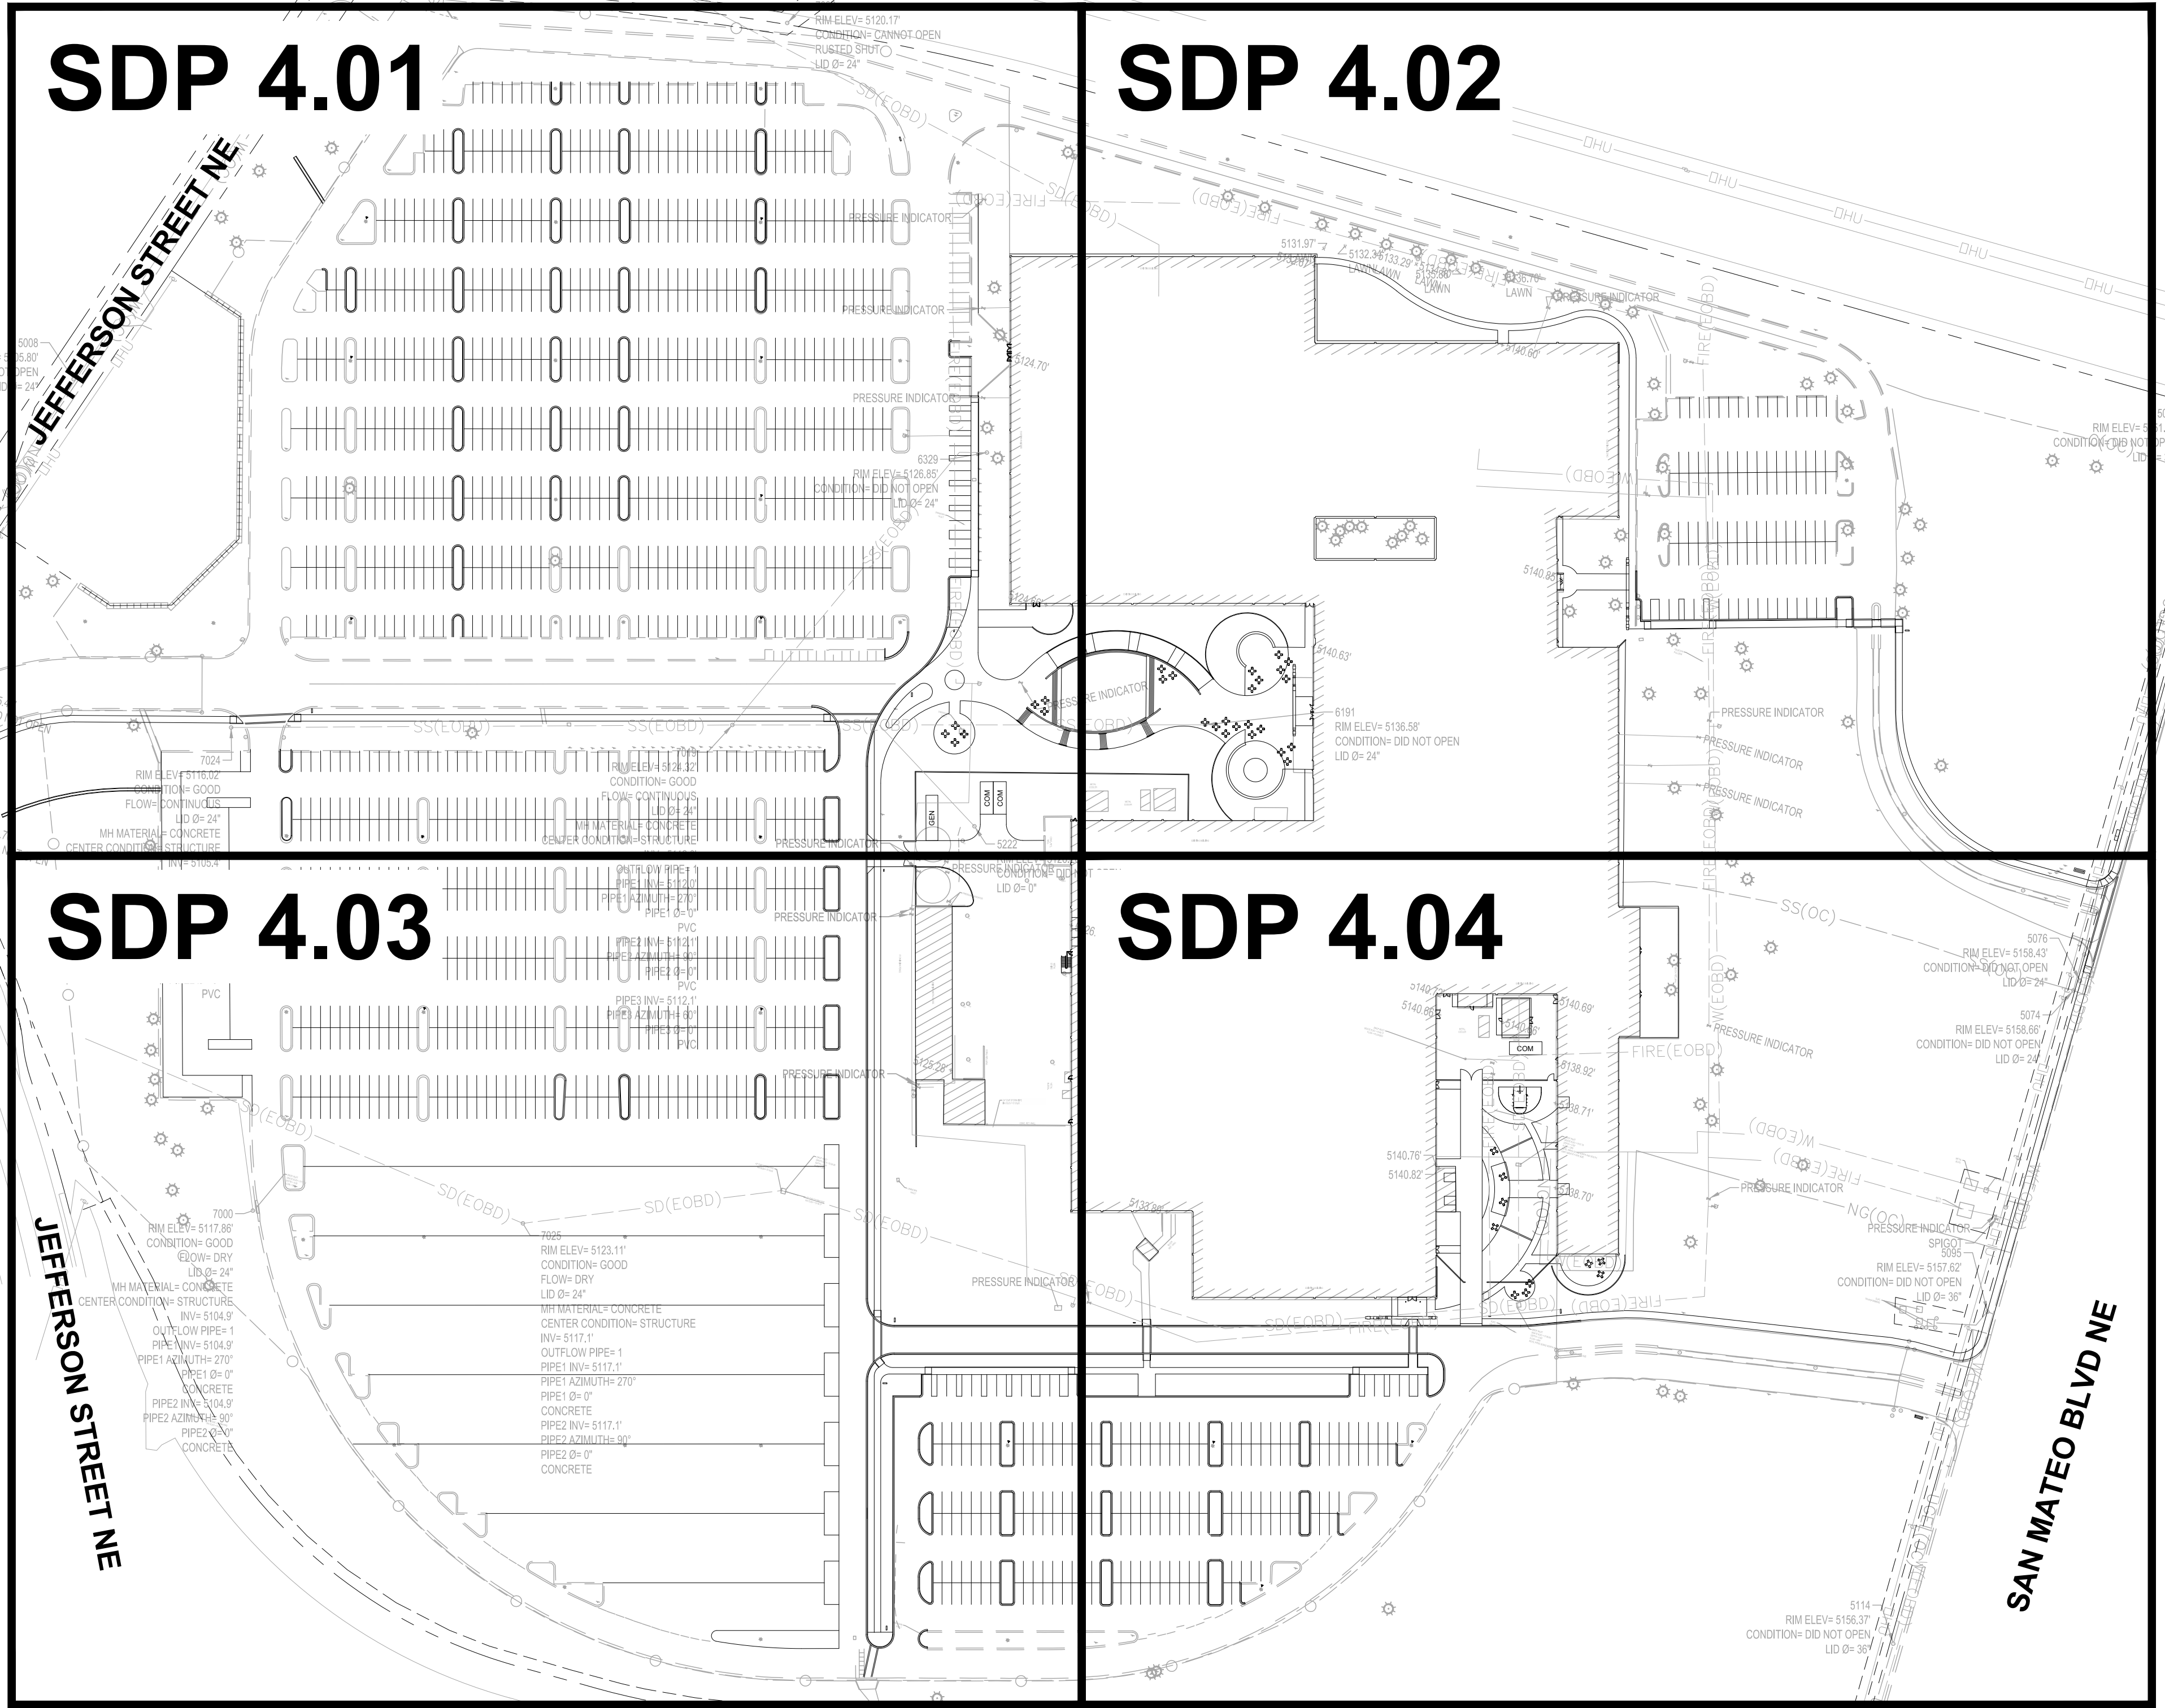

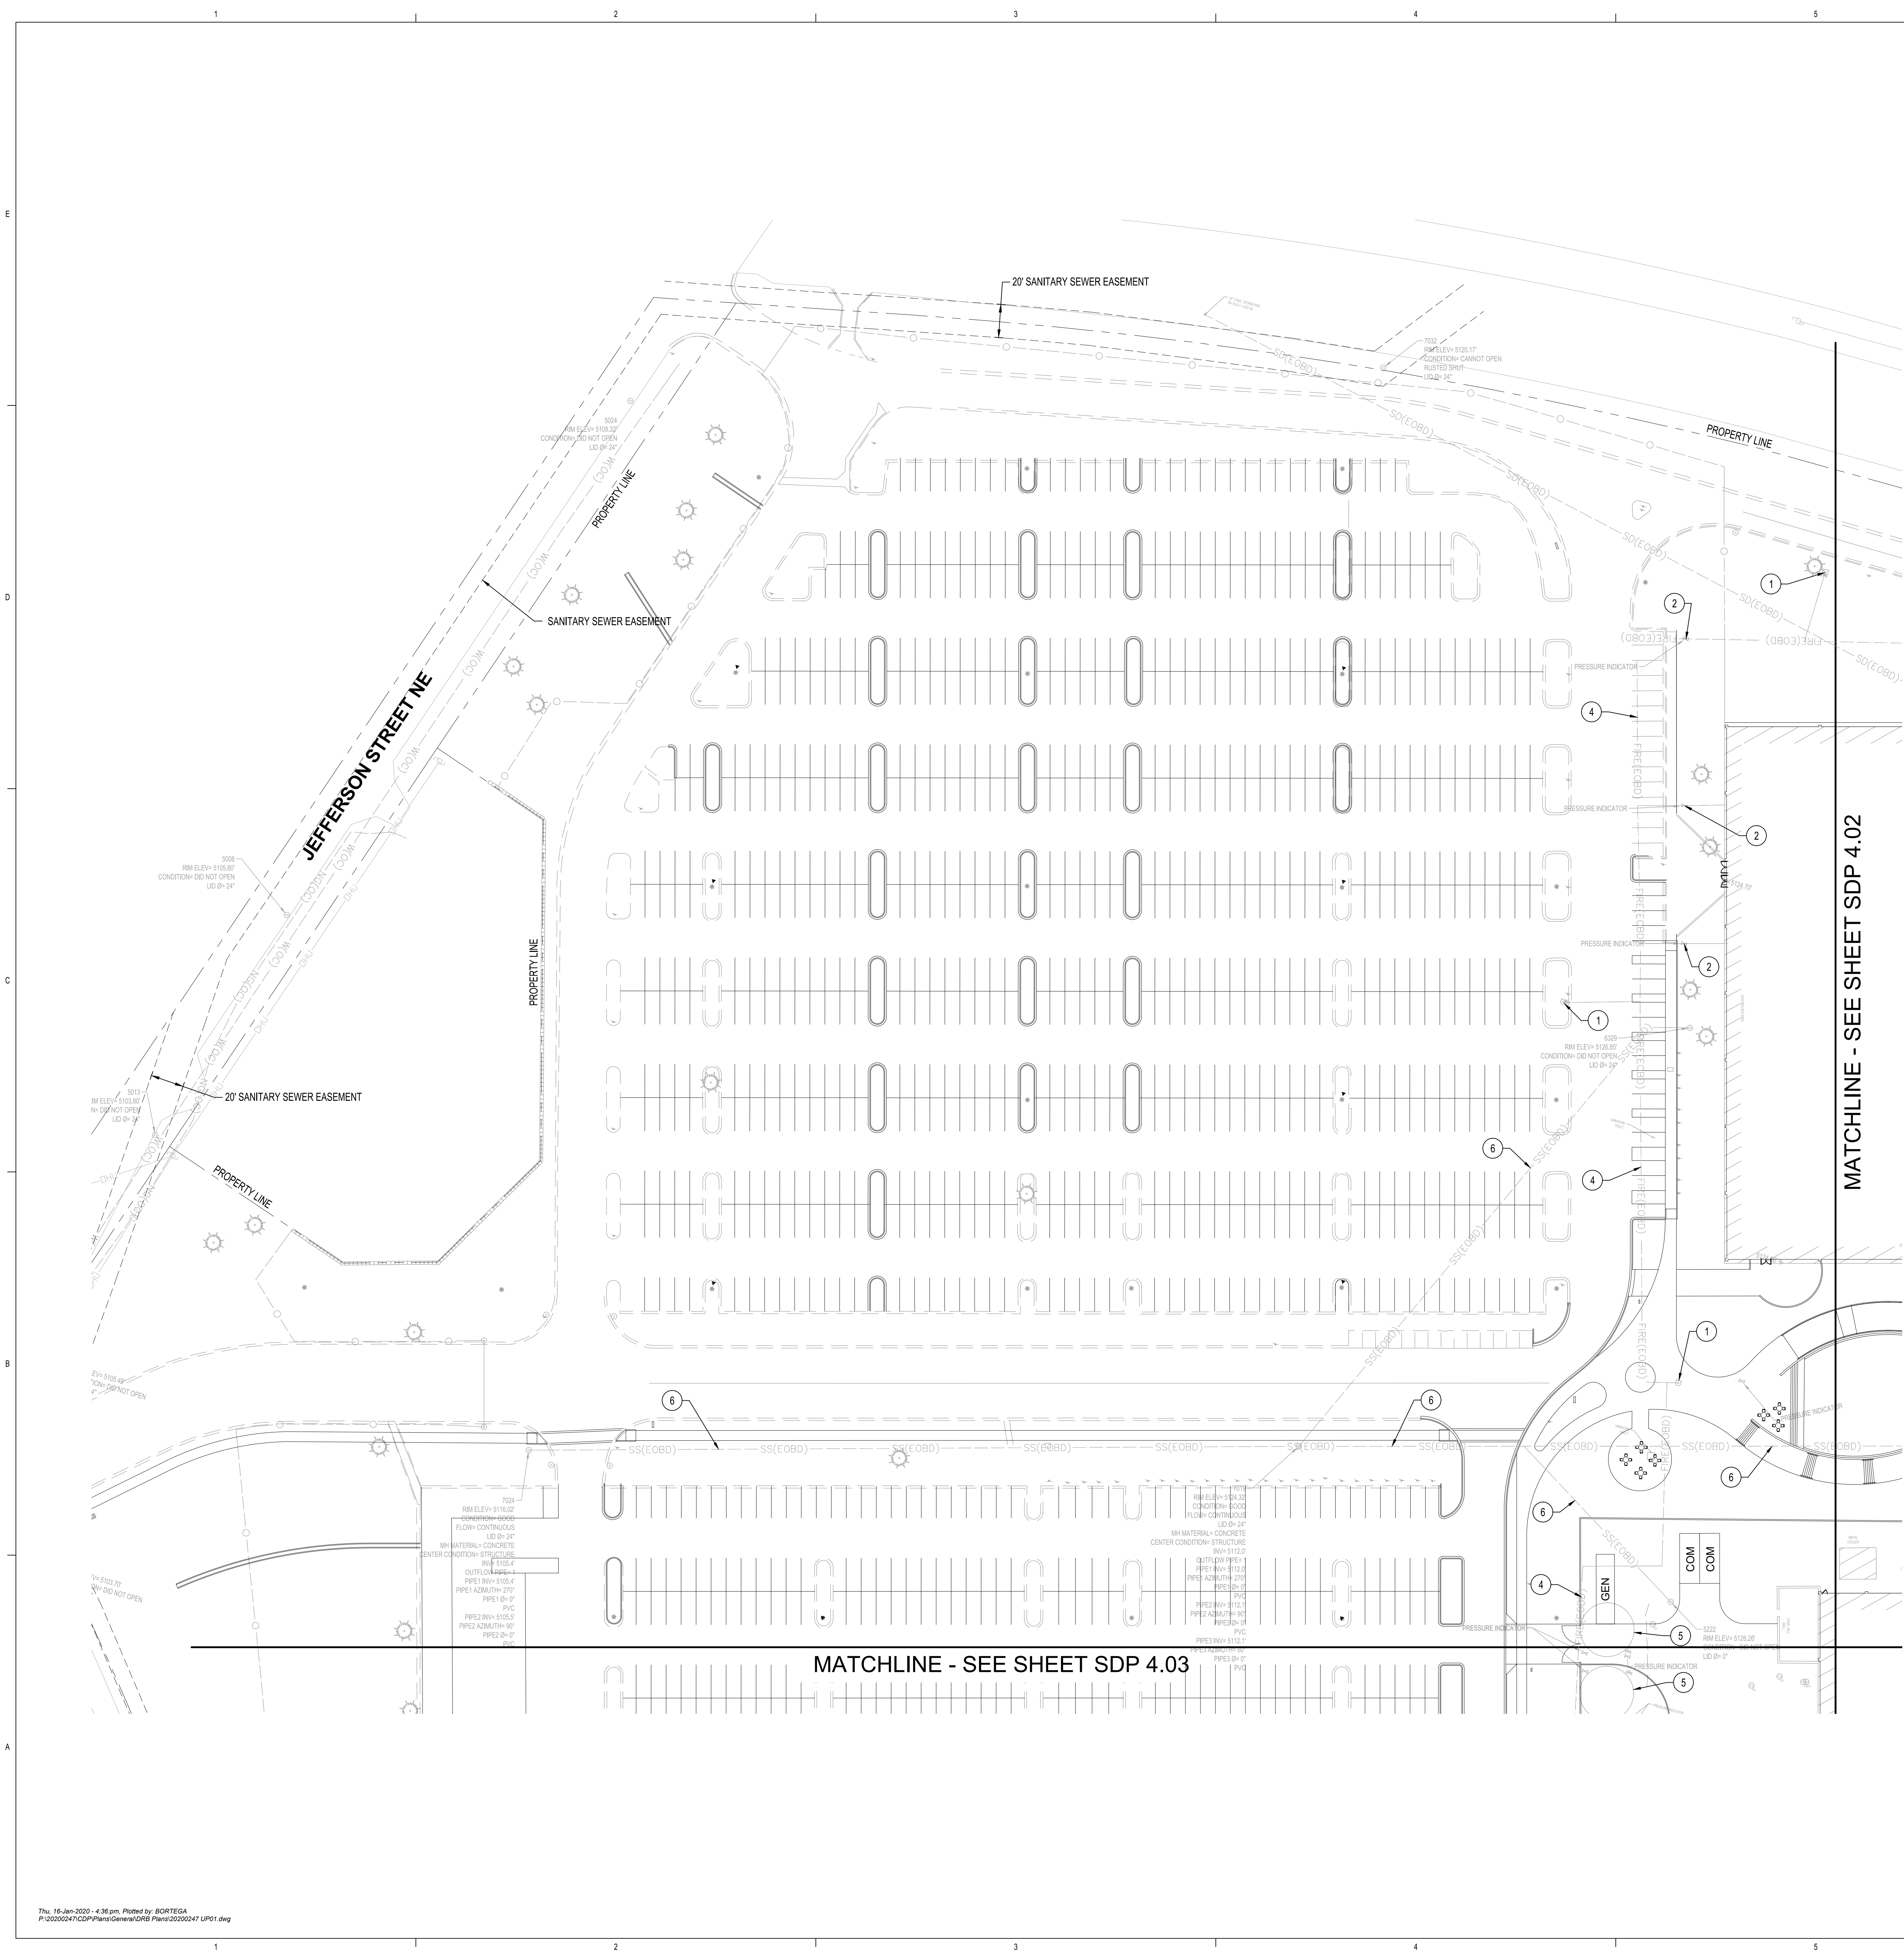

KEYED NOTES

- EXISTING FIRE HYDRANT.
- EXISTING POST INDICATOR VALVE (PIV).
- EXISTING 18" FIRE PROTECTION LINE.
- EXISTING 12" FIRE PROTECTION LINE.
- EXISTING FIRE WATER SUPPLY TANKS TO BE REMOVED.
- EXISTING SANITARY SEWER SERVICE LINE.
- EXISTING GAS SERVICE LINE.
- DOMESTIC BACKFLOW PREVENTOR.
- FIRE PROTECTION BACKFLOW PREVENTOR.

NOTE: NOT ALL KEYED NOTES MAY APPLY TO THIS SHEET.

UTILITY LEGEND

- W(EODB) EXISTING WATER LINE
- SS(EODB) EXISTING SANITARY SEWER LINE
- FIRE (EODB) EXISTING FIRE WATER LINE
- SD(EODB) EXISTING STORM DRAIN LINE
- NG(OC) EXISTING NATURAL GAS LINE
- C(OC) EXISTING COMM LINE
- UGEL(OC) EXISTING UNDERGROUND ELECTRIC LINE


DEKKER
PERICH
SABATINI

ARCHITECTURE
DESIGN
INSPIRATION

ARCHITECT

PRELIMINARY
NOT FOR CONSTRUCTION

ENGINEER

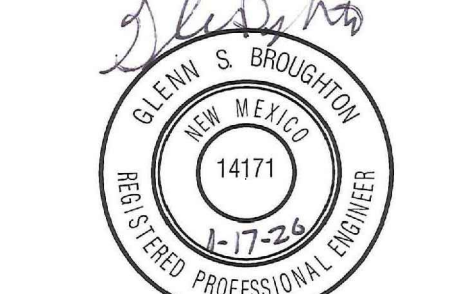

NOT FOR CONSTRUCTION

PROJECT

PHS ALOFT PLAZA

9201 SAN MATEO
ALBUQUERQUE, NM 87113

DRB
SUBMITTAL


REVISIONS

- △
- △
- △
- △
- △
- △

DRAWN BY	BO
REVIEWED BY	GSB
DATE	01/17/2020
PROJECT NO.	19-0008
DRAWING NAME	SITE UTILITY PLAN

SHEET NO.

SDP 4.01
OF

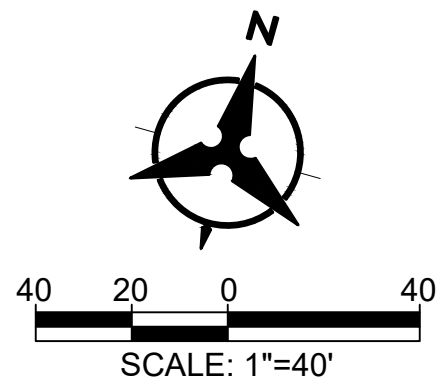

Bohannon & Huston
www.bhnc.com 800.877.5332



KEYED NOTES


1. EXISTING FIRE HYDRANT.
2. EXISTING POST INDICATOR VALVE (PIV).
3. EXISTING 18" FIRE PROTECTION LINE.
4. EXISTING 12" FIRE PROTECTION LINE.
5. EXISTING FIRE WATER SUPPLY TANKS TO BE REMOVED.
6. EXISTING SANITARY SEWER SERVICE LINE.
7. EXISTING GAS SERVICE LINE.
8. DOMESTIC BACKFLOW PREVENTER.
9. FIRE PROTECTION BACKFLOW PREVENTOR.

NOTE: NOT ALL KEYED NOTES MAY APPLY TO THIS SHEET.

UTILITY LEGEND

- W(E OBD) EXISTING WATER LINE
- SS(E OBD) EXISTING SANITARY SEWER LINE
- FIRE (E OBD) EXISTING FIRE WATER LINE
- SD(E OBD) EXISTING STORM DRAIN LINE
- NG(OC) EXISTING NATURAL GAS LINE
- C(OC) EXISTING COMM LINE
- UGEL(OC) EXISTING UNDERGROUND ELECTRIC LINE

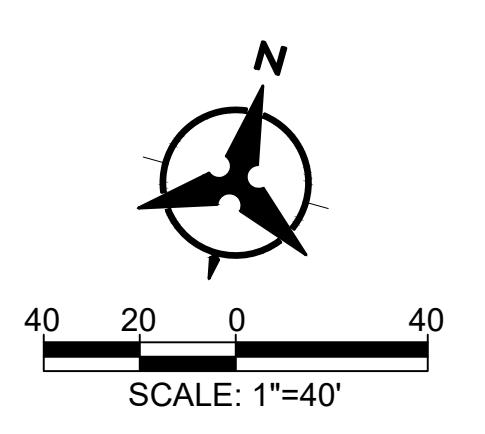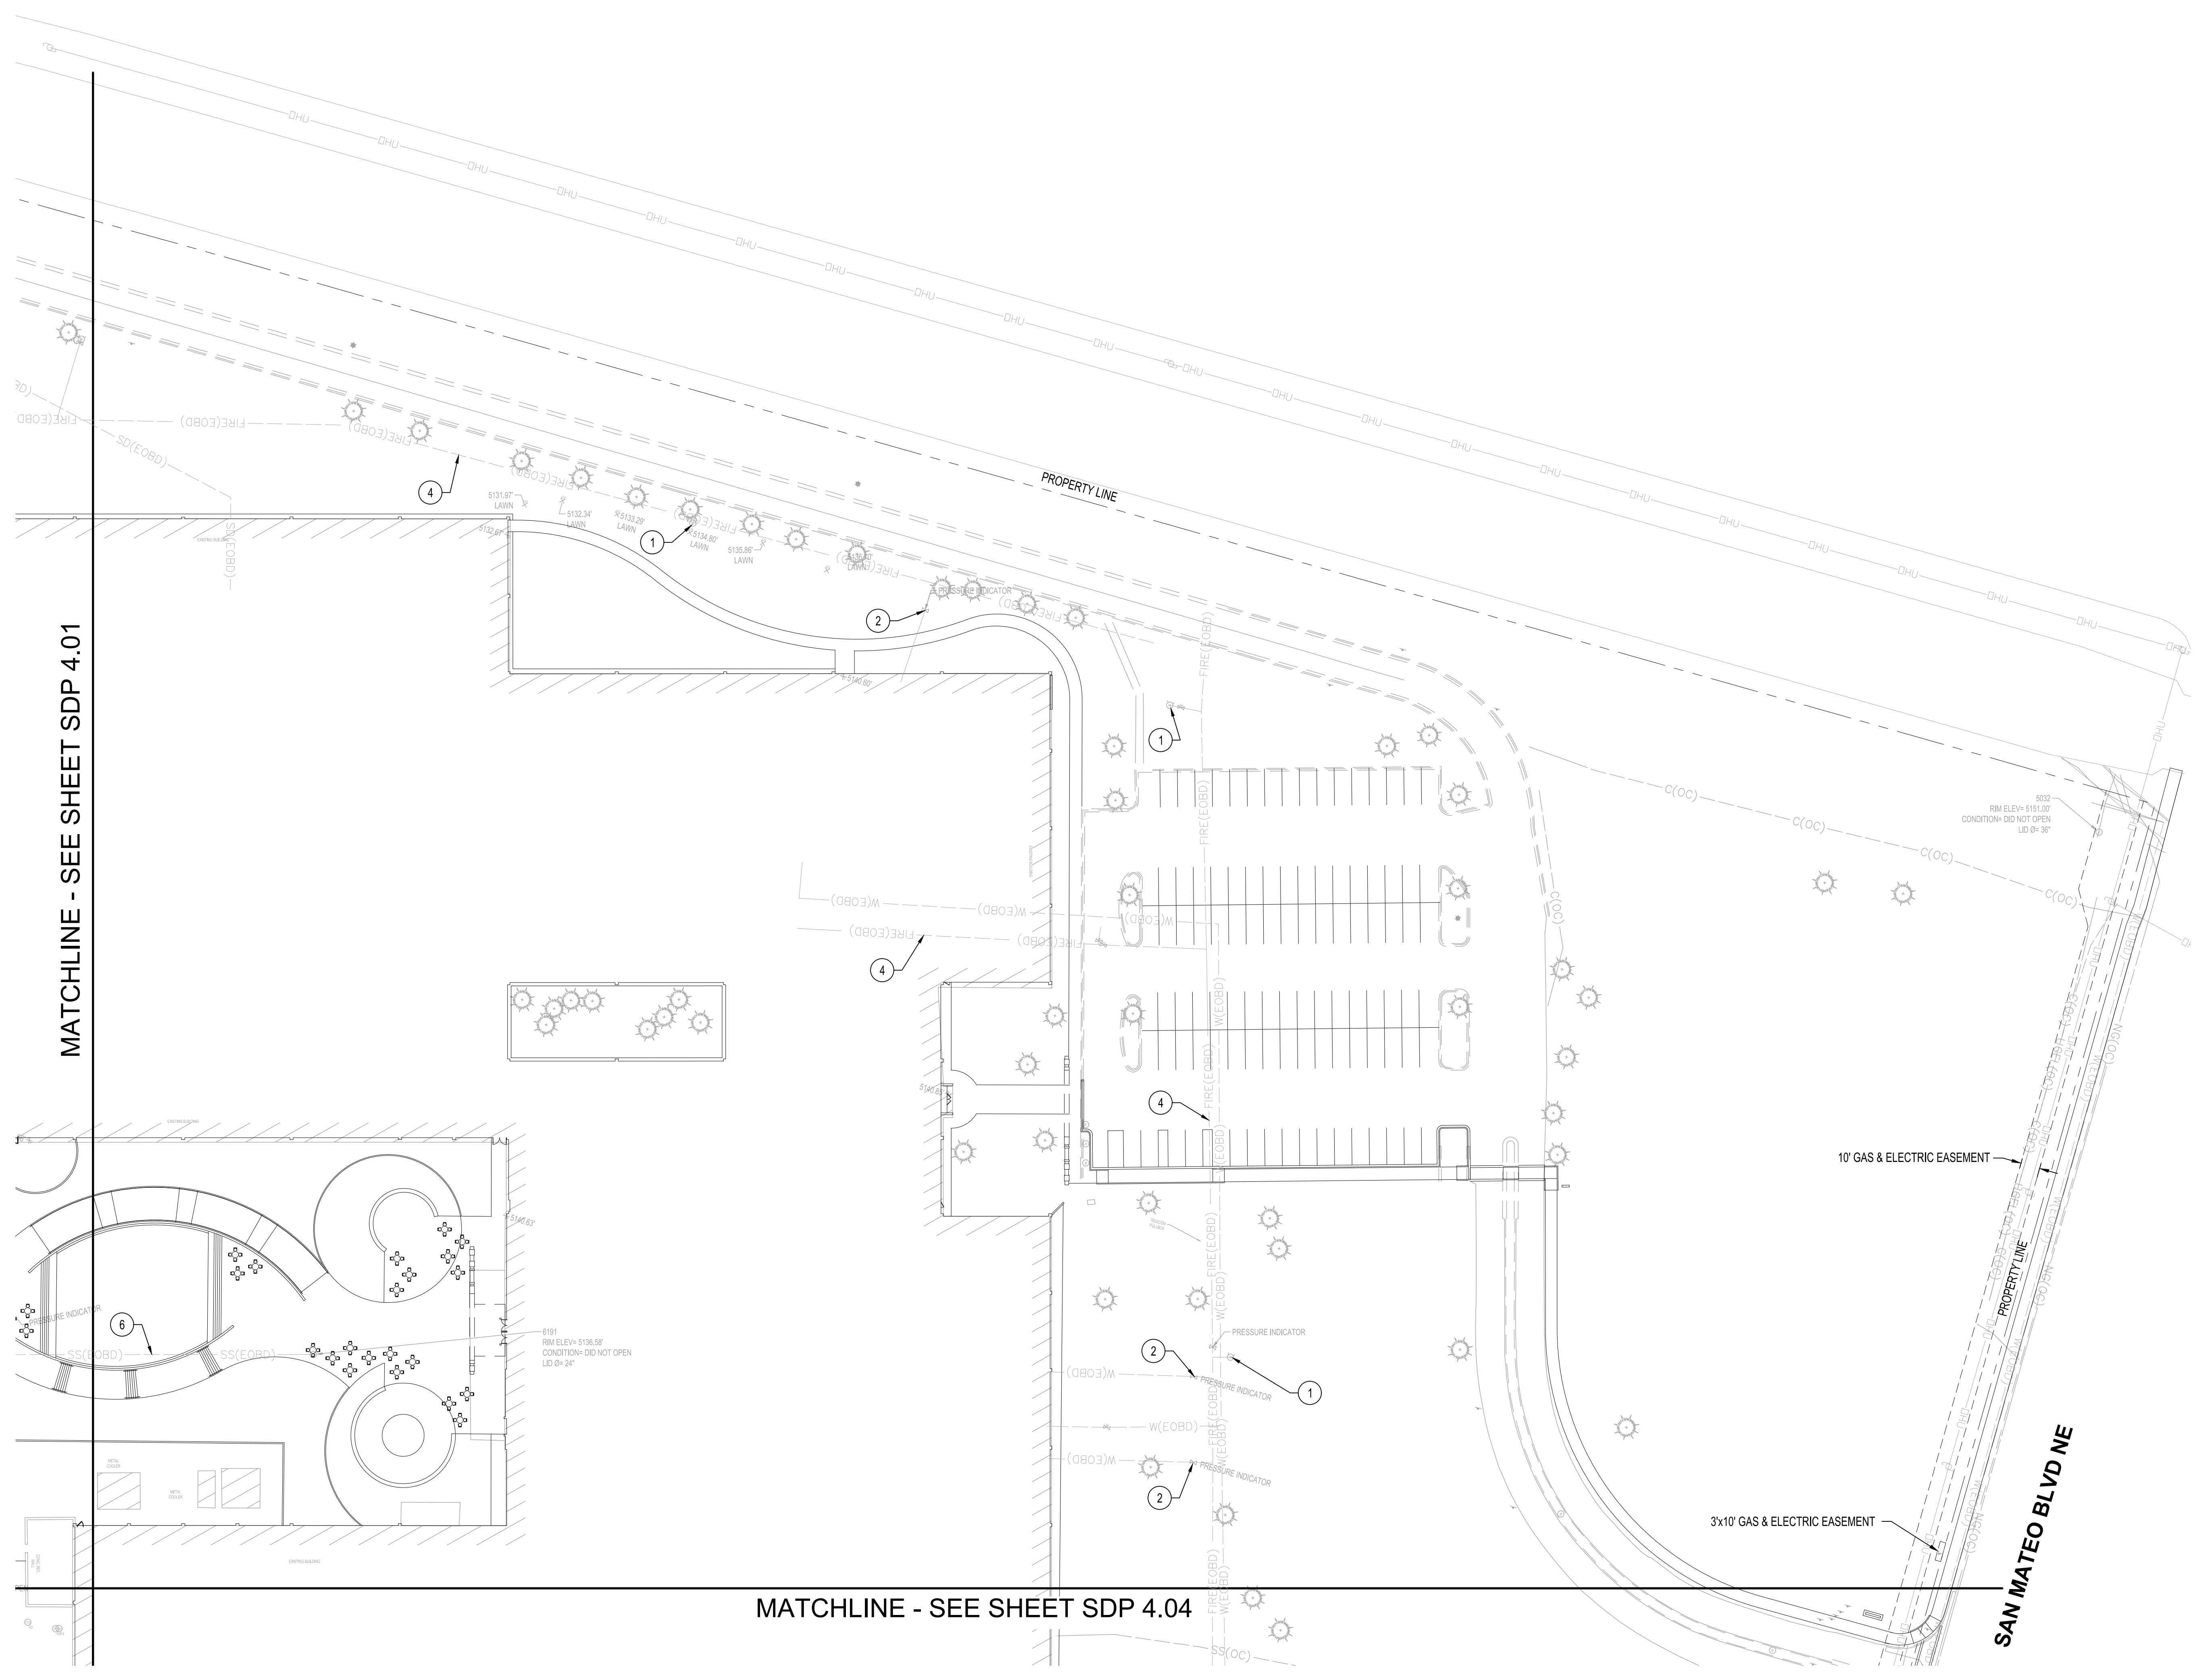

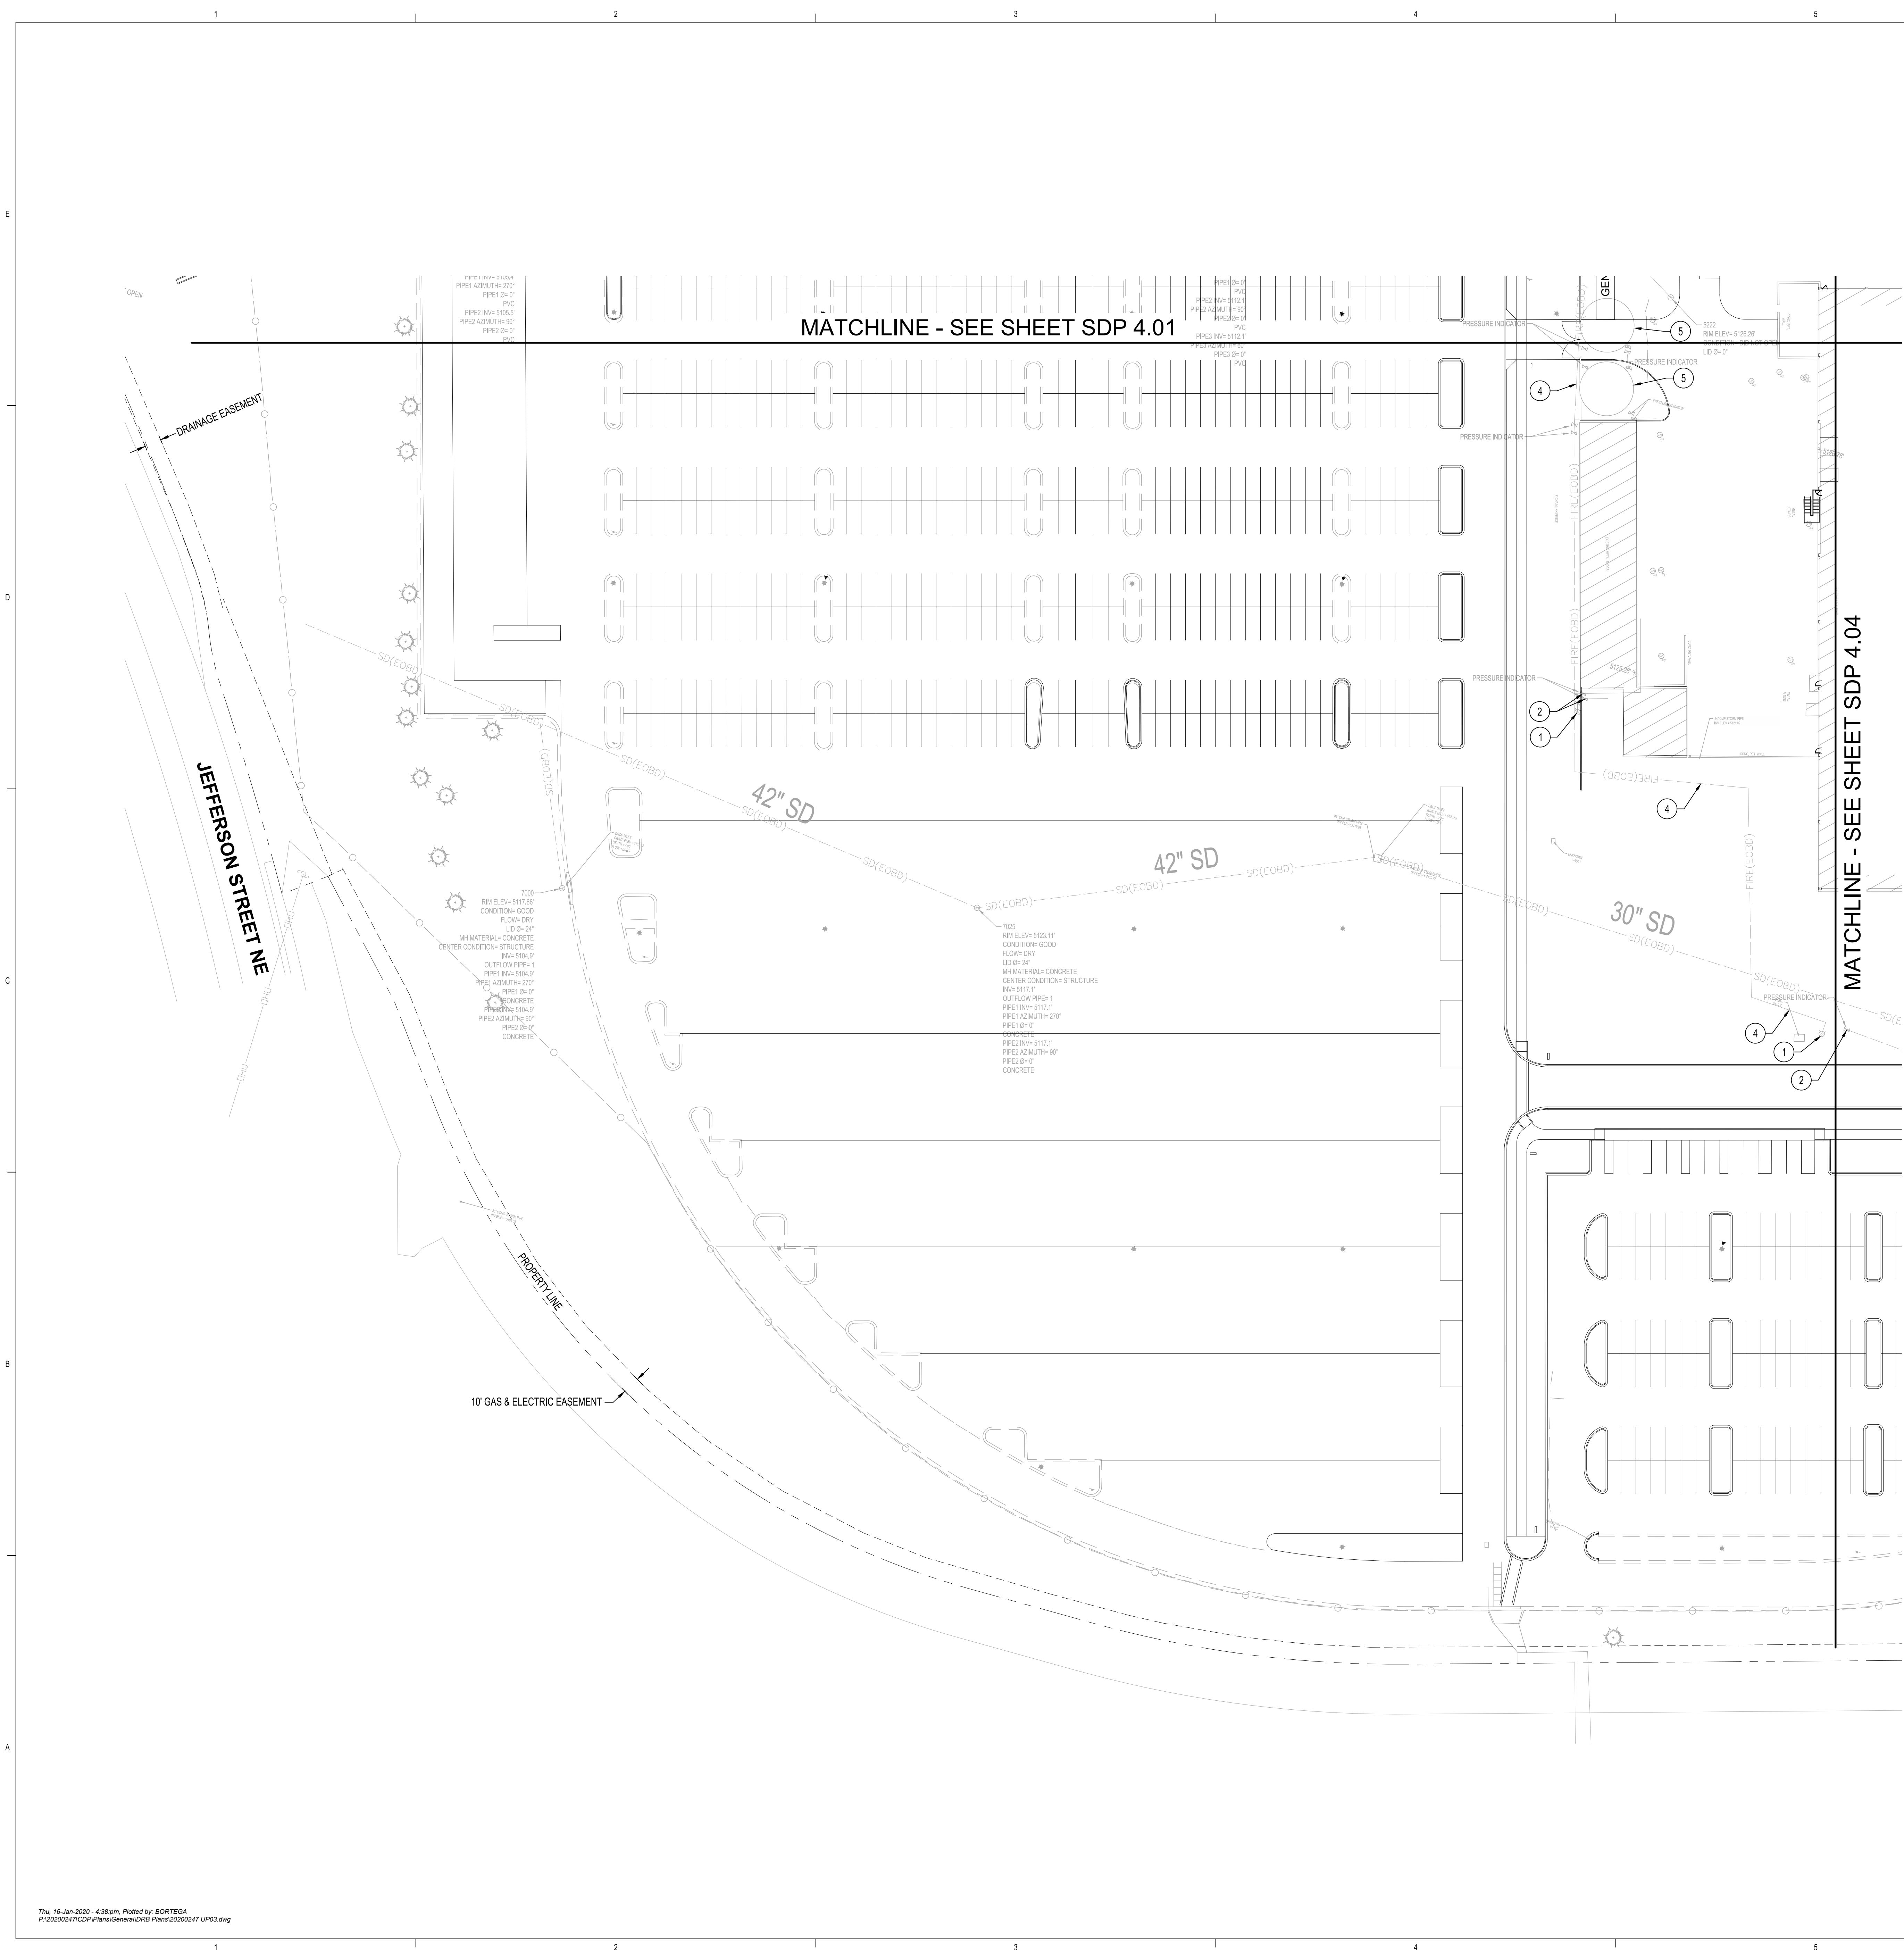

KEYED NOTES

- EXISTING FIRE HYDRANT.
- EXISTING POST INDICATOR VALVE (PIV).
- EXISTING 18" FIRE PROTECTION LINE.
- EXISTING 12" FIRE PROTECTION LINE.
- EXISTING FIRE WATER SUPPLY TANKS TO BE REMOVED.
- EXISTING SANITARY SEWER SERVICE LINE.
- EXISTING GAS SERVICE LINE.
- DOMESTIC BACKFLOW PREVENTOR.
- FIRE PROTECTION BACKFLOW PREVENTOR.

NOTE: NOT ALL KEYED NOTES MAY APPLY TO THIS SHEET.

UTILITY LEGEND

- W(EOBD) — EXISTING WATER LINE
- SS(EOBD) — EXISTING SANITARY SEWER LINE
- FIRE (EOBD) — EXISTING FIRE WATER LINE
- SD(EOBD) — EXISTING STORM DRAIN LINE
- NG(OC) — EXISTING NATURAL GAS LINE
- C(OC) — EXISTING COMM LINE
- UGEL(OC) — EXISTING UNDERGROUND ELECTRIC LINE

DEKKER
PERICH
SABATINI

ARCHITECTURE
DESIGN
INSPIRATION

ARCHITECT

PRELIMINARY
NOT FOR CONSTRUCTION

ENGINEER

NOT FOR CONSTRUCTION
PROJECT

PHS ALOFT PLAZA

9201 SAN MATEO
ALBUQUERQUE, NM 87113

DRB
SUBMITTAL

REVISIONS

DRAWN BY	BO
REVIEWED BY	GSB
DATE	01/17/2020
PROJECT NO.	19-0008
DRAWING NAME	SITE UTILITY PLAN

SHEET NO.

SDP 4.03

OF

KEYED NOTES

- EXISTING FIRE HYDRANT.
- EXISTING POST INDICATOR VALVE (PIV).
- EXISTING 18" FIRE PROTECTION LINE.
- EXISTING 12" FIRE PROTECTION LINE.
- EXISTING FIRE WATER SUPPLY TANKS TO BE REMOVED.
- EXISTING SANITARY SEWER SERVICE LINE.
- EXISTING GAS SERVICE LINE.
- DOMESTIC BACKFLOW PREVENTER.
- FIRE PROTECTION BACKFLOW PREVENTOR.

NOTE: NOT ALL KEYED NOTES MAY APPLY TO THIS SHEET.

UTILITY LEGEND

- W(E,OBD) EXISTING WATER LINE
- SS(E,OBD) EXISTING SANITARY SEWER LINE
- FIRE (E,OBD) EXISTING FIRE WATER LINE
- SD(E,OBD) EXISTING STORM DRAIN LINE
- NG(O,C) EXISTING NATURAL GAS LINE
- C(O,C) EXISTING COMM LINE
- UGEL(O,C) EXISTING UNDERGROUND ELECTRIC LINE

