



DWG FILE: C:\p\aw\p\1\Mesquite\41632858\PH3_DRB_STPL.dwg
 SAVE DATE: Apr 30, 2020 12:10 PM BY: Mesquite\RS
 XREFS:\X001\STPL.dwg CR3\WP001.dwg AW3\HWPL.dwg SW3\SWPL.dwg CWP002CCV.dwg E003\W3PL.dwg X_COT_BORDER_PHS.dwg RJP_NMISTAMP.dwg CWP004CCV.dwg

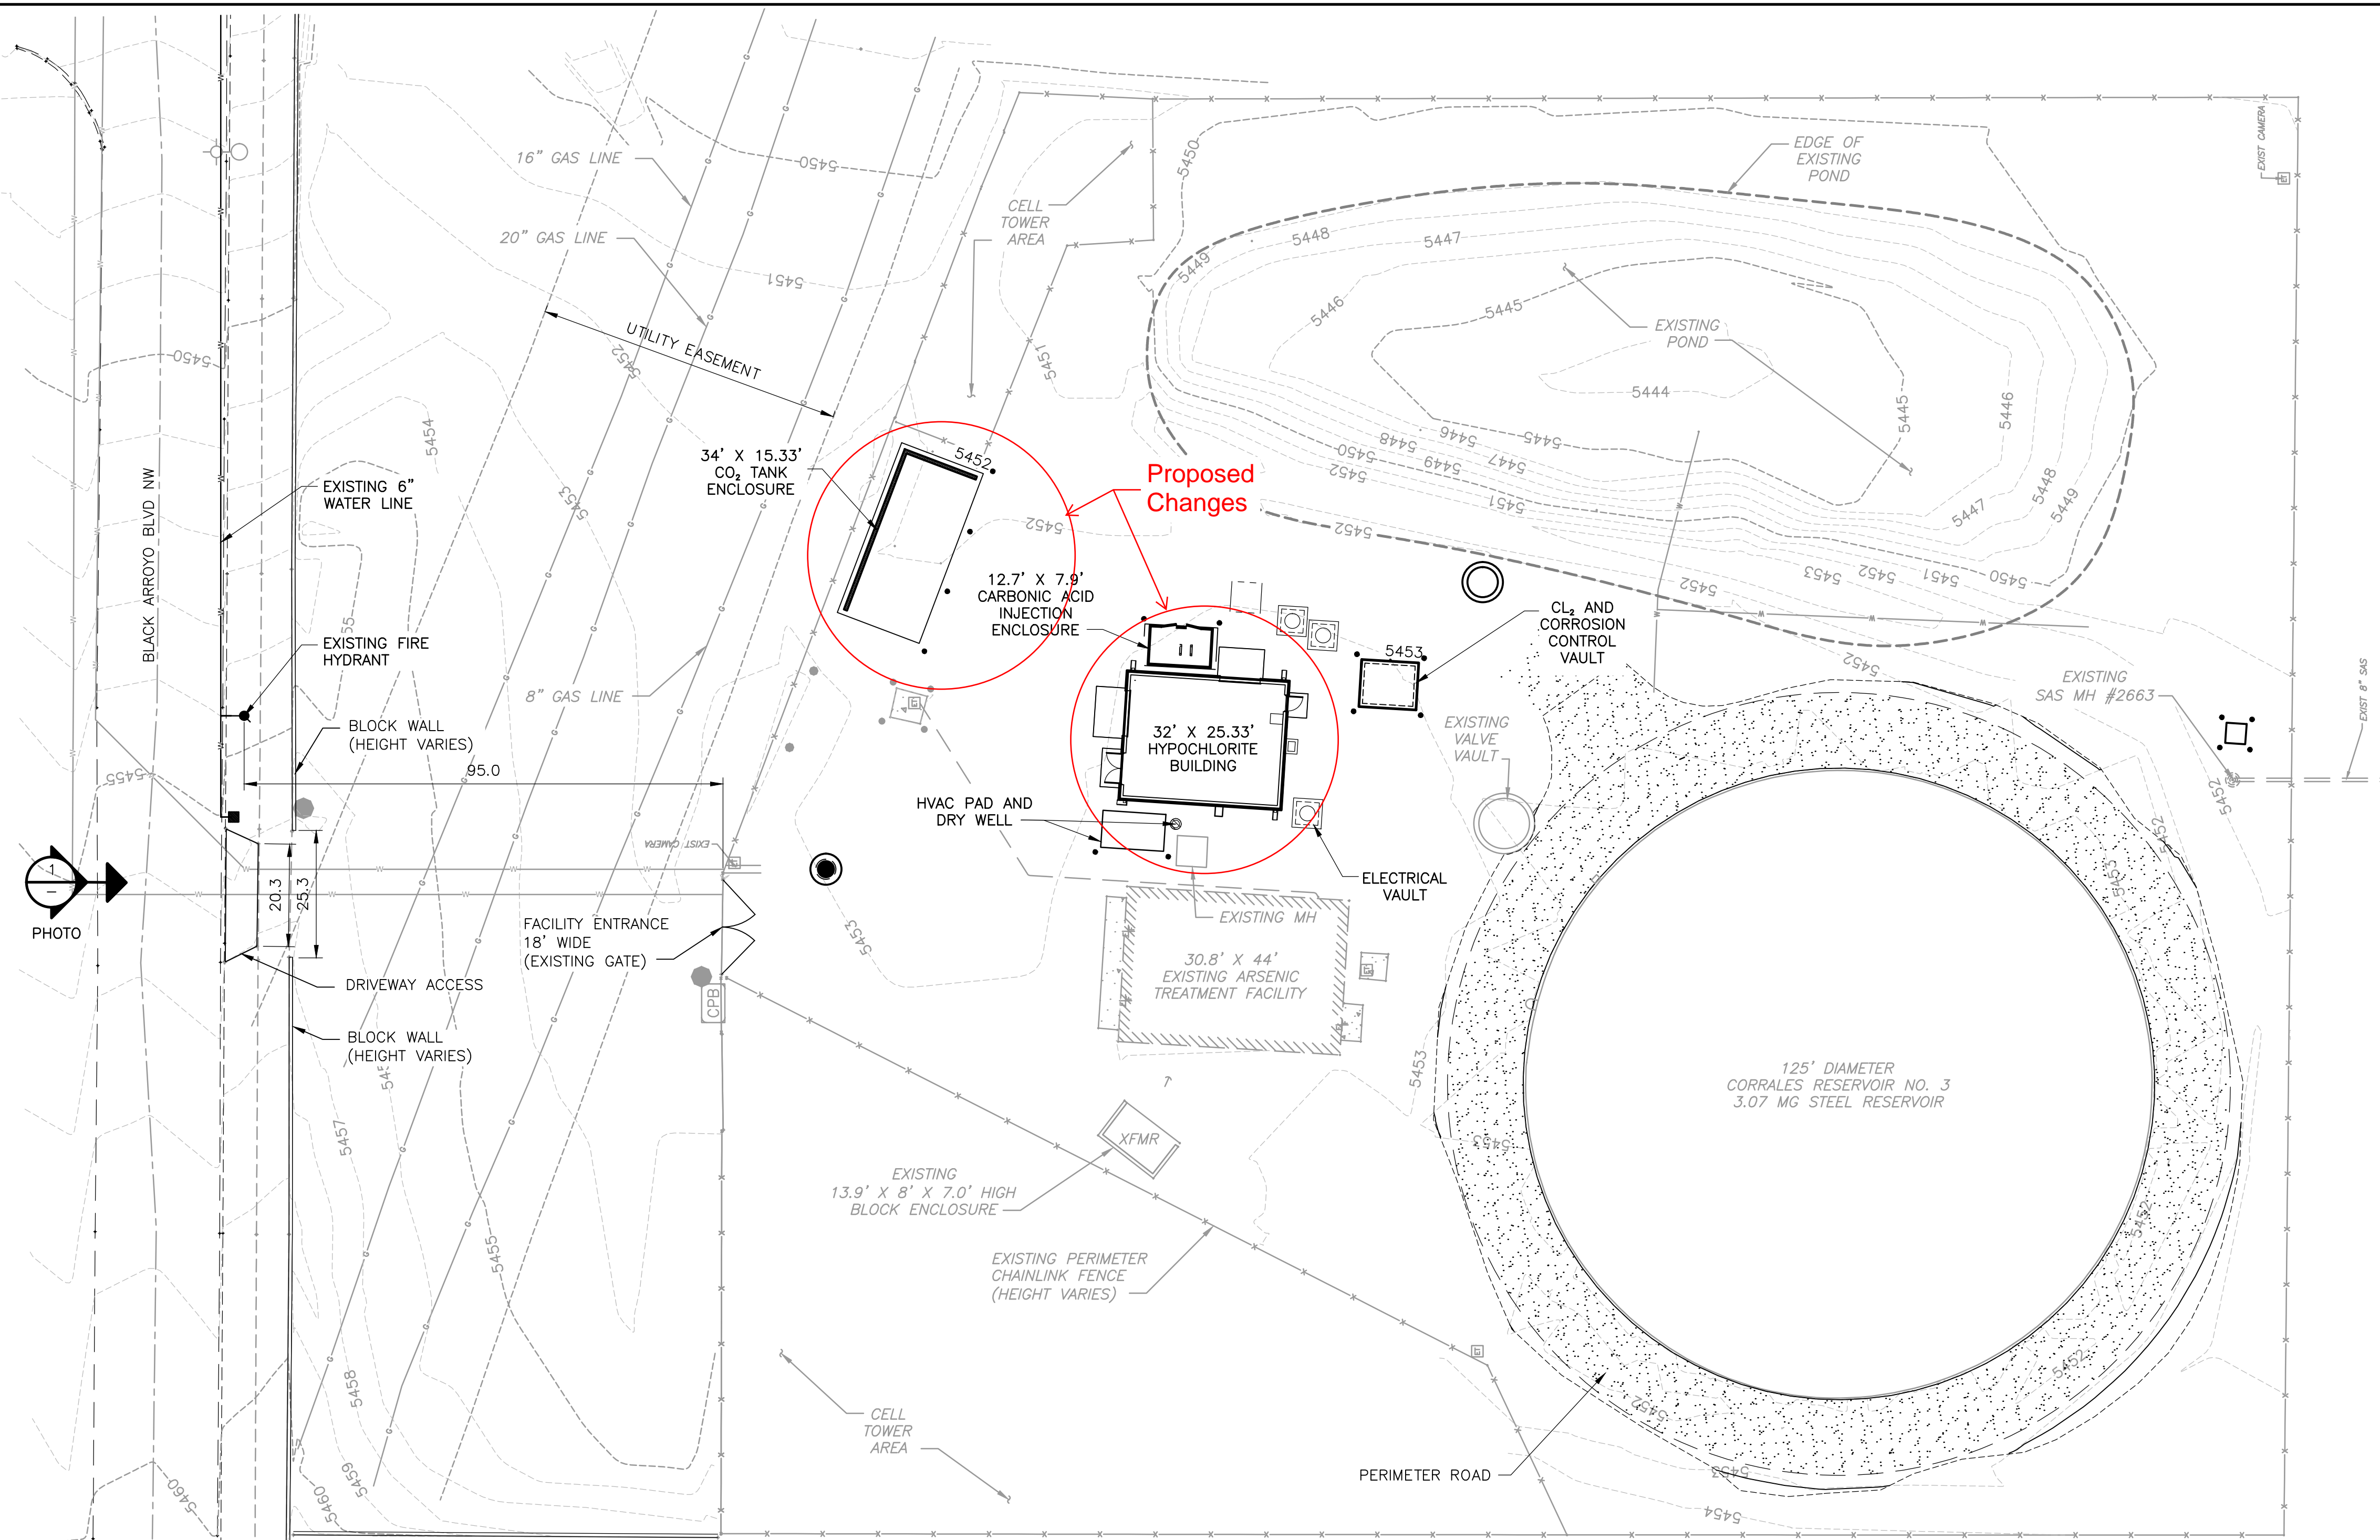

RESERVOIR NO. 3 ENTRANCE
 OFF BLACK ARROYO BLVD. NW
PHOTO 1
 NOT TO SCALE

PLAN
 1" = 20'-0"

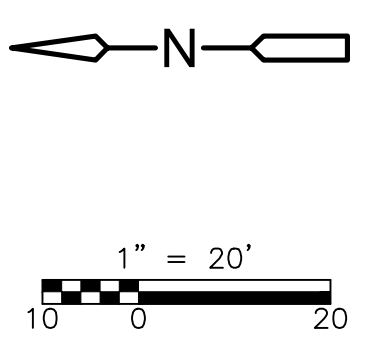

AS BUILT INFORMATION	
CONTRACTOR	DATE
WORKED BY	DATE
INSPECTORS	DATE
ACCEPTANCE BY	DATE
VERIFICATION BY	DATE
DRAWINGS CORRECTED BY	DATE
MICRO-FILM INFORMATION	
RECORDED BY	DATE
NO.	DATE

BENCH MARKS	

ENGINEER'S SEAL

05-01-2020

NO.	DATE	REMARKS	BY

CDM SMITH	DESIGNED BY	R. PAULETTE	DATE	MAY 2020
	DRAWN BY	R. MESQUITA	DATE	MAY 2020
	CHECKED BY	R. FOWLE	DATE	MAY 2020

CDM Smith
 6001 Indian School Road N.E., Suite 310
 Albuquerque, New Mexico 87110
 Tel: (505) 243-3200

Bohannon Huston
 www.bhinc.com 800.877.5332

ALBUQUERQUE BERNALILLO COUNTY WATER UTILITY AUTHORITY

TITLE: CORRALES TRUNK COLLECTOR PIPELINE (CTCP) PHASE 3
 CORRALES WELL 2 SITE IMPROVEMENTS AND CORRALES RESERVOIR 3 SITE
 AND ARSENIC TREATMENT SYSTEM IMPROVEMENTS
**CORRALES RESERVOIR 3
 PROPOSED SITE PLAN**

WATER AUTHORITY CONSTRUCTION PROJECT NO.	2323.003YY		
A/E Design Project No.	COA Project No.	Zone Map No.	Drawing No.
1205.012	7734.61	A-10	DRB-01
CDM Smith Project No.	File Name		SHEET OF
33280-236044	PH3_C012FIRE	A-11	