


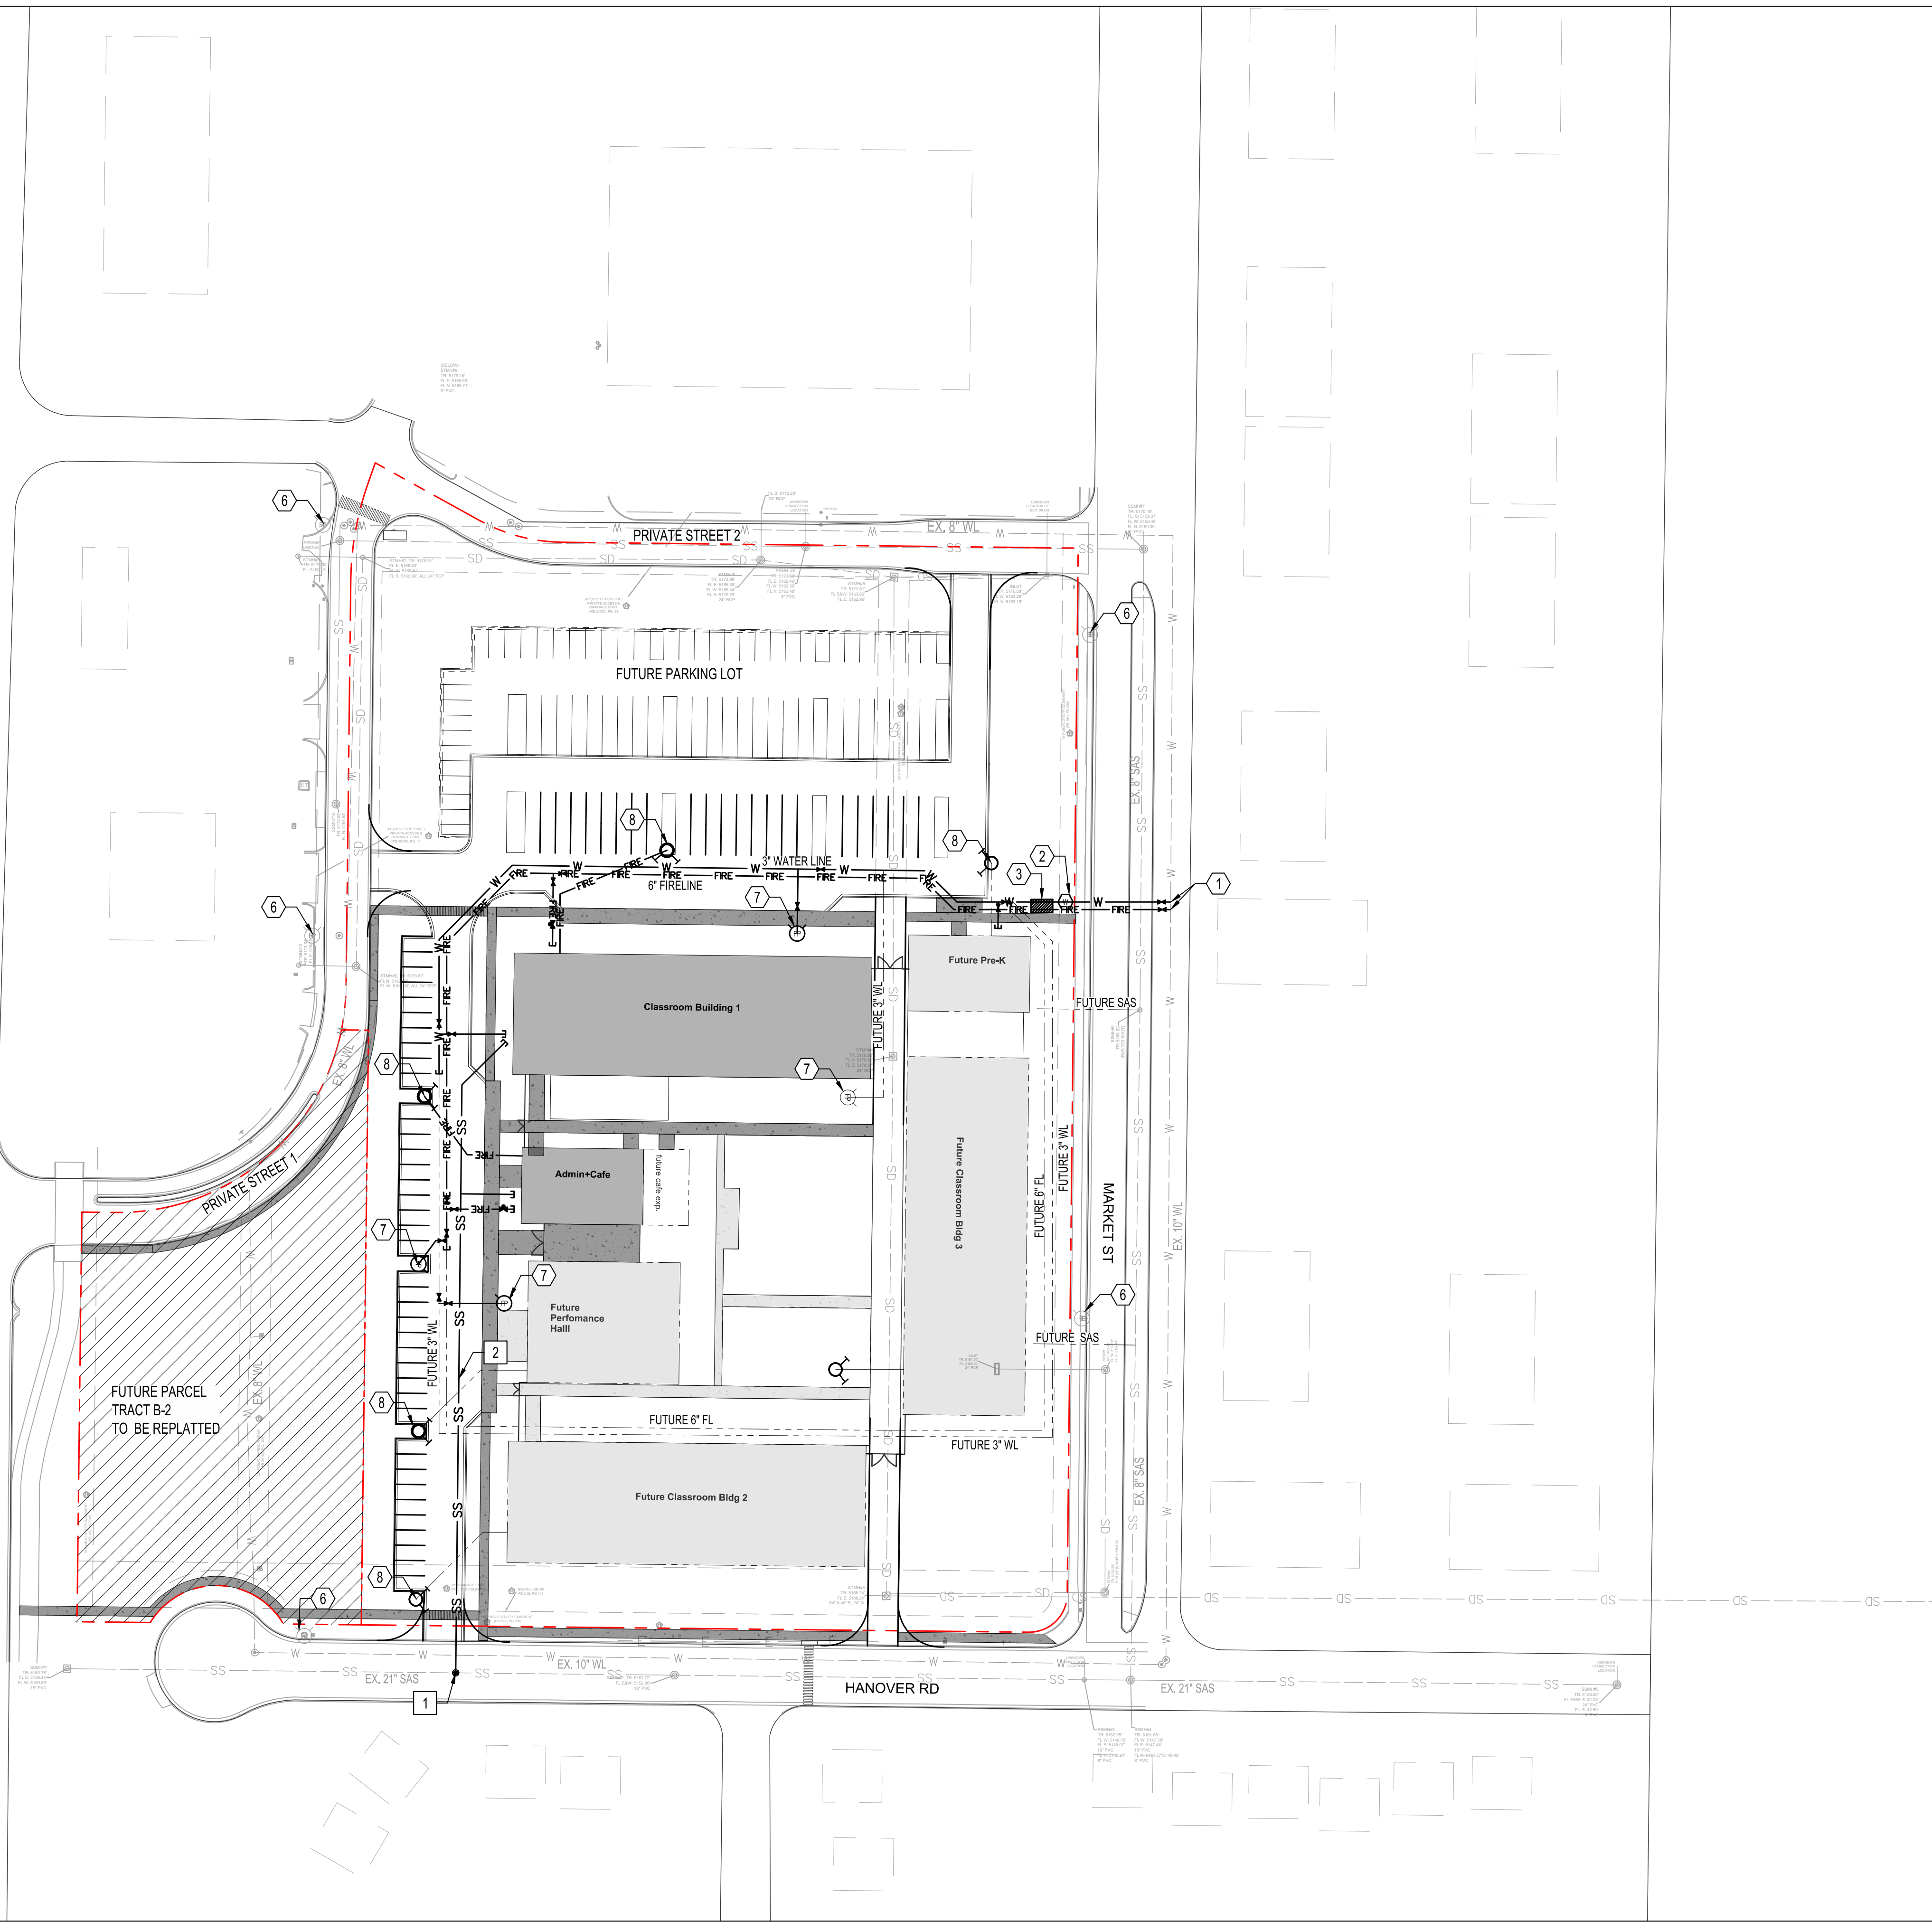

WATER KEYED NOTES

- CONNECT TO EXISTING WATER LINE.
- INSTALL 2" DOMESTIC WATER METER.
- INSTALL HEATED ENCLOSURE WITH 2" DOMESTIC REDUCED PRESSURE BACKFLOW PREVENTER AND 6" FIRE REDUCED PRESSURE BACKFLOW PREVENTER.
- INSTALL 3" WATER LINE.
- INSTALL 6" FIRE WATER SERVICE LINE.
- EXISTING FIRE HYDRANT.
- INSTALL FIRE HYDRANT PER STANDARD DETAILS.
- INSTALL REMOTE FIRE DEPARTMENT CONNECTION.

SEWER KEYED NOTES

- CONNECT TO EXISTING SEWER LINE.
- INSTALL 6" SANITARY SEWER SERVICE LINE.


LEGEND

- EXISTING PROPERTY LINE
- FUTURE PROPERTY LINE
- PHASE 1
- FUTURE PHASE
- EXISTING EASEMENT
- EXISTING WATER LINE
- EXISTING SANITARY SEWER LINE
- EXISTING STORM DRAIN LINE
- PROPOSED DOMESTIC WATER LINE
- PROPOSED FIRE LINE
- PROPOSED SANITARY SEWER LINE
- PROPOSED WATER VALVE
- PROPOSED WATER METER
- PROPOSED FIRE HYDRANT
- PROPOSED FIRE DEPARTMENT CONNECTION
- PROPOSED POST INDICATOR VALVE
- PROPOSED CLEAN OUT
- PROPOSED CAP
- PROPOSED MANHOLE

Bohannon **Huston**
www.bhinc.com 800.877.5332

RIO GRANDE ACADEMY OF FINE ARTS CONCEPTUAL SITE PLAN FOR SKETCH PLAT

BHI PROJECT NO.	20250418	DWG NO.	SHEET	1	OF	1
-----------------	----------	---------	-------	---	----	---

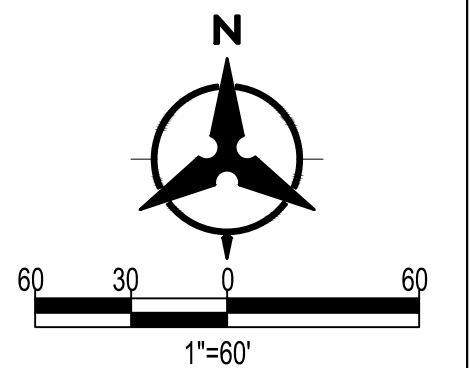

BENCH MARKS

BENCH MARK LINE 1
BENCH MARK LINE 2
BENCH MARK LINE 3
BENCH MARK LINE 4
BENCH MARK LINE 5
BENCH MARK LINE 6
BENCH MARK LINE 7
BENCH MARK LINE 8
BENCH MARK LINE 9

ENGINEER'S SEAL

AS-BUILT INFORMATION

CONTRACTOR	DATE
WORK STARTED BY	DATE
INSPECTORS ACCEPTANCE BY	DATE
FIELD VERIFICATION BY	DATE
DRAWINGS CORRECTED BY	DATE

REVISIONS

BY	DATE

DESIGN

DESIGNED BY	KK	CHECKED BY	KK	DRAWN BY	JR
-------------	----	------------	----	----------	----