


Scale : 1" = 30'

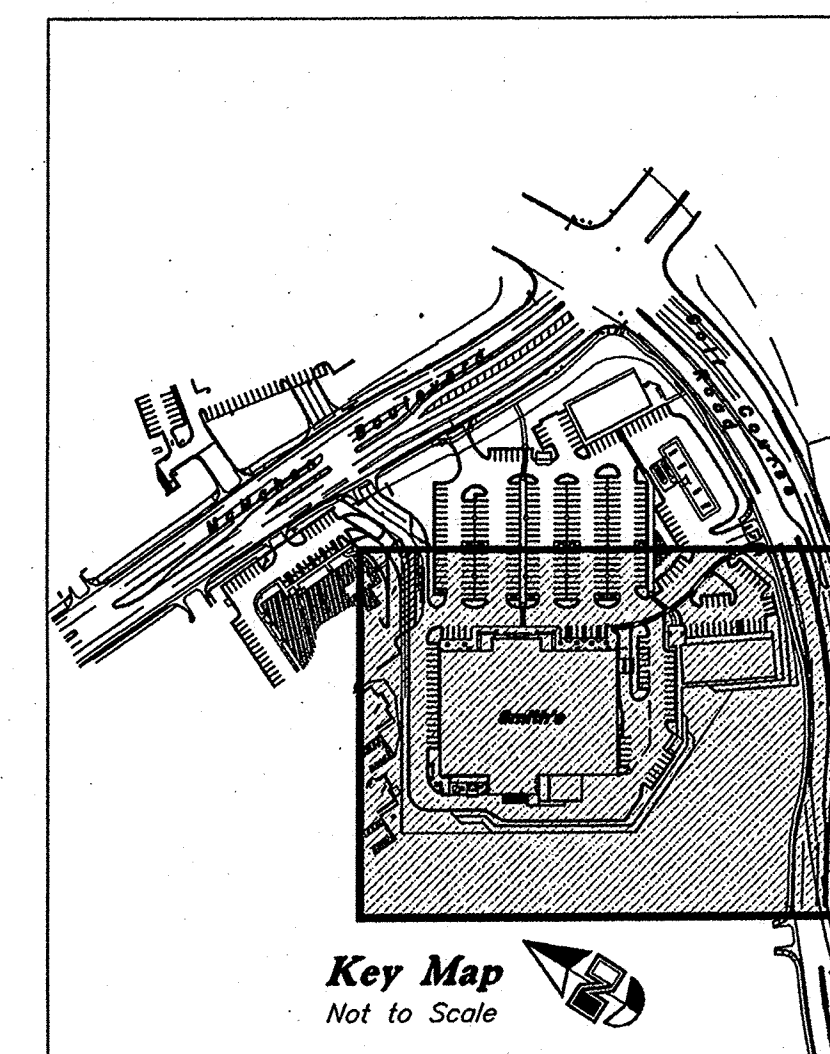

Waterline Construction Notes

- 1 Const. 8" PVC C-900 Waterline
- 2 Const. 6" PVC C-900 Waterline (Fire)
- 3 Const. 8" Gate Valve
- 4 Const. 6" Gate Valve
- 5 Const. 6" Wet Tap & Valve (Fully Blocked)
- 6 Const. 8" 90° Bend
- 7 Const. 8" 45° Bend
- 8 Const. Fire Hydrant Assembly per COA Std. Dwg. 2340
- 9 Const. 8" x 8" x 8" Tee
- 10 Const. 8" x 8" x 6" Tee (Restrained)
- 11 Const. 2" Meter & Service per COA Std. Dwg. 2363
- 12 Const. 2" DCVA Assembly per COA Std. Dwg. 2386
- 13 Const. 3" Water Service
- 14 Const. 6" 90° Bend
- 15 Const. 22.5° Bend
- 16 Const. 6" 45° Bend
- 17 Const. 1.5" Meter & Service per COA Std. Dwg. 2363
- 18 Const. 1.5" DCVA Assembly per COA Std. Dwg. 2386
- 19 Const. 2" Irrigation Service w/ 2" Meter and RPBA
- 20 Const. 2" Water Service
- 21 Const. 3/4" Meter & 1" Service Line Per NMU Reqs.
- 22 Const. 3/4" DCVA Per NMU Reqs.
- 23 Const. 1" Water Service
- 24 Const. 6" Post Indicator Valve & Tamper Switch with 3/4" Conduit from Switch to Building. Coordinate with Fire System Contractor.

All Utility Construction Shall Comply with New Mexico Utilities Inc. Specifications For Water and Wastewater Facilities.

Smith's
FOOD & DRUG STORES
#463

RECEIVED
APR 6 2 2008
HYDROLOGY
SECTION

Golf Course Road & McMahon Boulevard
Albuquerque, New Mexico

5 Jun, 2006

SHEET NO.

C3.1

Utility Plan

Smith's Food and Drug Stores
1550 South Redwood Road
Salt Lake City, Utah 84104
Telephone (801) 974-1400


GREAT BASIN ENGINEERING - SOUTH
CONSULTING ENGINEERS and LAND SURVEYORS
2010 North Redwood Road, P.O. Box 16747
Salt Lake City, Utah 84116
Fax (801) 521-9551
Ogden (801) 394-7288

Designed by: KR
Drafted by: BP
Client Name:
Smith's Food &
Drug Centers, Inc.
SMC463-UT

REV.	DATE	DESCRIPTION

Match Line Sheet C3.2


Match Line Sheet C3.3

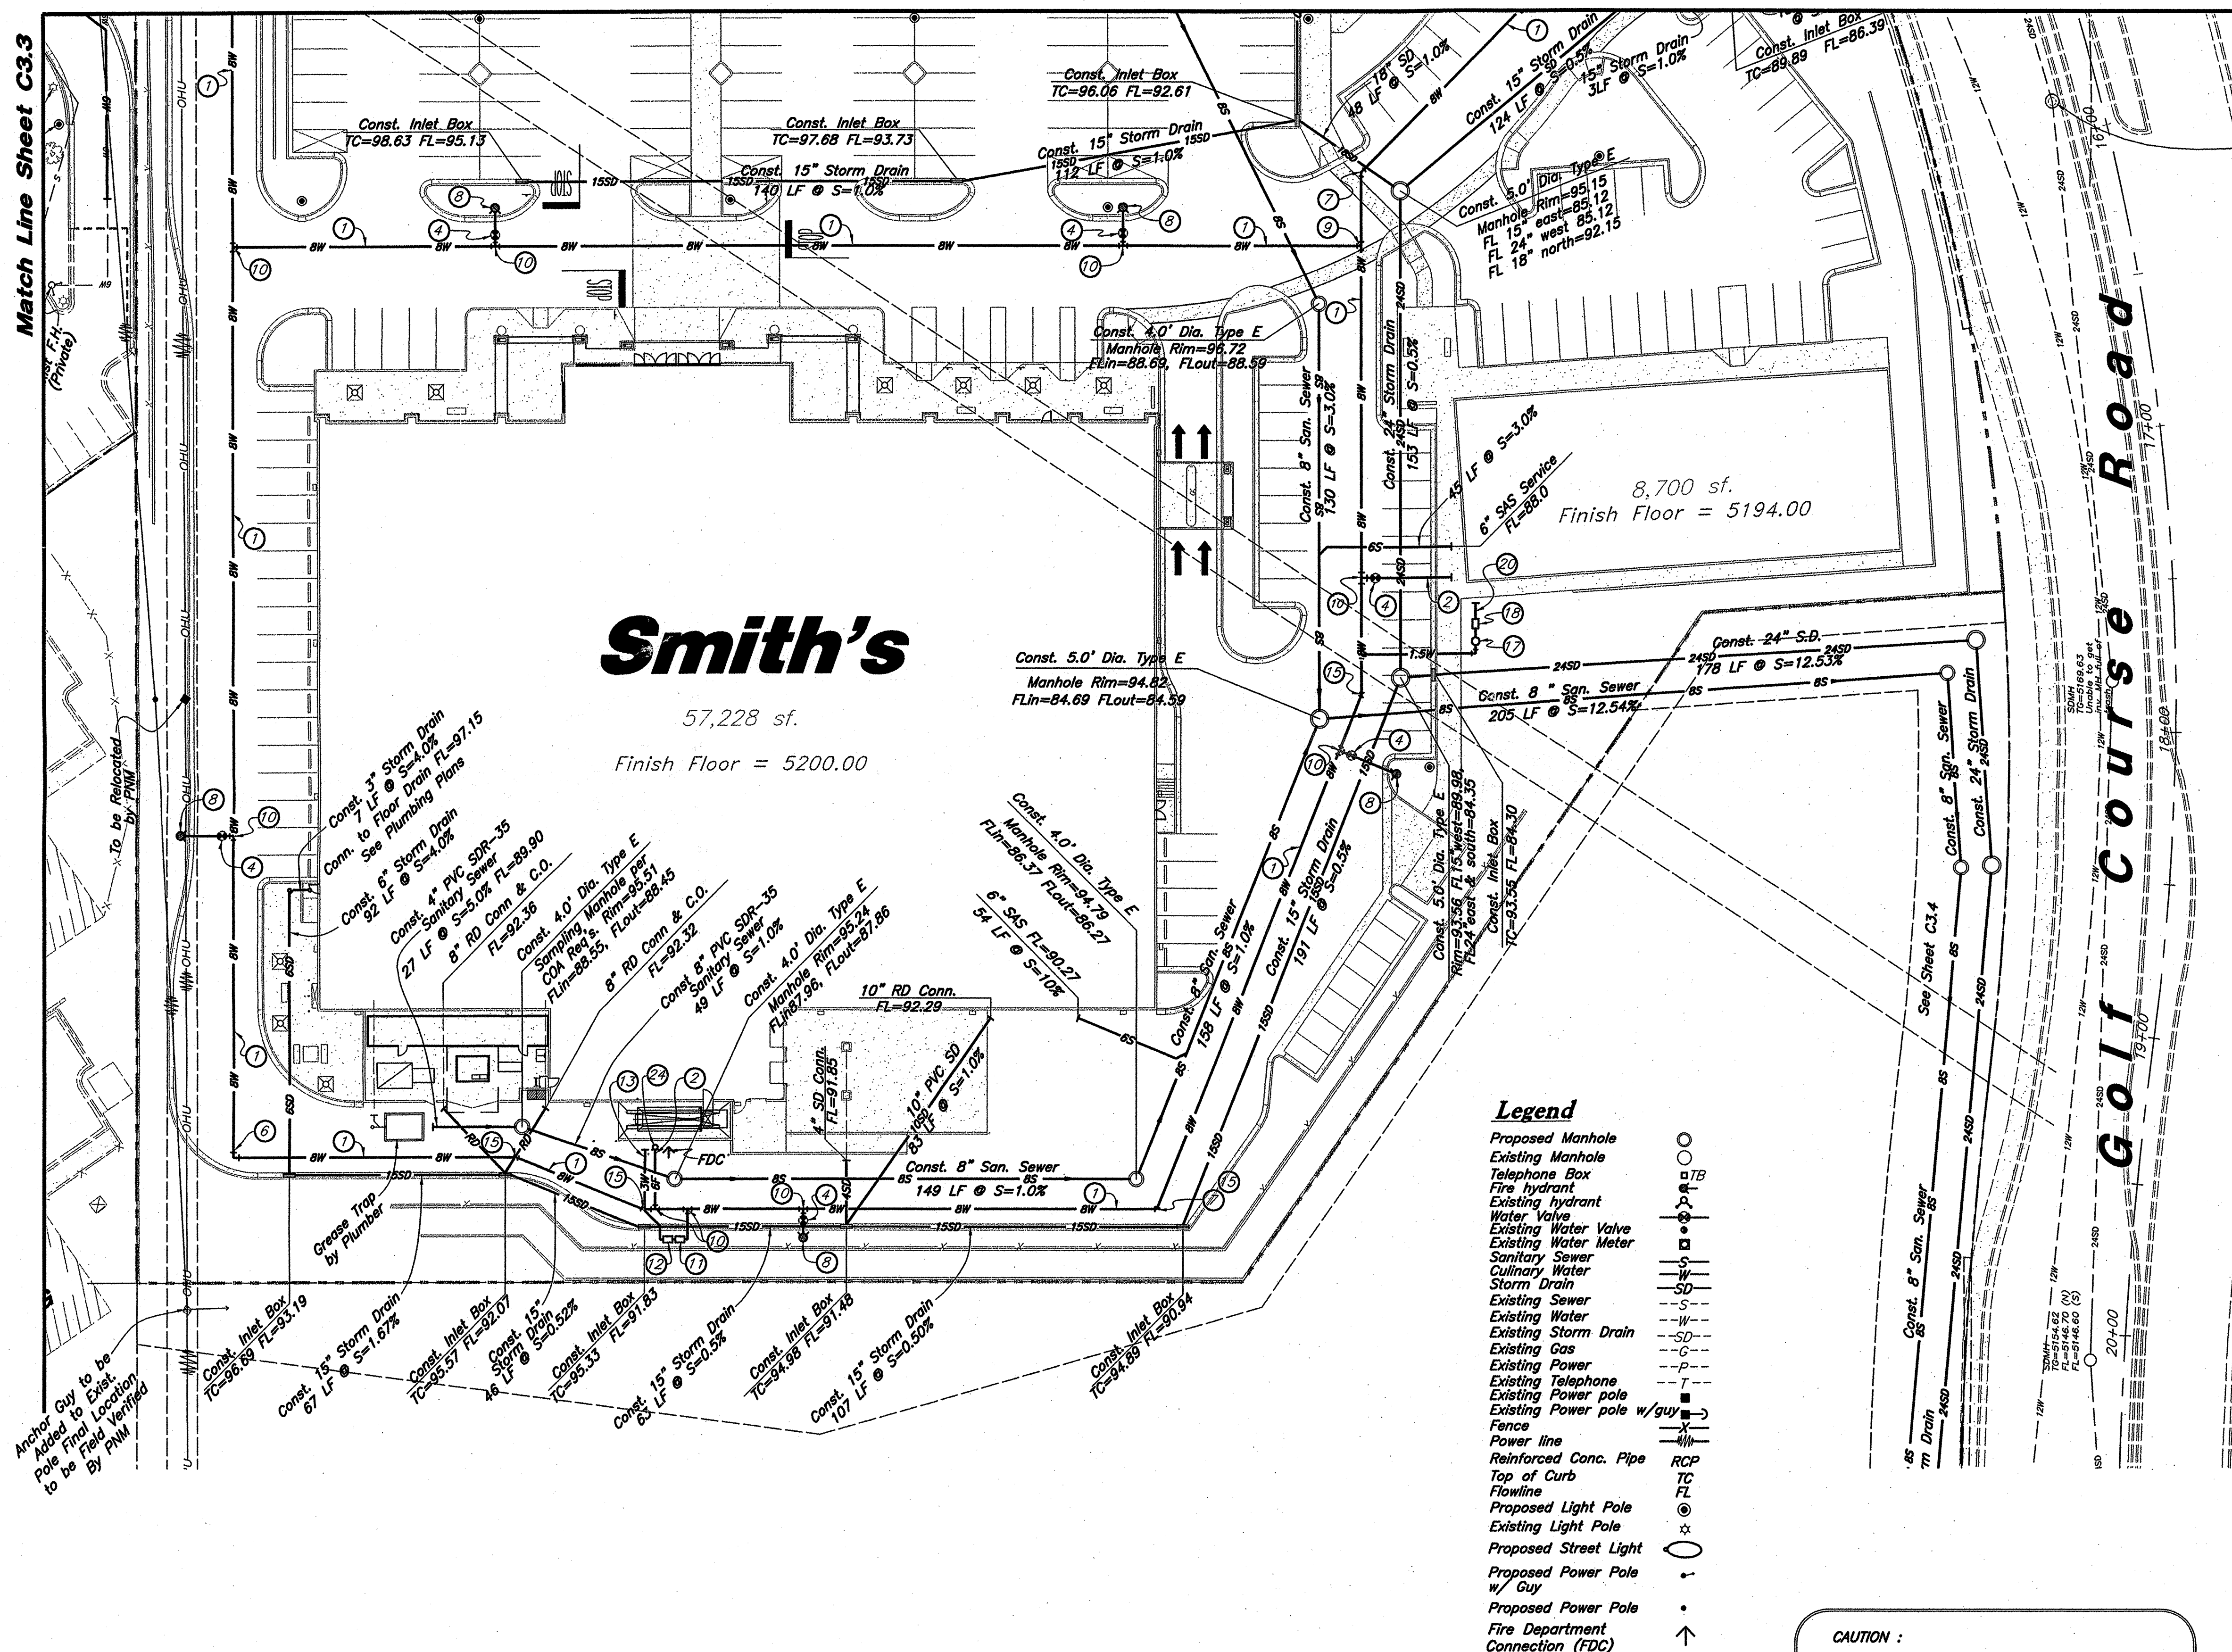

Legend


- Proposed Manhole
- Existing Manhole
- Telephone Box
- Fire hydrant
- Existing hydrant
- Water Valve
- Existing Water Valve
- Existing Water Meter
- Sanitary Sewer
- Culinary Water
- Storm Drain
- Existing Sewer
- Existing Water
- Existing Storm Drain
- Existing Gas
- Existing Power
- Existing Telephone
- Existing Power pole
- Existing Power pole w/guy
- Fence
- Power line
- Reinforced Conc. Pipe
- Top of Curb
- Flowline
- Proposed Light Pole
- Existing Light Pole
- Proposed Street Light
- Proposed Power Pole w/guy
- Proposed Power Pole
- Fire Department Connection (FDC)

CAUTION :
The location and/or elevation of existing utilities as shown on these plans is based on records of the various utility companies and, where possible, measurements taken in the field. The information is not to be relied on as being exact or complete.

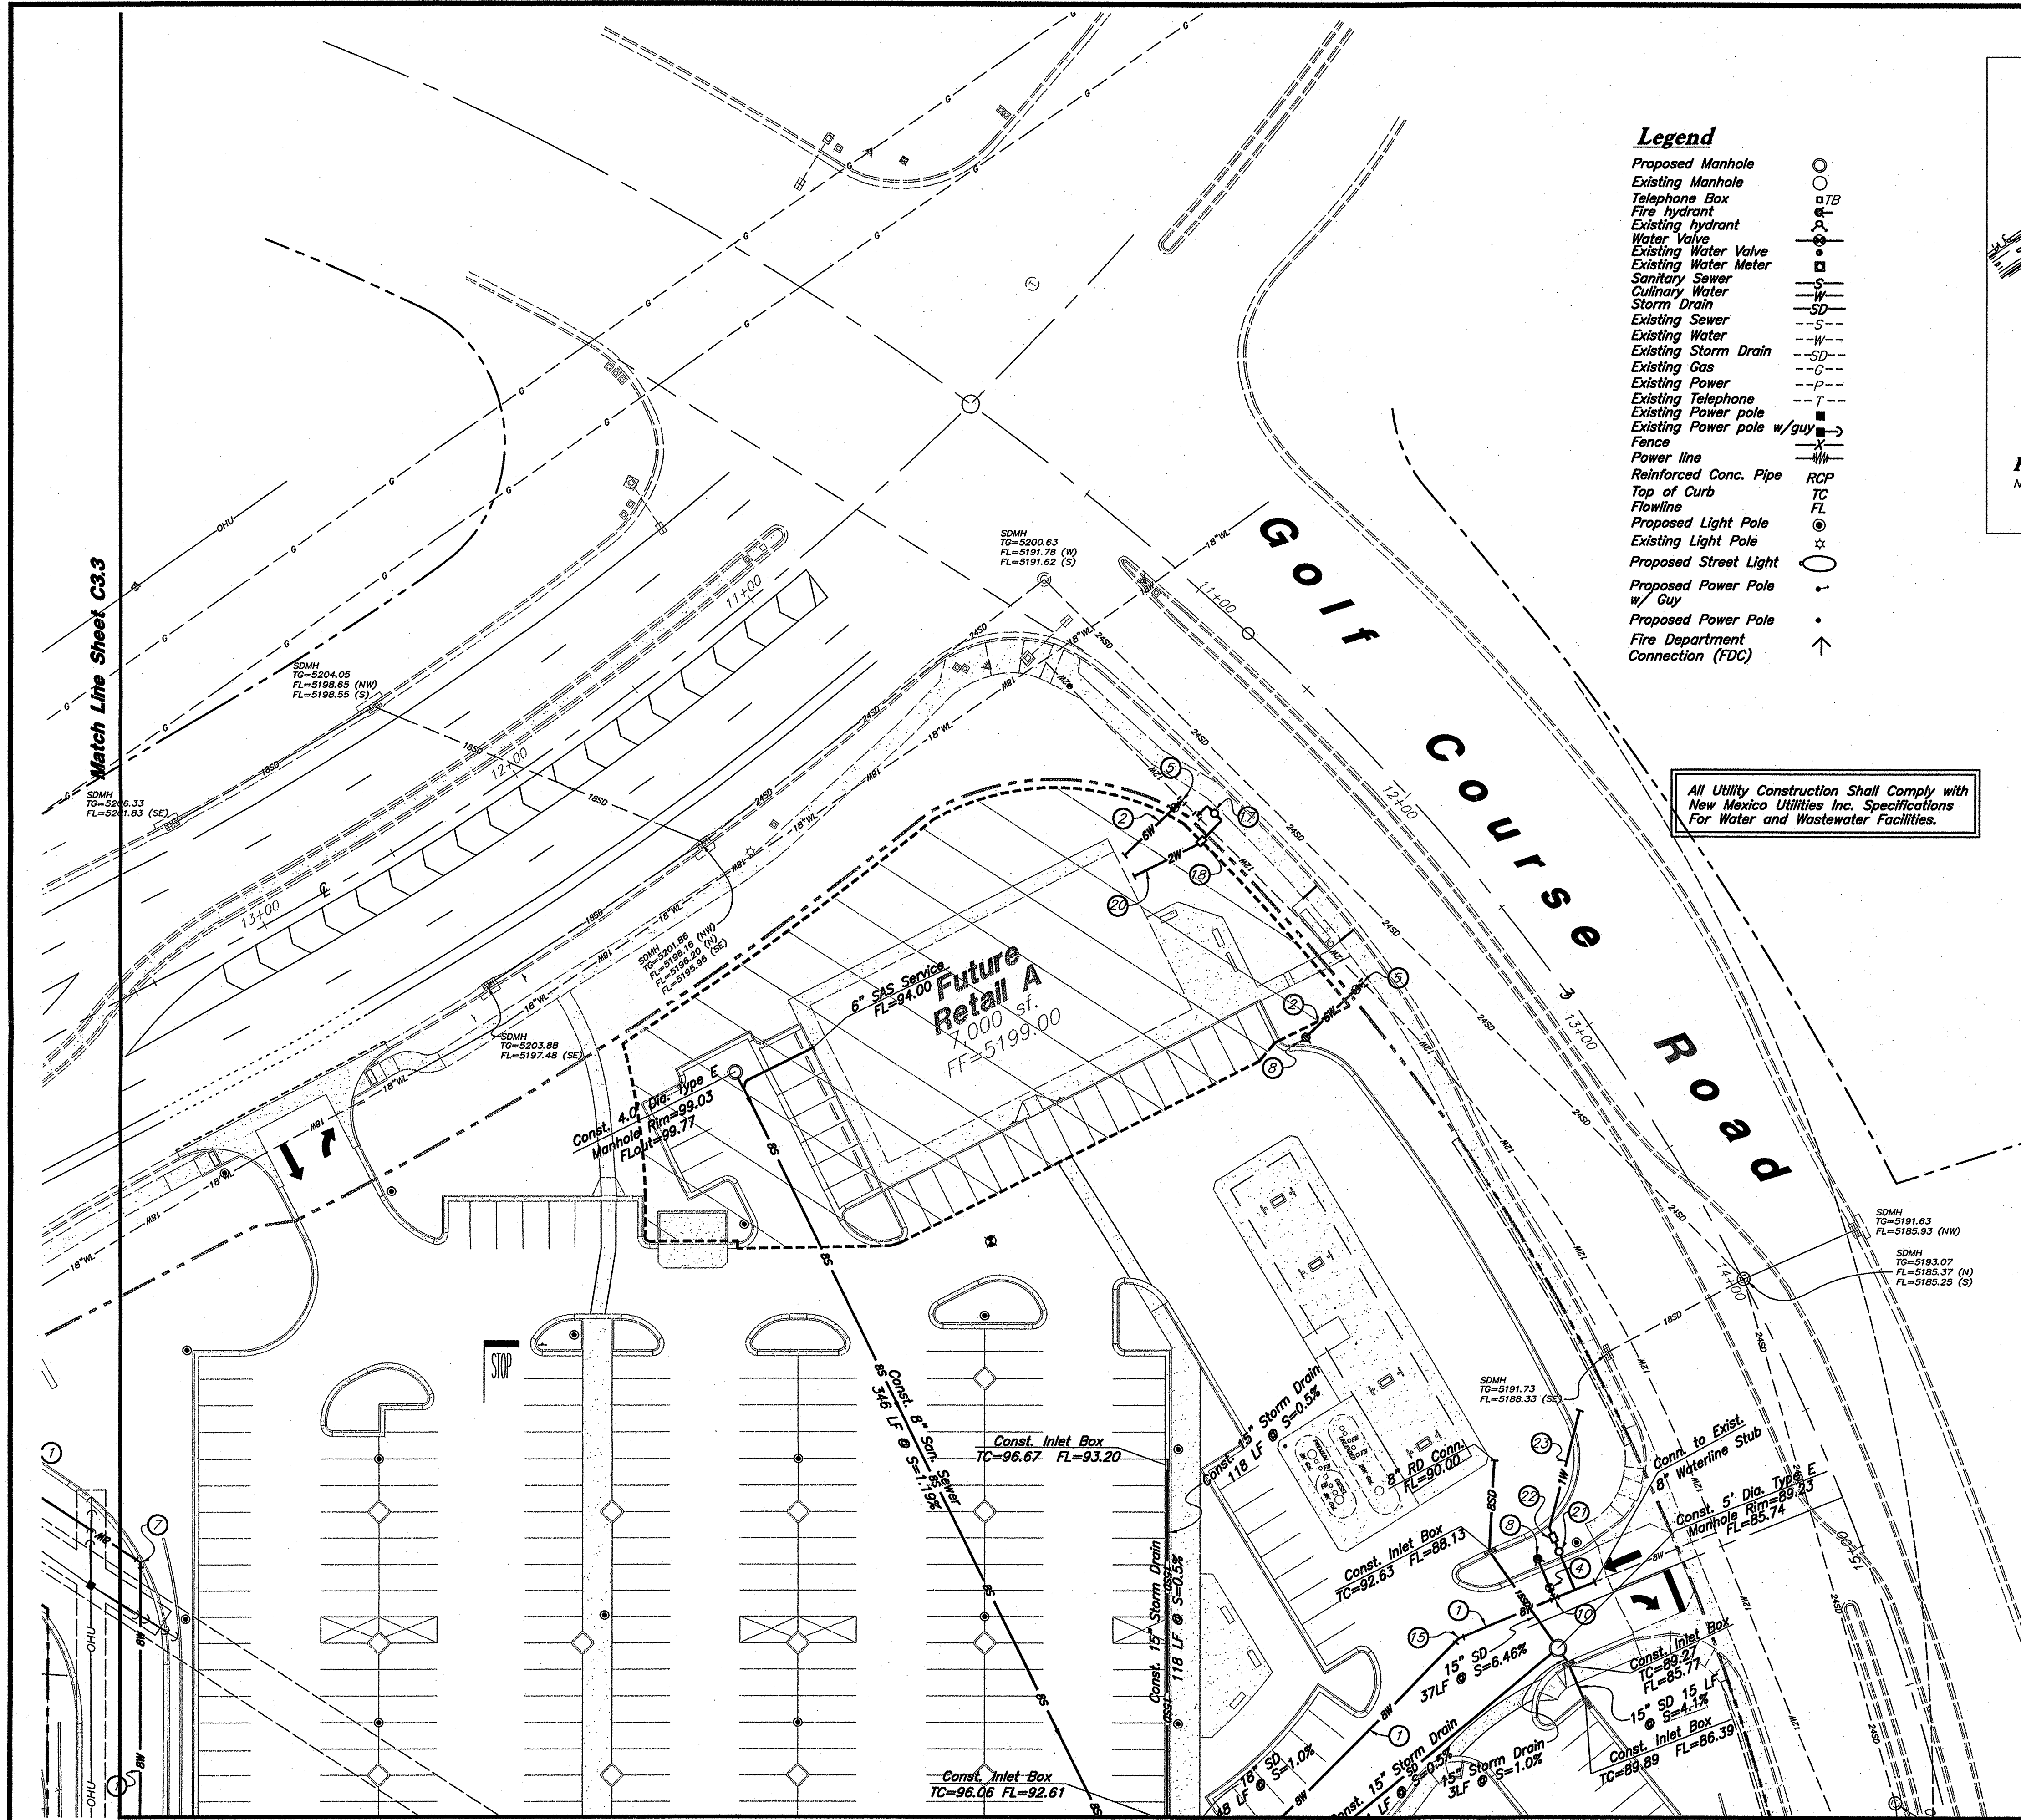


Legend

- Proposed Manhole
- Existing Manhole
- Telephone Box
- Fire hydrant
- Existing hydrant
- Water Valve
- Existing Water Valve
- Existing Water Meter
- Sanitary Sewer
- Culinary Water
- Storm Drain
- Existing Sewer
- Existing Water
- Existing Storm Drain
- Existing Gas
- Existing Power
- Existing Telephone
- Existing Power pole
- Existing Power pole w/guy
- Fence
- Power line
- Reinforced Conc. Pipe
- Top of Curb
- Flowline
- Proposed Light Pole
- Existing Light Pole
- Proposed Street Light
- Proposed Power Pole w/ Guy
- Proposed Power Pole
- Fire Department Connection (FDC)

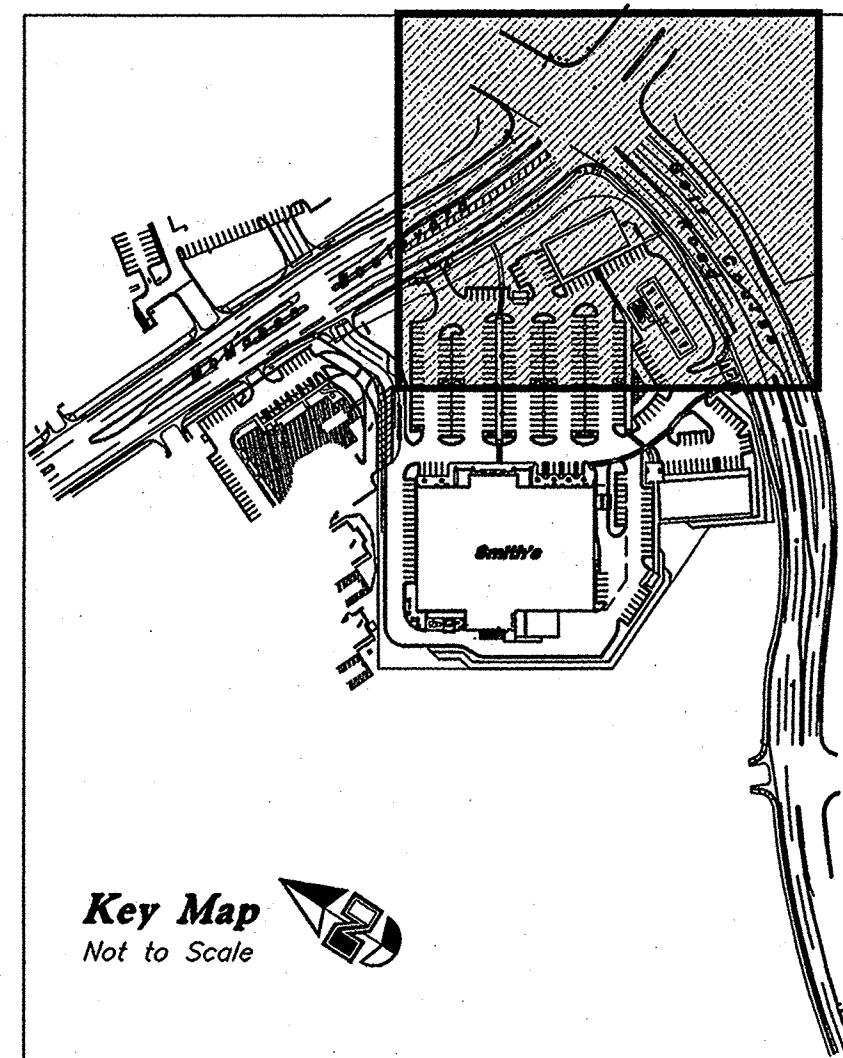

Key Map
Not to Scale

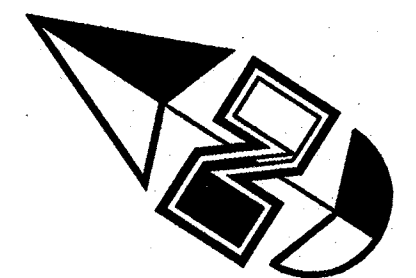

Scale : 1" = 30'



All Utility Construction Shall Comply with
New Mexico Utilities Inc. Specifications
For Water and Wastewater Facilities.

Waterline Construction Notes

1. Const. 8" PVC C-900 Waterline
2. Const. 6" PVC C-900 Waterline (Fire)
3. Const. 8" Gate Valve
4. Const. 6" Gate Valve
5. Const. 6" Wet Tap & Valve (Fully Blocked)
6. Const. 8" 90° Bend
7. Const. 8" 45° Bend
8. Const. Fire Hydrant Assembly per COA Std. Dwg. 2340
9. Const. 8" x 8" x 8" Tee
10. Const. 8" x 8" x 6" Tee (Restrained)
11. Const. 2" Meter & Service per COA Std. Dwg. 2363
12. Const. 2" DCVA Assembly per COA Std. Dwg. 2386
13. Const. 3" Water Service
14. Const. 6" 90° Bend
15. Const. 22.5° Bend
16. Const. 6" 45° Bend
17. Const. 1.5" Meter & Service per COA Std. Dwg. 2363
18. Const. 1.5" DCVA Assembly per COA Std. Dwg. 2386
19. Const. 2" Irrigation Service
20. Const. 2" Water Service
21. Const. 3/4" Meter & 1" Service Line Per NMU Reqs.
22. Const. 3/4" DCVA Per NMU Reqs.
23. Const. 1" Water Service
24. Const. 6" Post Indicator Valve & Tamper Switch with 3/4" Conduit from Switch to Building. Coordinate with Fire System Contractor.

CAUTION :

The location and/or elevation of existing utilities as shown on these plans is based on records of the various utility companies and, where possible, measurements taken in the field. The information is not to be relied on as being exact or complete.


Smith's
FOOD & DRUG STORES
#463

Golf Course Road & McMahon Boulevard
Albuquerque, New Mexico

RECEIVED
APR 9 2 2305
HYDROLOGY
SECTION

GREAT BASIN ENGINEERING - SOUTH
CONSULTING ENGINEERS and LAND SURVEYORS
2010 North Redwood Road, P.O. Box 16747
Salt Lake City, Utah 84116
Ogden (801) 521-5529 Fax (801) 521-5551
Salt Lake City (801) 521-5529

Utility Plan
Smith's Food and Drug Stores
1550 South Redwood Road
Salt Lake City, Utah 84104
Telephone (801) 974-1400

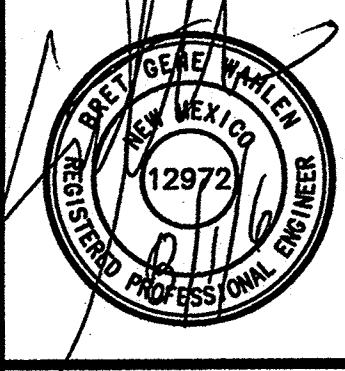


5 Jun, 2006

SHEET NO.


C3.2

Approved

University of New Mexico

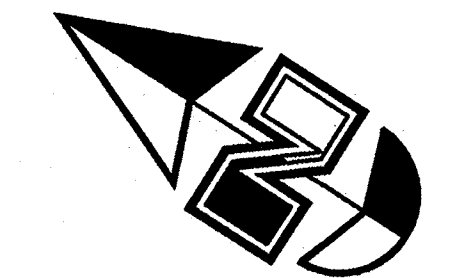

Scale : 1" = 30'

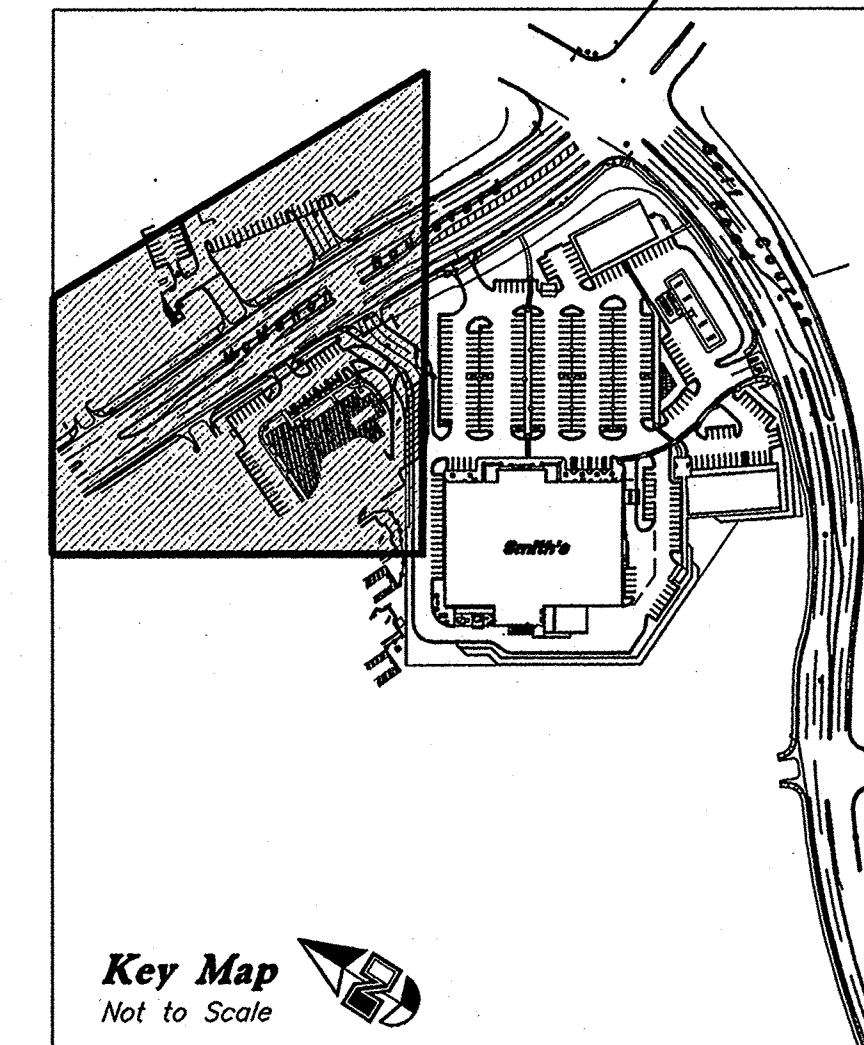

Key Map
Not to Scale

Note:
Contractor shall Provide UNM with Copies of the Construction Schedule and Provide Written Notice for Work Affecting the UNM Property. Work Shall be Scheduled and Staged in order to Not Interrupt any Services or Disrupt the Operation of the Clinic.

Legend

Proposed Manhole	○
Existing Manhole	○
Telephone Box	□
Fire hydrant	⊕
Existing hydrant	⊕
Water Valve	⊕
Existing Water Valve	⊕
Existing Water Meter	⊕
Sanitary Sewer	-S-
Culinary Water	-W-
Storm Drain	-SD-
Existing Sewer	-S-
Existing Water	-W-
Existing Storm Drain	-SD-
Existing Gas	-G-
Existing Power	-P-
Existing Telephone	-T-
Existing Power pole	⊕
Existing Power pole w/guy	⊕
Fence	—
Power line	—
Reinforced Conc. Pipe	RCP
Top of Curb	TC
Flowline	FL
Proposed Light Pole	⊕
Existing Light Pole	⊕
Proposed Street Light	⊕
Proposed Power Pole w/ Guy	⊕
Proposed Power Pole	⊕
Fire Department Connection (FDC)	↑

All Utility Construction Shall Comply with New Mexico Utilities Inc. Specifications For Water and Wastewater Facilities.

Waterline Construction Notes

1. Const. 8" PVC C-900 Waterline
2. Const. 6" PVC C-900 Waterline (Fire)
3. Const. 8" Gate Valve
4. Const. 6" Gate Valve
5. Const. 6" Wet Tap & Valve (Fully Blocked)
6. Const. 8" 90° Bend
7. Const. 6" 45° Bend
8. Const. Fire Hydrant Assembly per COA Std. Dwg. 2340
9. Const. 8" x 8" x 8" Tee
10. Const. 8" x 8" x 6" Tee (Restrained)
11. Const. 2" Meter & Service per COA Std. Dwg. 2363
12. Const. 2" DCVA Assembly per COA Std. Dwg. 2386
13. Const. 3" Water Service
14. Const. 6" 90° Bend
15. Const. 22.5° Bend
16. Const. 6" 45° Bend
17. Const. 1.5" Meter & Service per COA Std. Dwg. 2363
18. Const. 1.5" DCVA Assembly per COA Std. Dwg. 2386
19. Const. 2" Irrigation Service w/ 2" Meter & RPBA

CAUTION :

The location and/or elevation of existing utilities as shown on these plans is based on records of the various utility companies and, where possible, measurements taken in the field. The information is not to be relied on as being exact or complete.


Match Line Sheet C3.1 & C3.2

UNM West Side Clinic

McMahon Boulevard


Smith's
FOOD & DRUG STORES
#463

Golf Course Road & McMahon Boulevard
Albuquerque, New Mexico

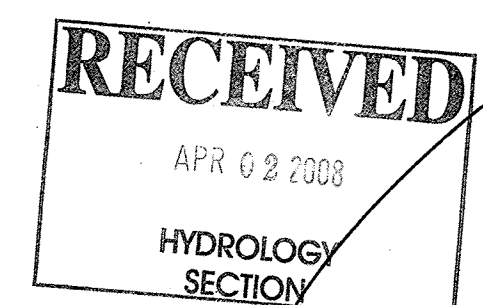

GREAT BASIN ENGINEERING - SOUTH
CONSULTING ENGINEERS and LAND SURVEYORS
2010 North Redwood Road, P.O. Box 16747
Salt Lake City, Utah 84116
Open (801)394-7288 Fax (801)351-9551
Salt Lake City (801)351-8529

Utility Plan
Smith's Food and Drug Stores
1550 South Redwood Road
Salt Lake City, Utah 84104
Telephone (801) 974-1400

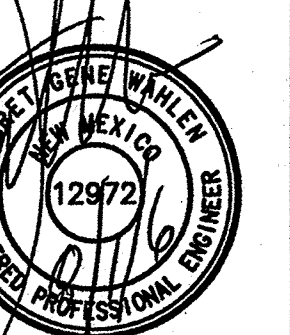

5 Jun, 2006

SHEET NO.

C3.3

DESCRIPTION
REV
DATE

