

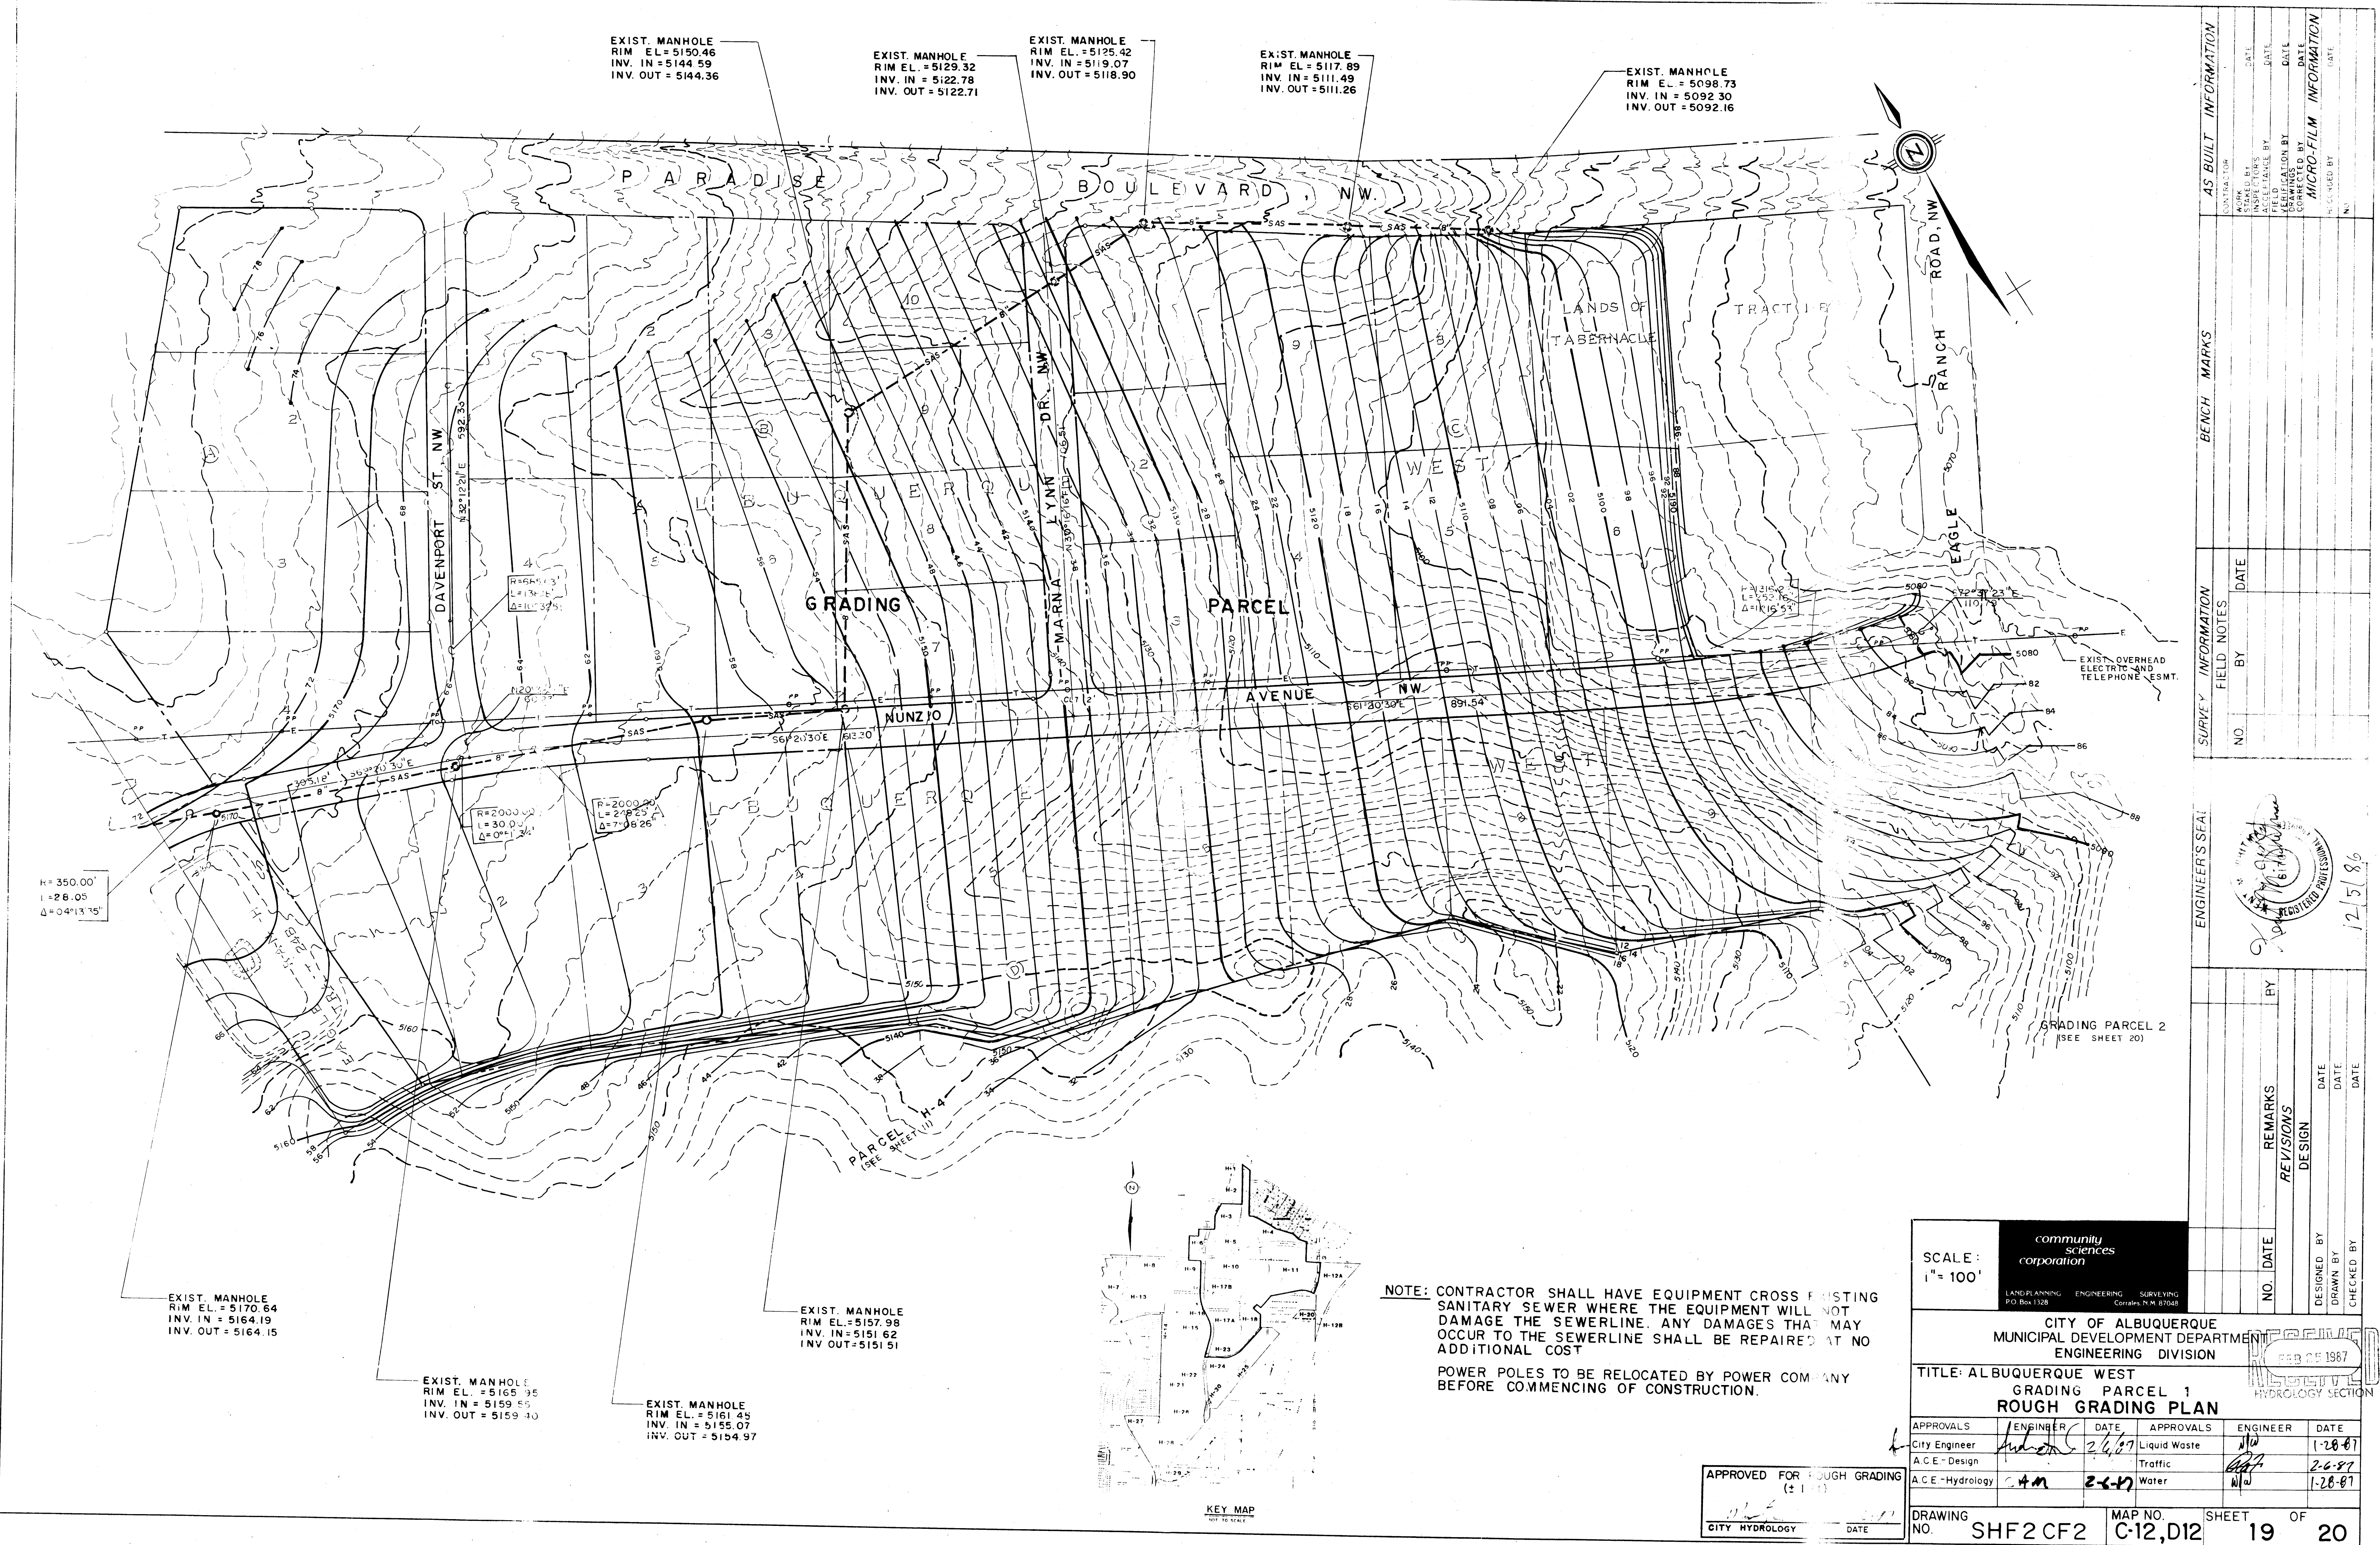


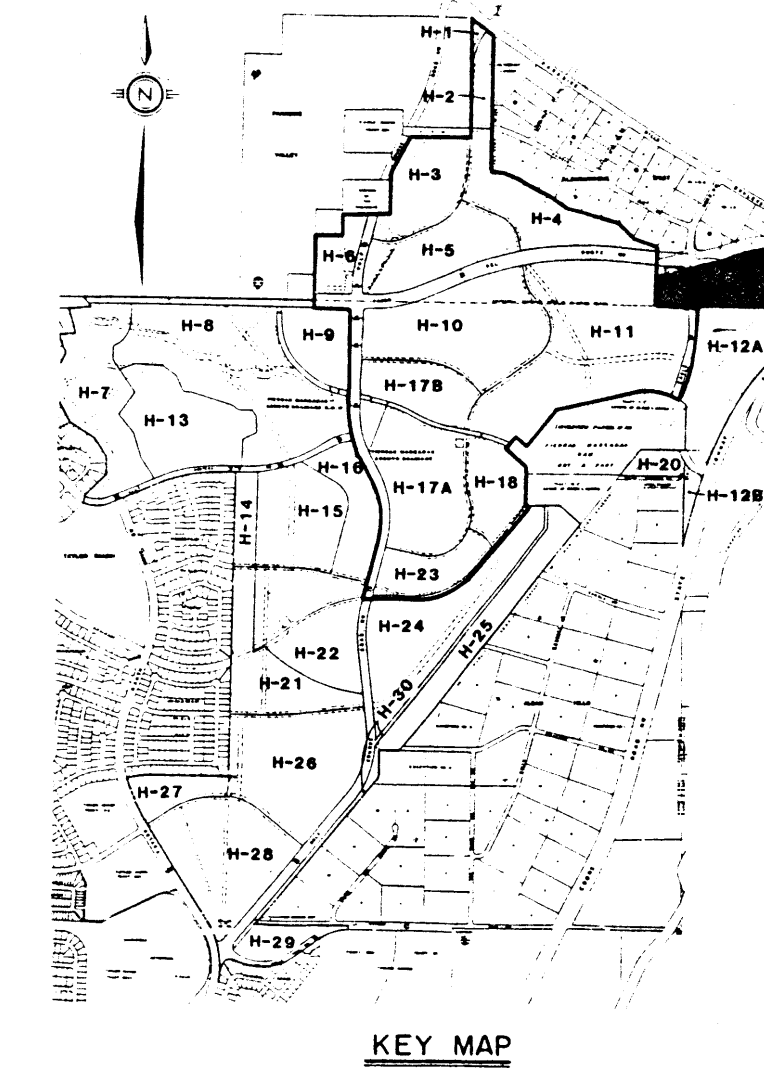

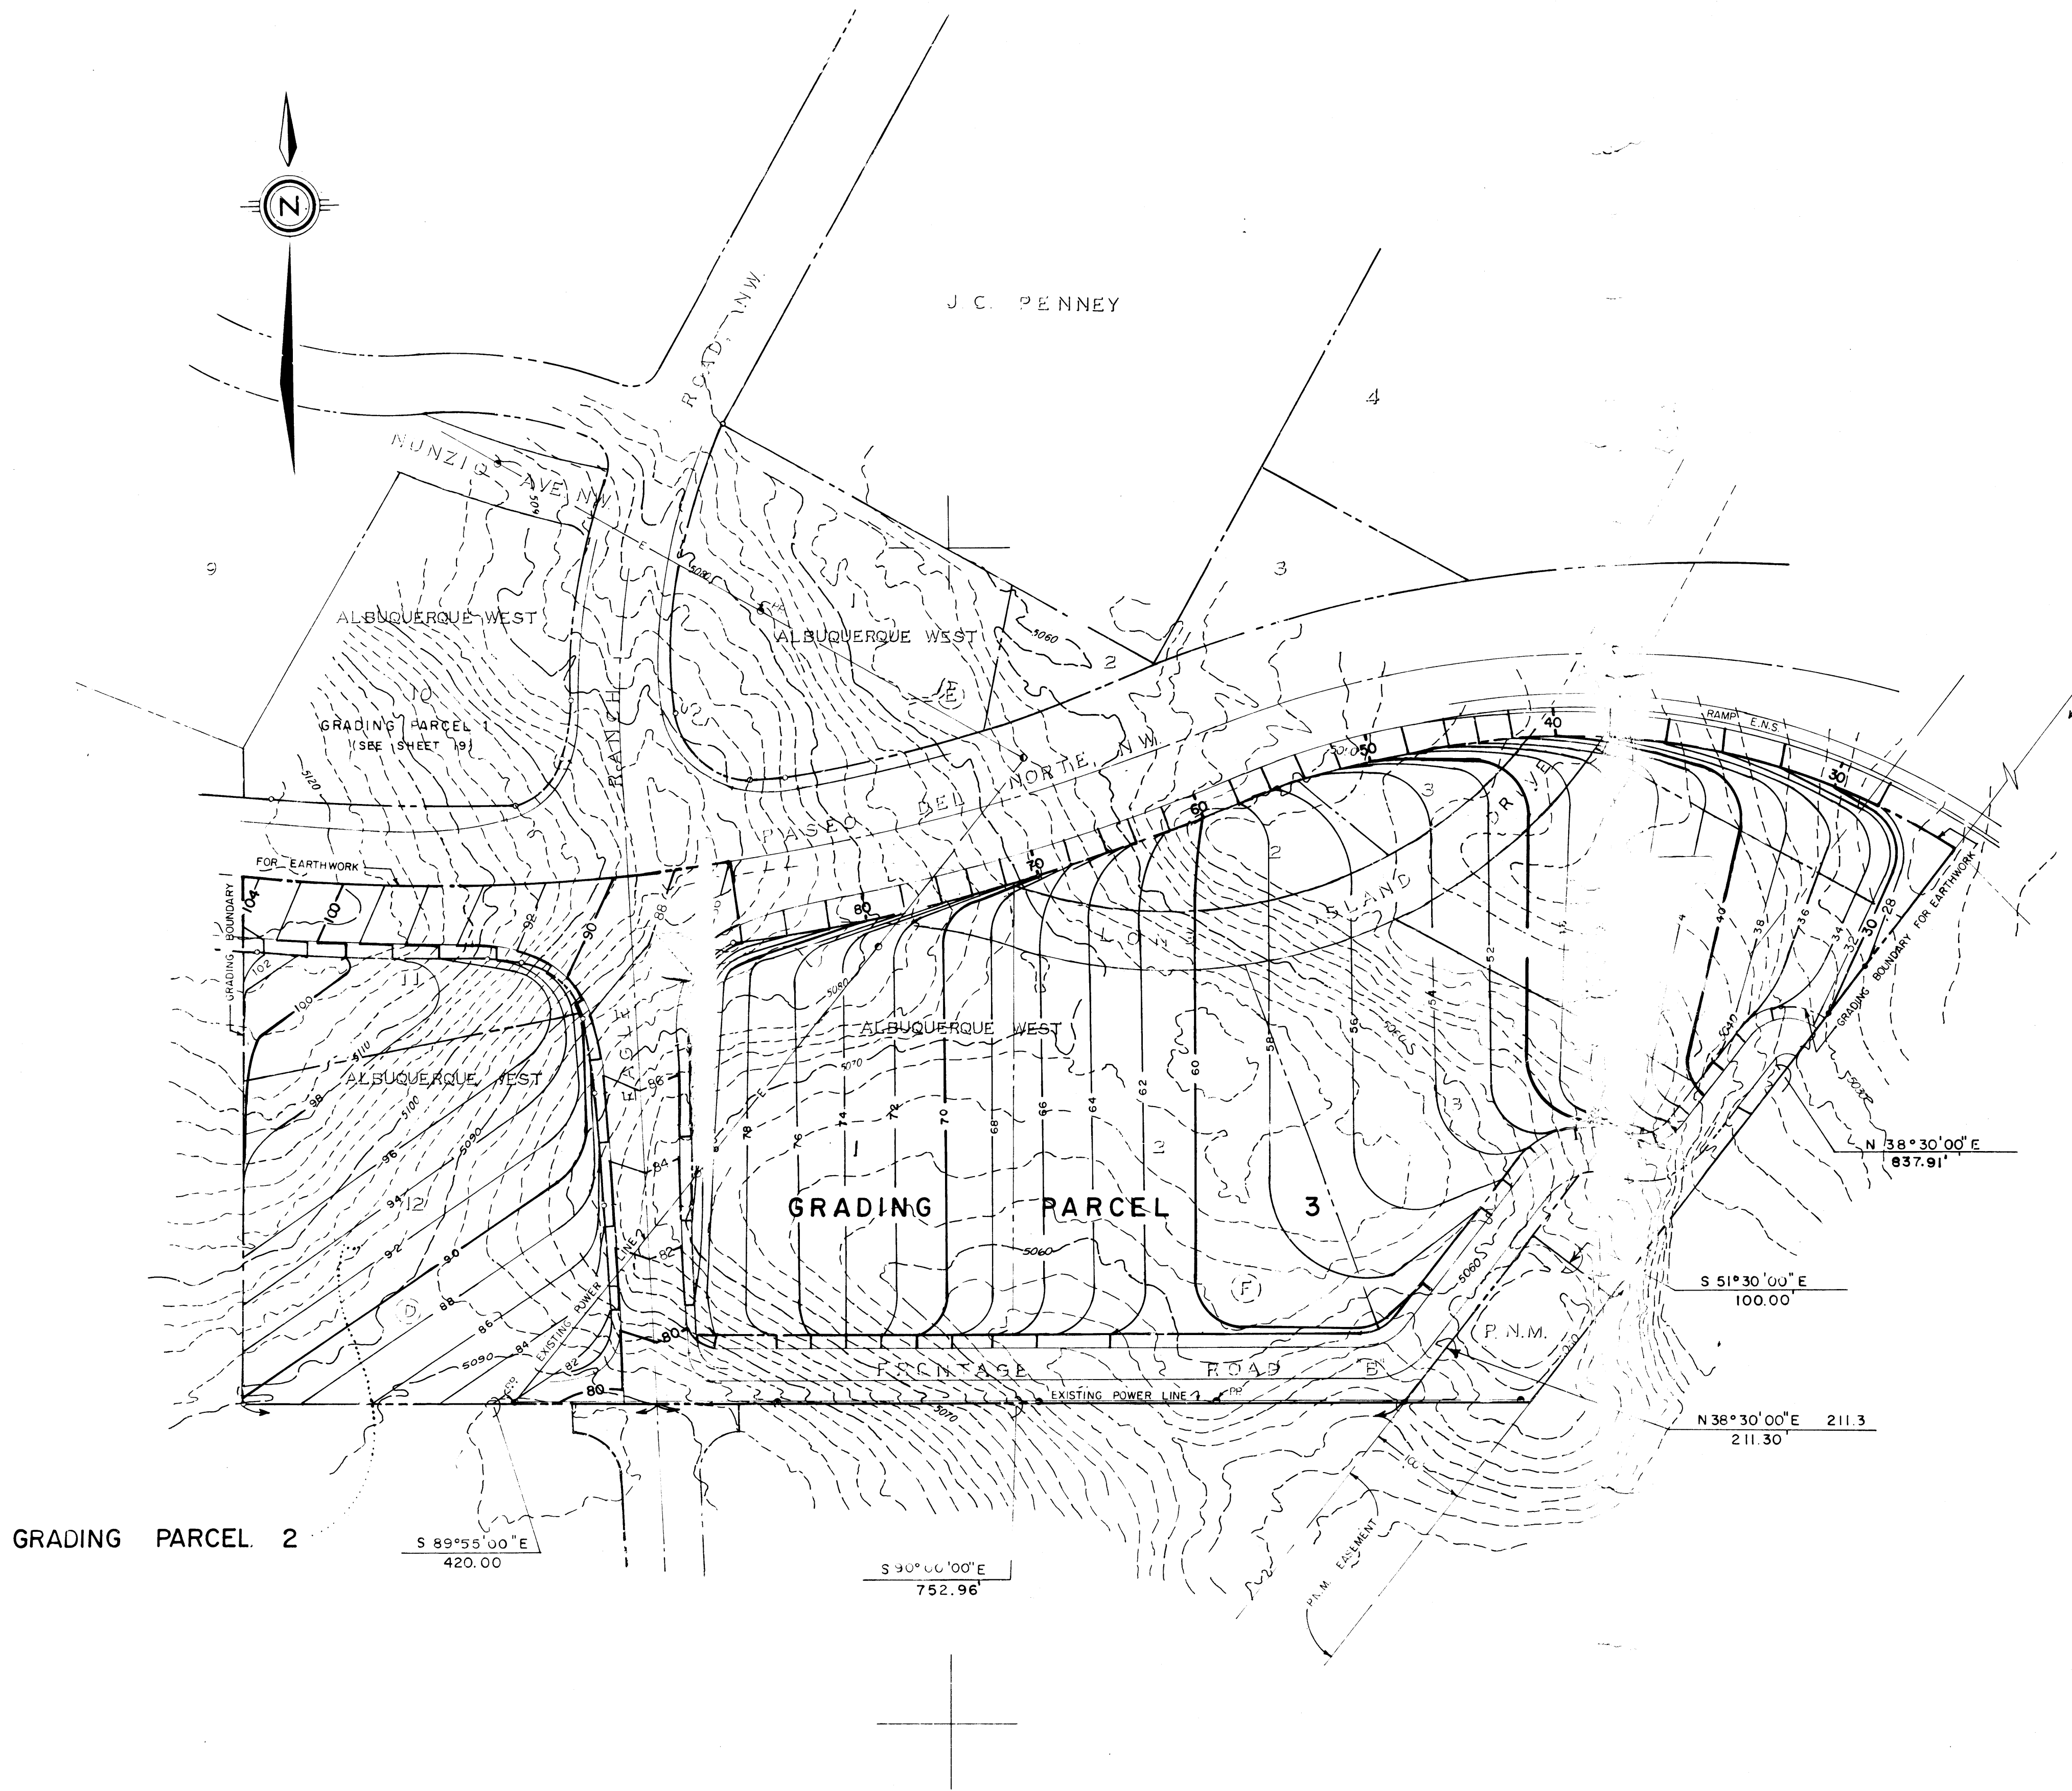

SCALE:		community sciences corporation	
1"=100'			
CITY OF ALBUQUERQUE MUNICIPAL DEVELOPMENT DEPARTMENT ENGINEERING DIVISION			
TITLE: ALBUQUERQUE WEST GRADING PARCELS 2 & 3 ROUGH GRADING PLAN			
APPROVALS	ENGINEER	DATE	APPROVALS
City Engineer	WJW	2/6/87	Liquid Waste
A.C.E. - Design	WJW	2-6-87	Traffic
A.C.E. - Hydrology	WJW	1-28-87	Water
DRAWING NO.		MAP NO.	SHEET OF
C-12, D-13		20	20

NOTE:
POWER POLES TO BE RELOCATED BY POWER COMPANY
BEFORE COMMENCING OF CONSTRUCTION.

APPROVED FOR ROUGH GRADING (± 1 FT.)	DATE
CITY HYDROLOGY	2-6-87

SURVEY INFORMATION		FIELD NOTES		BENCH MARKS		AS BUILT INFORMATION	
NO.	BY	NO.	DATE	NO.	DATE	CONTRACTOR	DATE
						INSPECTOR'S	DATE
						ACCEPTANCE BY	DATE
						VERIFICATION BY	DATE
						GRADING BY	DATE
						MICRO-FILM	DATE
						RECORDED BY	DATE
						NO	DATE