


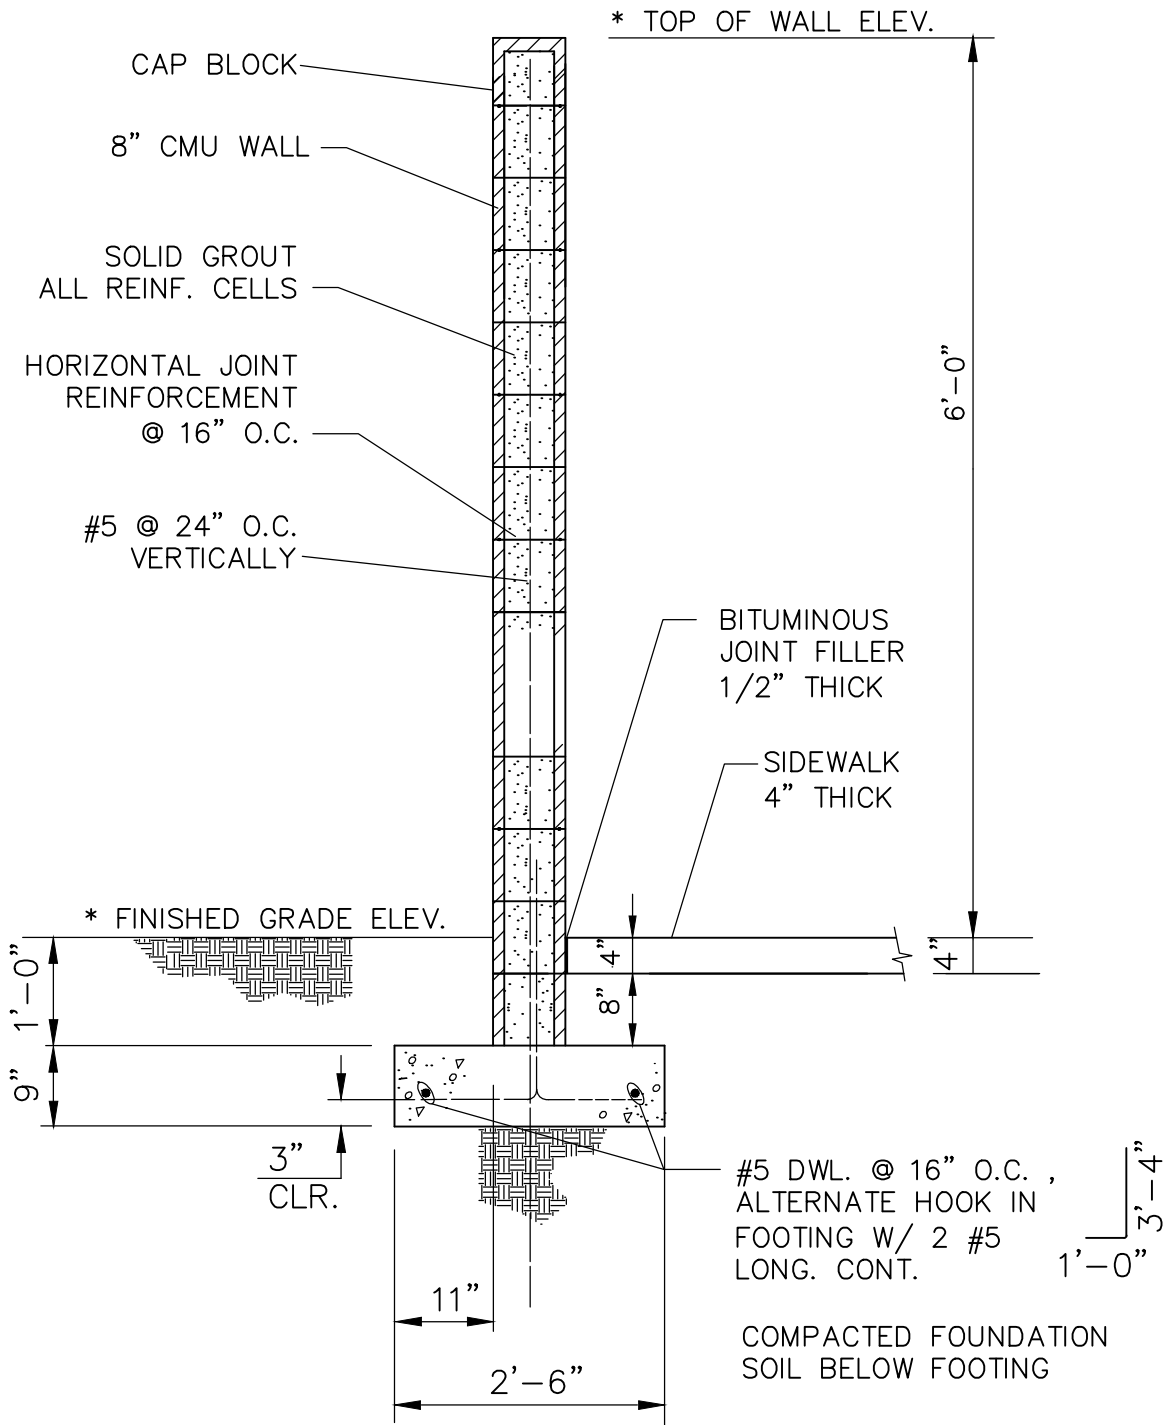

CMU GARDEN WALL
NOT TO SCALE

**WILSON
& COMPANY**
2600 THE AMERICAN RD. SE SUITE 100
RIO RANCHO, NM 87124
PHONE: 505-898-8021
FAX: 505-898-8501
www.wilsonco.com

PROJECT NAME
CITY OF ALBUQUERQUE
PUBLIC WORKS DEPARTMENT
ENGINEERING GROUP

SAD 228
DRAINAGE PLAN UNIT 19

SEAL

SHEET TITLE **LEGAL DESCRIPTION**
LOT 8, BLOCK 4
VOLCANO CLIFFS SUBDIVISION
UNIT 19

WCI	#0840010400	SHEET NO:
DESIGNED BY:		02
DRAWN BY:		
CHECKED BY:		
DATE:	SEPTEMBER 2014	