



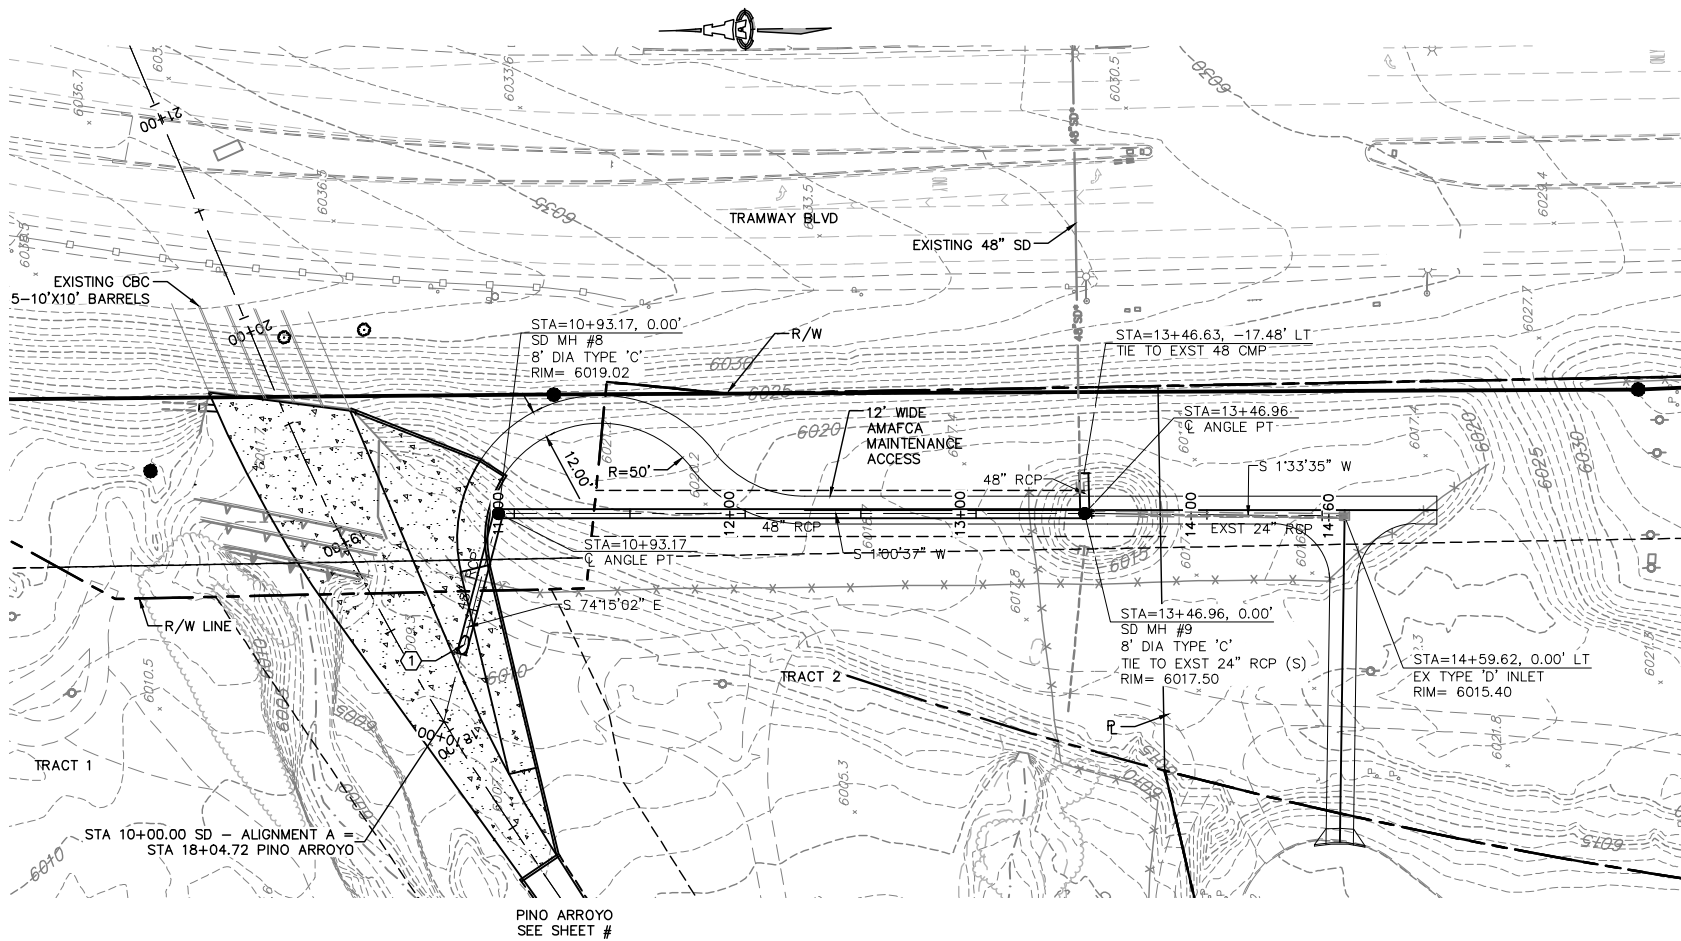

STORM DRAIN 'A'

SCALES:
1"=40' HOR.
1"=10' VERT.

Elevation Datum: NAVD 88

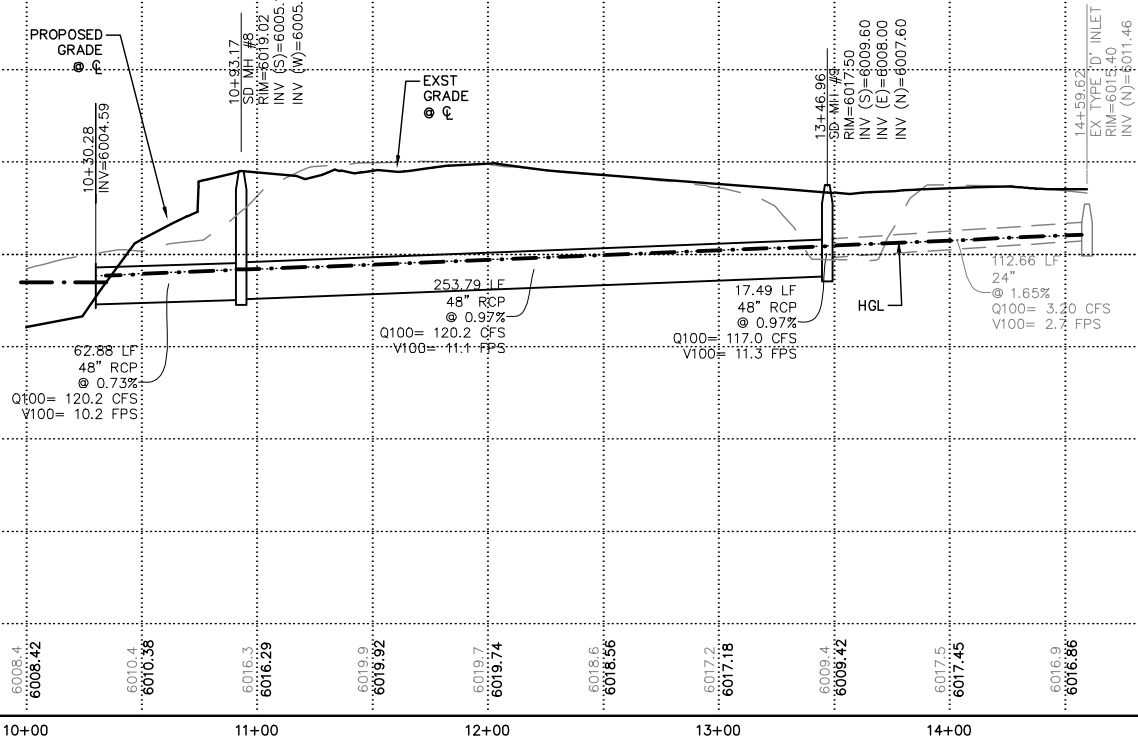

ISAACSON & ARFMAN, P.A.
Consulting Engineering Associates
 128 Monroe Street N.E.
 Albuquerque, New Mexico 87108
 Ph. 505-268-8828 www.iacivil.com
 1883 CP-302.dwg Nov 20,2014

CITY OF ALBUQUERQUE
PUBLIC WORKS DEPARTMENT
ENGINEERING GROUP

TITLE: THE FOOTHILLS
STORM DRAIN 'A' STA 10+00 - END

CONCEPTUAL PLAN AND PROFILE

Design Review Committee	City Engineer Approval	Last Design Update	Mo./Day/Yr.	Mo./Day/Yr.

City Project No.	Zone Map No.	Sheet	0
------------------	--------------	-------	---

[illegible]