



\\projects\1800-1899\1883\DWG\1883 CP-302.dwg, 2/27/2015 3:14:00 PM, thor

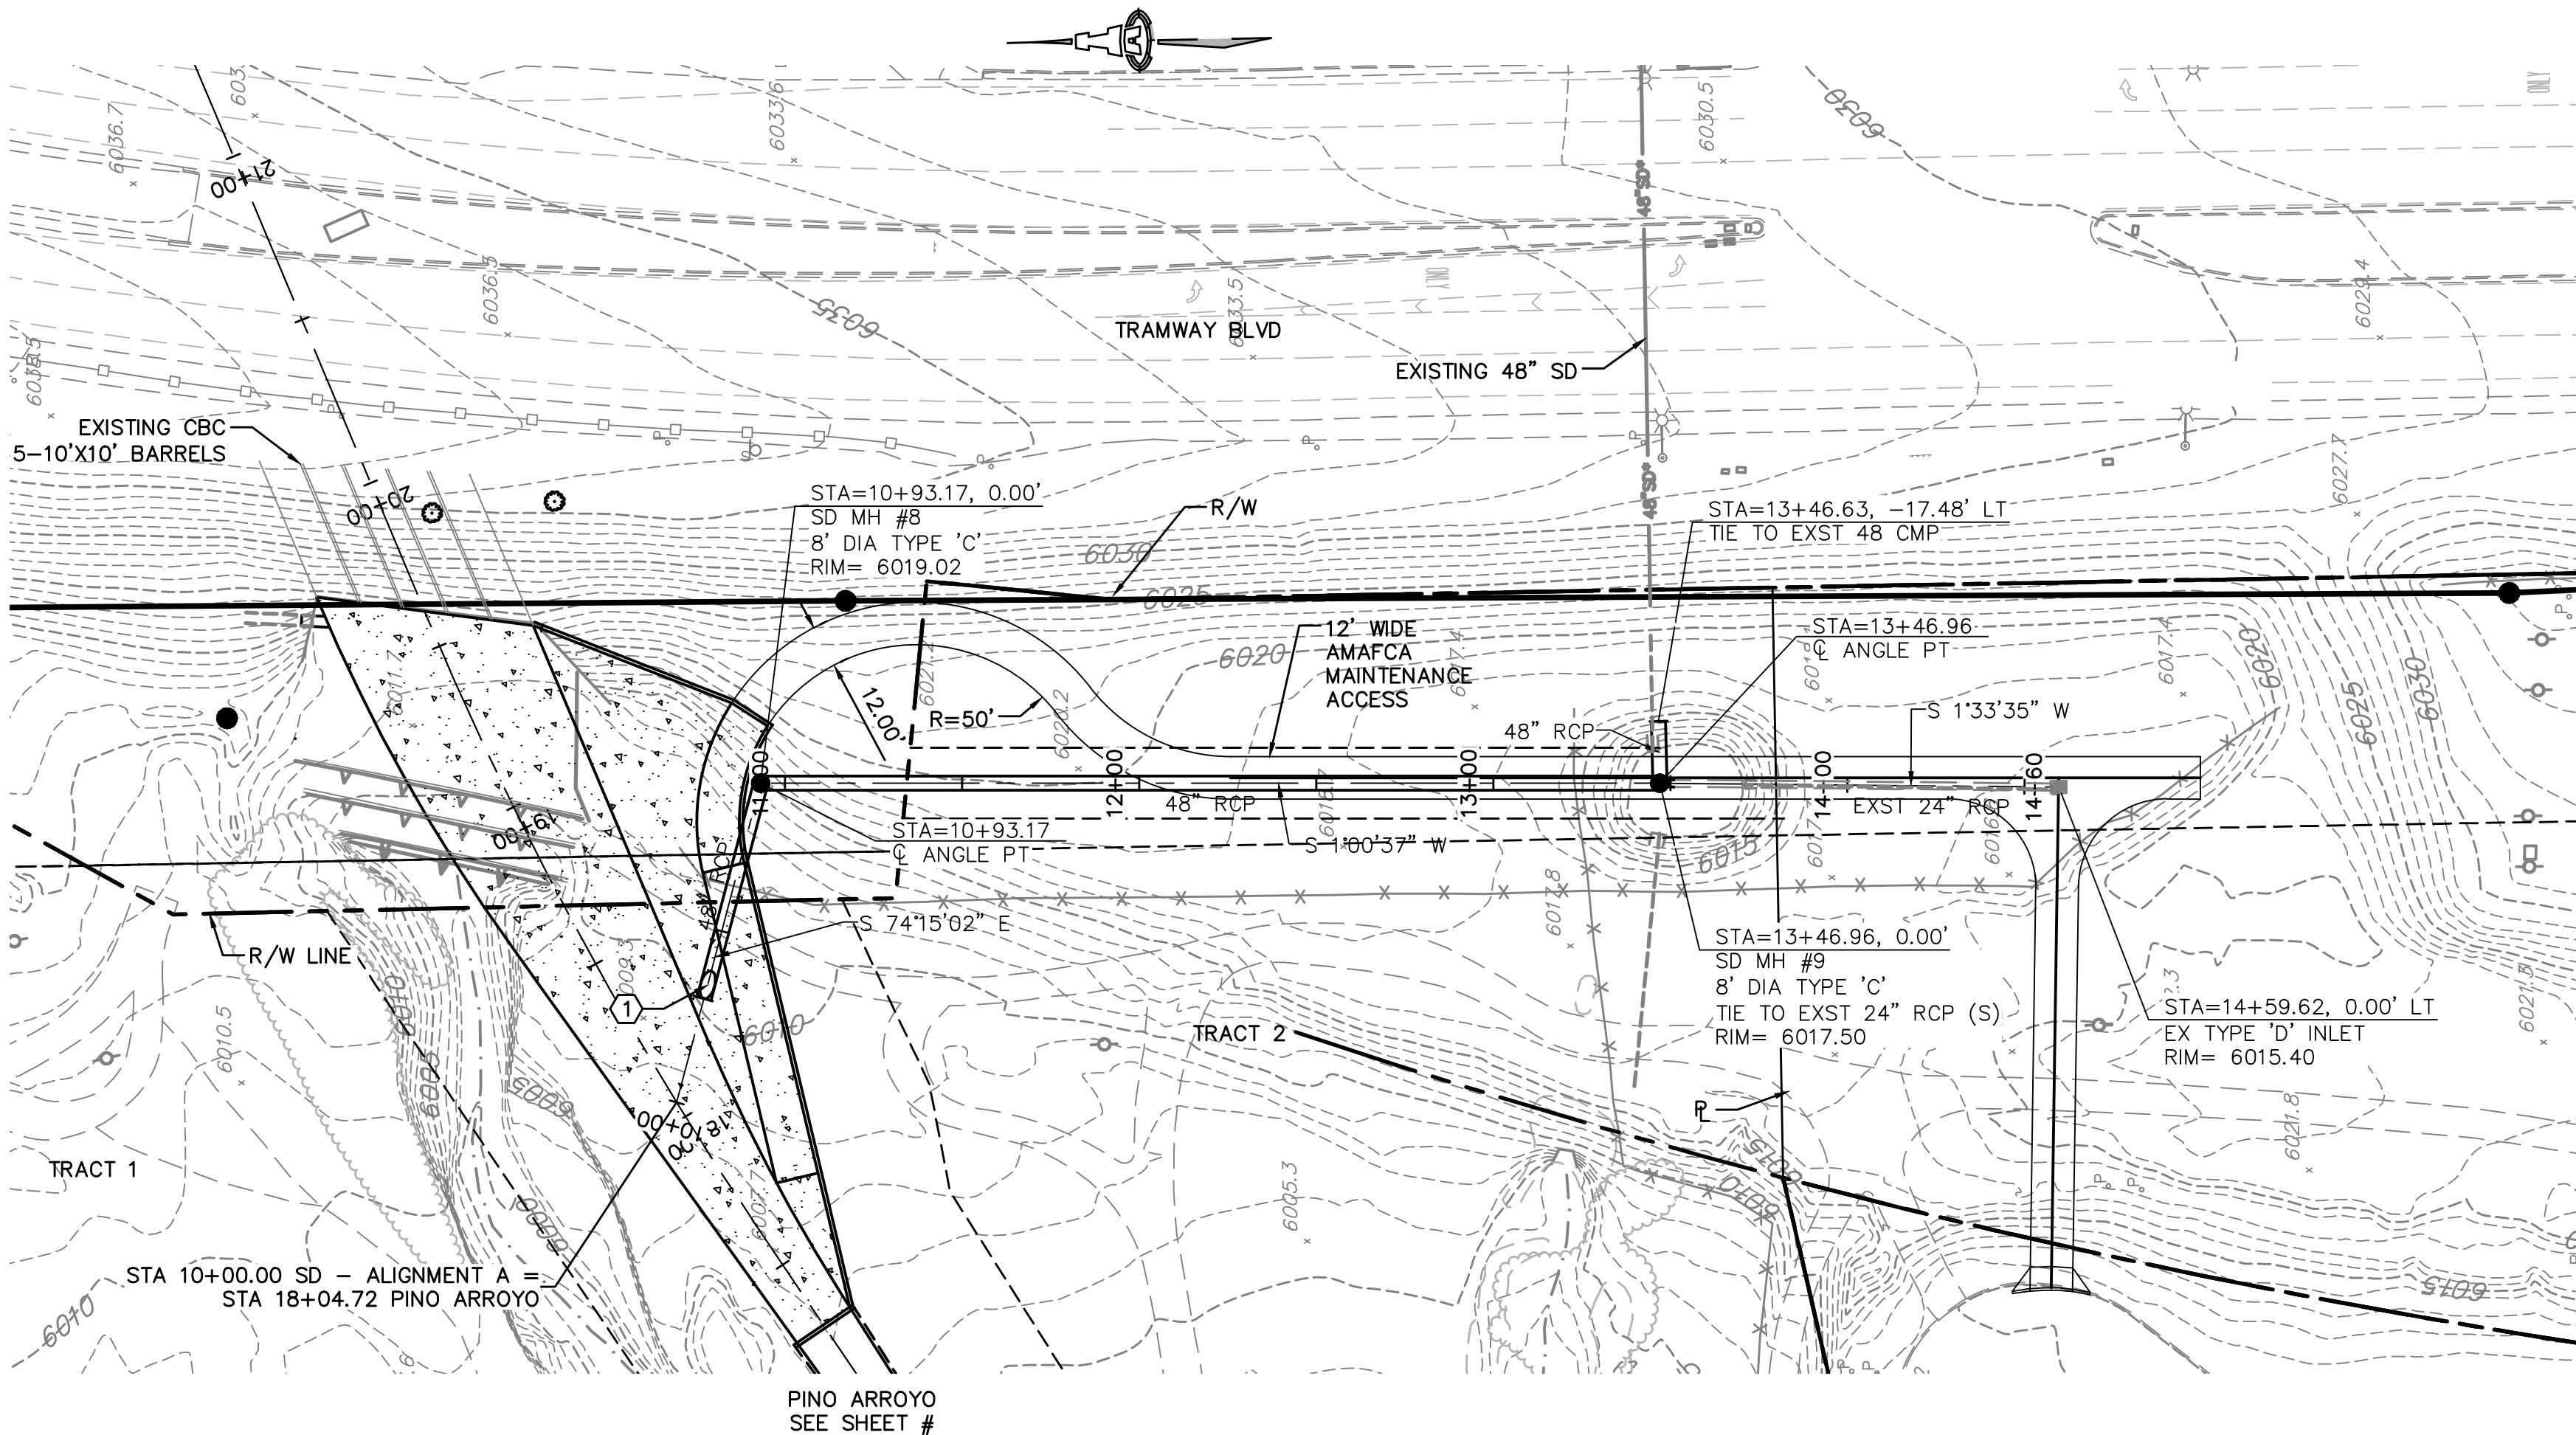

STORM DRAIN 'A'

SCALES:
1"=40' HOR.
1"=10' VERT.

Elevation Datum: NAVD 88

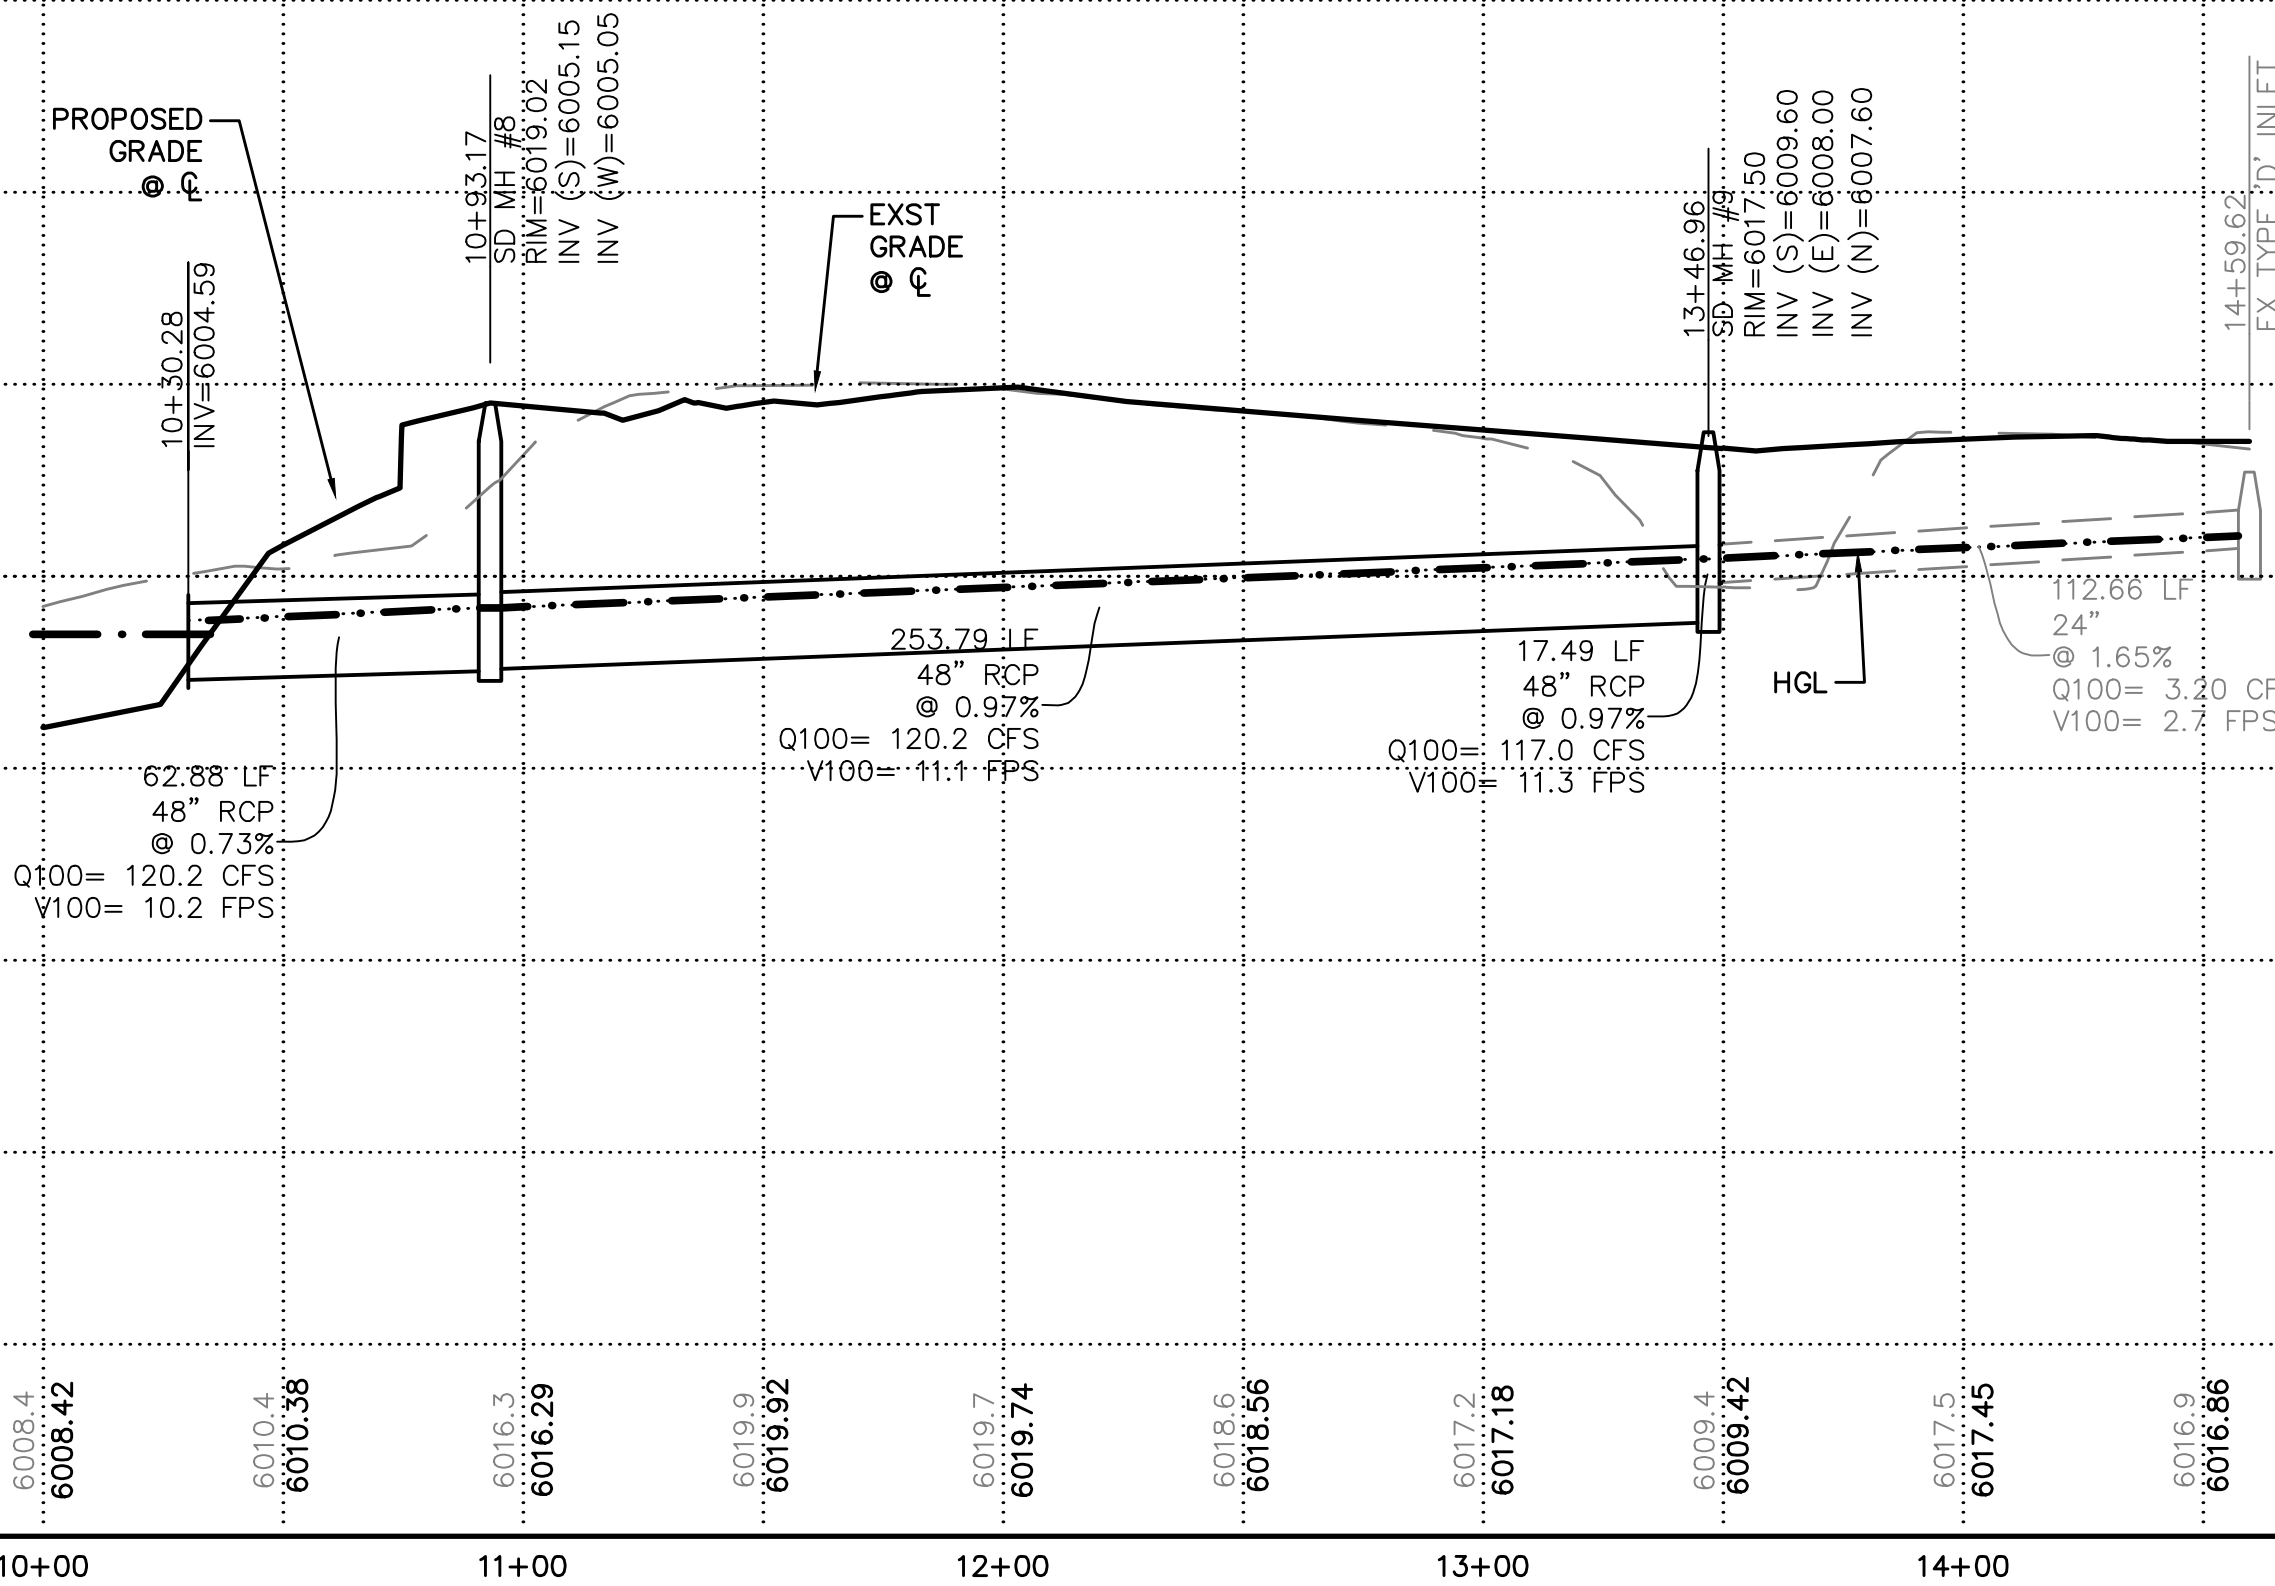


KEYED NOTES

1. 48" RCP PENETRATION INTO CHANNEL SIDE SLOPE PER AMAFCA STD DWG #104.

AS-BUILT INFORMATION	
CONTRACTOR	
WORK STAGED BY	
DATE	
ACCEPTANCE BY	
DATE	
FIELD CORRECTION BY	
DATE	
RECORDED BY	
DATE	

BENCH MARKS	
CITY OF ALBUQUERQUE "3-E23"	
ELEVATION: 6009.561 NAVD88.	

SURVEY INFORMATION	
FIELD NOTES	

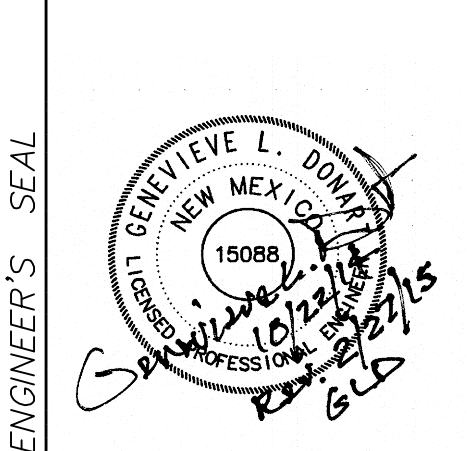

ENGINEER'S SEAL	
REVISIONS	BY
NO.	DATE
DESIGNED BY	GLD
DRAWN BY	thor
CHECKED BY	GLD
DATE	11/16/07

ISAACSON & ARFMAN, P.A.
Consulting Engineering Associates
128 Monroe Street N.E.
Albuquerque, New Mexico 87108
Ph. 505-268-8828 www.iacivil.com
1883 CP-302.dwg Nov 20, 2014

CITY OF ALBUQUERQUE
PUBLIC WORKS DEPARTMENT
ENGINEERING GROUP

TITLE: THE FOOTHILLS
STORM DRAIN 'A' STA 10+00 - END

CONCEPTUAL PLAN AND PROFILE	
Design Review Committee	City Engineer Approval
Last Design Update	
Mo./Day/Yr.	
Mo./Day/Yr.	
Mo./Day/Yr.	
Mo./Day/Yr.	