

REVISED DRAINAGE PLAN



EDMON INDUSTRIAL PARK

BERNALILLO COUNTY, NEW MEXICO


ZONE MAP F-15 BENCHMARK ACS 2-F15A ELEV. 4984.24 FLOOD PANEL 16

ZONED M-1 TOTAL AREA: 11.729 ACRES (510,915 SQ. FT.)

FILE #F15-D9 APPROVED:

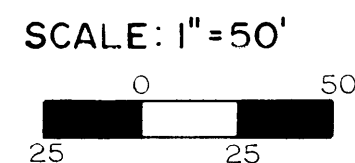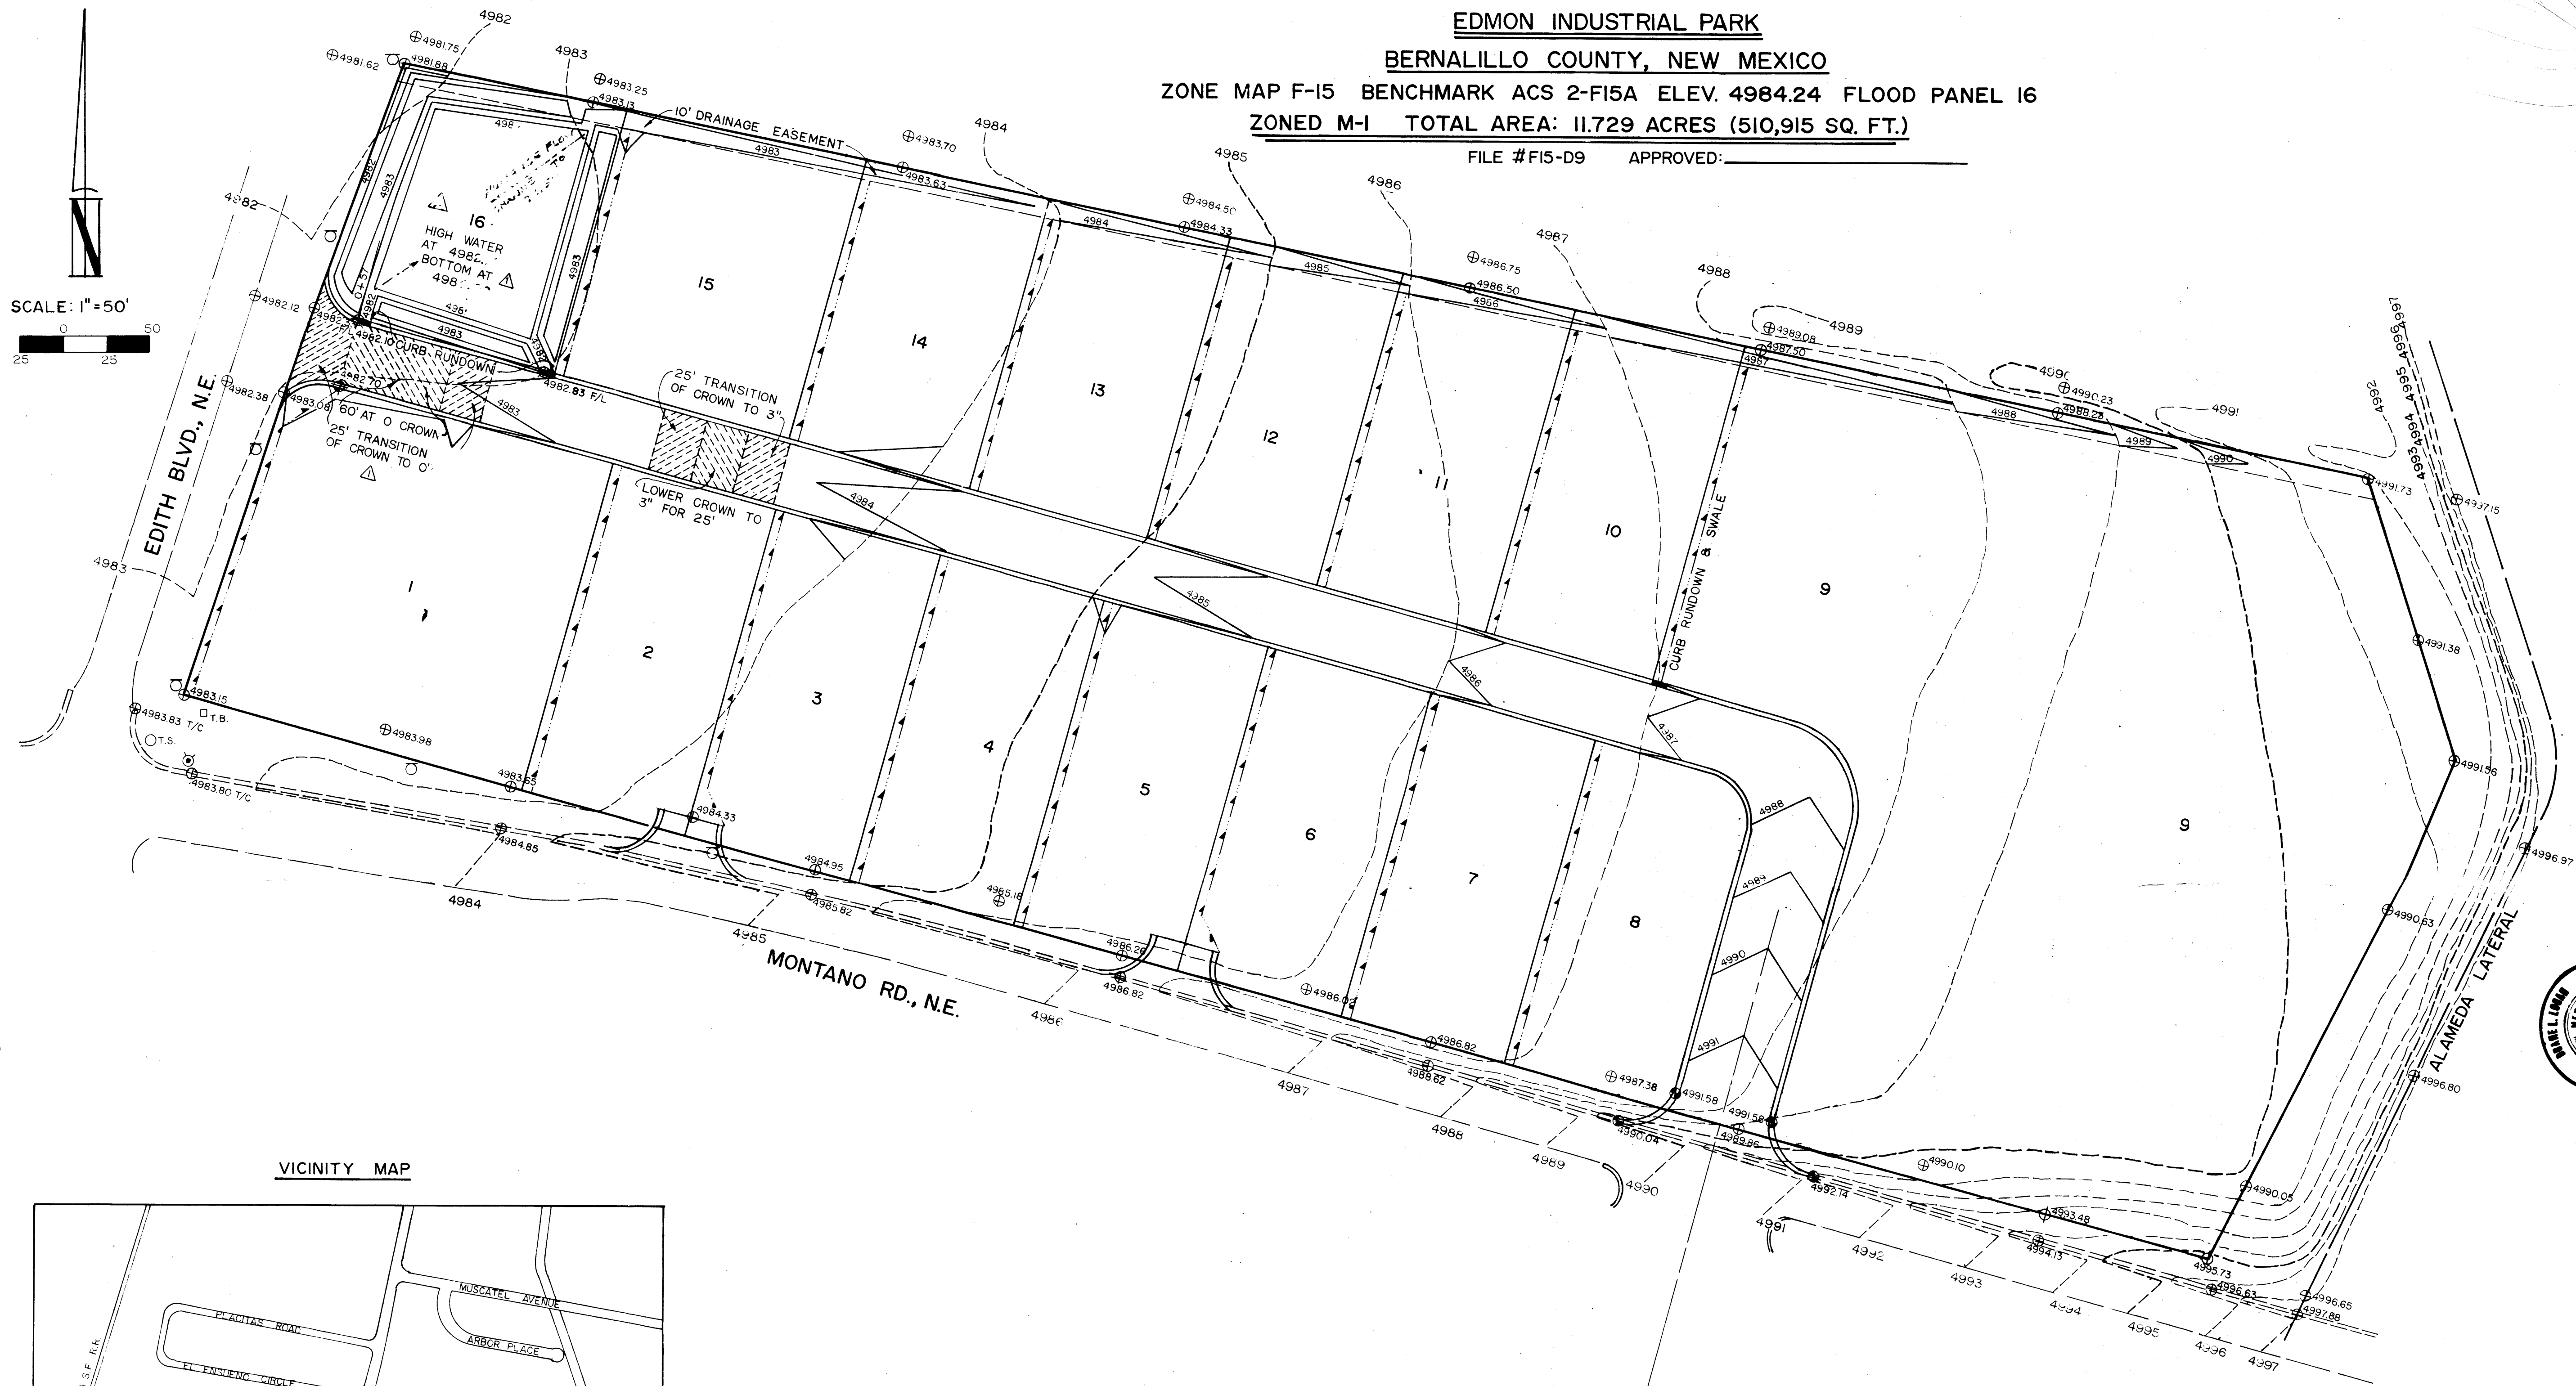


VICINITY MAP

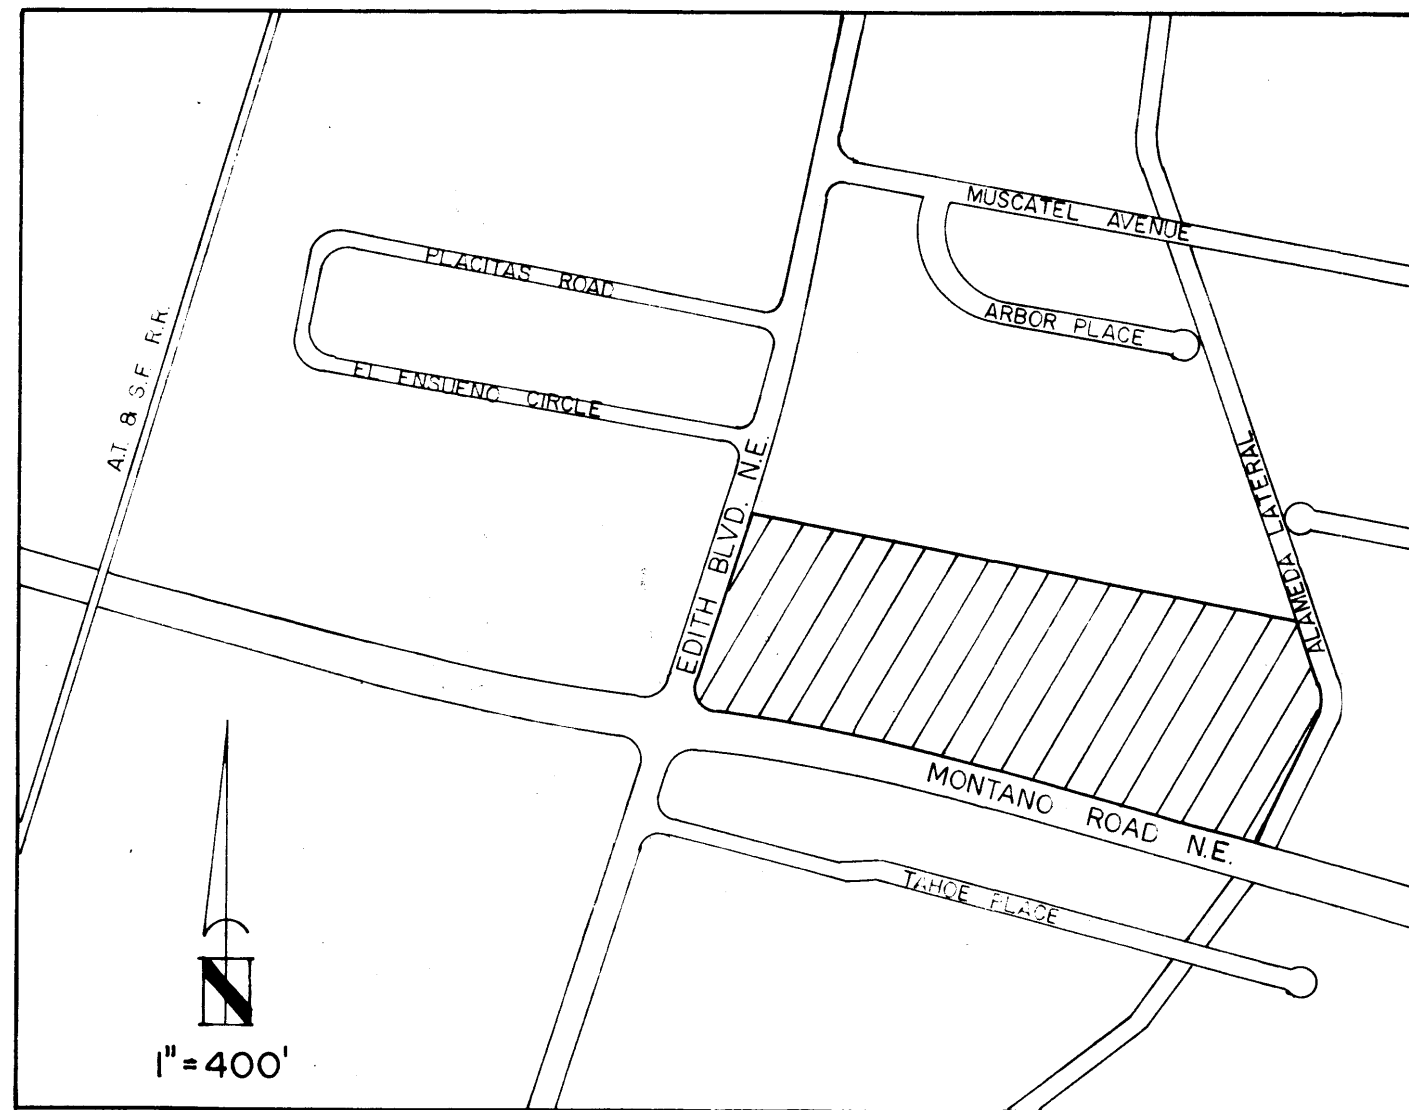

LEGEND

- EXISTING CONTOUR
- PROPOSED CONTOUR
- EXISTING SPOT ELEVATIONS
- PROPOSED SPOT ELEVATIONS
- DIRECTION OF FLOW
- DRAINAGE SWALE
- PROPOSED STANDARD CURB & GUTTER
- EXISTING STANDARD CURB & GUTTER
- EXISTING UTILITY POLE

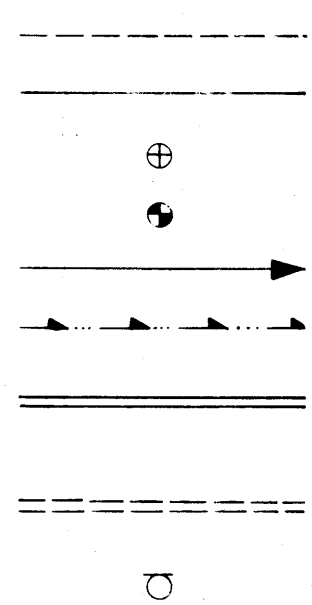

OCT 10 1985
HYDROLOGY SECTION

AS BUILT INFORMATION	
CONTRACTOR	
INSPECTOR'S NAME	
DATE	
FIELD	
DATE	
VERIFICATION BY	
DATE	
CORRECTED BY	
DATE	
RECORDED BY	
NO	


BENCH MARKS	
2-F15A AT SW CORNER OF EDITH & MONTANO	4984.24

SURVEY INFORMATION	
FIELD NOTES	
BY	
DATE	3/8/84
NO.	3-10 JAM & DLL


ENGINEER'S SEAL	
REGISTERED PROFESSIONAL ENGINEER	
STATE OF NEW MEXICO	
REGISTERED	
7-15-85	

REVISIONS	
NO.	DATE
1	7/16/84
2	7/20/84
3	7/31/84


CITY OF ALBUQUERQUE MUNICIPAL DEVELOPMENT DEPARTMENT ENGINEERING DIVISION					
TITLE: EDMON INDUSTRIAL PARK DEVELOPED DRAINAGE & GRADING PLAN					
APPROVALS	ENGINEER	DATE	APPROVALS	ENGINEER	DATE
City Engineer			Liquid Waste		
A.C.E. - Design			Traffic		
A.C.E. - Hydrology			Water		
PROJECT NO.	H-11	MAP NO.	F-15	PLATE	OF 2

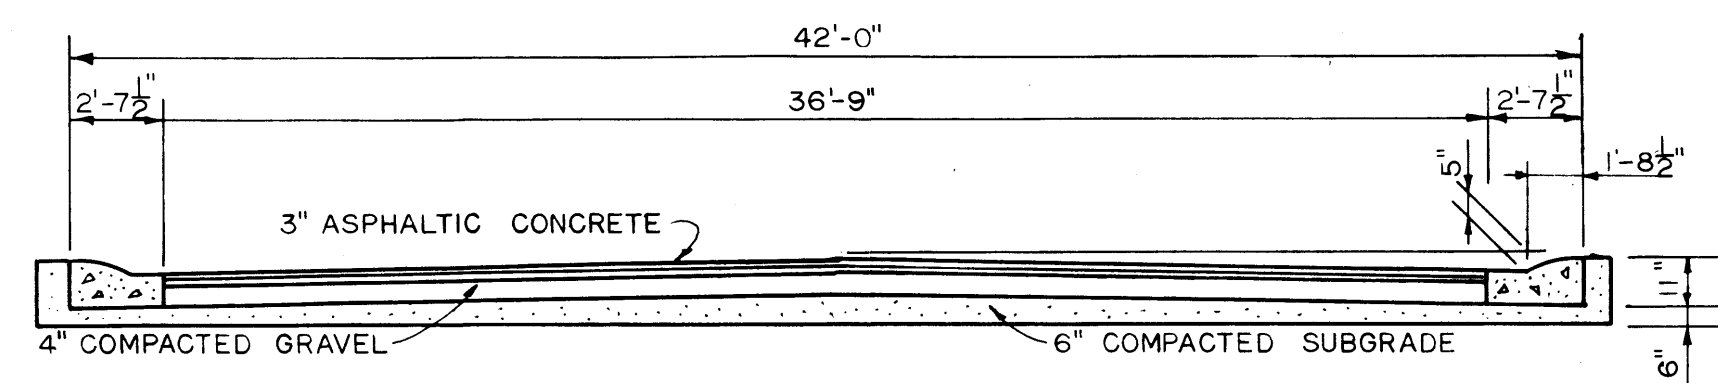


TYPICAL PAVEMENT SECTION
3/16" = 1'-0"

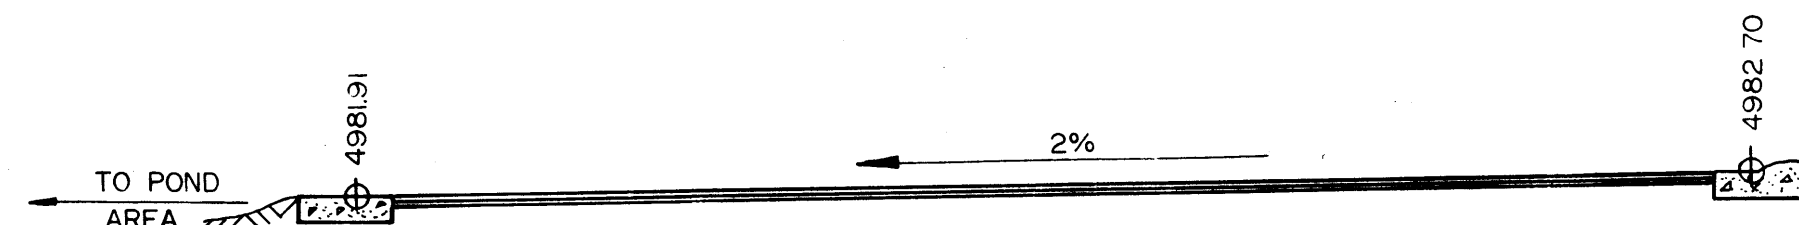


CROSS-SECTION AT 0+57
3/16" = 1'-0"

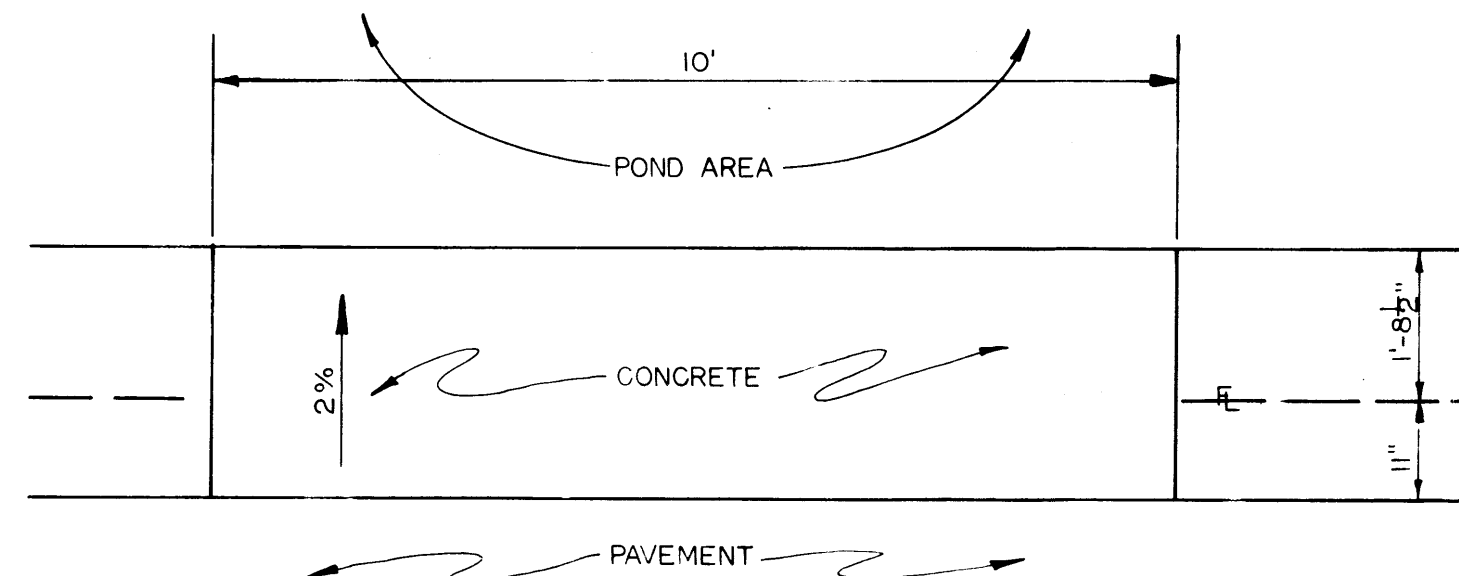


CURB RUNDOWN PLAN
1/2" = 1'-0"

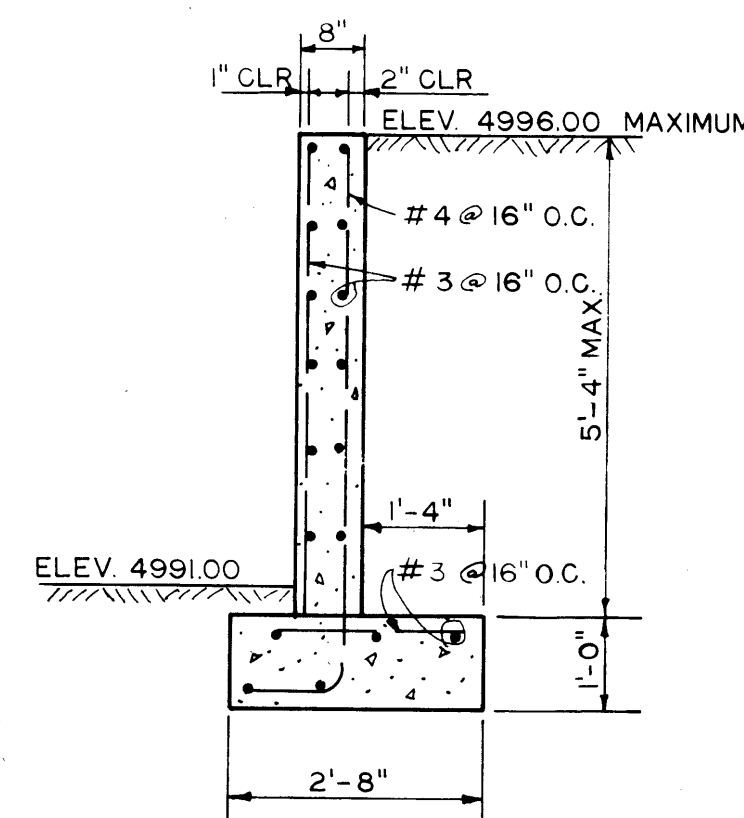


SUGGESTED RETAINING WALL (IF REQUIRED)
1/2" = 1'-0"

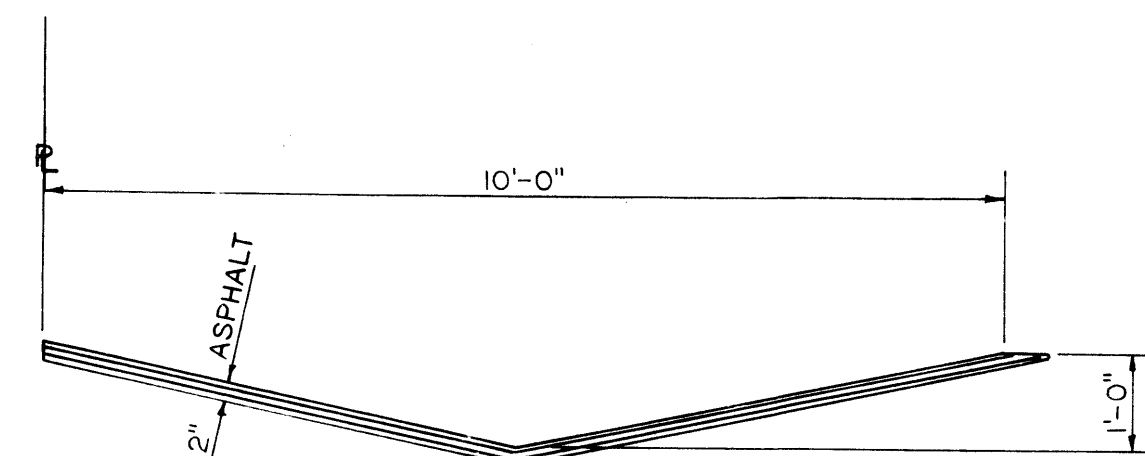


SWALE CROSS-SECTION
AT NORTH R. OF SUBDIVISION
AND WEST R. OF LOT 9
1/2" = 1'-0"

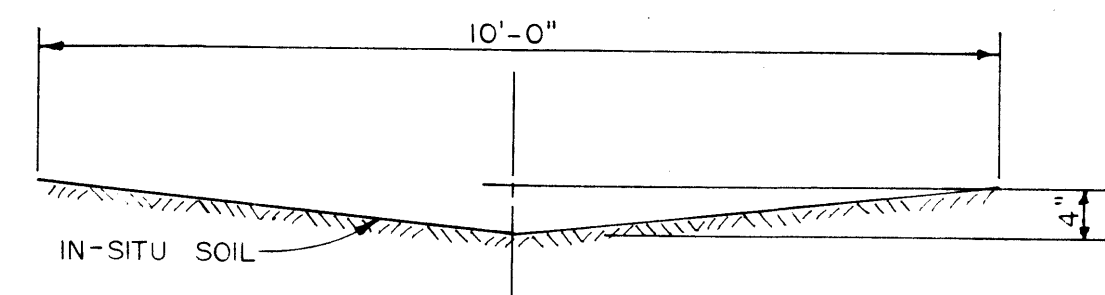


INDIVIDUAL LOT SWALES
1/2" = 1'-0"

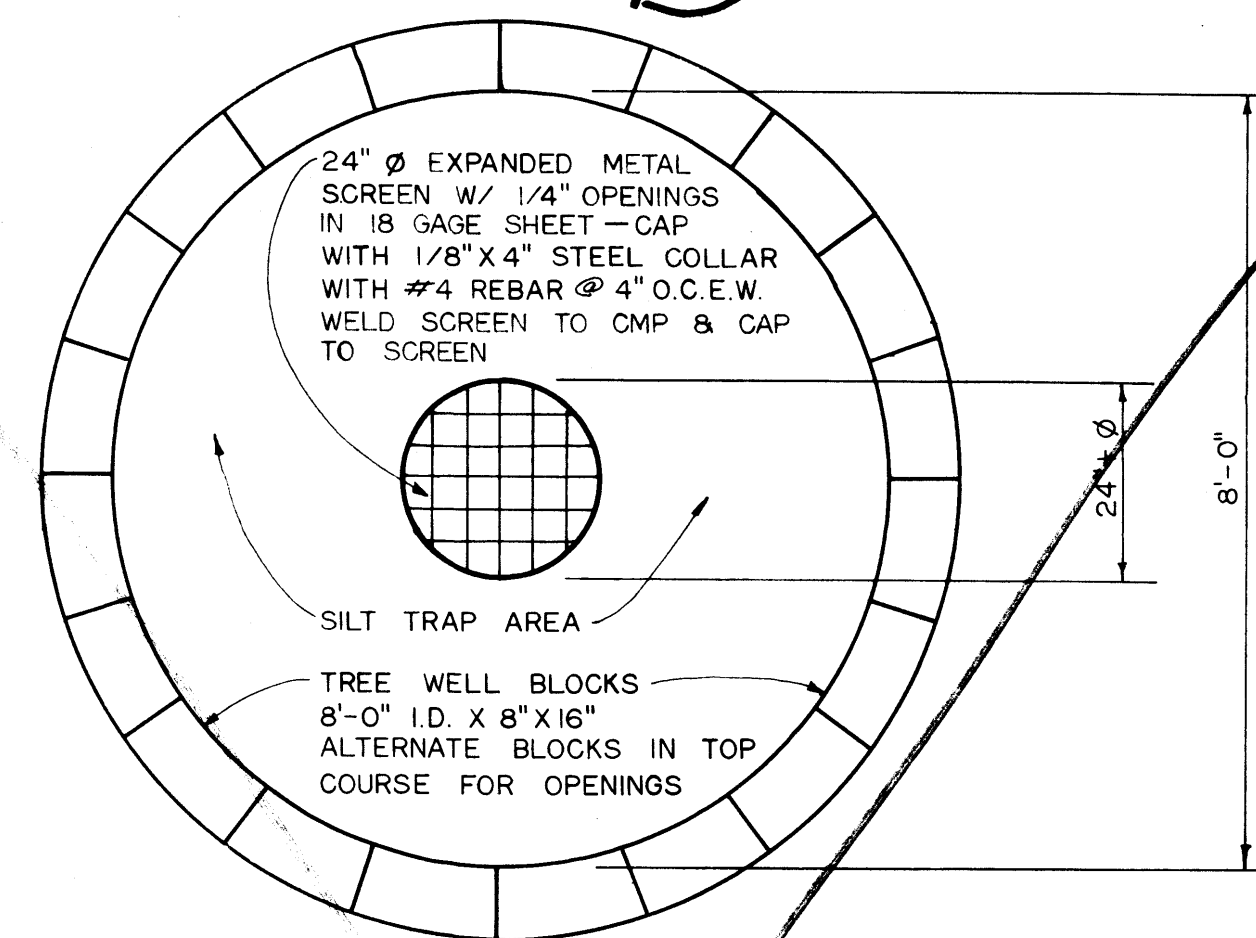


INJECTION WELL PLAN
1/2" = 1'-0"
(SQUARE CONFIGURATION IS ACCEPTABLE)

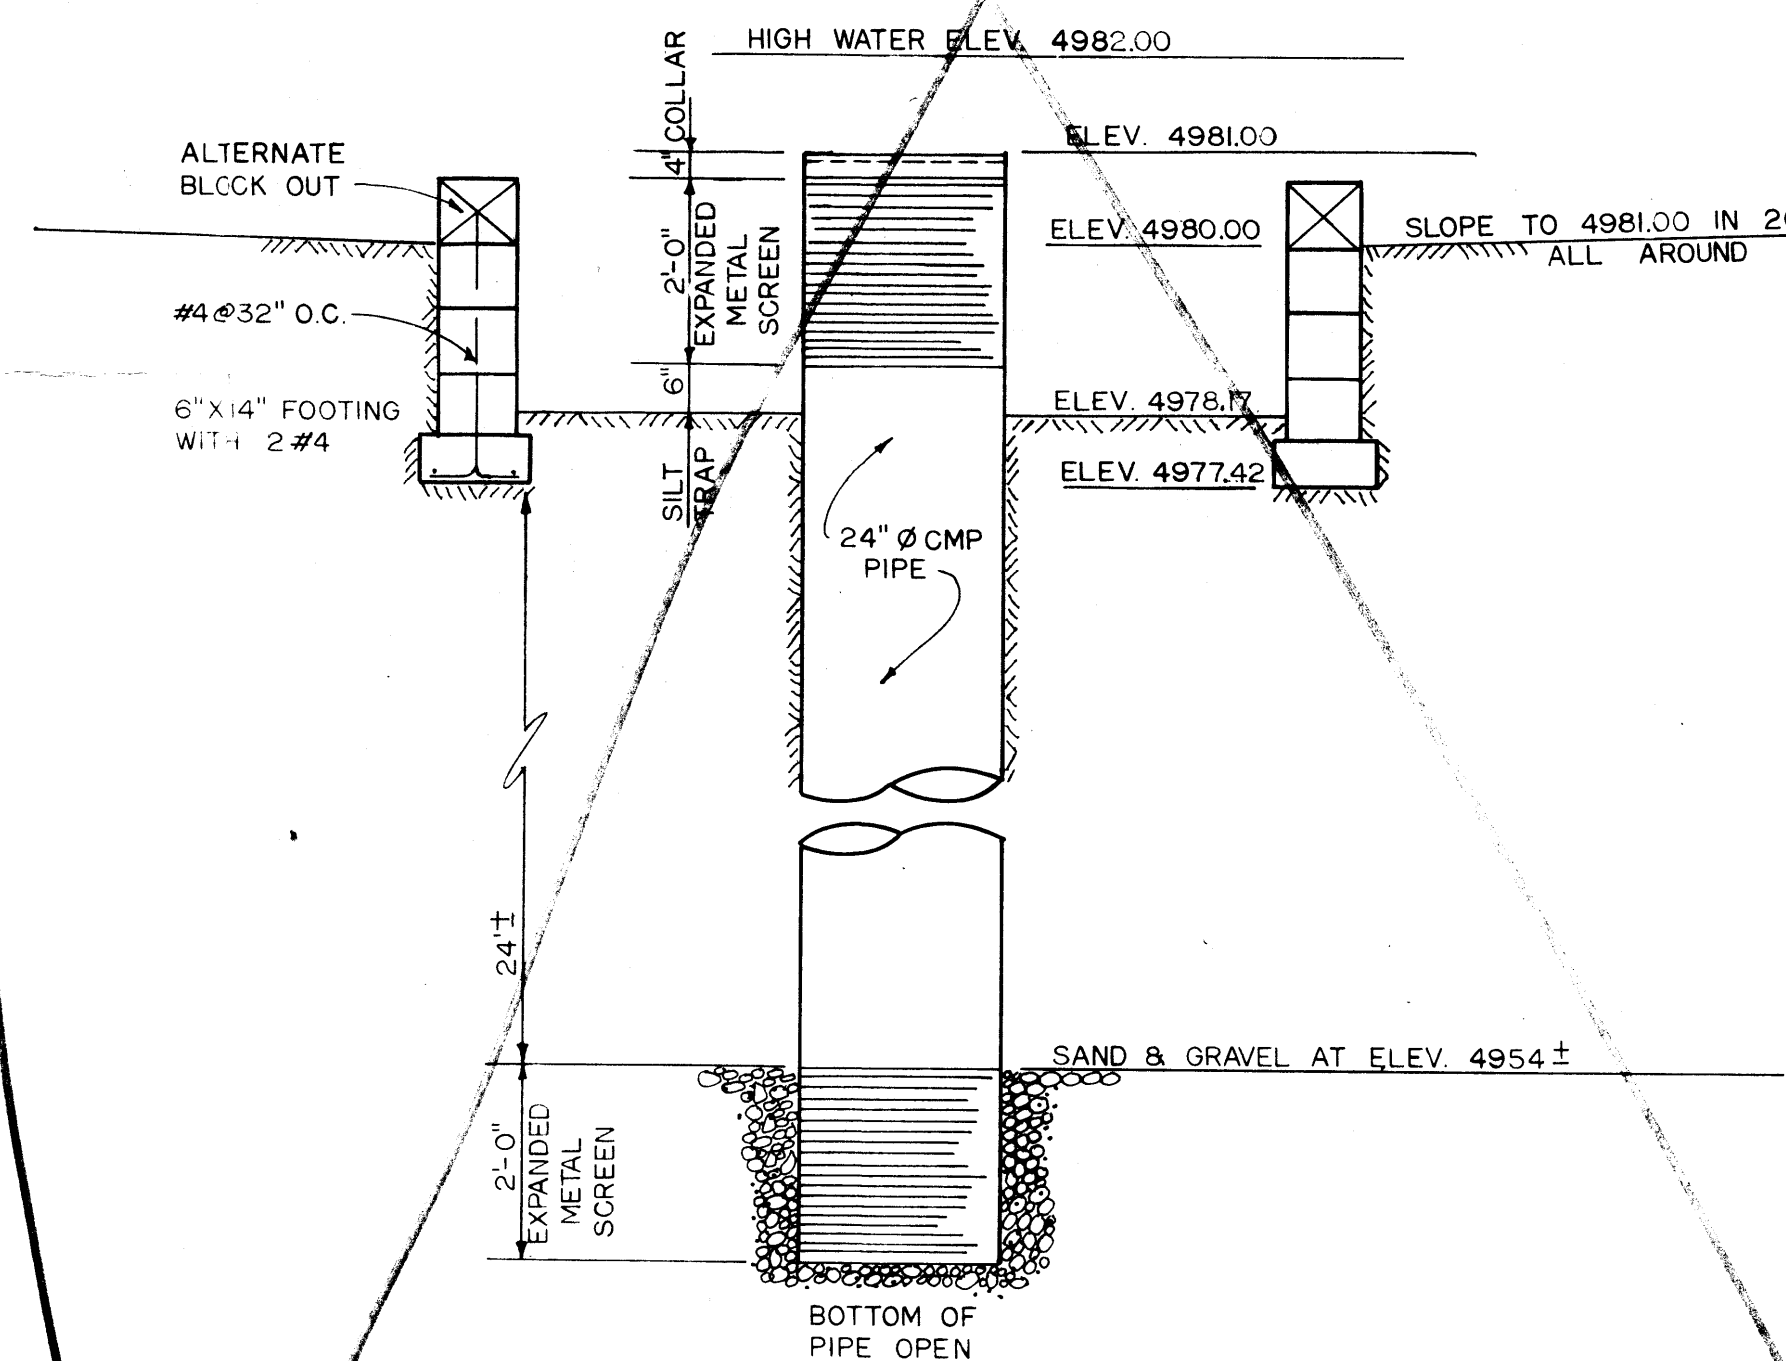

INJECTION WELL ELEVATION
1/2" = 1'-0"

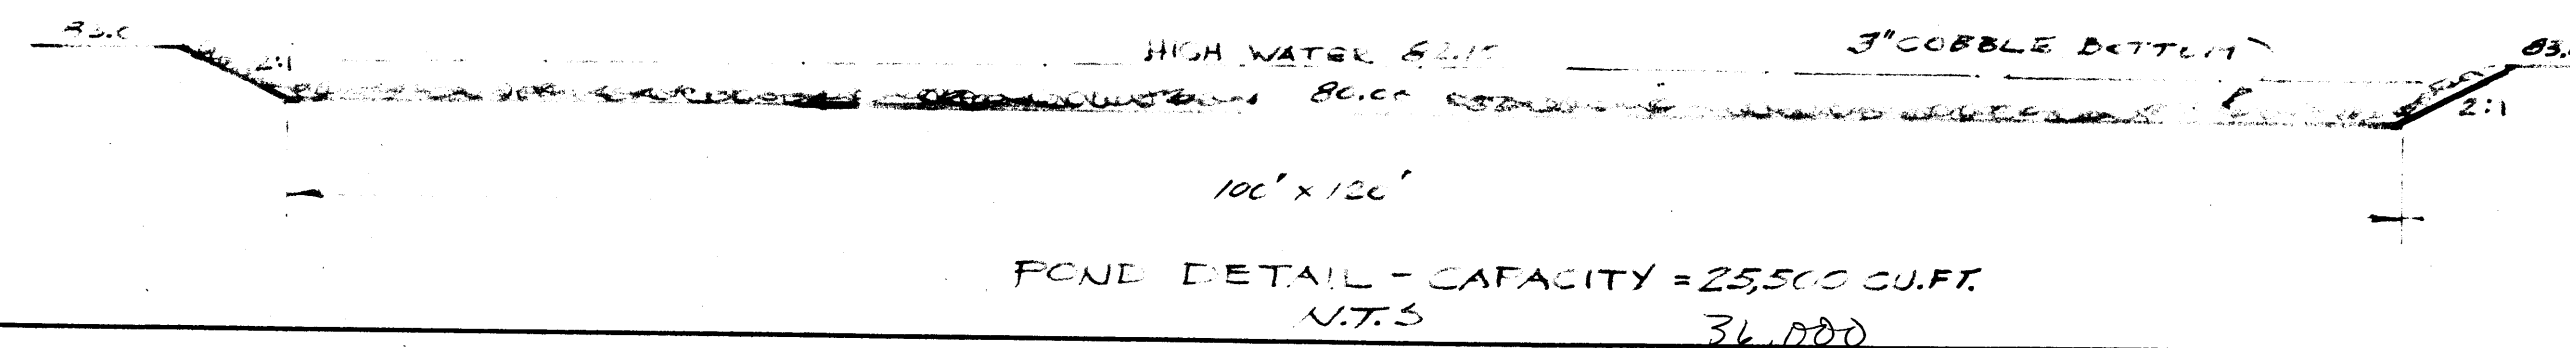

POND DETAIL - CAPACITY = 25,500 CU.FT.
N.T.S.

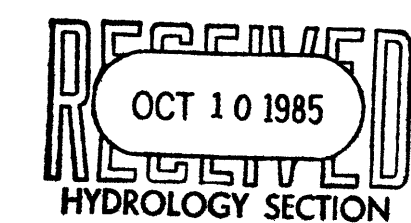

CITY OF ALBUQUERQUE MUNICIPAL DEVELOPMENT DEPARTMENT ENGINEERING DIVISION					
TITLE: EDMON INDUSTRIAL PARK CONSTRUCTION DETAILS					
APPROVALS	ENGINEER	DATE	APPROVALS	ENGINEER	DATE
City Engineer			Liquid Waste		
A.C.E. - Design			Traffic		
A.C.E. - Hydrology			Water		
PROJECT NO.	H-11	MAP NO.	F-15	PLATE	2 OF 2

ENGINEER'S SEAL				SURVEY INFORMATION		BENCH MARKS		AS BUILT INFORMATION			
 8/15/84 - 7:15 PM				FIELD NOTES							
				NO.	BY	DATE					
REVISIONS				MICRO-FILM INFORMATION							
DESIGN				RECORDED BY							
DRAWN BY				NO							
CHECKED BY											