
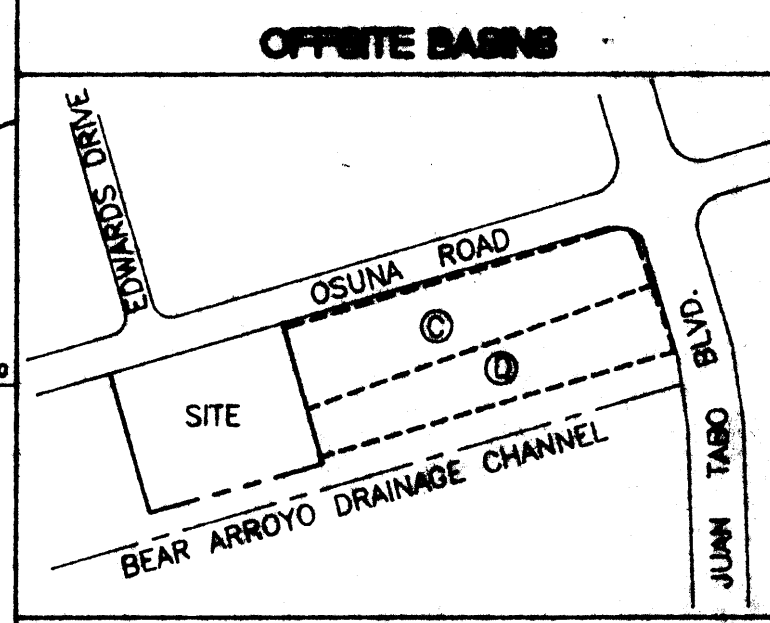
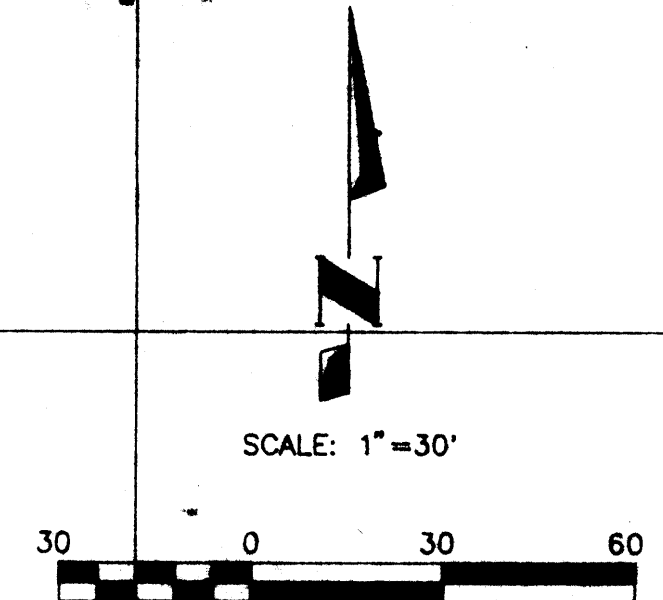


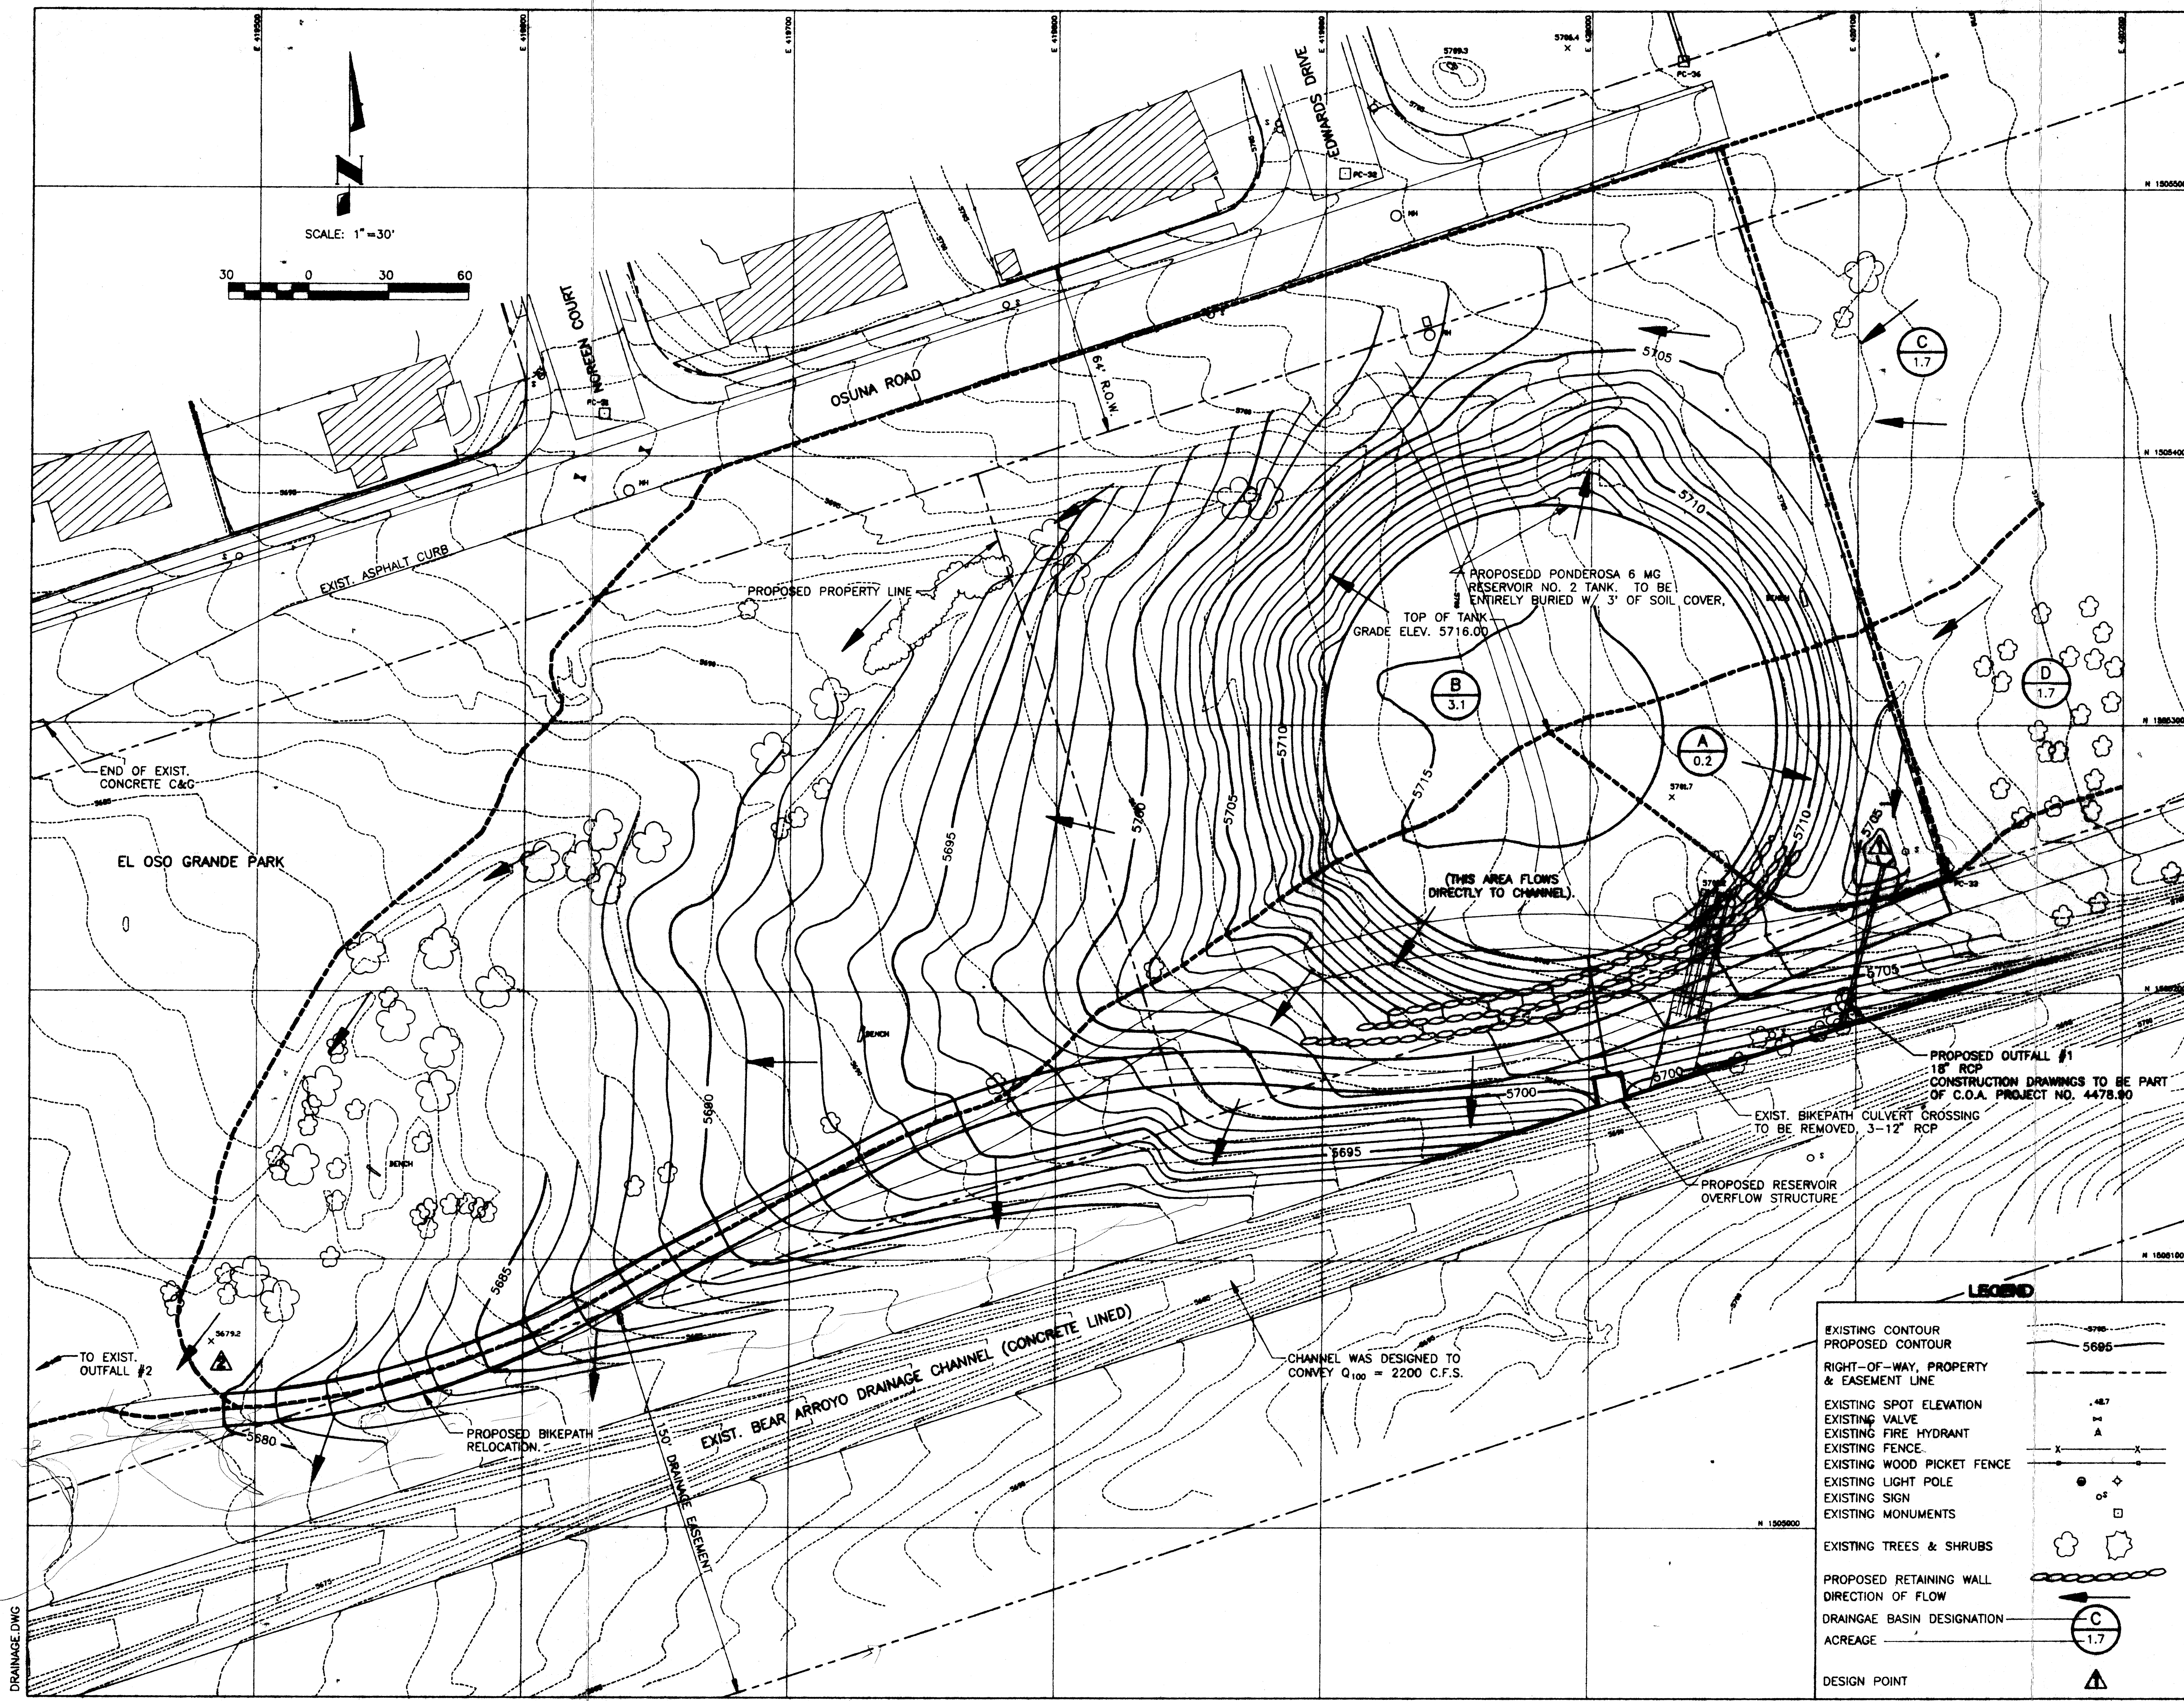

FLOW SUMMARY

BASIN	UNDEVELOPED		DEVELOPED	
	Q ₁₀ CFS	Q ₁₀₀ CFS	Q ₁₀ CFS	Q ₁₀₀ CFS
A	0.3	0.4	0.3	0.4
B	4.0	6.0	4.4	6.7
C	2.2	3.3	2.2	3.3
D	2.2	3.3	2.2	3.3

DESIGN POINT	UNDEVELOPED		DEVELOPED	
	Q ₁₀ CFS	Q ₁₀₀ CFS	Q ₁₀ CFS	Q ₁₀₀ CFS
1	2.4	3.7	2.4	3.7
2	4.3	6.6	4.7	7.1

- LEGEND**
- EXISTING CONTOUR
 - PROPOSED CONTOUR
 - RIGHT-OF-WAY, PROPERTY & EASEMENT LINE
 - EXISTING SPOT ELEVATION
 - EXISTING VALVE
 - EXISTING FIRE HYDRANT
 - EXISTING FENCE
 - EXISTING WOOD PICKET FENCE
 - EXISTING LIGHT POLE
 - EXISTING SIGN
 - EXISTING MONUMENTS
 - EXISTING TREES & SHRUBS
 - PROPOSED RETAINING WALL
 - DIRECTION OF FLOW
 - DRAINAGE BASIN DESIGNATION
 - ACREAGE
 - DESIGN POINT

URS
CONSULTANTS, INC.
MAKING TECHNOLOGY WORK

CITY OF ALBUQUERQUE
PUBLIC WORKS DEPARTMENT
ENGINEERING GROUP

RECEIVED
JUL 22 1992
HYDROLOGY DIVISION

TITLE: **PONDEROSA RESERVOIR NO. 2 DRAINAGE PLAN**

APPROVALS	ENGINEER	DATE	APPROVALS	ENGINEER	DATE
DRC CHAIRMAN			WATER		
TRANSPORTATION			WASTEWATER		
HYDROLOGY					

AS BUILT INFORMATION

CONTRACTOR	DATE

BENCH MARKS

NO.	FIELD NOTES	DATE

ENGINEER'S SEAL

REVISIONS

NO.	DATE	REVISIONS	BY

DESIGNED BY **DATE** **7/15/92**
DRAWN BY **DATE** **7/16/92**
CHECKED BY **DATE** **7/16/92**