


PLUMBING SITE PLAN DESIGN NOTES & KEY PLAN

- | | |
|----|---|
| 1 | 1 1/2" TYPE K COPPER DOMESTIC WATER SERVICE (PRIVATE) |
| 2 | 1 1/2" WATER METER (PRIVATE) |
| 3 | 1 1/2" SADDLE TAP CONNECTION TO FIRE SERVICE (PRIVATE) |
| 4 | 4" D.I.P. FIRE SERVICE (PRIVATE) |
| 5 | 4" TAPPING SLEEVE w/ 4" TAPPING VALVE (PRIVATE) |
| 6 | 4" PVC RESTROOM WASTE SERVICE LINE (PRIVATE) |
| 7 | GREASE INTERCEPTOR |
| 8 | 3" VENT LINE |
| 9 | 4" PVC KITCHEN WASTE LINE (PRIVATE) |
| 10 | 4" ONE-WAY CLEANOUT (TRAFFIC RATED) (PRIVATE) |
| 11 | 4" TWO-WAY CLEANOUT (TRAFFIC RATED) (PRIVATE) |
| 12 | 4" PVC WASTEWATER SERVICE LINE (PRIVATE) |
| 13 | 4" WASTEWATER SERVICE CONNECTION TO EX SANITARY SEWER STUB |
| 14 | 3/4" TYPE K COPPER WATER SERVICE TO YARD HYDRANT (PRIVATE) |
| 15 | 3/4" YARD HYDRANT (PRIVATE) |
| 16 | ELECTRIC TRANSFORMER |
| 17 | ELECTRIC SERVICE LINE |
| 18 | ELECTRIC METER AND DISTRIBUTION PANEL |
| 19 | GAS METER |
| 20 | GAS SERVICE LINE |
| 21 | TELEPHONE SERVICE LINE |
| 22 | FIRE DEPARTMENT CONNECTION |
| 23 | CONNECT TO IRRIGATION SYSTEM |
| 24 | KNOX BOX |
| 25 | 3" WIDE CONCRETE PAN |
| 26 | 18" WIDE CHASE |
| 27 | TRASH ENCLOSURE AREA DRAIN. CONNECT TO PROPOSED SANITARY SEWER SYSTEM |

NOTES:

- REFER TO SHEET C-1.0 FOR GENERAL NOTES AND LEGEND.
- CONTRACTOR TO FIELD VERIFY VERTICAL & HORIZONTAL LOCATIONS OF ALL EXISTING UTILITIES.
- REFER TO C-5.0 - C-5.3 FOR CIVIL STANDARD DETAILS..
- ALL SANITARY PVC PIPE TO BE SDR35.
- CONTRACTOR TO DISCUSS TEMPORARY POWER WITH PNM.
- ALL ELEVATIONS AND INVERTS ARE 53XX.XX'.
- CONTRACTOR TO COORDINATE WITH WALMART ON RELOCATION OF EX ELECTRIC POLES.
- PAD TRANSFORMER TO BE INSTALLED BY PNM.
- MINIMUM COVER ON WATER & FIRE LINE SHALL BE IN ACCORDANCE PER CITY OF ALBUQUERQUE AND COUNTY OF BERNALILLO WATER DESIGN CRITERIA.
- 4" PVC ROOF DRAIN PIPE CORED TROUGH CURB TO SPILL INTO DRIVE THRU LANE.

SANITARY DESIGN DETAIL
SCALE 1" = 10'

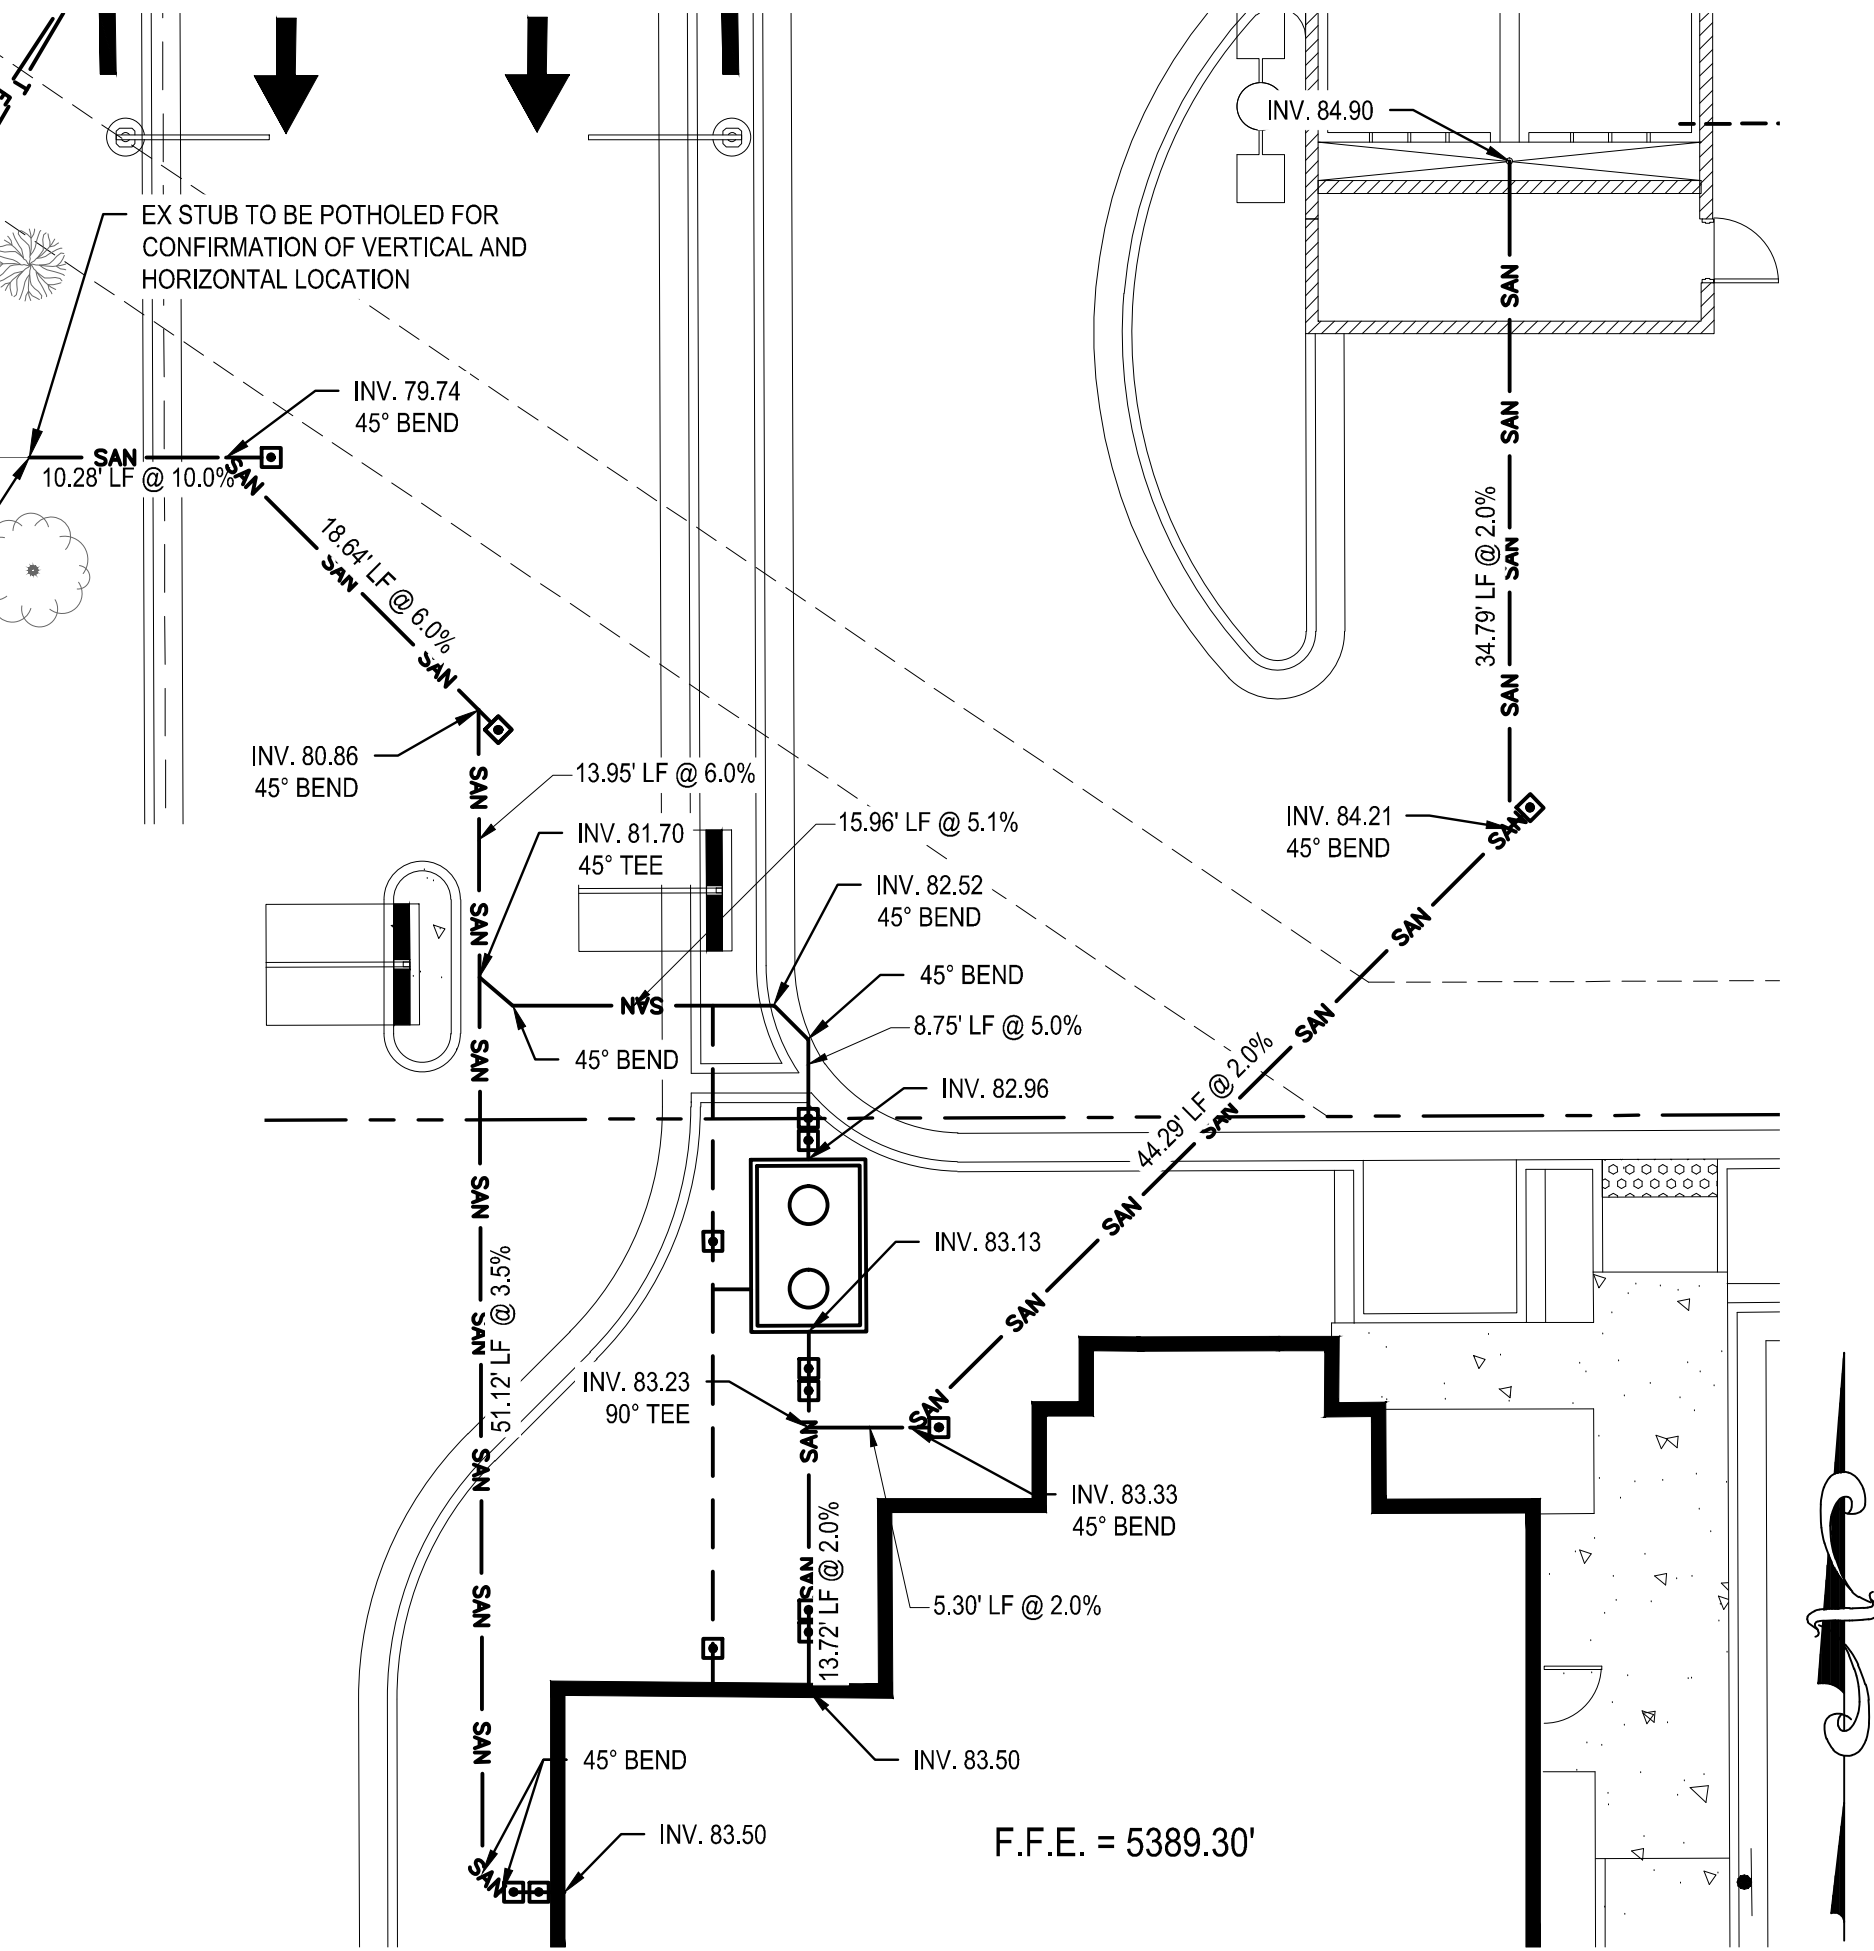

5200 Buffington Rd.
Atlanta, Georgia
30349-2998

Revisions:

Mark	Date	By
1	02/09/2015	

Mark	Date	By
△		
△		

Seal

MERRICK & COMPANY
5970 GREENWOOD PLAZA BLVD
GREENWOOD VILLAGE, CO 80111
303-751-0741

STORE
WYOMING BOULEVARD FSU
S08H-A-WC

2274 WYOMING BLVD. NE
ALBUQUERQUE, NM

SHEET TITLE

UTILITY PLAN

VERSION: H-V2
ISSUE DATE: 11-2014

Job No. : 65118374
Store : 03484
Date : 12/15/14
Drawn By : JD
Checked By: TDK

Sheet

PS-1.0