

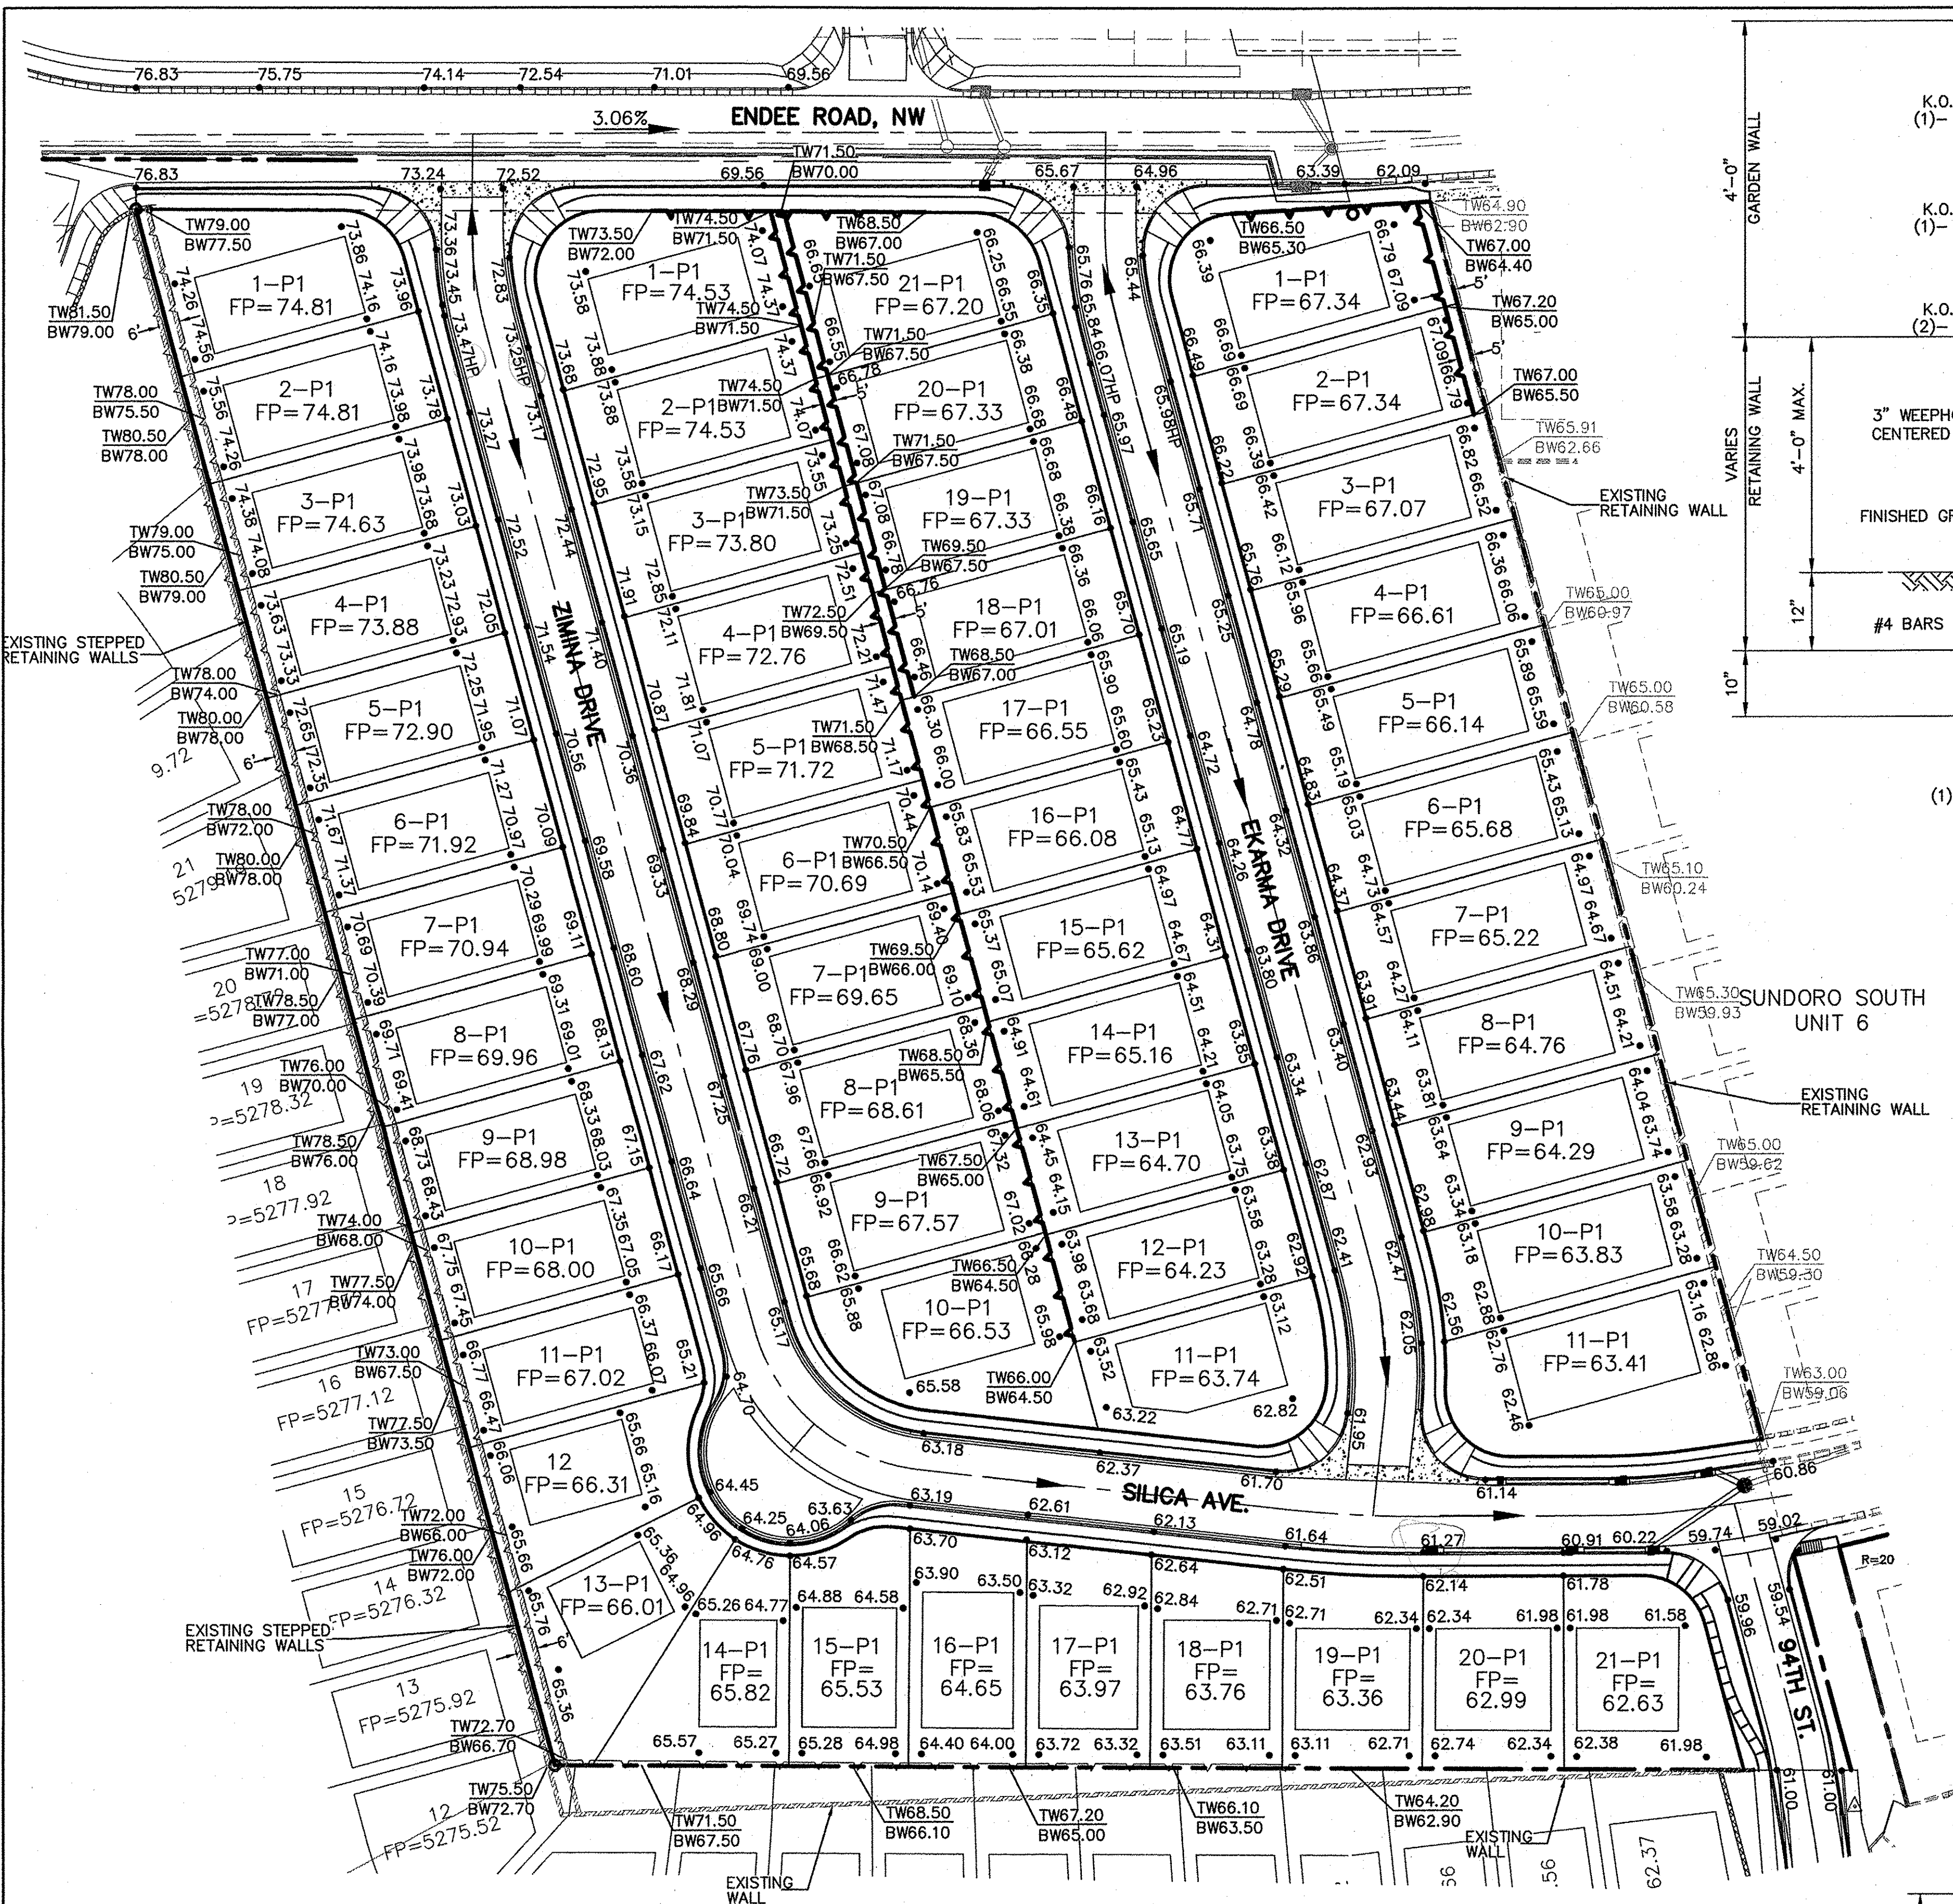
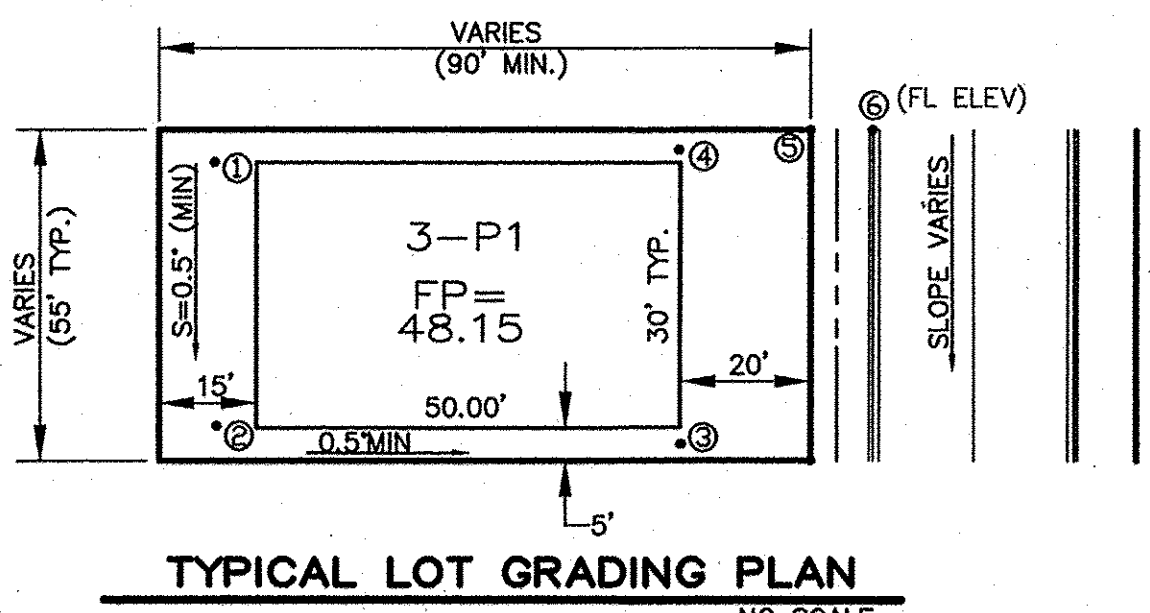


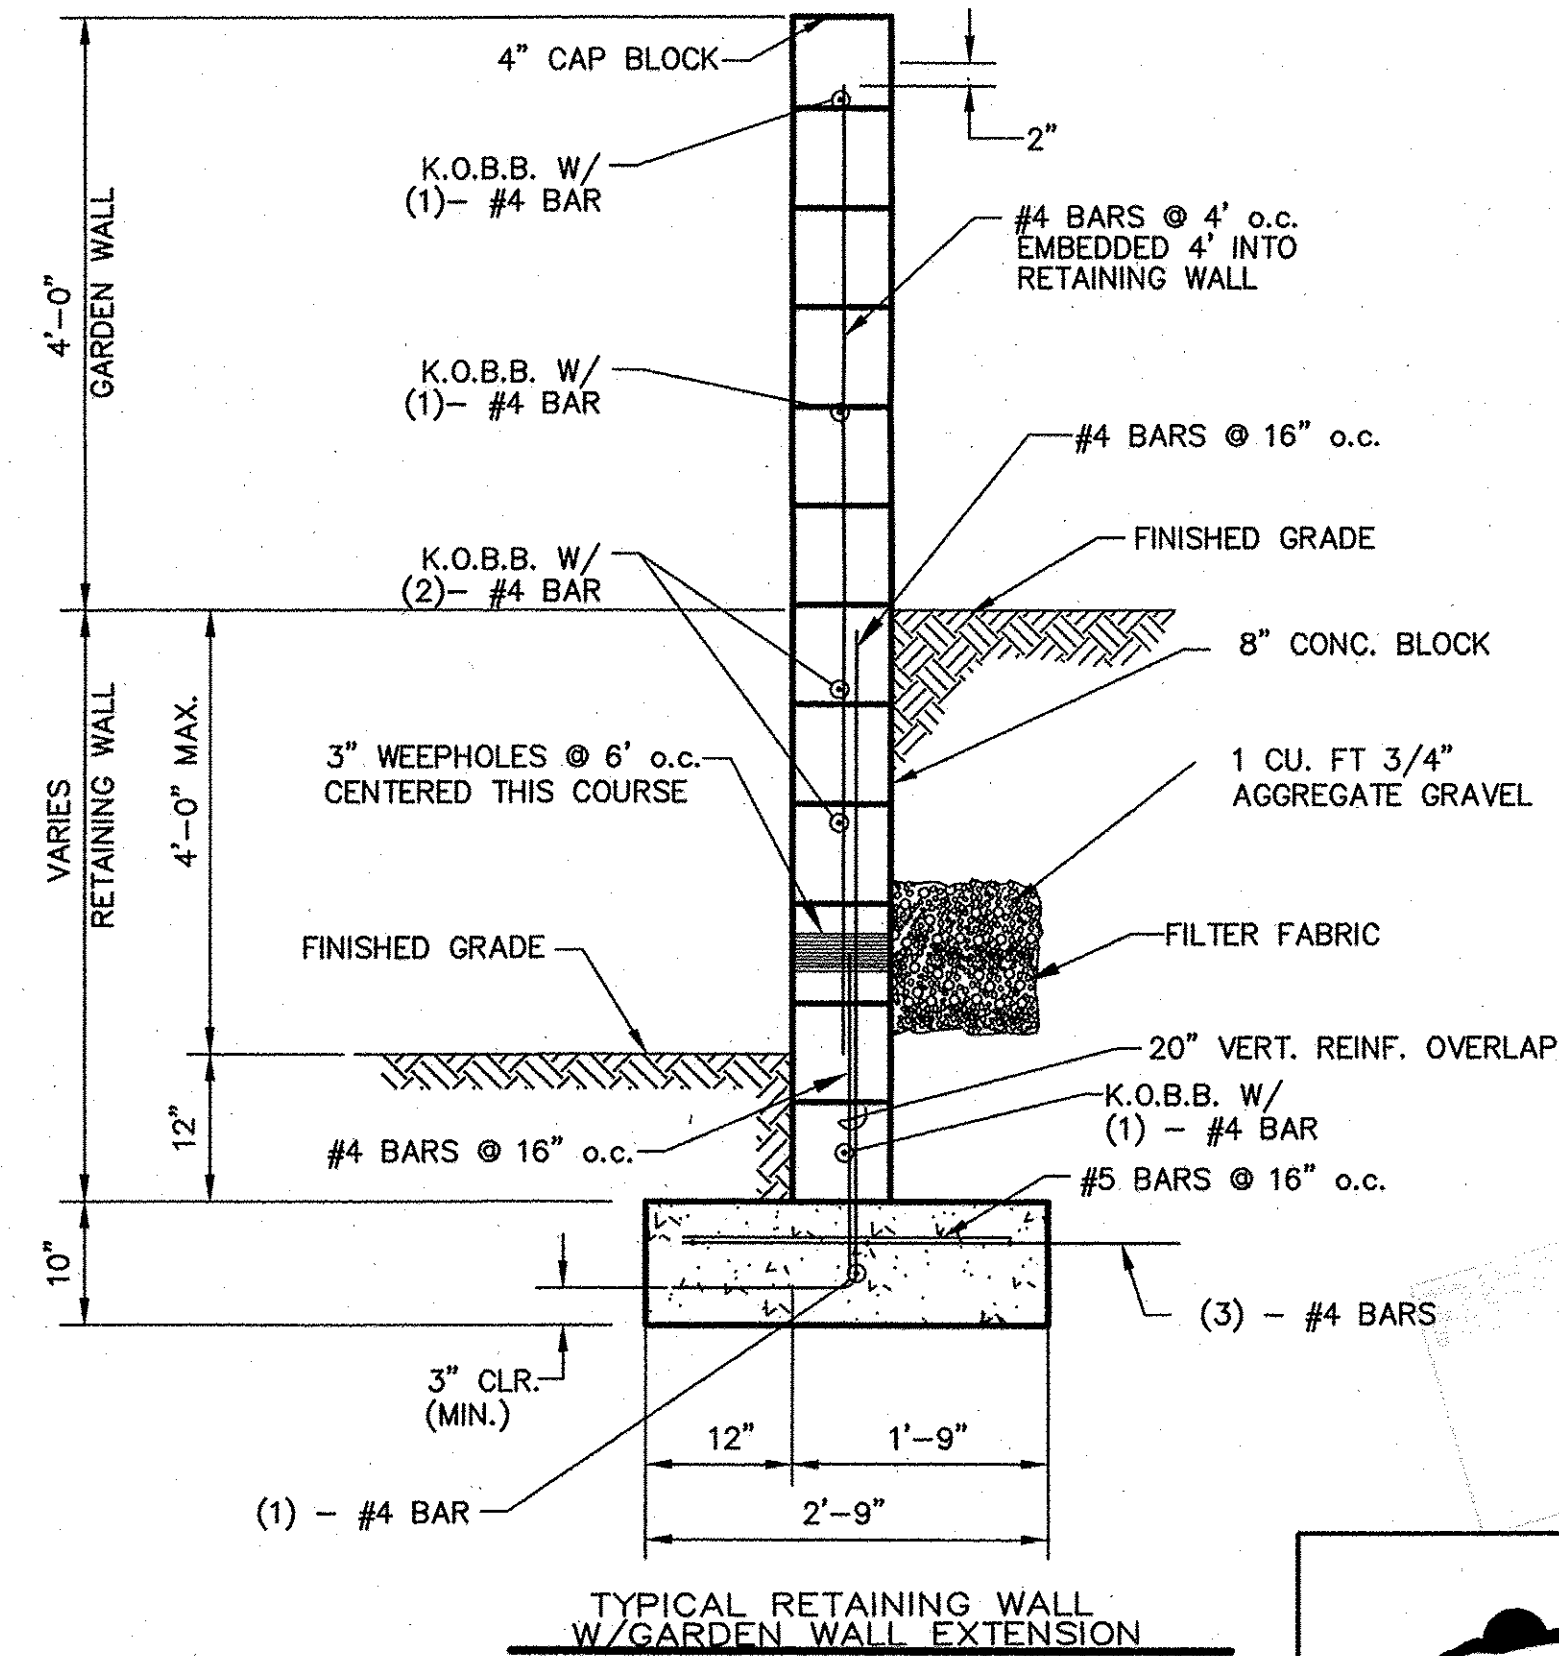


LEGEND

FP=09.07	FINISHED PAD SITE ELEVATION	●	PROPOSED MANHOLE
60.23	PROPOSED SPOT ELEVATION	—	PROPOSED STORM DRAIN
TC=12.51	TOP OF CURB AND FLOWLINE ELEVATIONS	—	PROPOSED STANDARD CURB AND GUTTER
FL=11.84		—	PROPOSED STANDARD CURB AND GUTTER
	EXISTING MAJOR CONTOUR	—	PROPOSED BASIN BOUNDARY
	EXISTING MINOR CONTOUR	—	PROPOSED INLET
	PROPOSED BASIN NUMBER	100	PROPOSED WHEEL CHAIR RAMPS
	PROPOSED RETAINING WALL		

NOTE:
THE TOTAL HEIGHT OF ANY WALL, INCLUDING RETAINING WALL, SHALL NOT EXCEED 8 FEET.

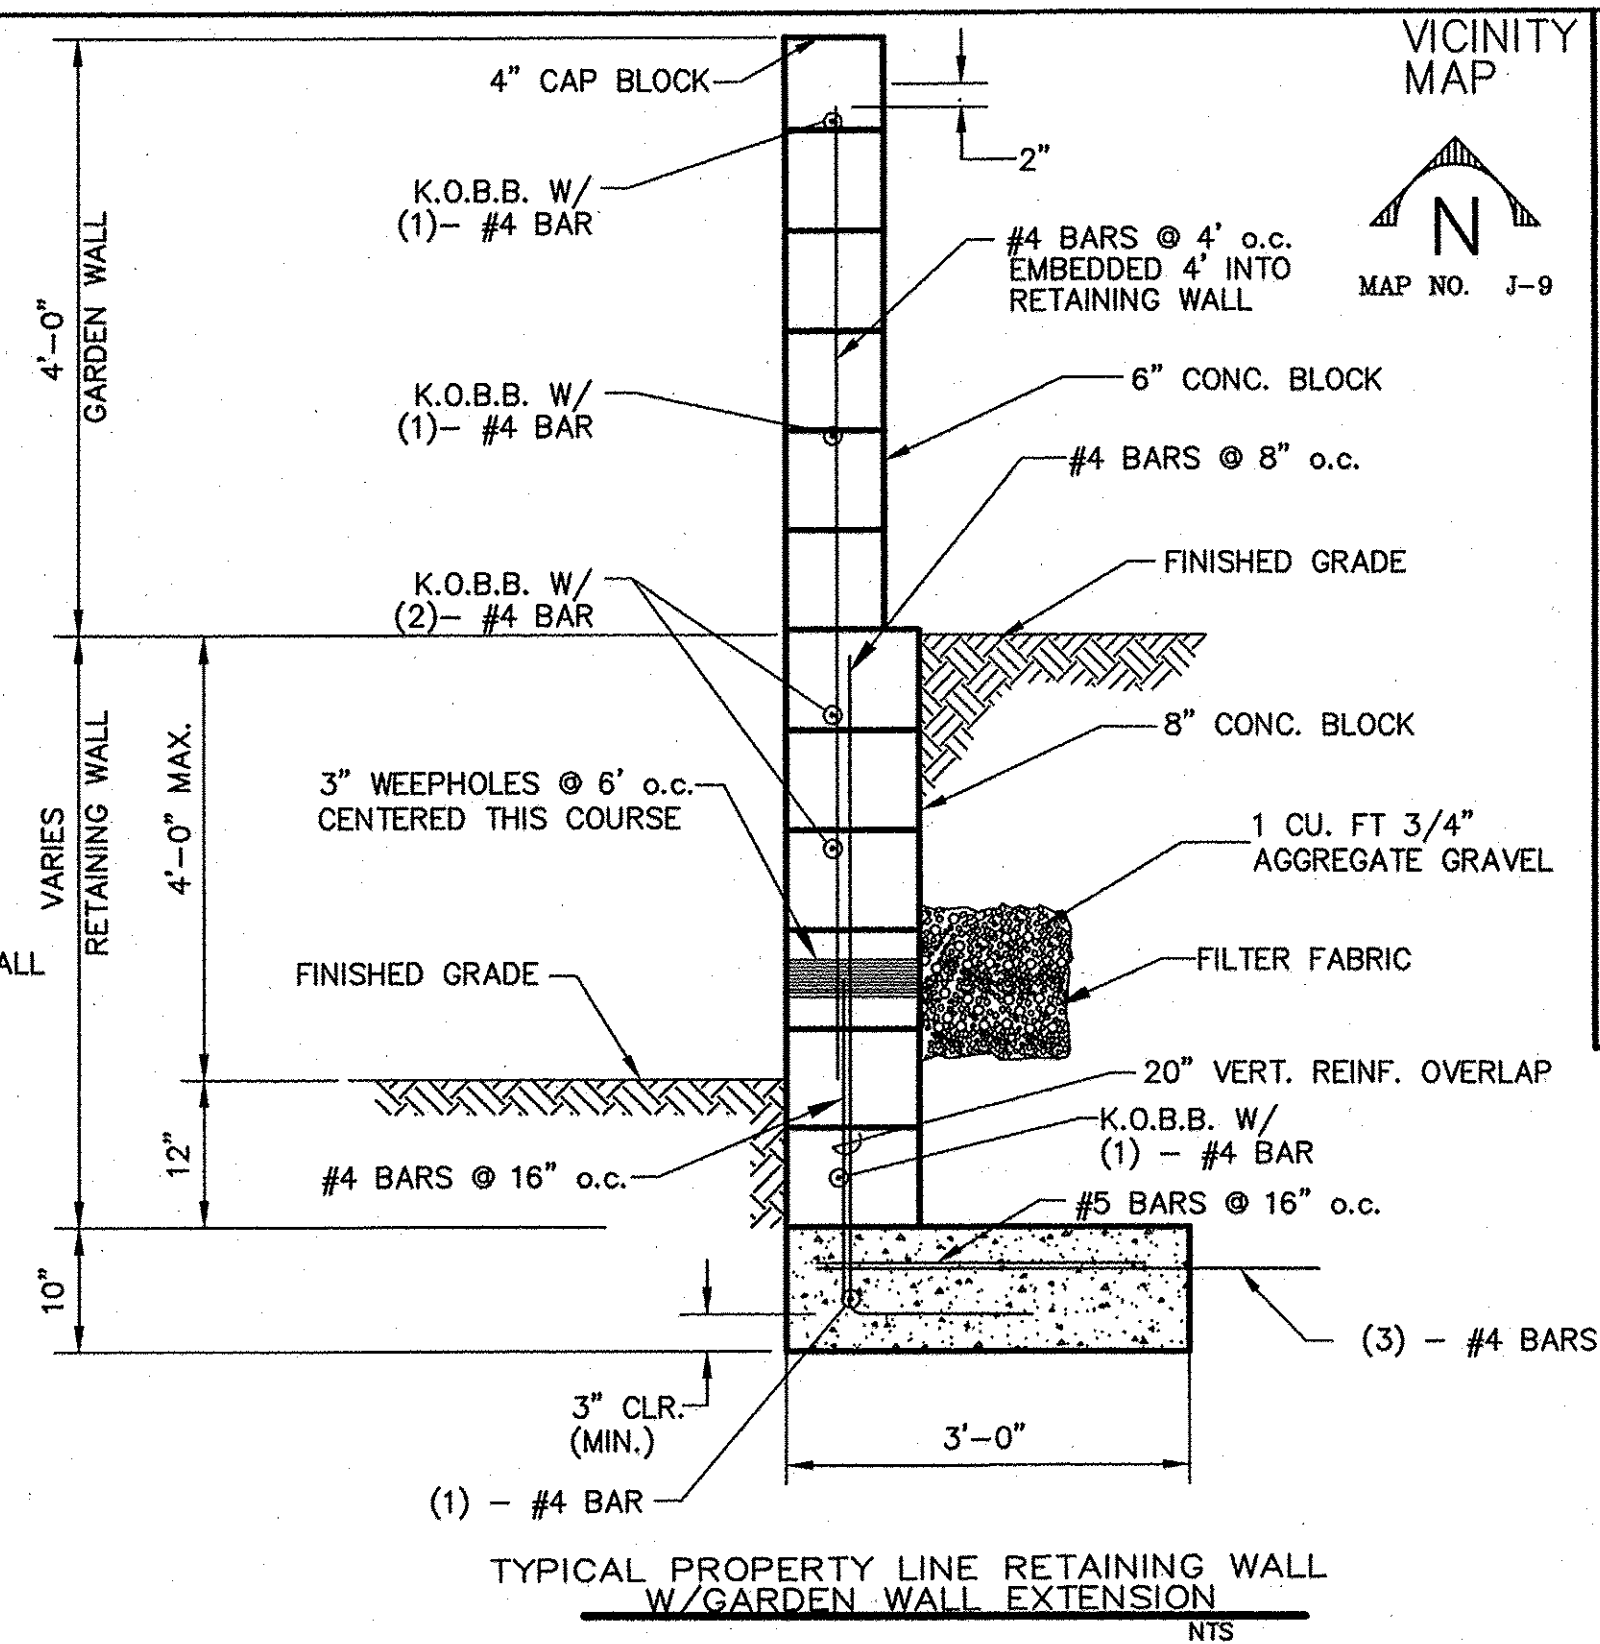

TO SET SPOT ① - SUBTRACT 0.25' FROM THE PAD ELEV.
TO SET SPOT ② - SUBTRACT 0.2' FROM SPOT ①
TO SET SPOTS ③ & ④ - SUBTRACT 0.4' FROM SPOTS ② & ① RESPECTIVELY
TO SET SPOT ⑤ - MULTIPLY D1 BY 2.0%, ADD CURB HEIGHT, AND ADD TO SPOT

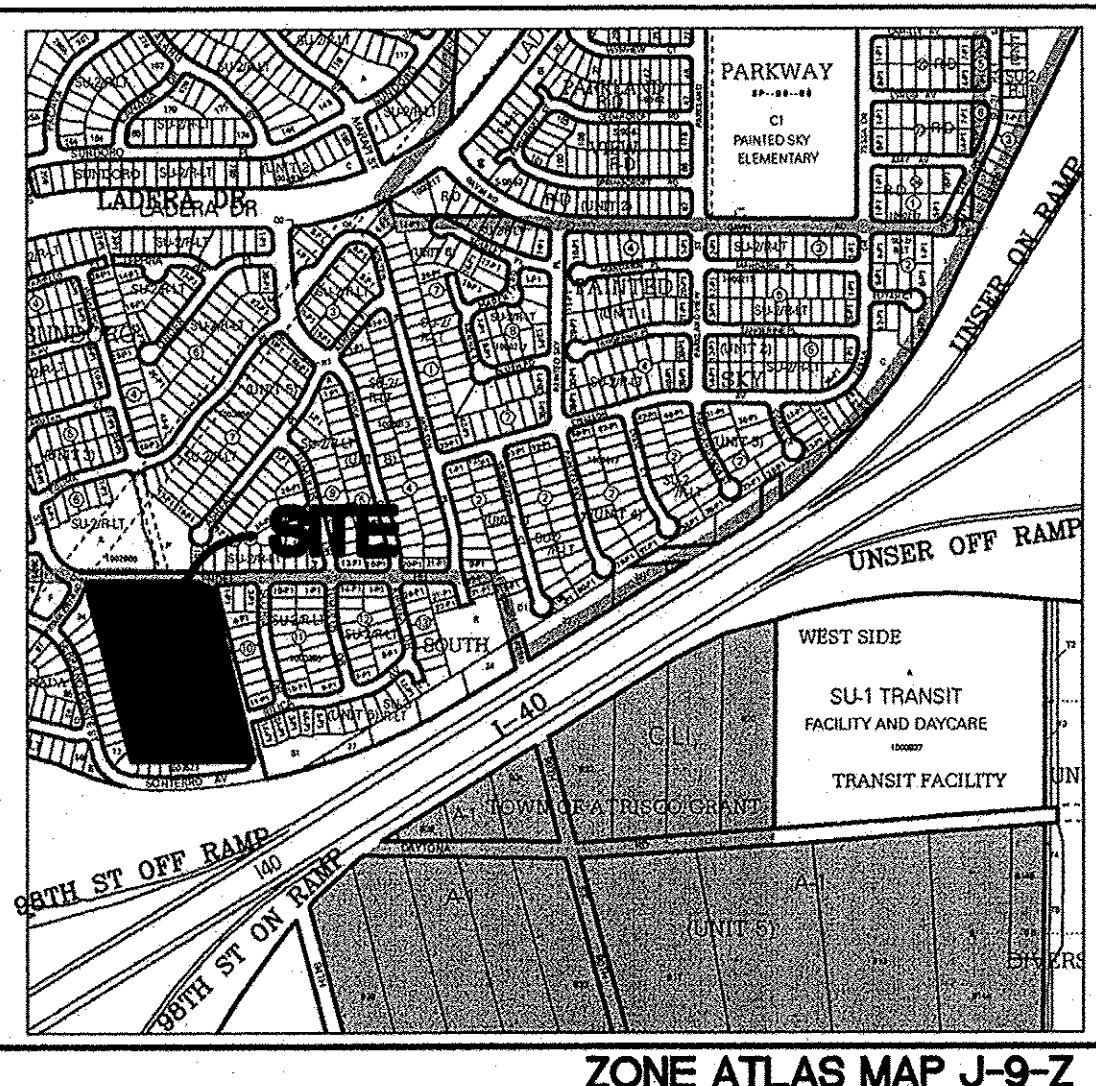



Thompson Engineering Consultants, Inc.
P.O. BOX 65760
ALBUQUERQUE, NM 87193
PHONE: (505) 271-2199
FAX: (505) 830-9428
tccrnm@yahoo.com

**CITY OF ALBUQUERQUE
PUBLIC WORKS DEPARTMENT
TRANSPORTATION DEVELOPMENT**

DESIGN REVIEW COMMITTEE		CITY ENGINEER APPROVAL		MO./DAY/YR.		MO./DAY/YR.	
City Project No. 7270.80				Zone Map No. J-9-Z		SHEET 3 OF 12	

AS BUILT INFORMATION		BENCH MARKS		SURVEY INFORMATION		ENGINEER'S SEAL	
CONTRACTOR	NGS MONUMENT "REWARD"	NO.	DATE	NO.	DATE	NO.	DATE
DATE	x = 350994.85						
DATE	y = 1487301.42						
DATE	Ground to Grid Factor:						
DATE	0.99967114						
DATE	Δα = -00' 17" 11"						
DATE	NMSP CENTRAL ZONE						
DATE	NAD 1927						
DATE	ELEVATION=5316.95 (NGVD 29)						

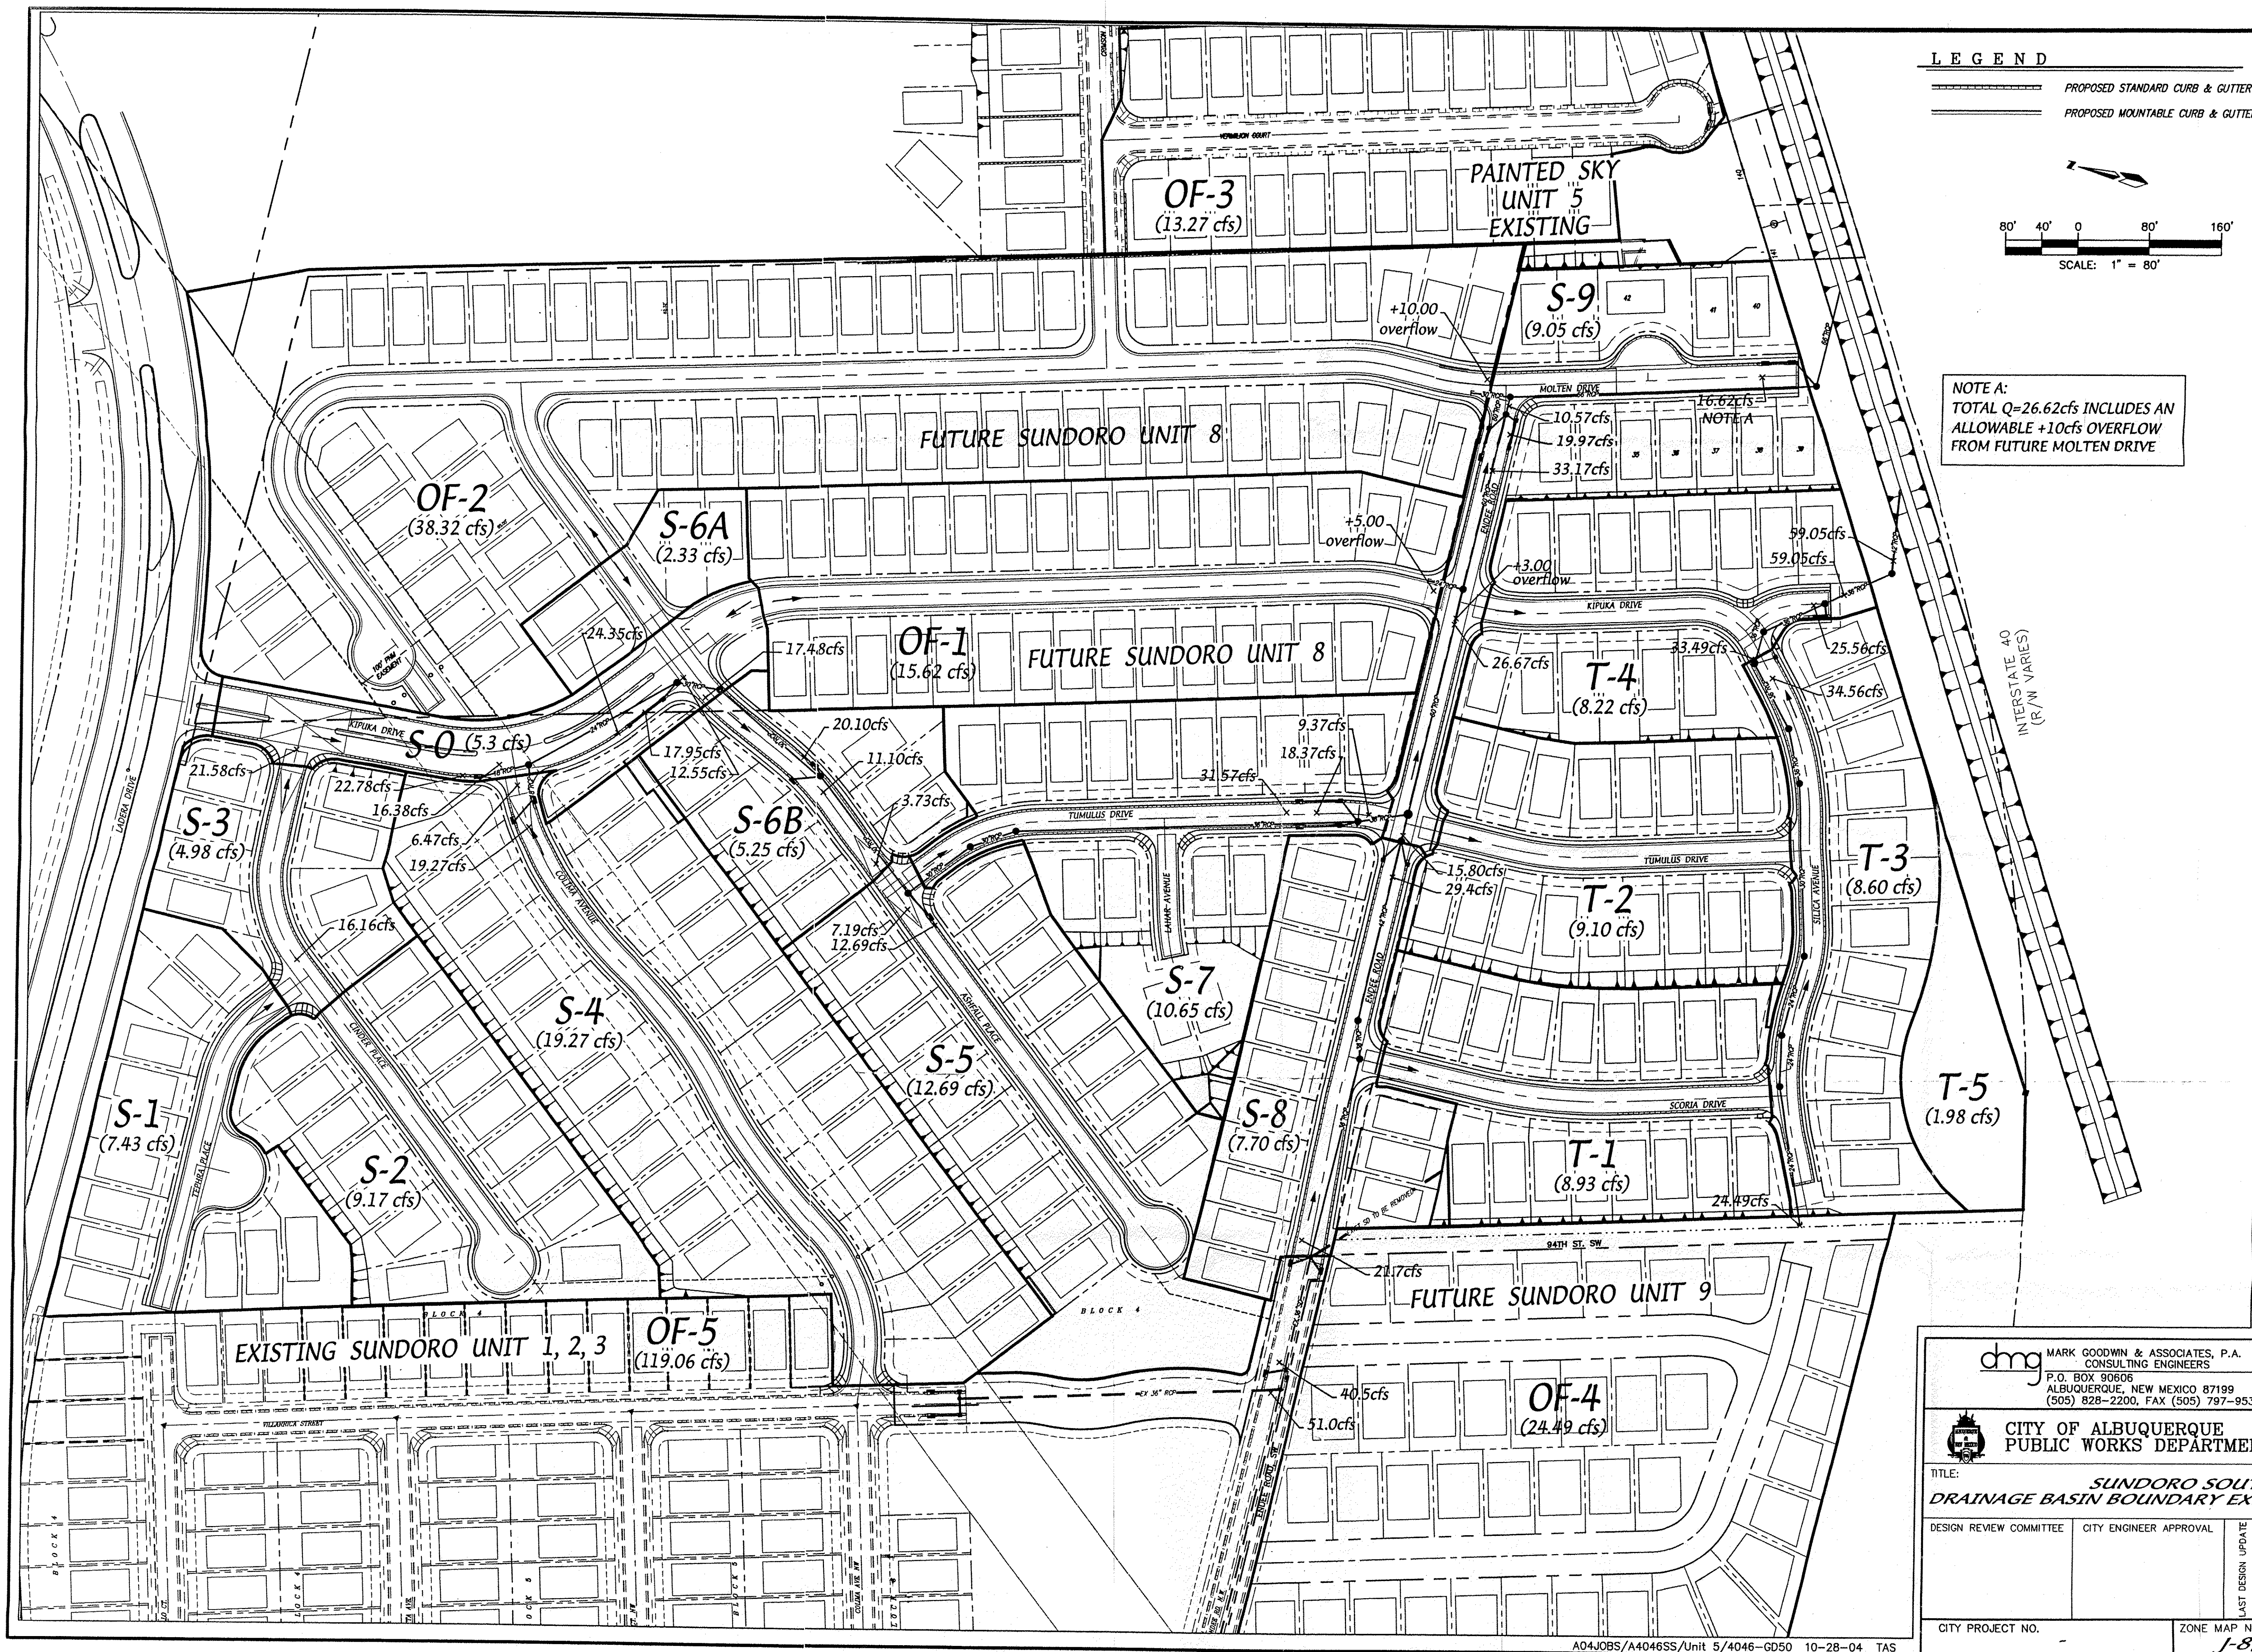[illegible]

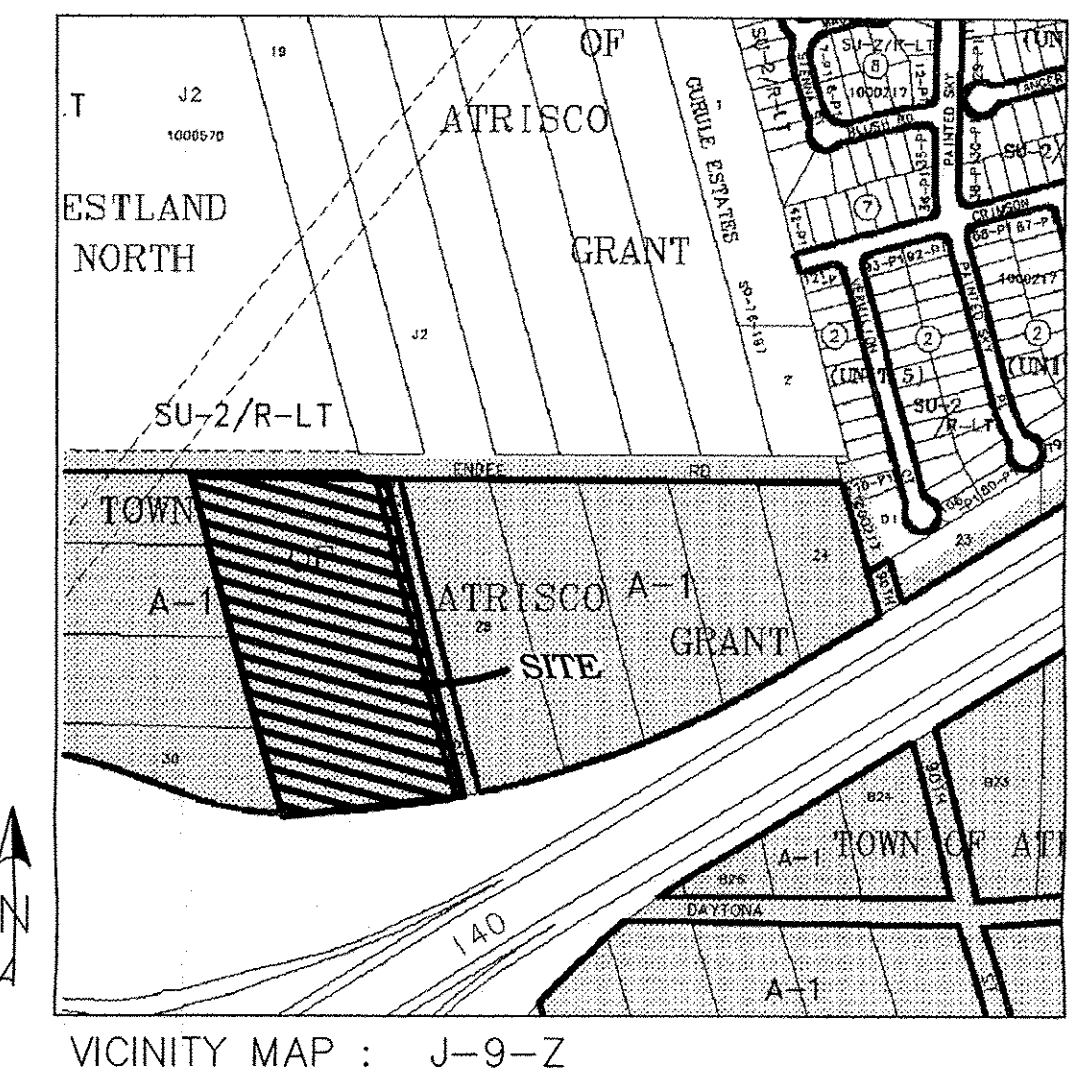

- LEGEND**
- PROPOSED 6" SD MANHOLE
 - PROPOSED RCP STORM DRAIN
 - PROPOSED STANDARD CURB AND GUTTER
 - PROPOSED MOUNTABLE CURB AND GUTTER
 - PROPOSED WHEEL CHAIR RAMPS
 - PROPOSED BASIN BOUNDARY
 - TYPE 'C' INLET (SINGLE)
 - PROPOSED RETAINING WALL
 - PROPOSED BASIN NUMBER
 - PROPOSED FLOW ARROW

NGS MONUMENT "REWARD"
 x = 250994.85
 y = 1487301.42
 Ground to Grid Factor:
 0.99967114
 Δa = -00° 17' 11"
 NAD83 CENTRAL ZONE
 NAD 1927

SCALE: 1"=40'

Thompson Engineering Consultants, Inc.
 tecm@yahoo.com
 P.O. BOX 65760 ALBUQUERQUE, NM 87193
 PHONE: (505) 271-2199 FAX: (505) 830-9428

**CITY OF ALBUQUERQUE
 PUBLIC WORKS DEPARTMENT
 TRANSPORTATION DEVELOPMENT**

**SUNDORO UNIT 9
 DRAINAGE PLAN**

DESIGN REVIEW COMMITTEE	CITY ENGINEER APPROVAL	MO./DAY/YR.	MO./DAY/YR.

City Project No. XXXX	Zone Map No. J-9-Z	PLATE 2
-----------------------	--------------------	---------

AS BUILT INFORMATION		BENCH MARKS		SURVEY INFORMATION		ENGINEER'S SEAL		REMARKS		DESIGN		NO. DATE		BY		DESIGNED BY DBT		DRAWN BY DEM		CHECKED BY DBT		DATE		DATE		DATE		DATE	
CONTRACTOR	WORK	DATE	INSPECTOR'S	DATE	ACCEPTANCE BY	DATE	VERIFICATION BY	DATE	DRAWING	DATE	NO.	DATE	BY	DATE	DESIGNED BY DBT	DATE	DRAWN BY DEM	DATE	CHECKED BY DBT	DATE	DATE	DATE	DATE	DATE	DATE	DATE	DATE	DATE	DATE