


TYPICAL SECTION
PONDING AREA

LEGEND
 O FINISH GRADE SPOT ELEVATION
 — 60 — FINISH GRADE CONTOUR
 - - - - - EXISTING GRADE CONTOUR

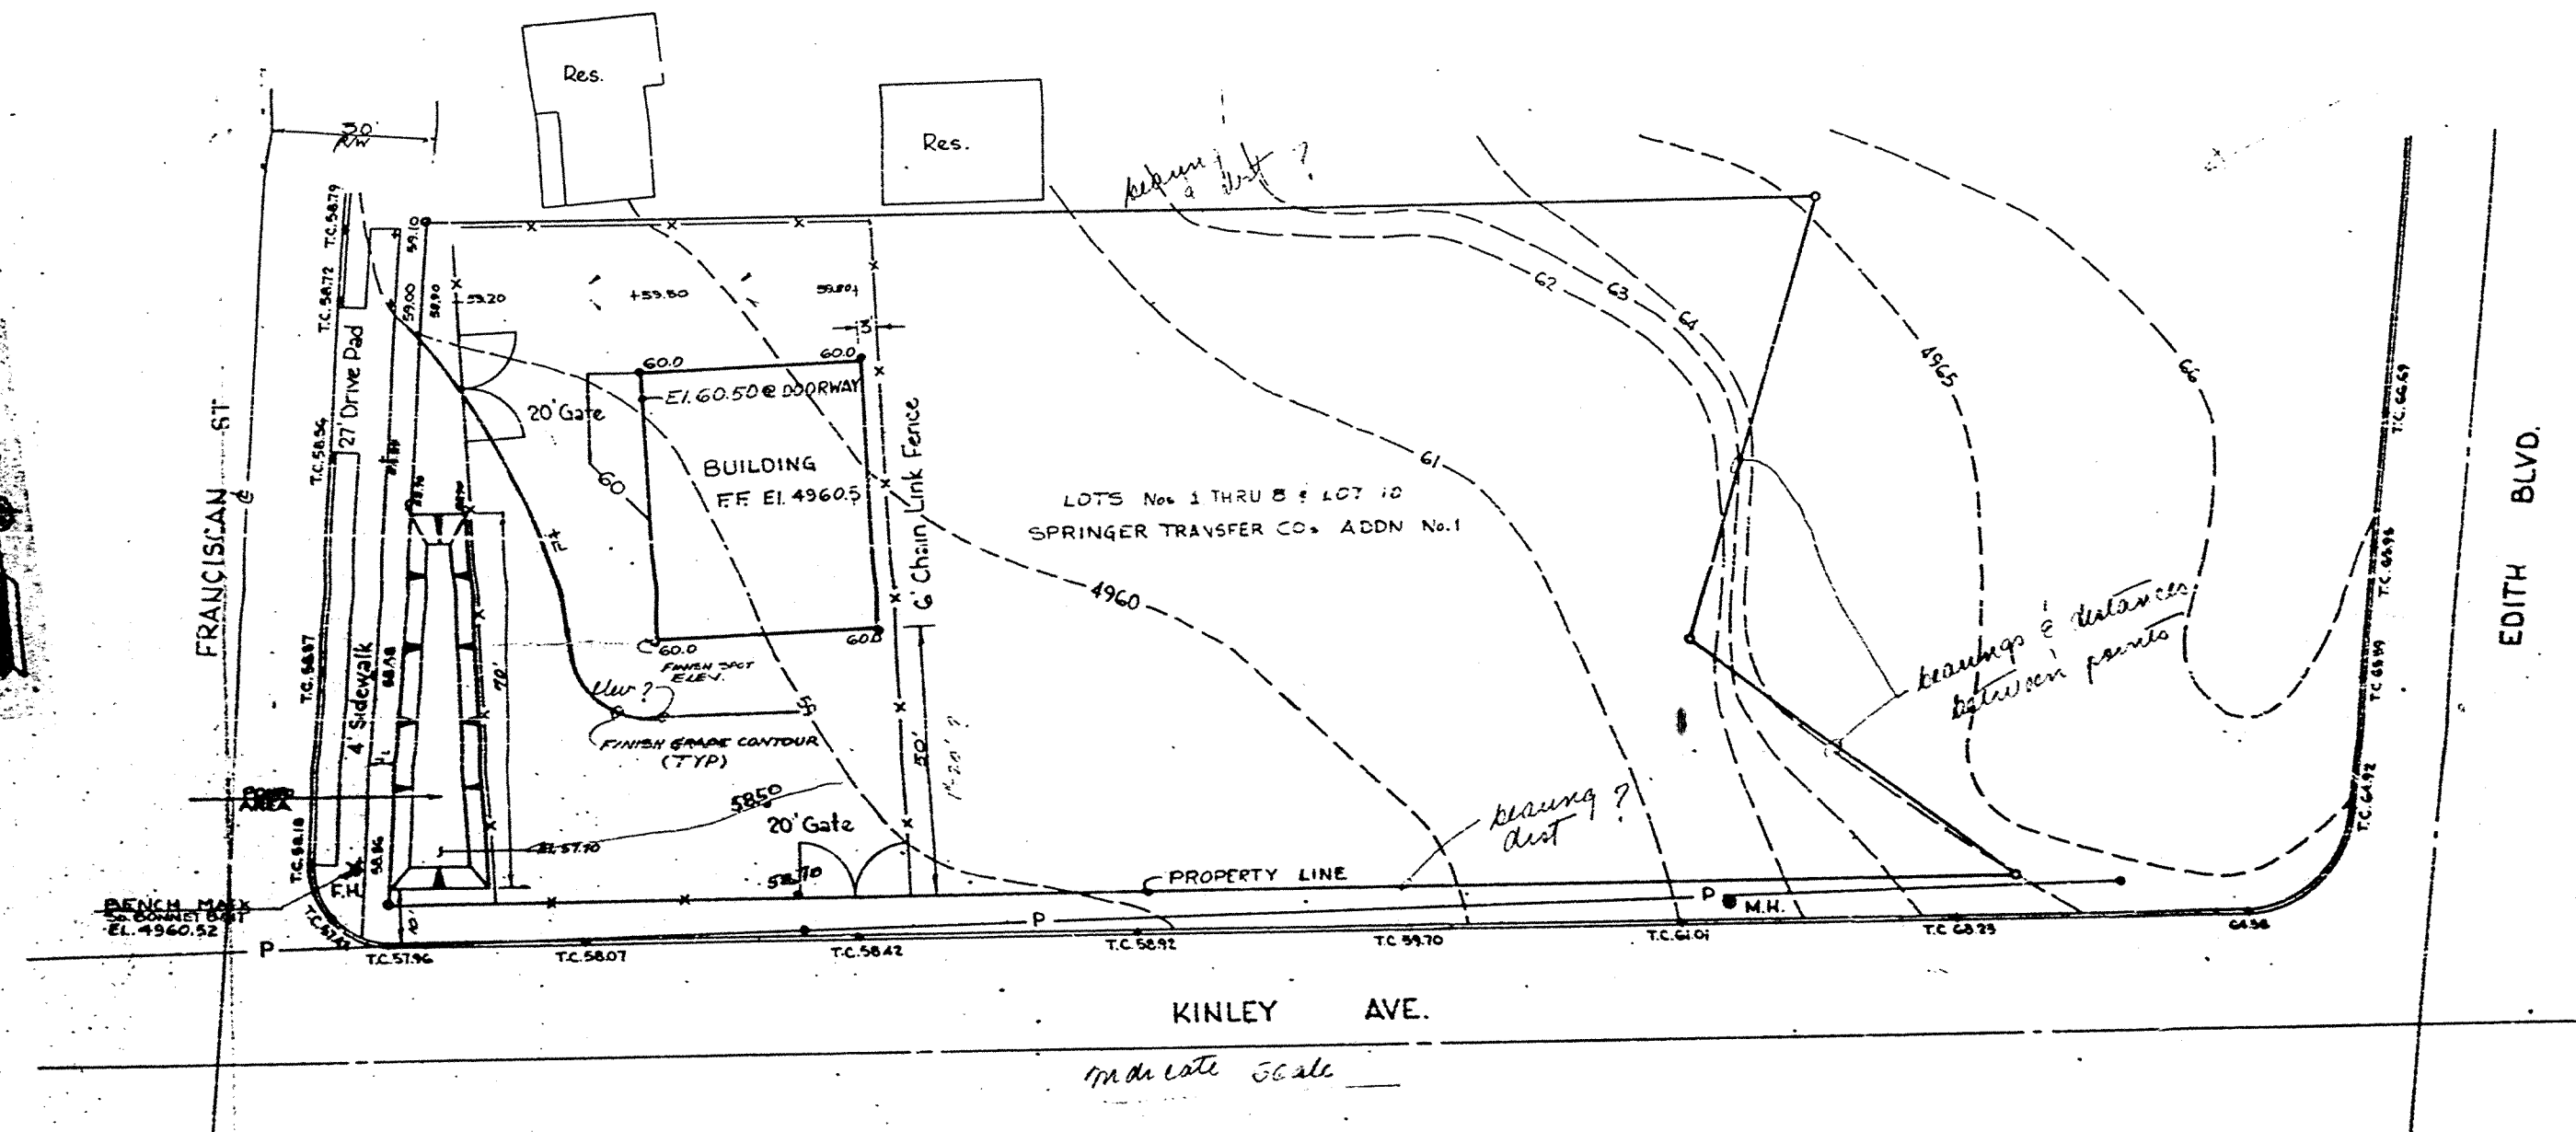

INDUSTRIAL ELECTRICAL EQUIPT.				SHEET OF
GRADING AND DRAINAGE PLAN				
ASSBURY & ASSOCIATES CONSULTING ENGINEERS ALBUQUERQUE, NEW MEXICO				
OWNER'S FILE NO. 77-117	DRAWN: D.P. TRACED: D.P.	CHECKED: J.T.A. APPROVED: J.T.A.	DATE: 7/77 SCALE: 1" = 20'	