

DRAINAGE PLAN



TRACT 1-F, BLOCK 2, SPRINGER TRANSFER COMPANY ADDITION #1 (N-81-8)

ALBUQUERQUE, NEW MEXICO

ZONE MAP J-14 ZONED M-1 1970 FLOOD PANEL 28

TOTAL AREA: 0.69 ACRES (29,825 S.F.) ALL ROOFED OR PAVED - SEE FILE J14-D9

BENCHMARK 7-315 ELEV. 4974.74

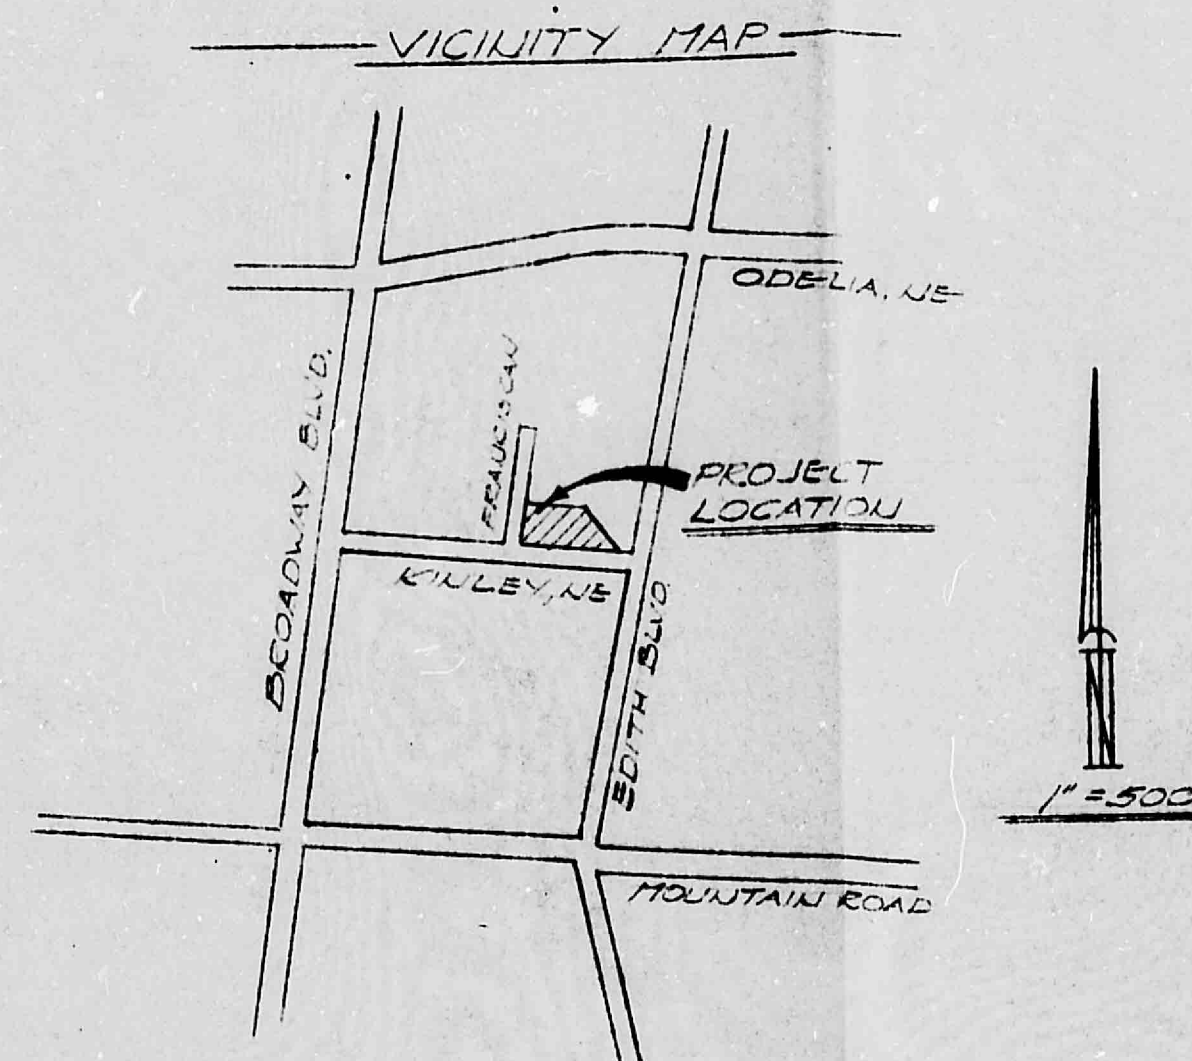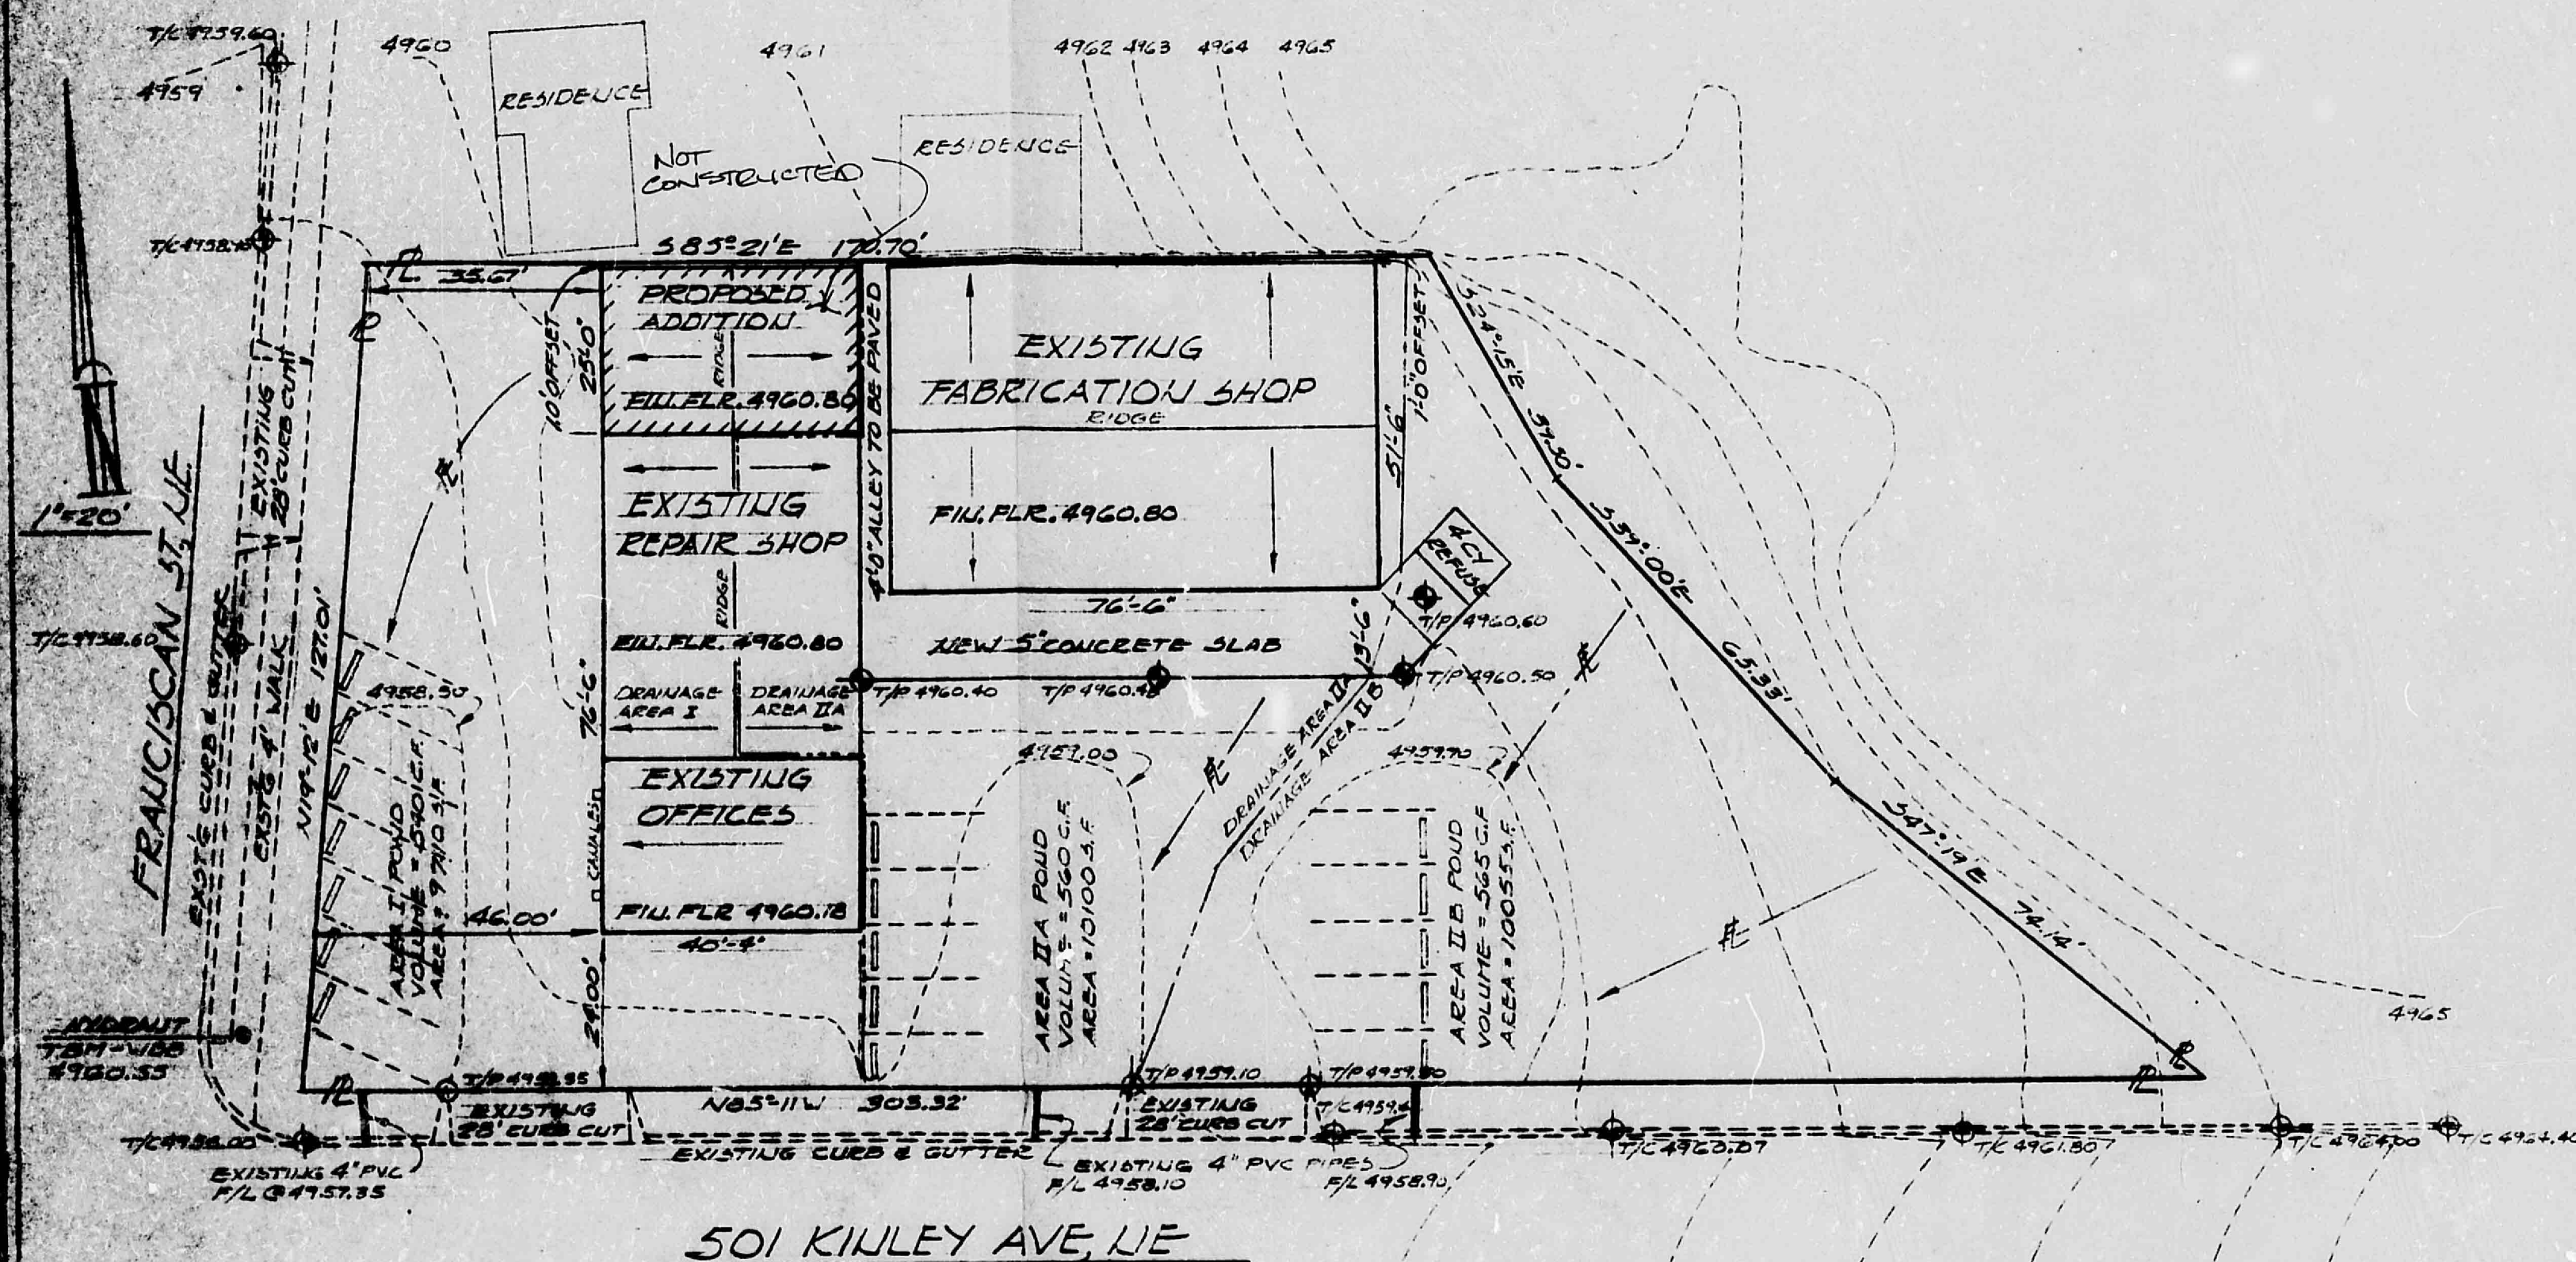

HYDROLOGY NOTES:

THIS PLAN IS ESSENTIALLY IDENTICAL TO THAT APPROVED JAN. 7, 1982. TO MAINTAIN DRAINAGE AREA I AS PLANNED, THE ADDITION WILL REQUIRE A GUTTER AT THE EAST EAVE, WITH A DOWNSPOUT AT THE NORTH END, DIRECTED TO THE WEST. SMALL CHANGES IN AREAS IIA & IIB ARE DUE TO THE RELOCATION OF THE REFUSE ENCLOSURE.

LEGEND:

- PROPERTY LINE ————
- EXISTING CONTOUR ————
- DRAINAGE AREA BOUNDARY ————
- EXISTING CURB & WALK ————
- FLOW DIRECTION ————
- EXISTING SPOT ELEVATION ⊕
- PROPOSED SPOT ELEVATION ⊕

RECEIVED
JUN 06 1984
HYDROLOGY SECTION

APPROVED FOR DRAINAGE

7/20/84

Billy J. Donahy

SIGNATURE

ADVISE DRAINAGE INSPECTOR


WHEN GRADING EXECUTED






DRAINAGE PLAN - SHEET 1 OF 1
REPAIR SHOP ADDITION-INDUSTRIAL ELECTRIC
501 KILLEY AVE., NE. D.L. 6-5-84

CITY OF ALBUQUERQUE
THIS MICROFILM IS THE BEST
POSSIBLE REPRODUCTION DUE
TO THE POOR QUALITY OF THE
ORIGINAL DOCUMENT

CITY OF ALBUQUERQUE

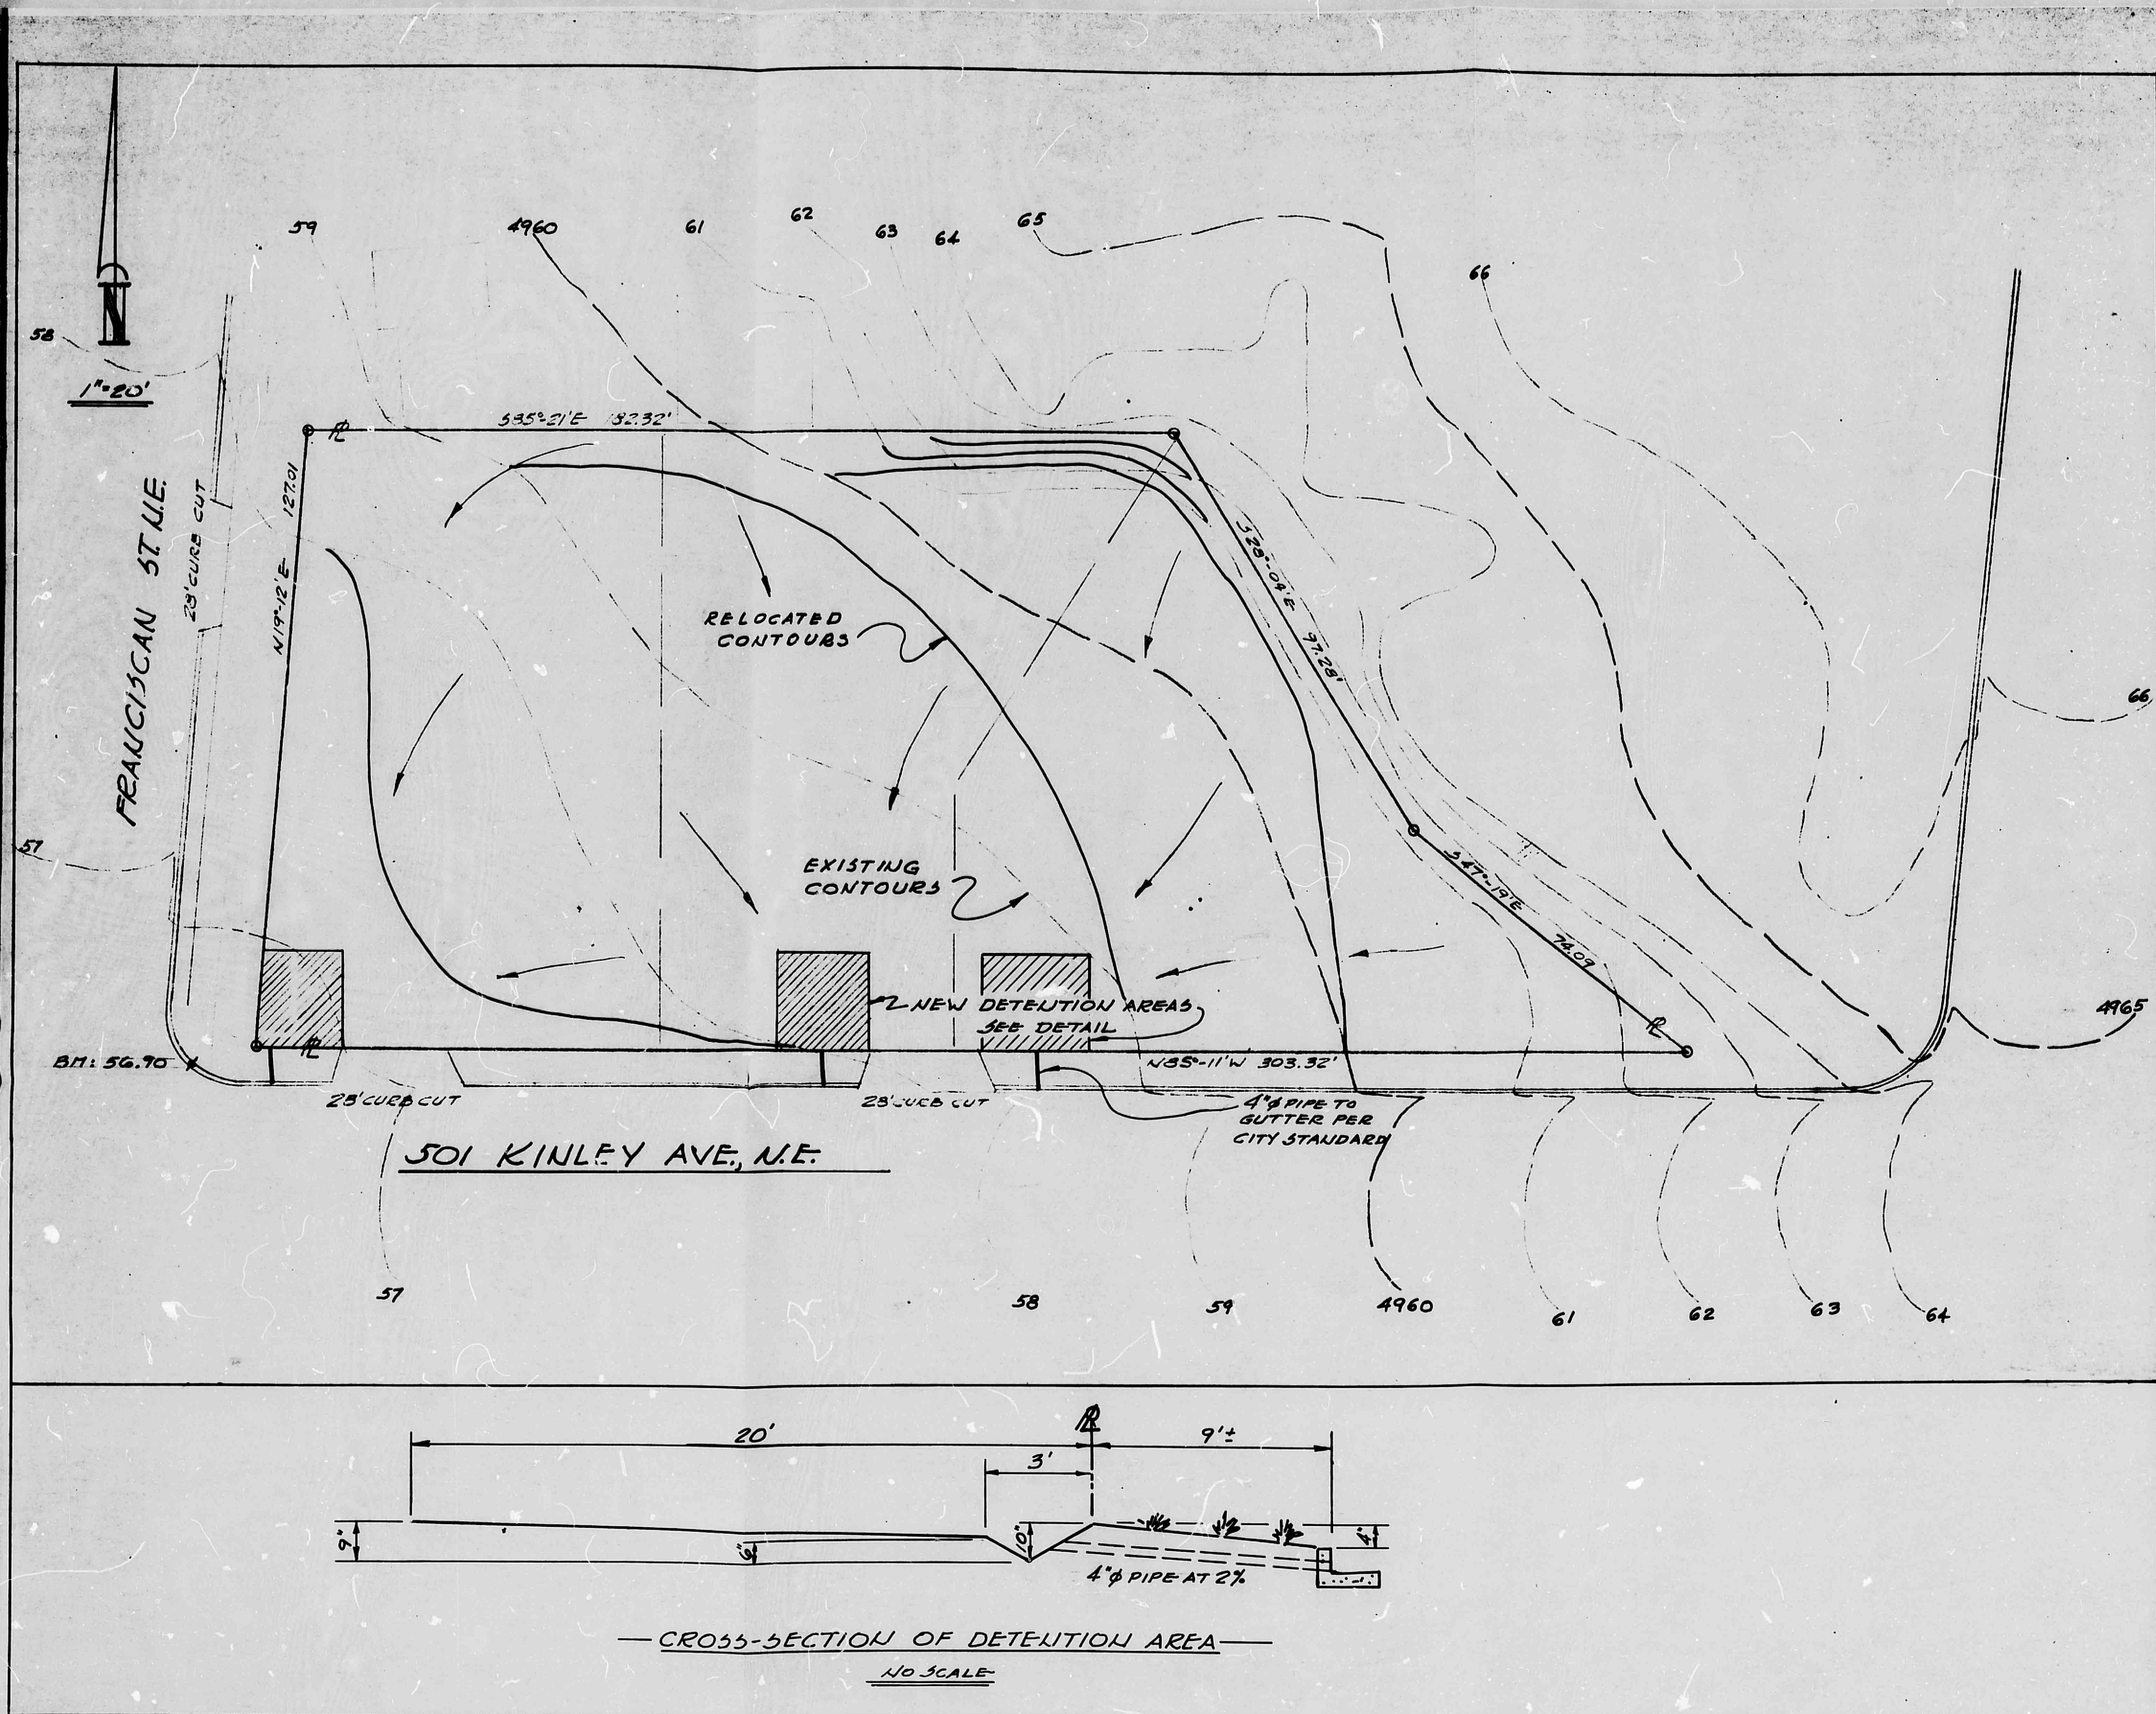

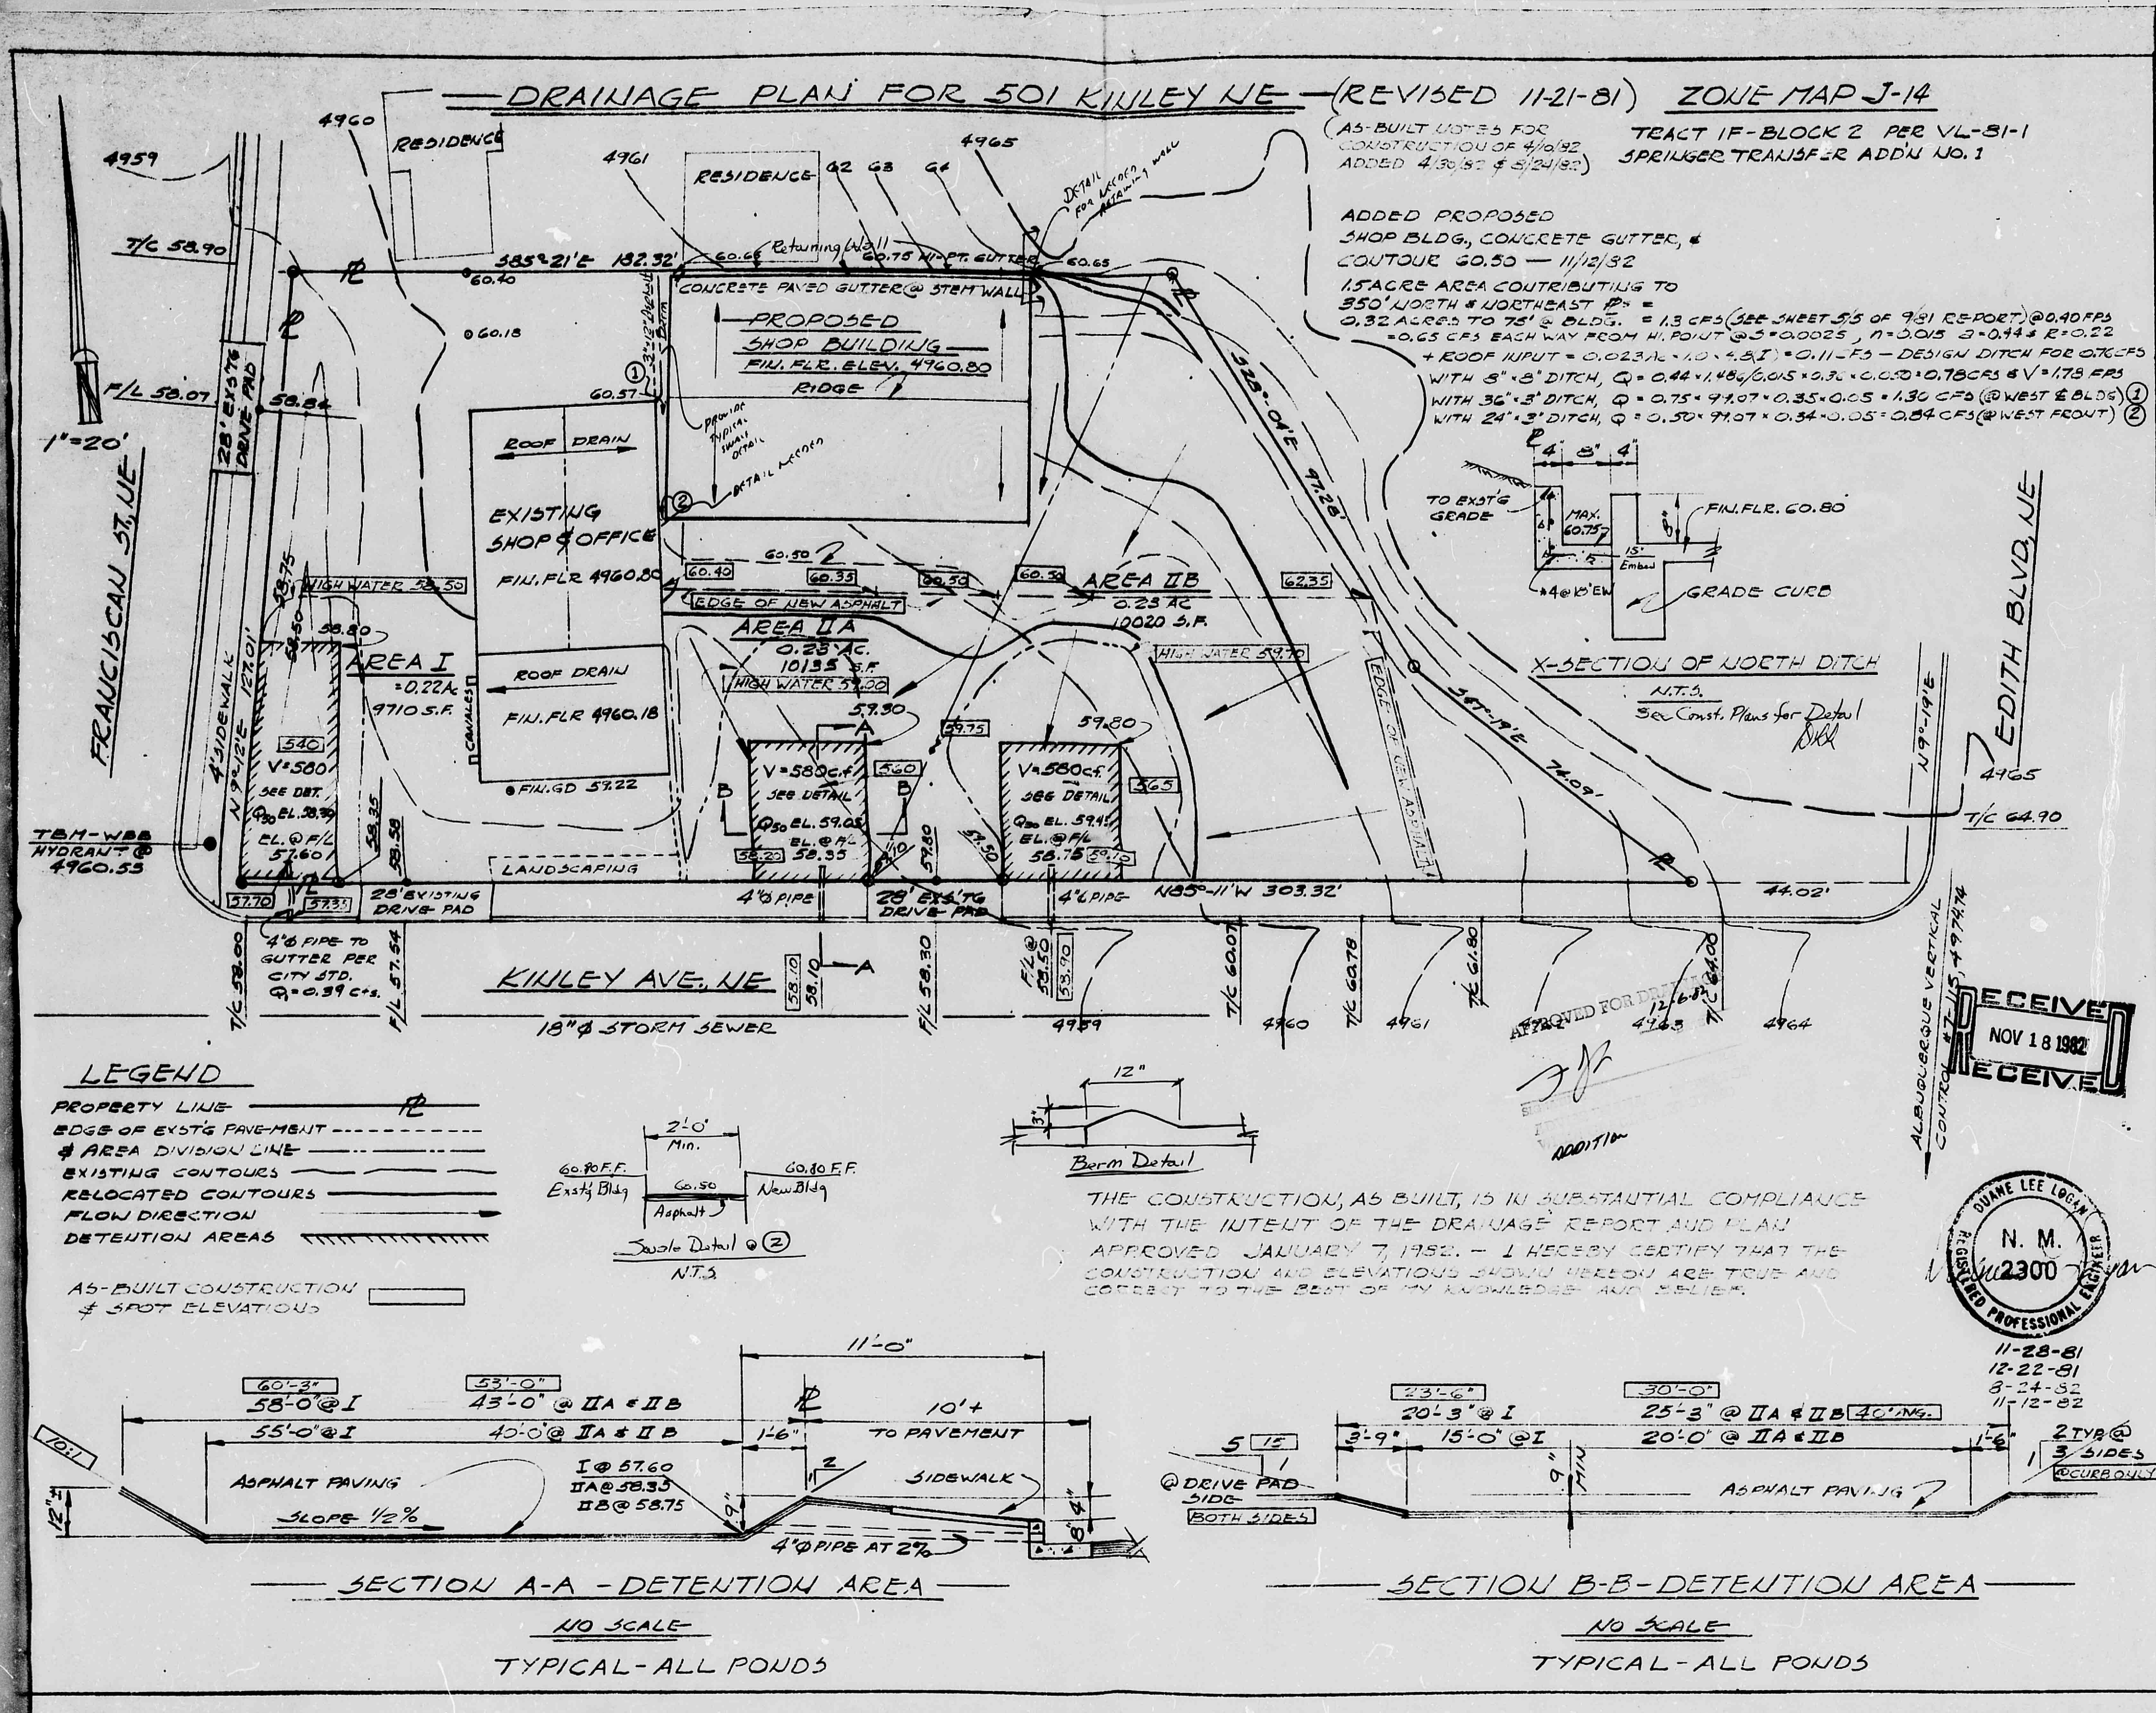

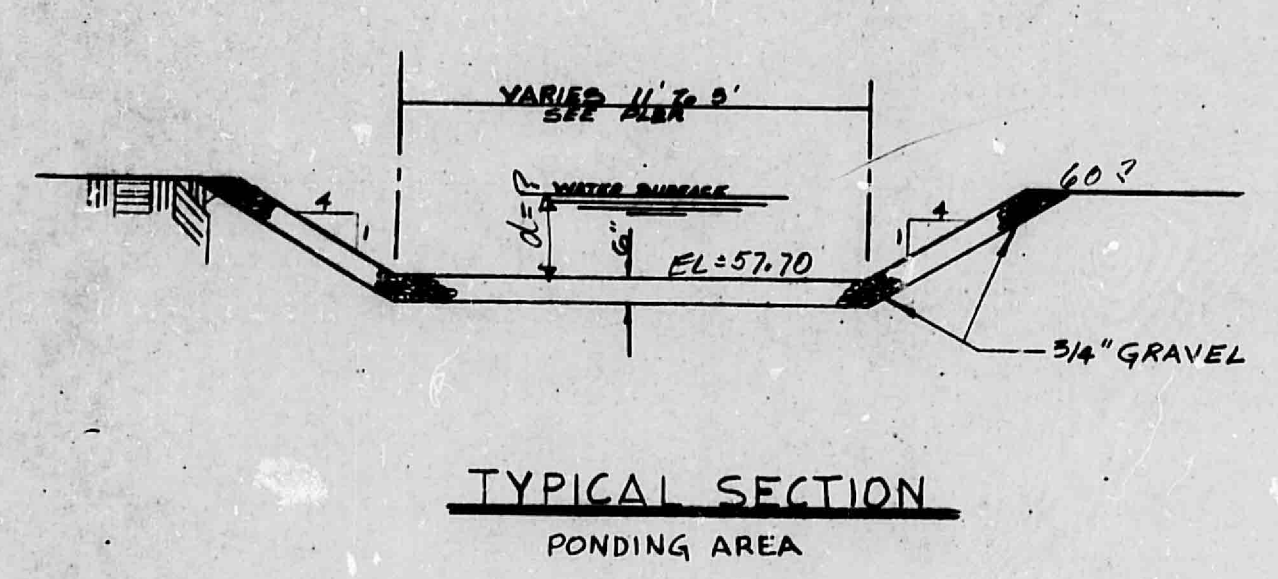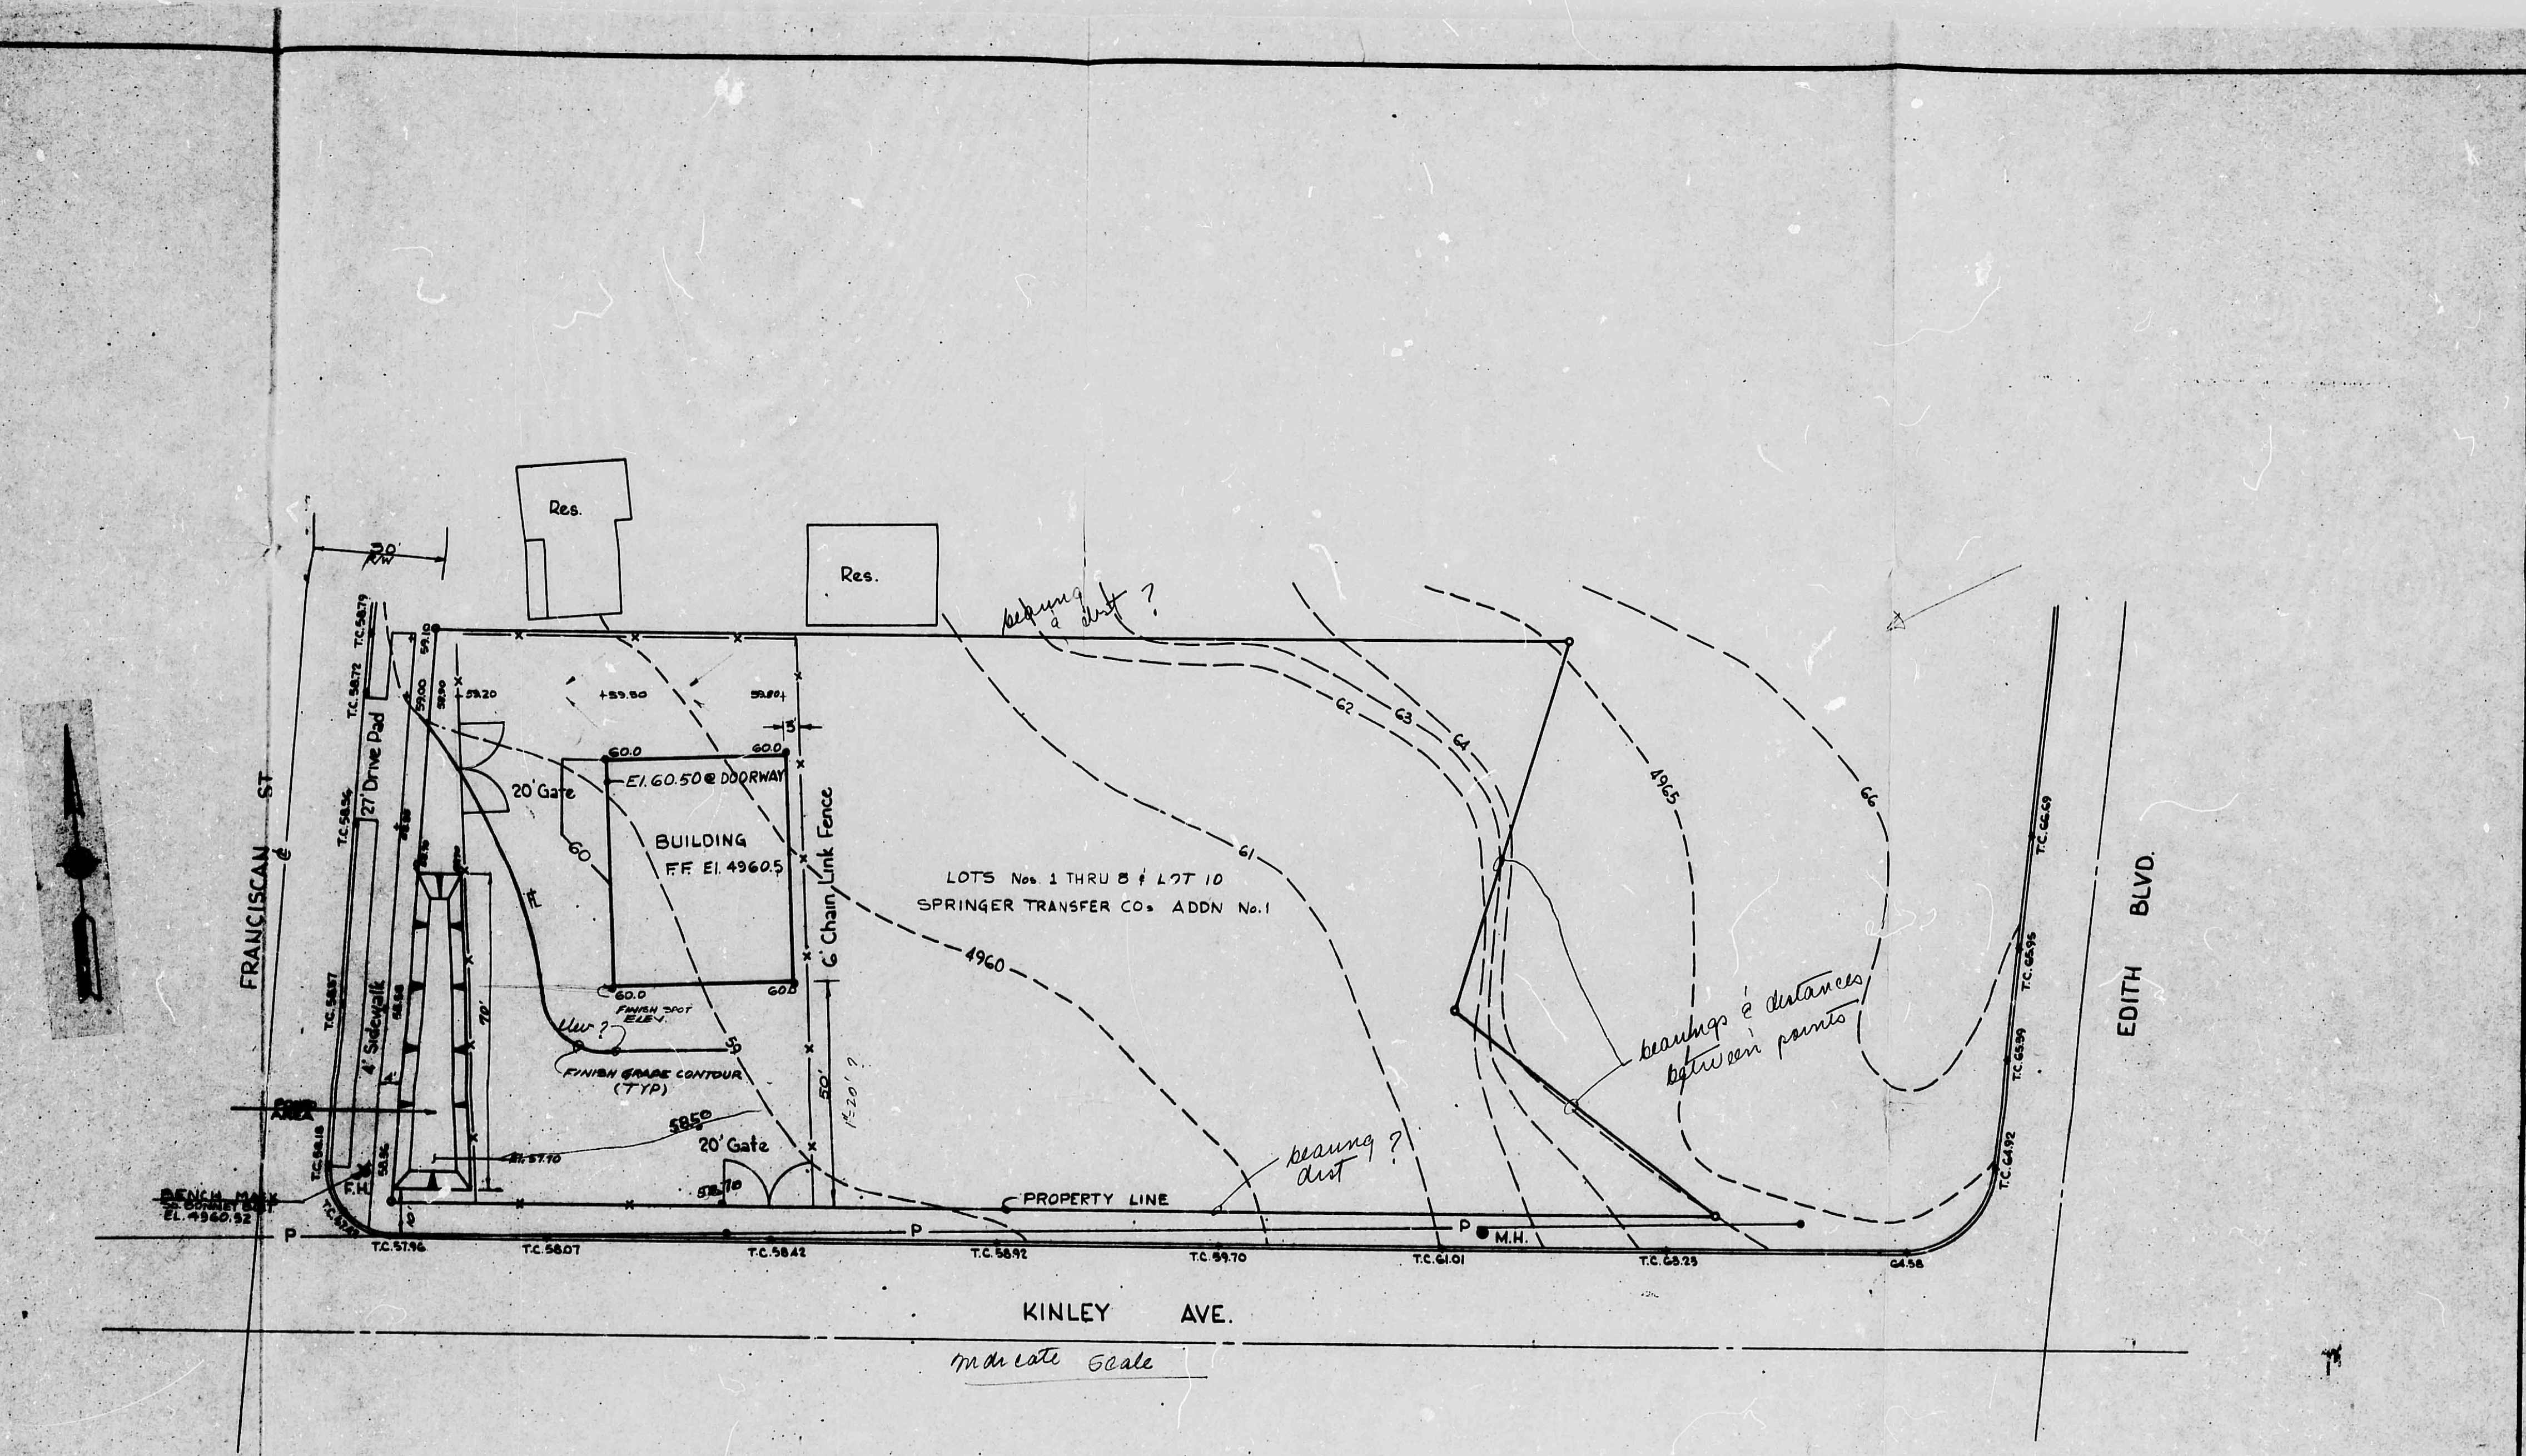

LEGEND
 O FINISH GRADE SPOT ELEVATION
 --- FINISH GRADE CONTOUR
 --- EXISTING GRADE CONTOUR



INDUSTRIAL ELECTRICAL EQUIP.				SHEET OF
GRADING AND DRAINAGE PLAN				
ASBURY & ASSOCIATES CONSULTING ENGINEERS ALBUQUERQUE, NEW MEXICO				
ENGR'S FILE NO. 77-117	DRAWN: D.P. TRACED: D.P.	CHECKED: CTA APPROVED: CTA	DATE: 9/22	SCALE: 1"=20'

CITY OF ALBUQUERQUE

C D