


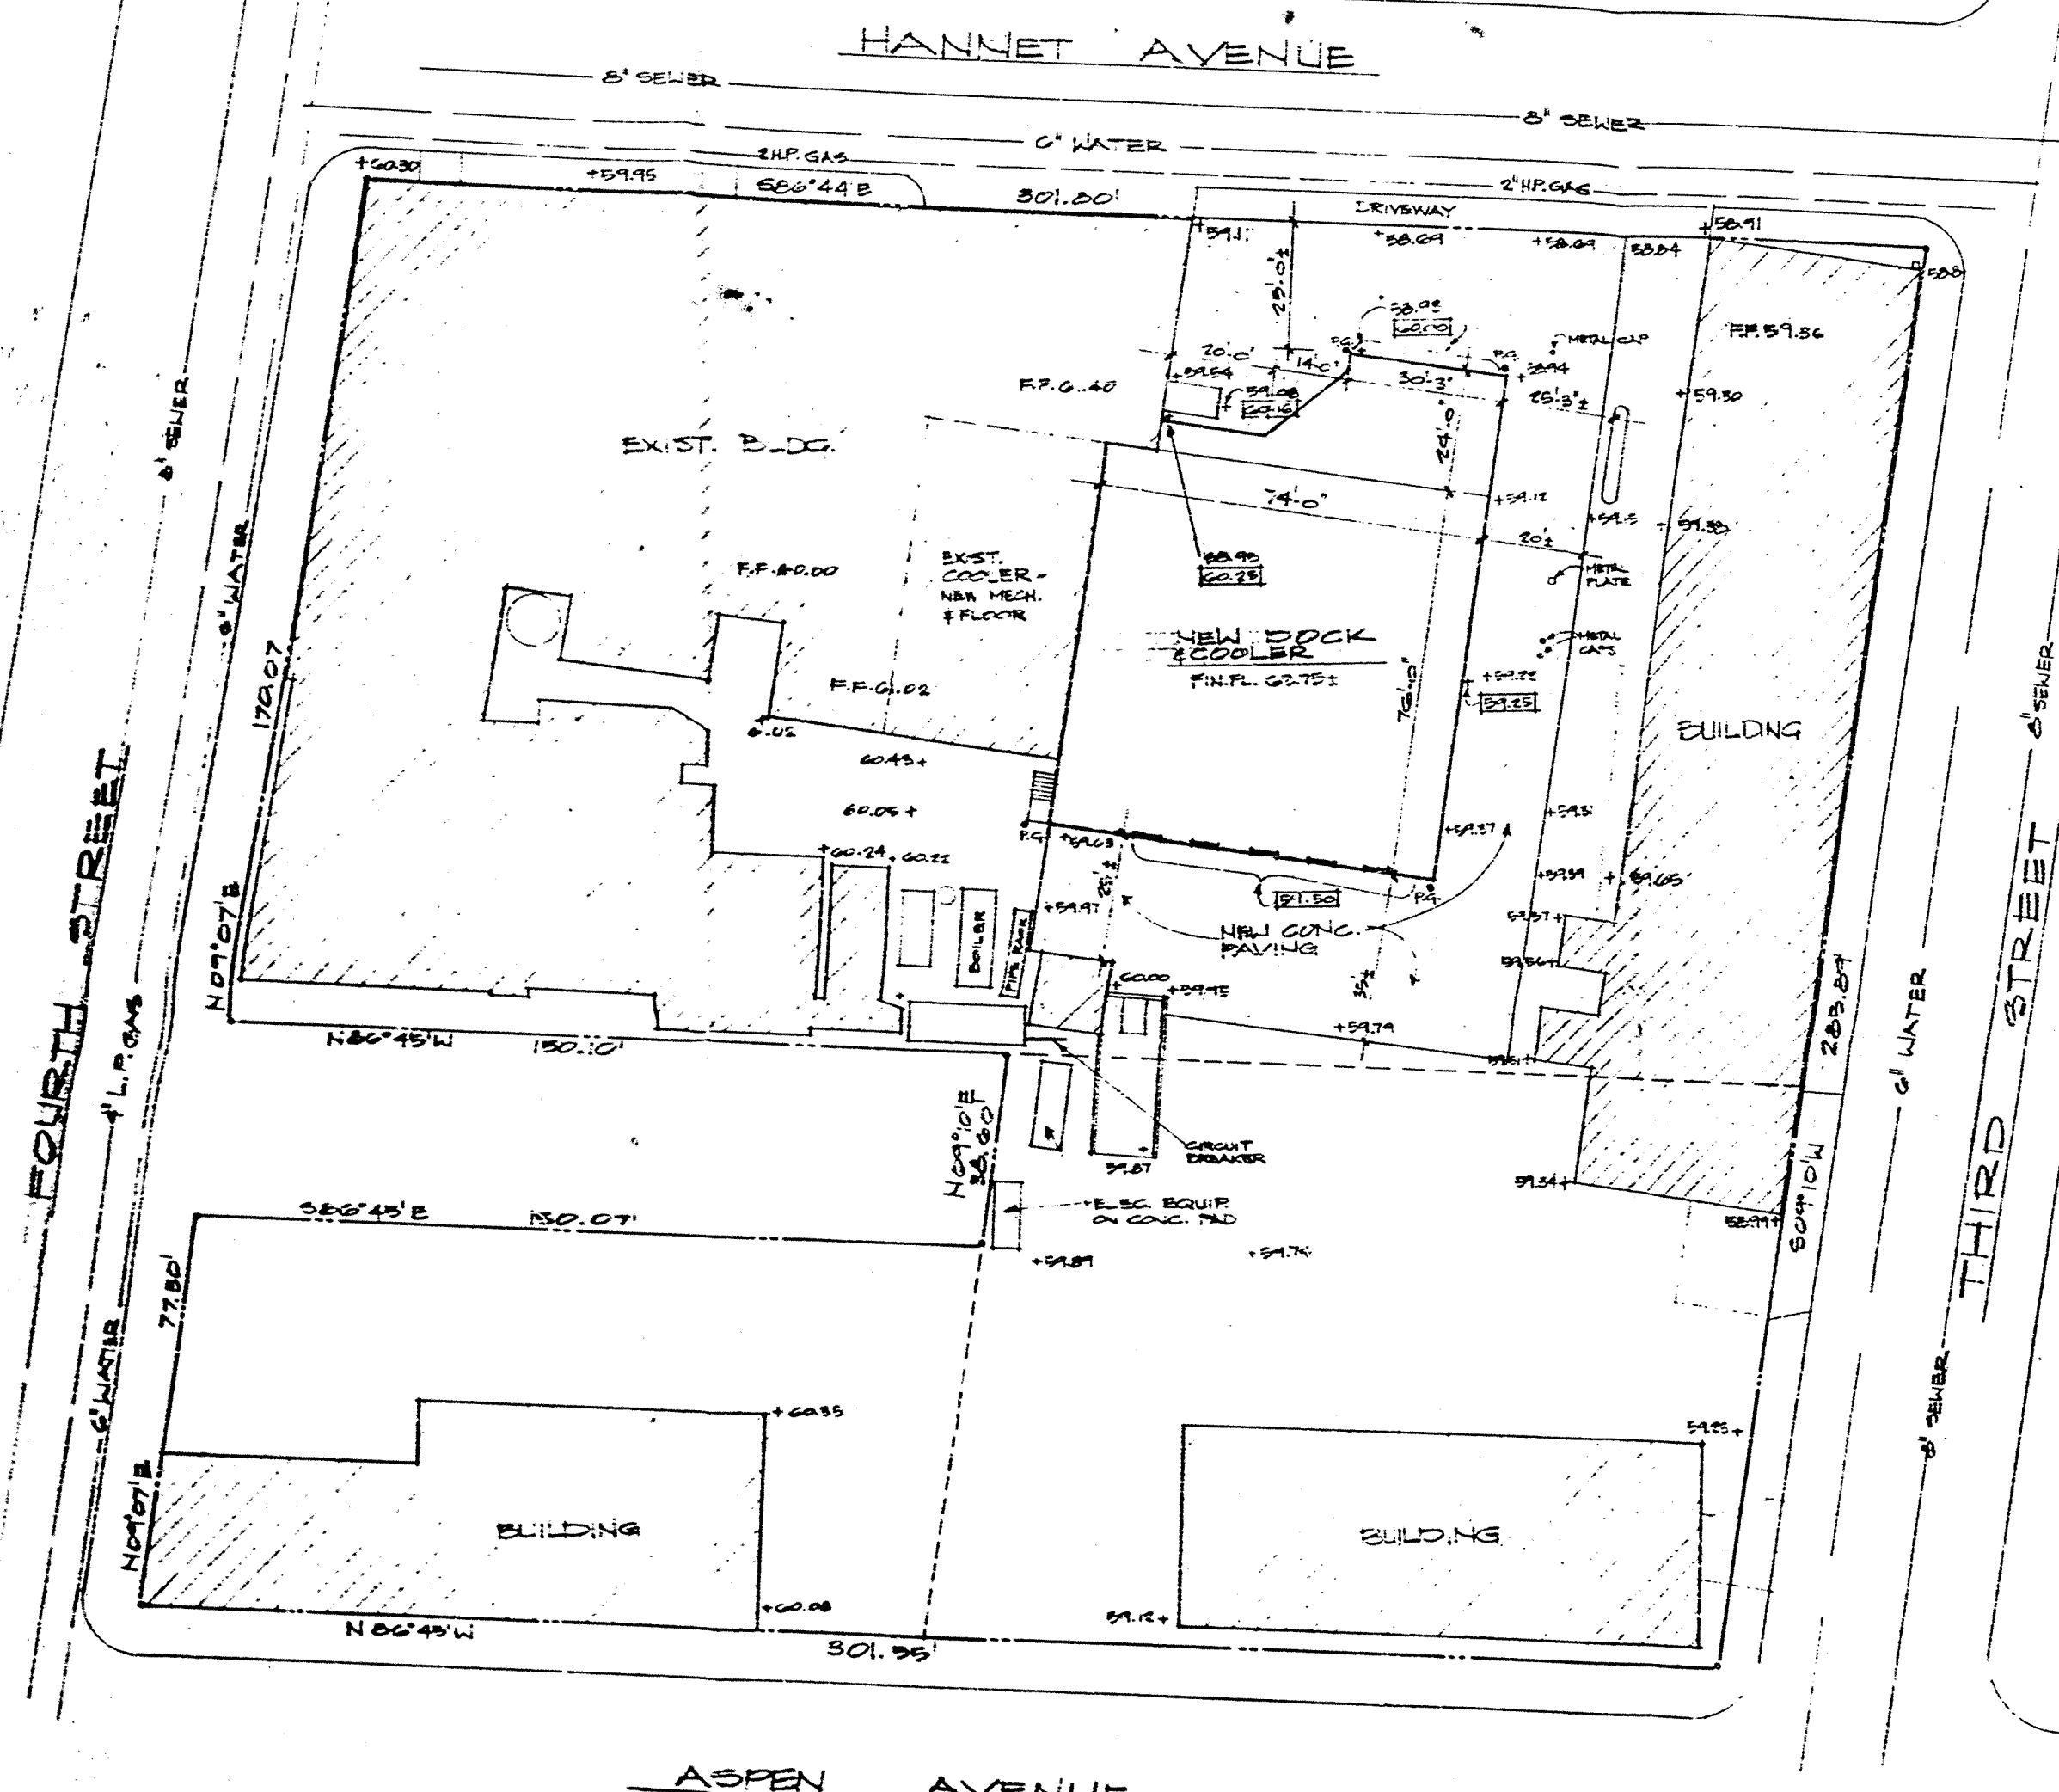

LEGAL DESCRIPTION:
 BLOCK #2, MATTHEW ADDITION, LOTS NO. 1, 2, 3, 6, 7, 8, 9

ADDRESS:
 1710 4TH STREET N.W.

OWNER:
 BORDEN, INC., 323 ASPEN, ALBUQUERQUE, N.M.
 PHONE: 242-0851


ZONING:
 M-1 PER ATLAS # C-14-2

OCCUPANCY:
 D-4

AREA:
 COOLER ADDITION 3624 SQ. FT.
 OPEN DOCK 1176
TOTAL 6800 SQ. FT.


OCCUPANT LOAD: 7

REQUIRED EXITS: ONE

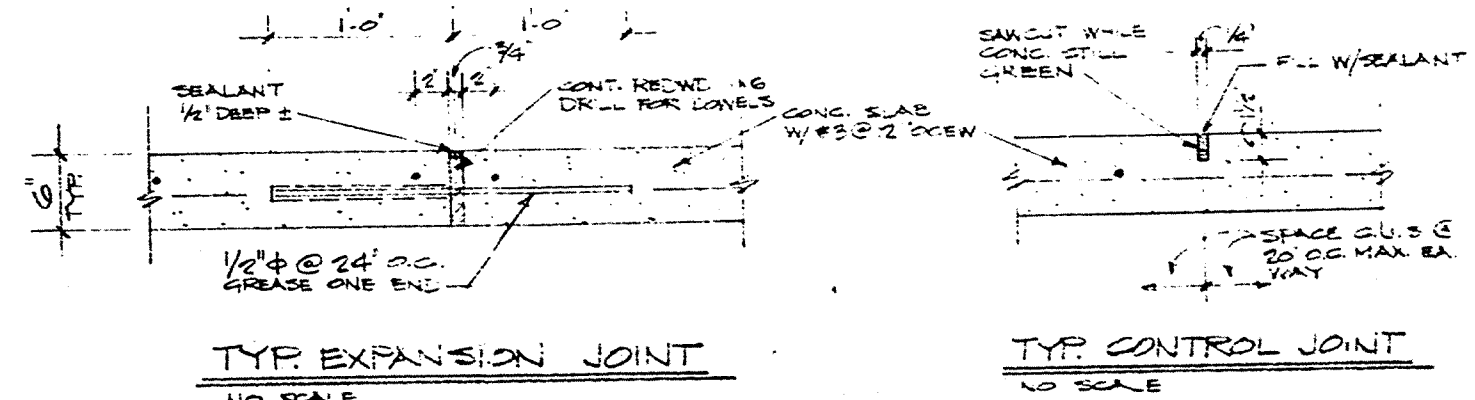

INDEX OF DRAWINGS

C1	SITE & PAVING PLAN
C2	DEMOLITION PLAN ORDER OF CONSTRUCTION
A1	FLOOR PLAN
A2	CONVEYOR PLAN
A3	EXTERIOR ELEVATIONS
A4	SECTIONS & DETAILS
A5	TEMPORARY CONVEYOR PLAN
S1	FOUNDATION PLAN & NOTES
S2	FOUNDATION DETAILS
S3	STRUCTURAL STEEL PLAN
E1	ELECTRICAL PLAN & SCHEDULES
M1	MECHANICAL PLAN, ROOF PLAN
P1	PLUMBING PLAN

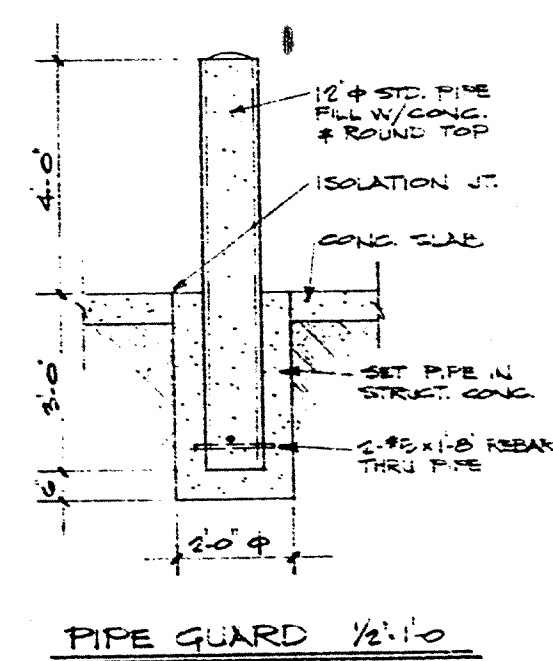

ALL EXISTING GRADES & UTILITY INFO. SHOWN TAKEN FROM PLAT BY WILLIAM P. PETTIT, REGISTERED NEW MEXICO LAND SURVEYOR NUMBER 8243, DATED SEPT. 27 1979.

SITE PLAN
 SCALE: 1" = 20'

FOR-	THE BORDEN COMPANY	PROJECT-	ADDITION		REVISION	DATE		DRAWING NO.
	1710 FOURTH STREET N.W.	DOCK & COOLER				1-21-85		
	ALBUQUERQUE, NEW MEXICO					SCALE		JOB NO.
						NOTED		11713

CITY OF ALBUQUERQUE