

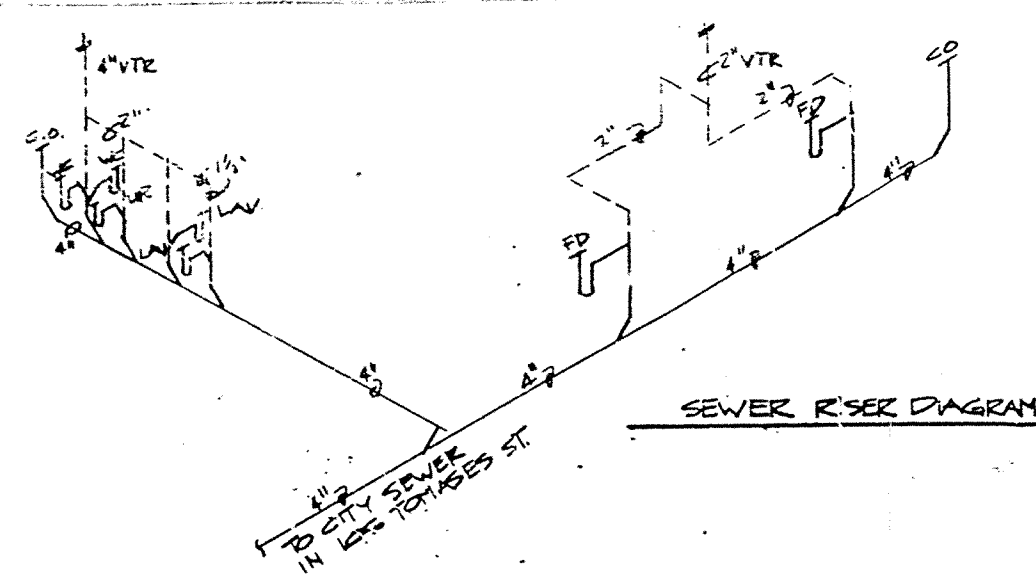


4/1/82

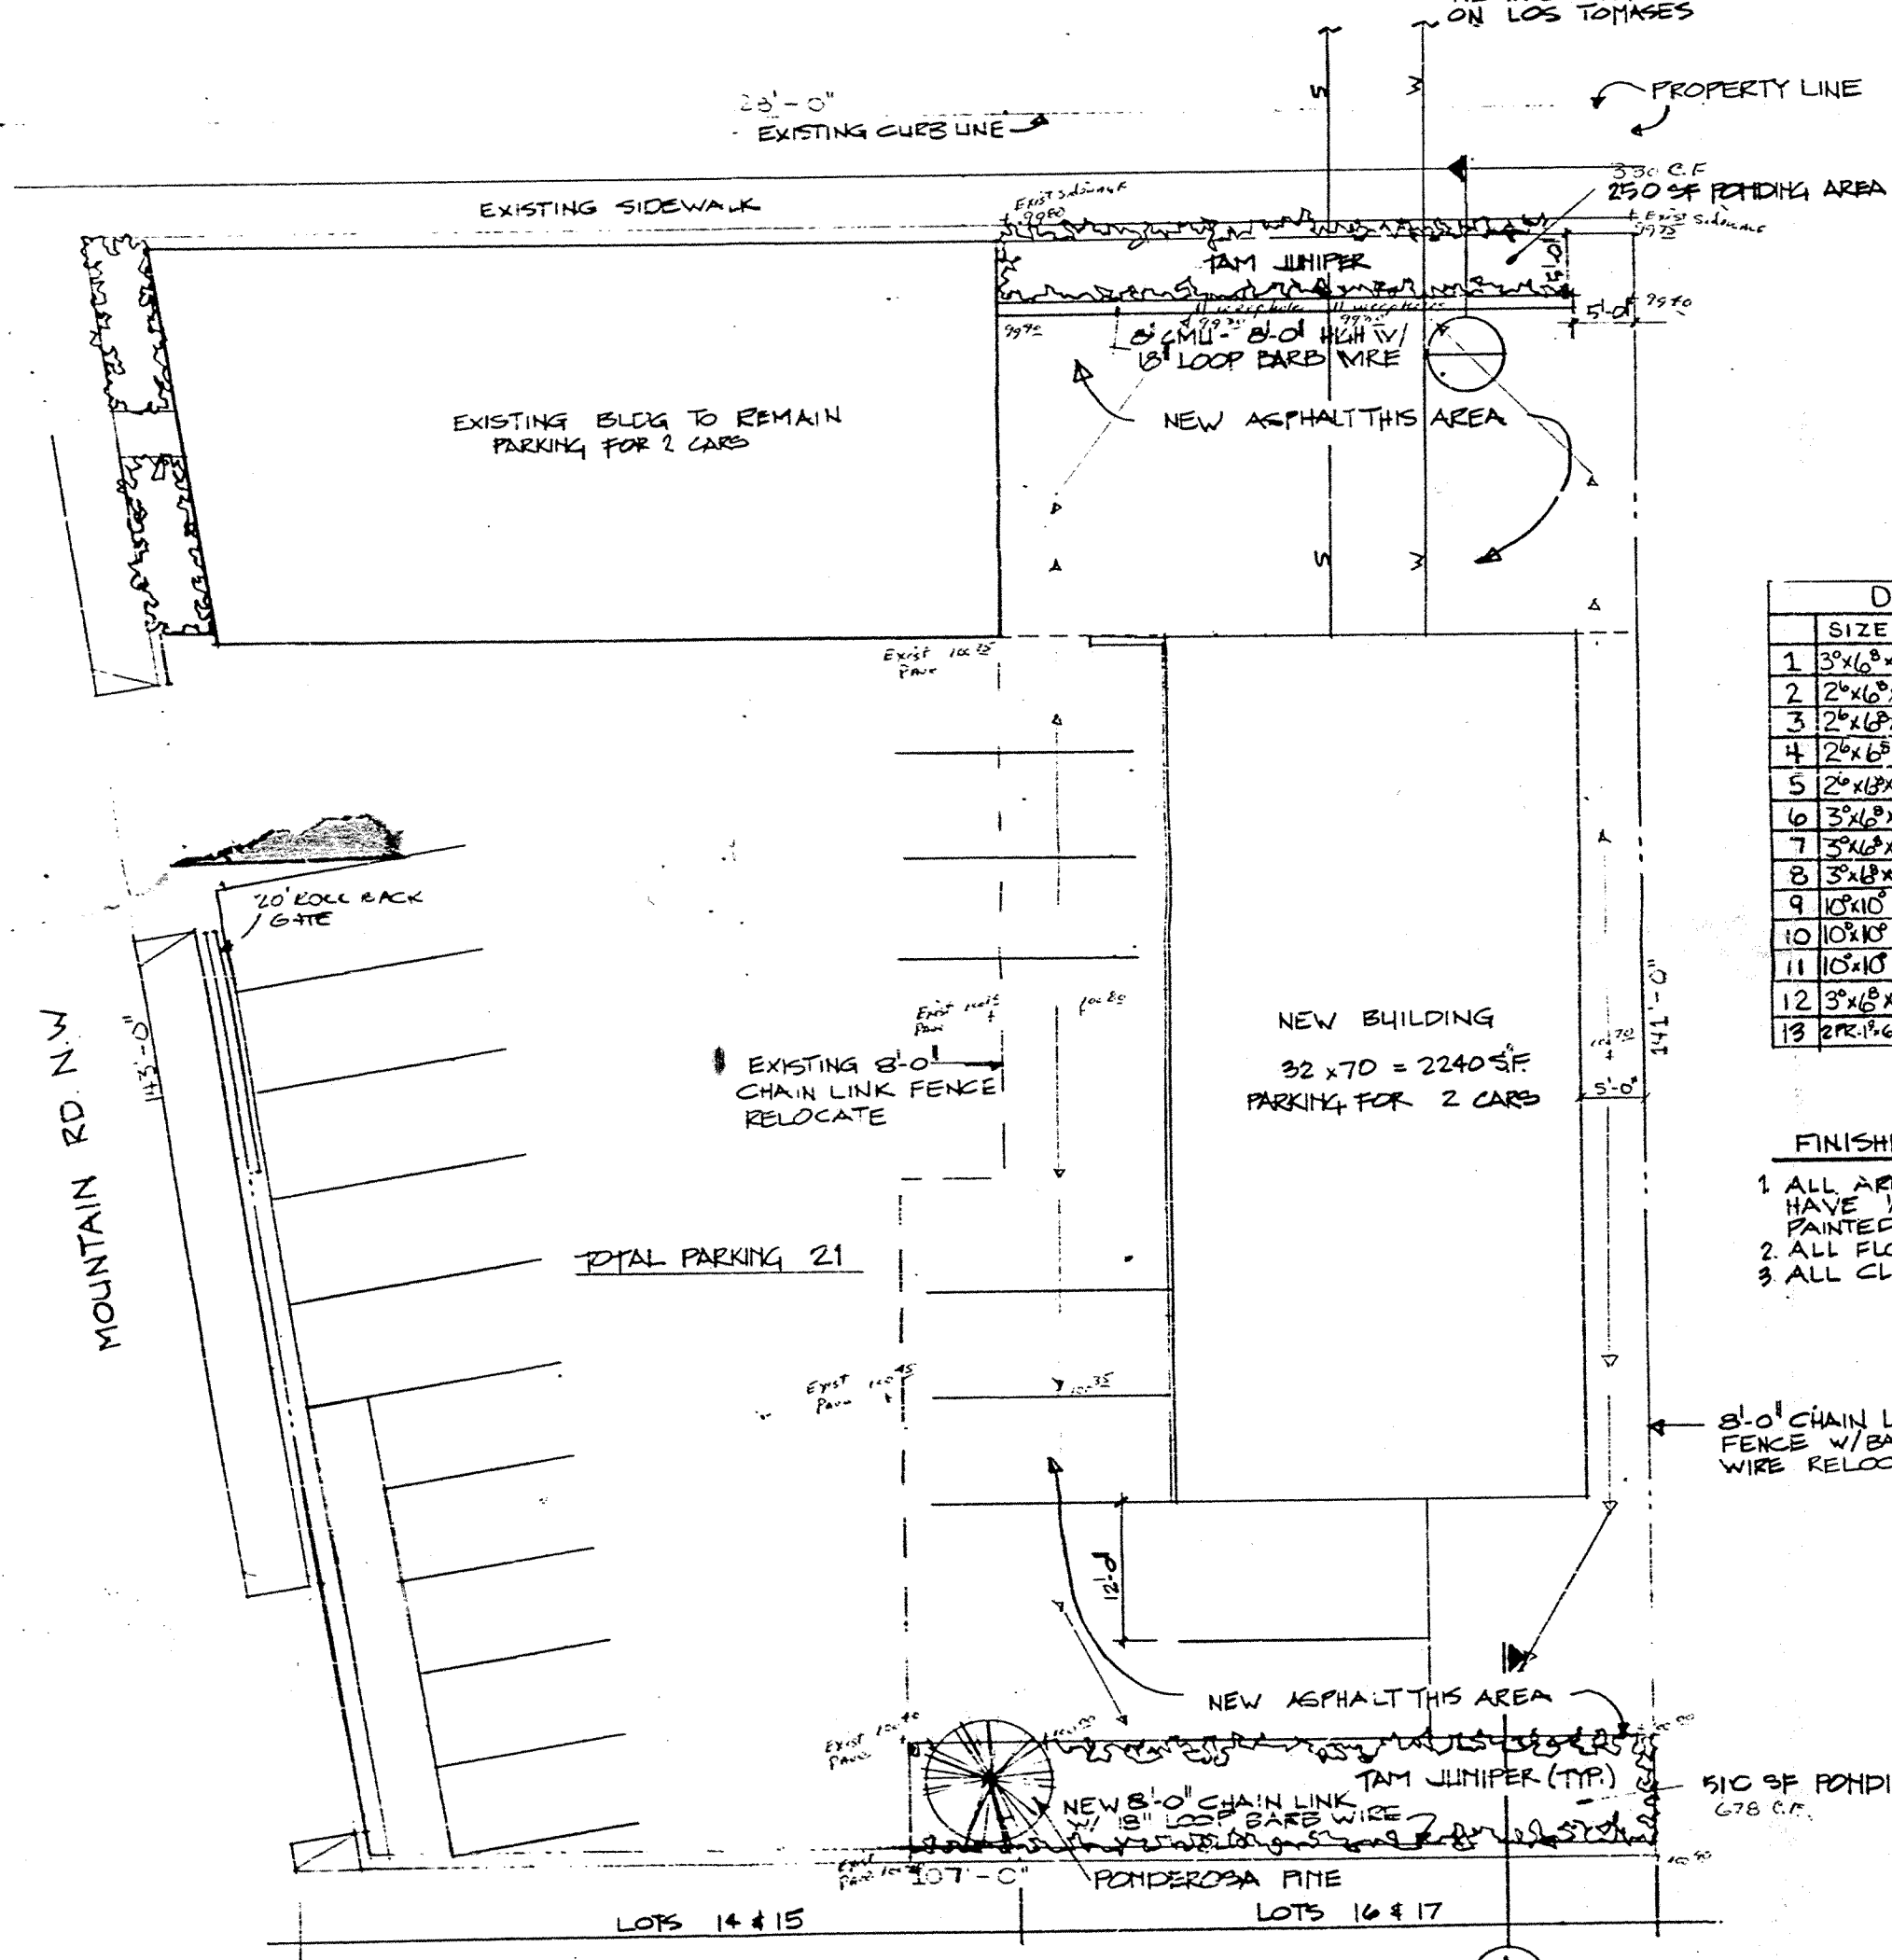

LOS TOMASES


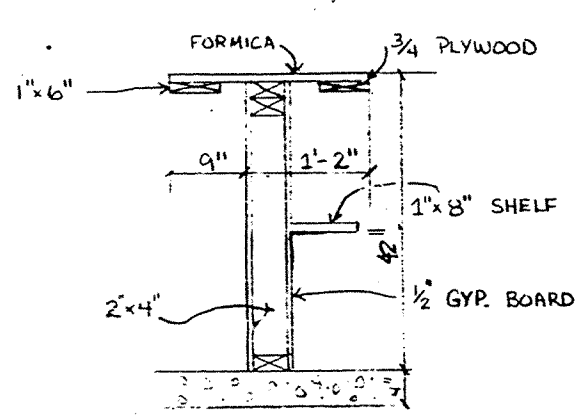


DOOR SCHEDULE					
NO.	SIZE	TYPE	FINISH	HW SET	REMARKS
1	3'0" x 6'0"	HM FLUSH	PAINT/PAINT	DEAD BOLT LOCK SET	
2	2'6" x 6'0"	HC FLUSH	STAIN/STAIN	LOCK SET	
3	2'6" x 6'0"	HC FLUSH			
4	2'6" x 6'0"	HC FLUSH			
5	2'0" x 6'0"	SC FLUSH		LOCK SET	
6	3'0" x 6'0"	HM FLUSH	PAINT/PAINT	DEAD BOLT LOCK SET	3/4 HE
7	3'0" x 6'0"	HM FLUSH		DEAD BOLT LOCK SET	3/4 HE
8	3'0" x 6'0"	HM FLUSH			
9	10'0" x 10'0"	METAL ROLL-UP		LOCK SET	PREFINISHED
10	10'0" x 10'0"	METAL ROLL-UP		LOCK SET	
11	10'0" x 10'0"	METAL ROLL-UP		LOCK SET	
12	3'0" x 6'0"	HM FLUSH	PAINT/PAINT	DEAD BOLT LOCK SET	
13	2'0" x 6'0"	BI-FOLD	STAIN/STAIN	PULLS	

- FINISHES (EXCLUDING SHOPS)
1. ALL AREAS (EXCLUDING THE SHOPS) TO HAVE 1/2" GYP. BD TAPE, TEXTURED & PAINTED.
 2. ALL FLOOR TO BE V.A.T. W/ 1/4" VINYL BASE.
 3. ALL CLGS TO BE 2x4 LAY IN (SEE LIGHTING PLAN).

8'0" CHAIN LINK FENCE W/ BARBED WIRE RELOCATED

510 SF PONDING AREA

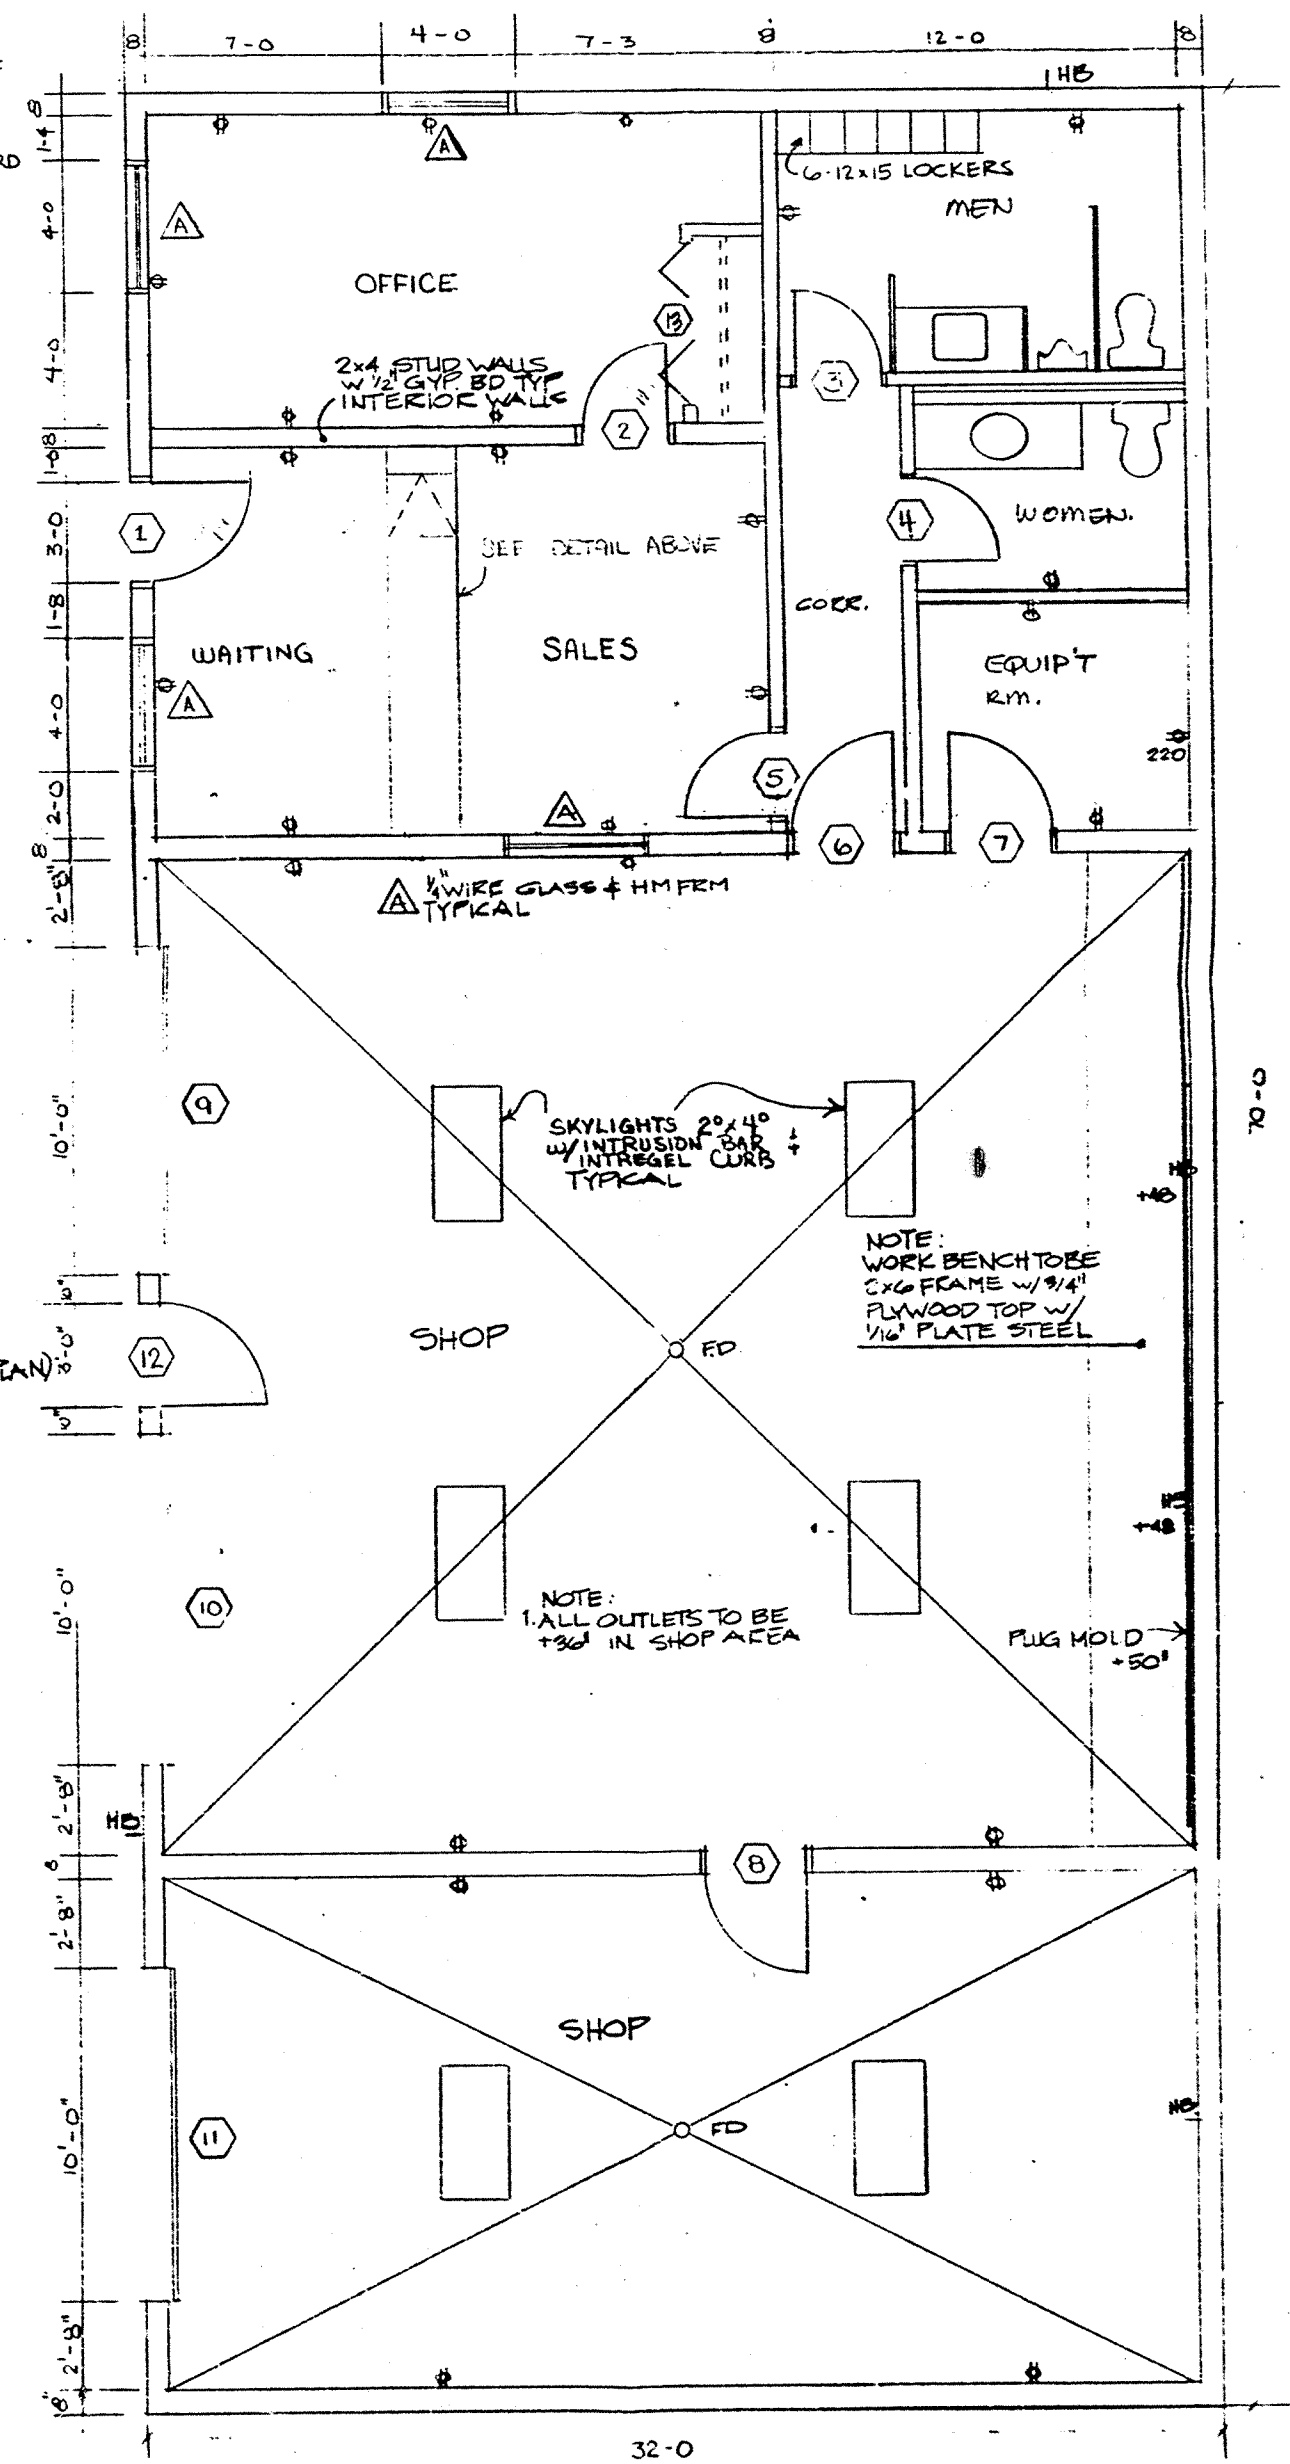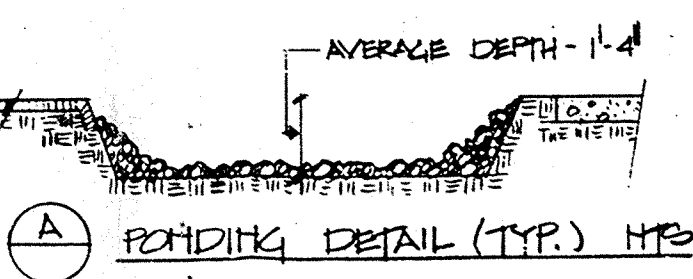

3/4/D52 (1)

SITE PLAN 1 1/2" = 10'-0"
G15 MOUNTAIN RD NW
BLOCK 0002
LOT 16 & 17
TOWN 10 N

FLOOR PLAN
SCALE 1/4" = 1'-0"