


File Path: E:\WORK\DWG\1837\1837-SDPP-R2.DWG Plot Date: 01-06-2010
File Name: 71837-SDPP-R2.DWG Plot Time: 09:54 am


(A1) STORM DRAIN PLAN AND PROFILE

SCALE: 1" = 20'

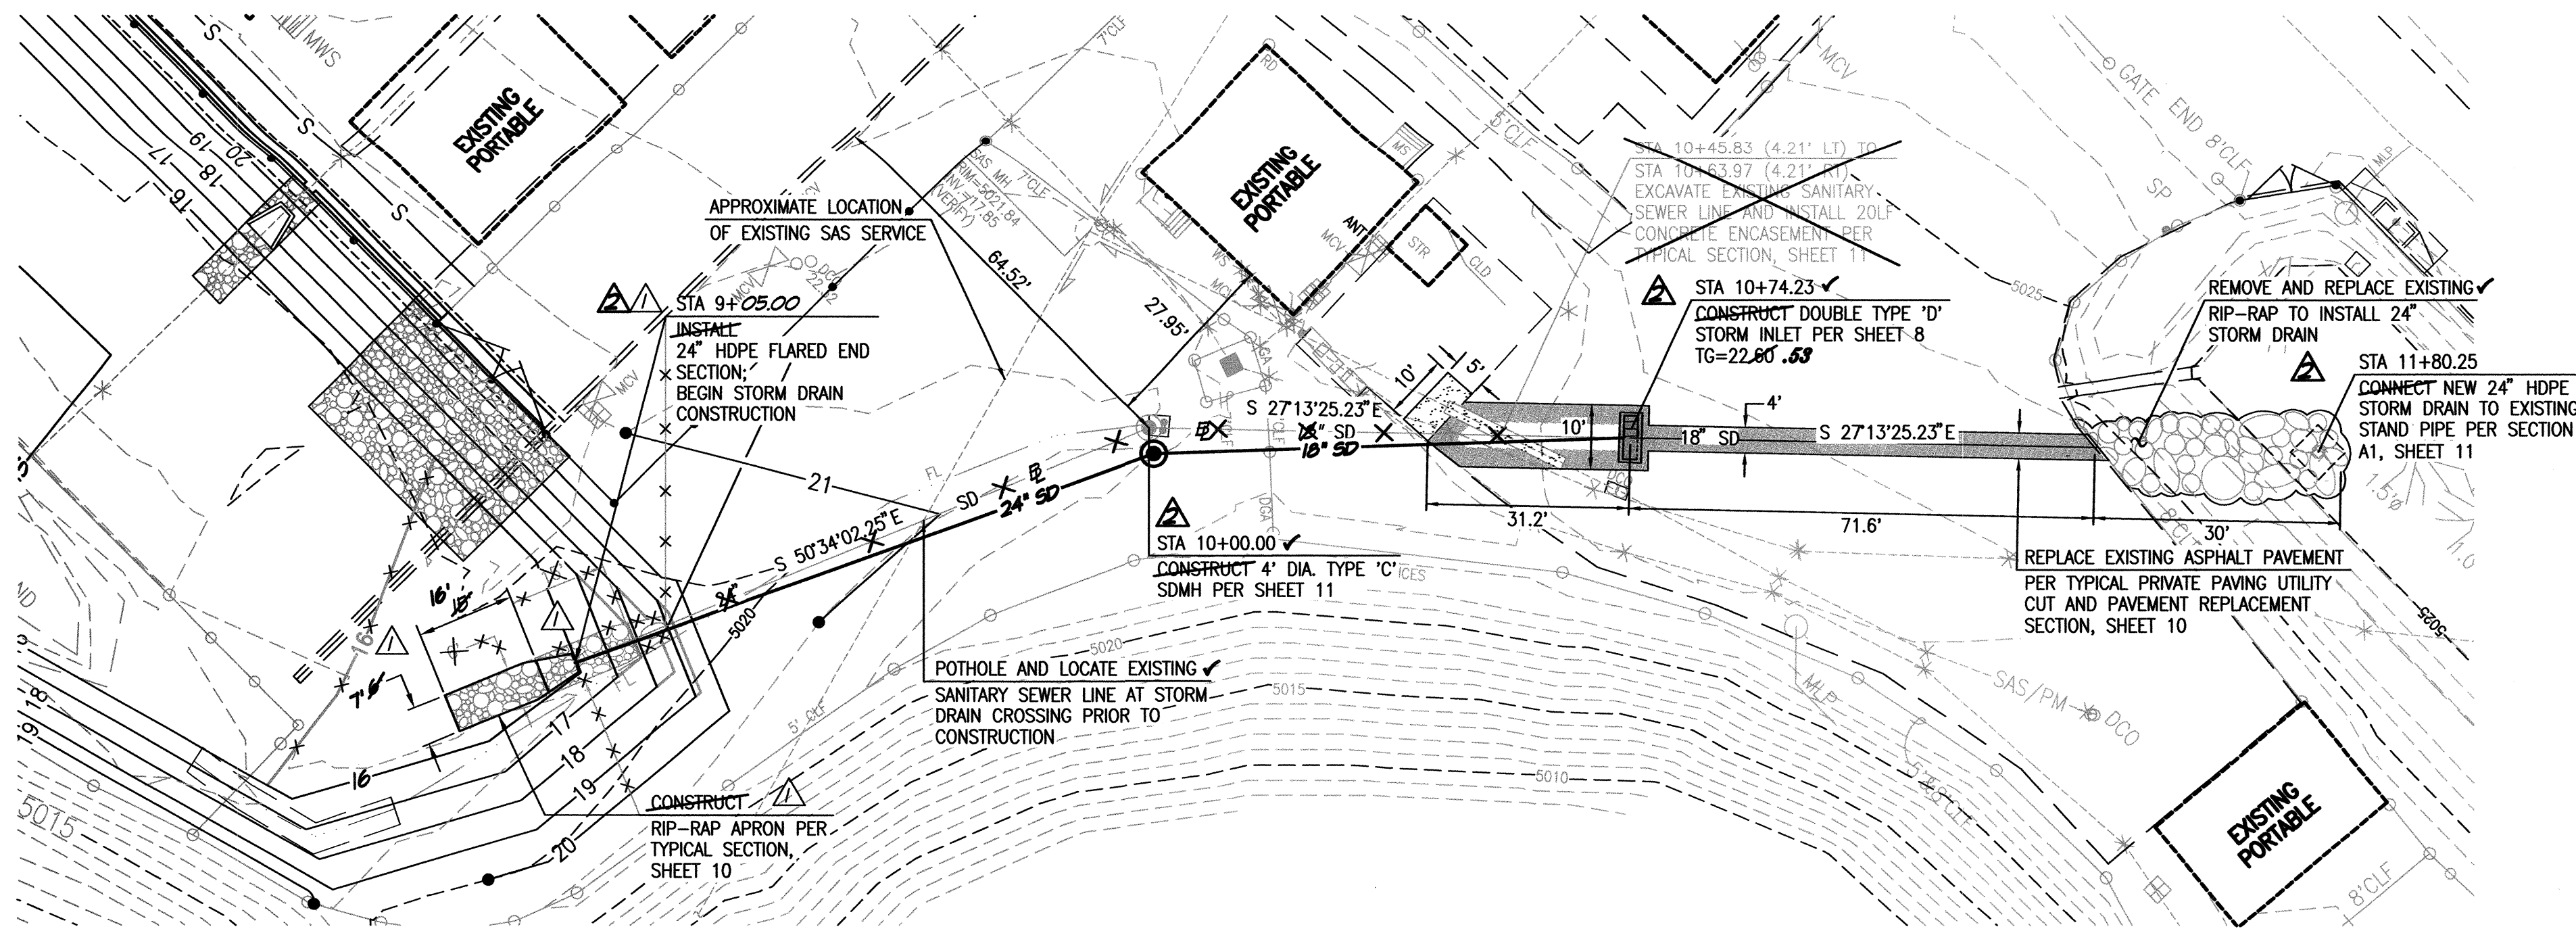

STORM DRAIN LINE

SCALE:
1" = 20' HORIZONTAL
1" = 5' VERTICAL

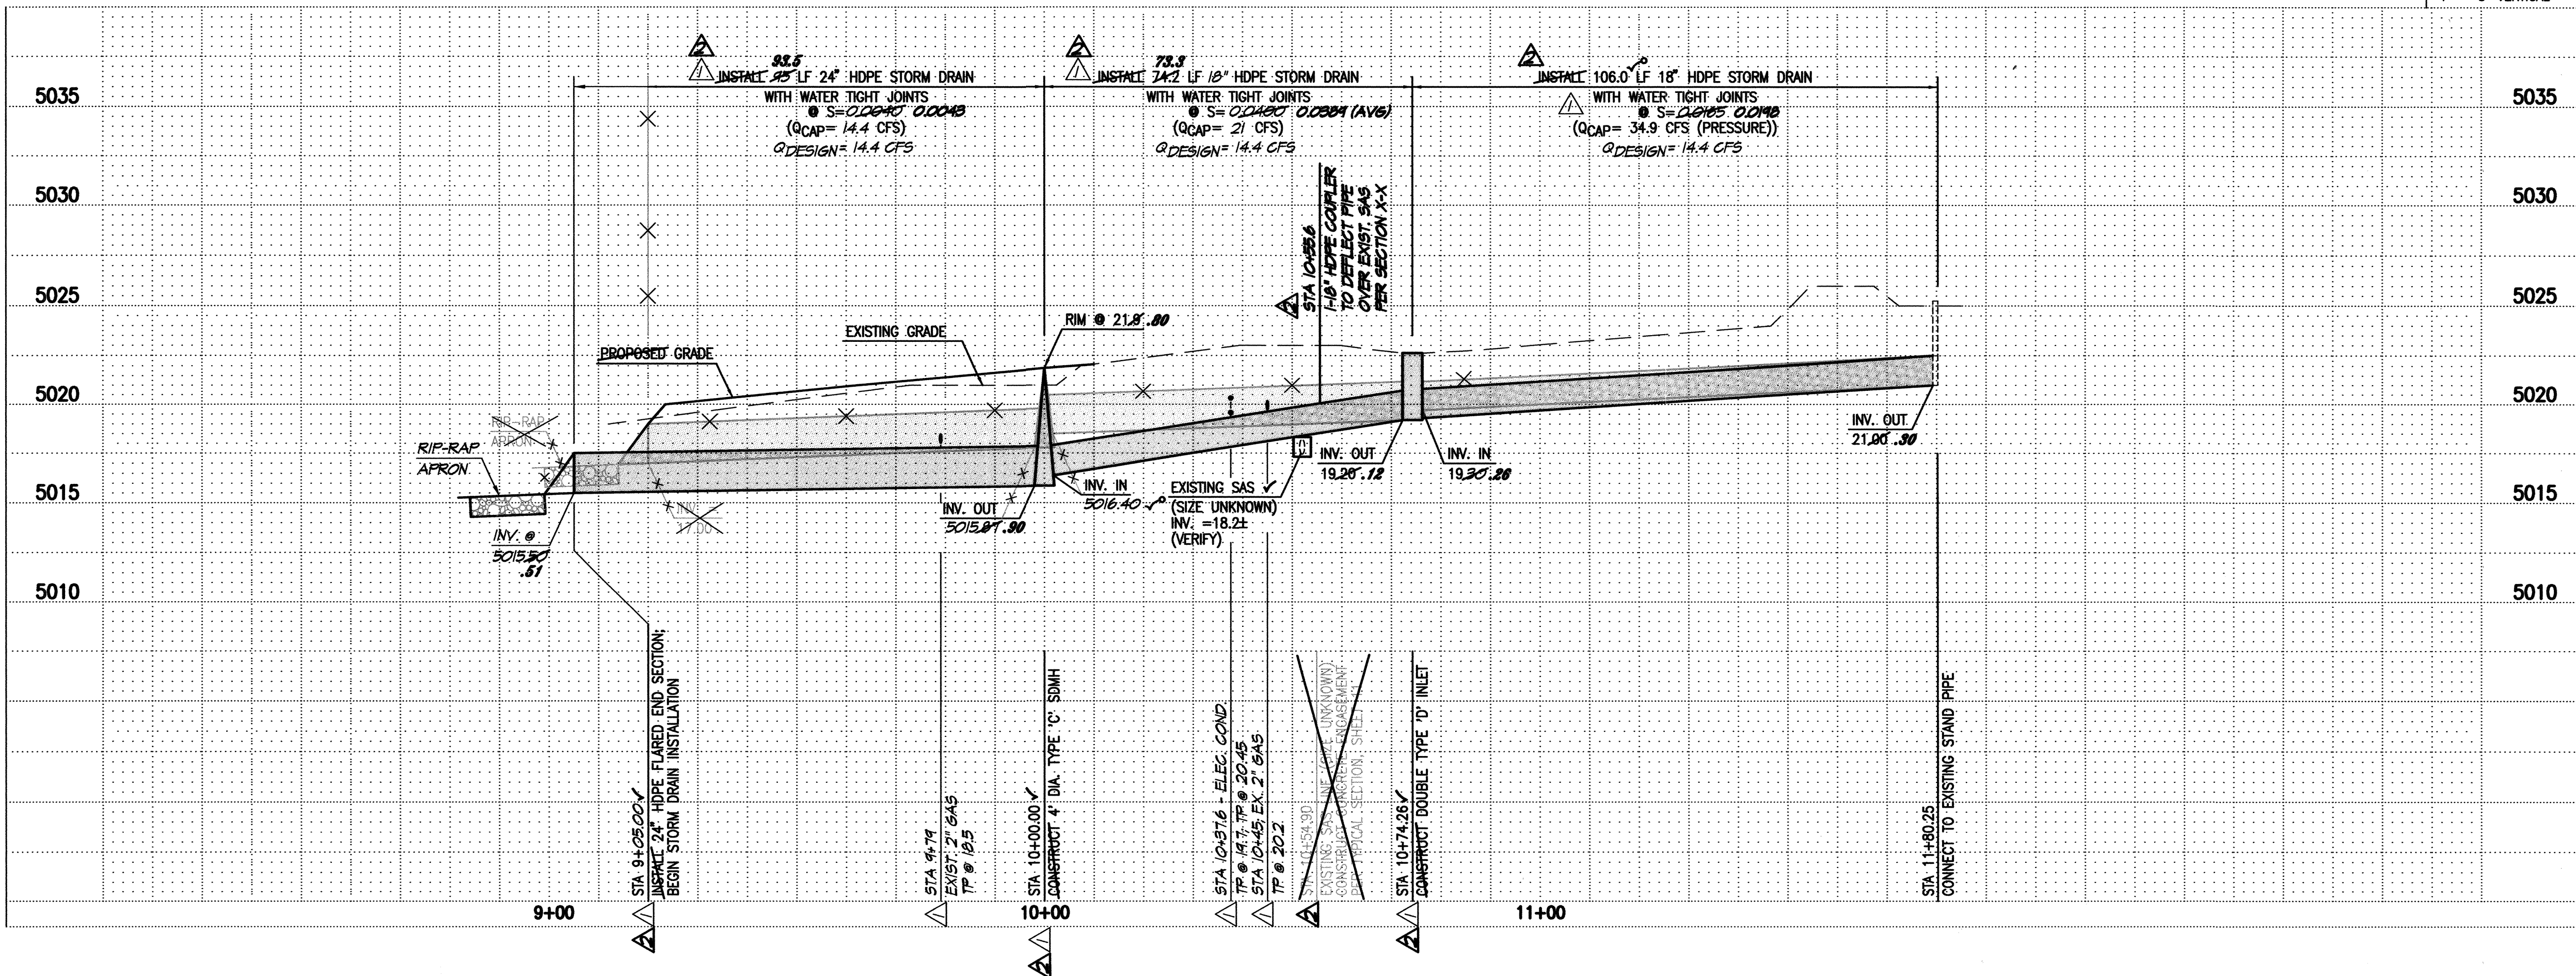

LEGEND


- STORM DRAIN MANHOLE
- DOUBLE 'D' INLET

STORM DRAIN NOTES:

1. ALL STORM DRAIN TO BE HDPE WITH WATER TIGHT JOINTS UNLESS OTHERWISE NOTED.
2. ALL MANHOLES SHALL BE 4' DIAMETER TYPE 'C' PER SHEET 11 UNLESS OTHERWISE NOTED.
3. ALL STATIONING SHOWN HEREON IS BASED ON STORM DRAIN CENTERLINE UNLESS OTHERWISE NOTED. SLOPES ARE BASED ON TRUE LENGTH OF PIPE.
4. THE CONTRACTOR SHALL BE RESPONSIBLE FOR SELECTING APPROPRIATE MEANS AND METHODS TO EXCAVATE AND TRENCH AND INSTALL PIPE SO AS TO NOT EXCEED RIGHT-OF-WAY OR EASEMENT LIMITS, AND SO AS NOT TO INTERFERE WITH OTHER UTILITIES. THIS SHALL BE CONSIDERED INCIDENTAL TO TRENCHING, THEREFORE, NO SEPARATE PAYMENT WILL BE MADE.
5. THE CONTRACTOR SHALL BE RESPONSIBLE FOR PROTECTING, SUPPORTING AND REPLACING, IF DAMAGED, ALL OTHER UTILITIES ENCOUNTERED DURING CONSTRUCTION. THIS SHALL BE CONSIDERED INCIDENTAL TO TRENCHING, THEREFORE, NO SEPARATE PAYMENT WILL BE MADE.

RECORD DRAWING LEGEND

- | CONSTRUCT | RECORD INFORMATION (VERIFIED BY ENGINEER) |
|-----------|--|
| ✓ | AS-CONSTRUCTED = AS-DESIGNED (VERIFIED BY ENGINEER) |
| 3/8" 42" | RECORD INFORMATION (VERIFIED BY ENGINEER) |
| +25.2 | RECORD INFORMATION (VERIFIED BY ENGINEER) |
| 28,98.42 | RECORD INFORMATION (VERIFIED BY ENGINEER) |
| ✓ | AS-CONSTRUCTED = AS-DESIGNED (VERIFIED BY AS-BUILT SURVEY) |
| 3/8" 31.8 | RECORD INFORMATION FROM AS-BUILT SURVEY |
| +26.9 | RECORD INFORMATION FROM AS-BUILT SURVEY |
| 31,28.22 | RECORD INFORMATION FROM AS-BUILT SURVEY |

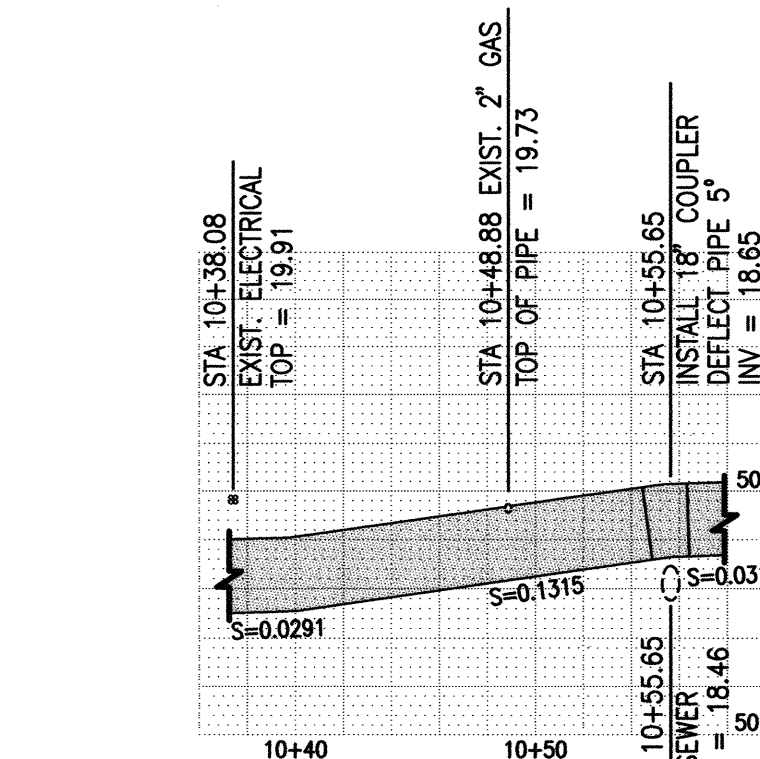

(A1) SECTION X-X (BY CCD)

SCALE: 1" = 8' HORIZONTAL
1" = 4' VERTICAL

RECORD DRAWING
FOR CERTIFICATION,
SEE SHEET 1

HIGH MESA
Consulting Group
FORMERLY JEFF MORRISON AND ASSOCIATES, INC.
6010-B MIDWAY PARK BLVD., NE
ALBUQUERQUE, NEW MEXICO 87109
PHONE: 505.345.4250 FAX: 505.345.4254
www.highmesacg.com

09-09-2009 10:10
01-11-2010
G. MORRISON
REGISTERED PROFESSIONAL ENGINEER
STATE OF NEW MEXICO
No. 13131
06-05-2009

MASTER DRAINAGE PLAN IMPROVEMENTS
PHASE 2-B
ALBUQUERQUE HIGH SCHOOL

REVISIONS			PROJECT No.	
NO.	DATE	BY	ADJUST PROFILE FOR UNFORESEEN UTILITIES REC. DWS. & CERT.	2007.183.7
1	01/04	J.G.M.		
2	12/04	A.M.		
DESIGNED BY			G.R.B.	
DRAWN BY			J.Y.R.	
APPROVED BY			J.G.M.	
SHEET TITLE				

STORM DRAIN
PLAN AND
PROFILE

C-107
SHEET 7 OF 14