


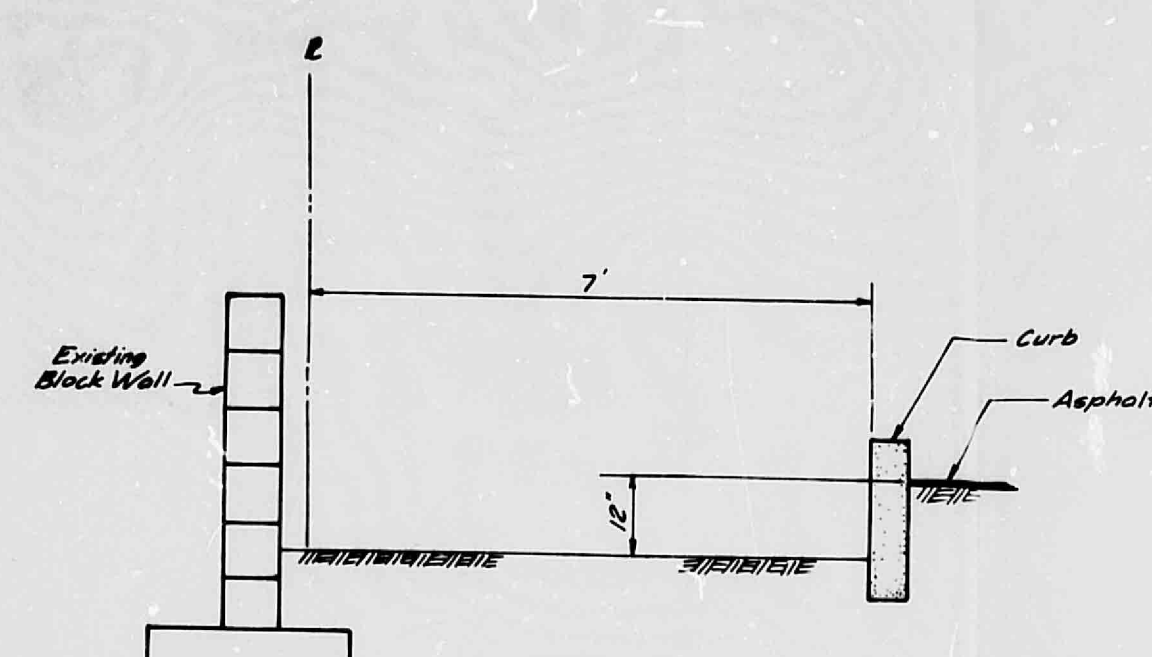


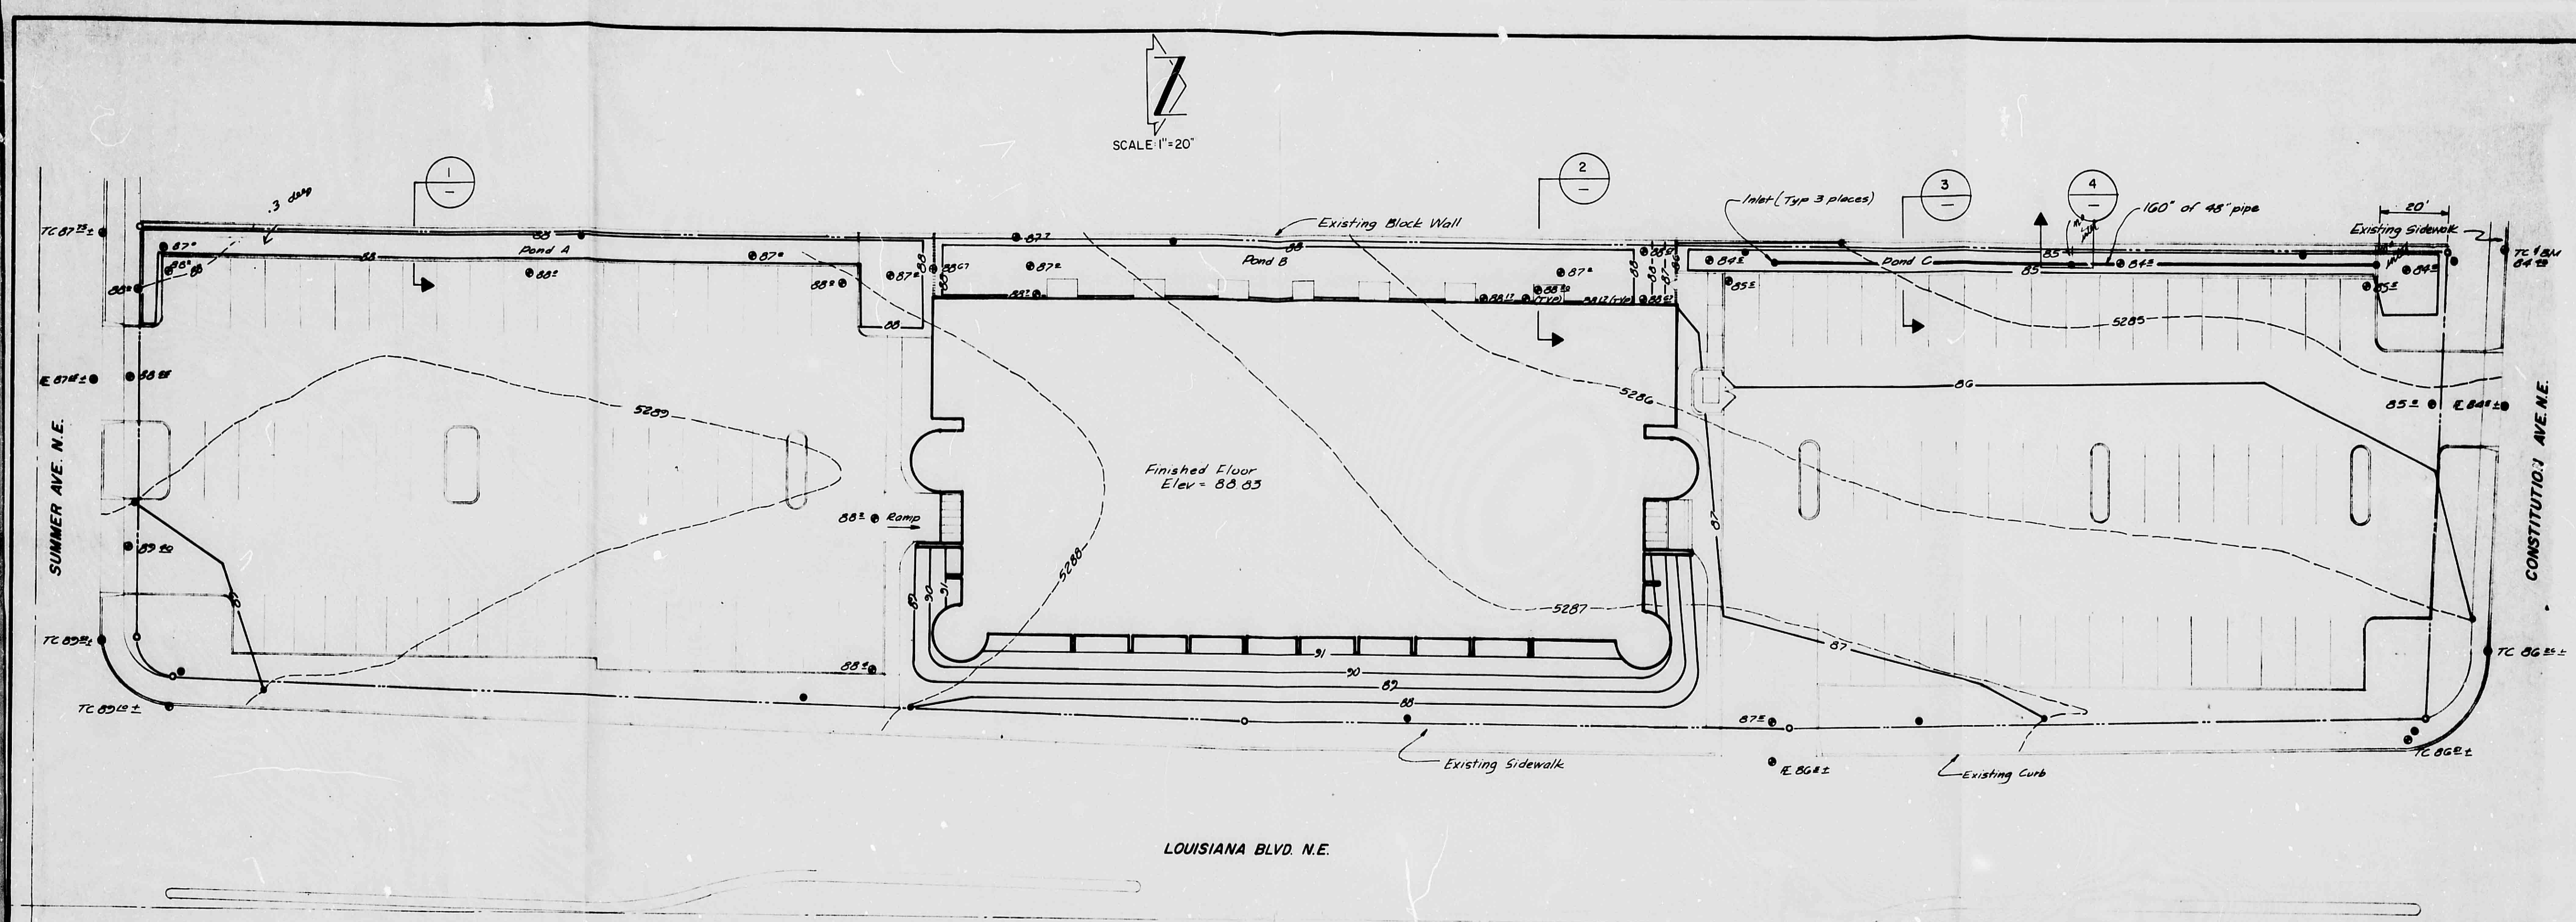


SECTION 1
SCALE 1" = 2'

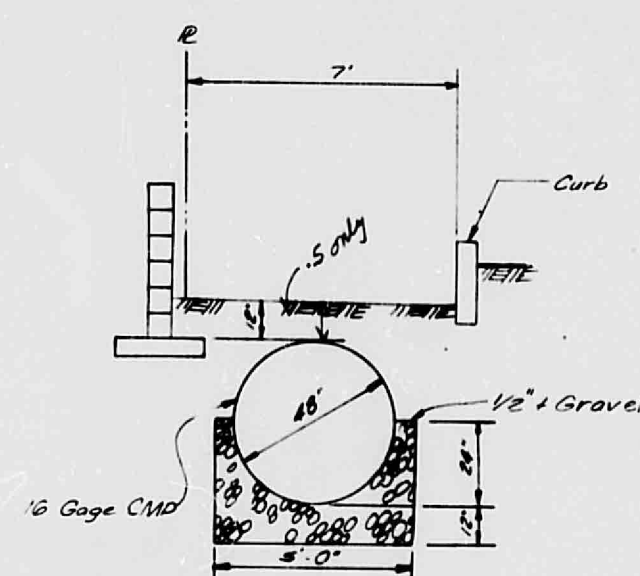


SECTION 3
SCALE 1" = 4'

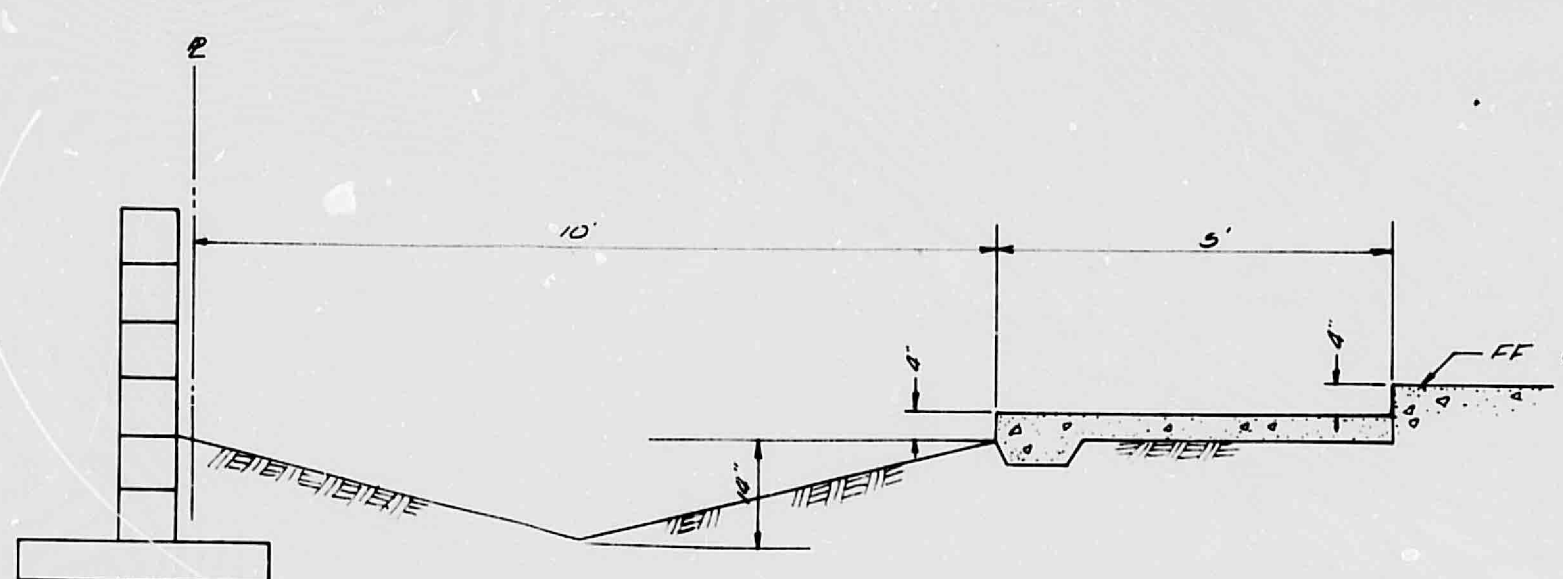

SECTION 2
SCALE 1" = 2'

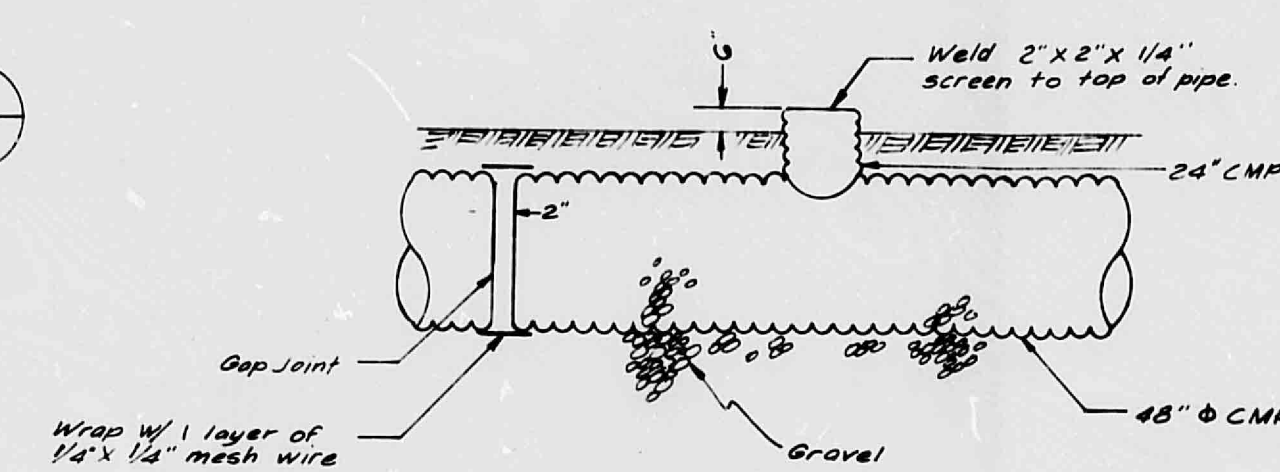

SECTION 4
NO SCALE

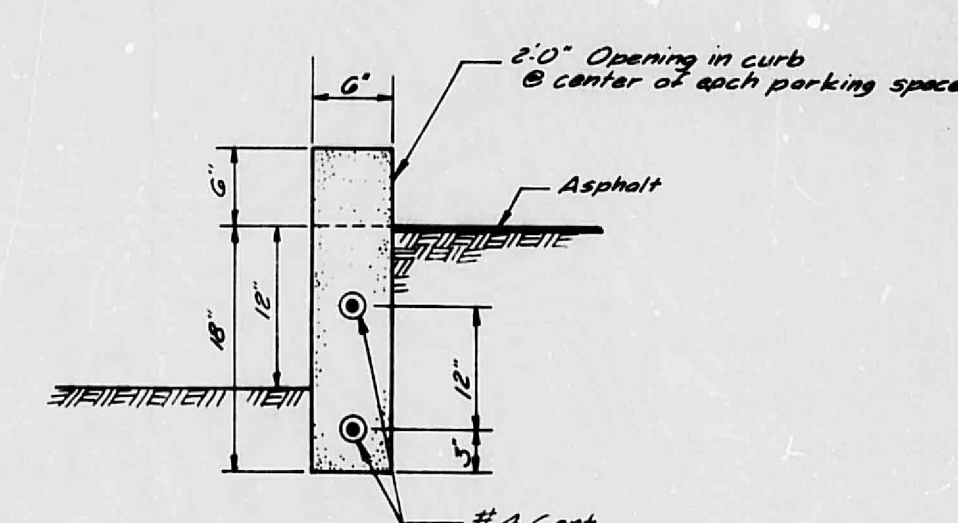

TYPICAL CURB
SCALE 1" = 1'

 Goldberg · Mann & Associates Engineers-Planners 911 Pennsylvania N.E. Albuquerque, New Mexico 87109	NO. DATE BY			REVISIONS	DESIGNED BY T.M.	JOB NO. 8-89	LOUISIANA PARK OFFICE BUILDING	FIGURE 4 DRAINAGE PLAN	FILE NO. _____
					DRAWN BY R.M.	DATE 10-78			
					APPROVED T.M.				

CITY OF ALBUQUERQUE
 THIS MICROFILME IS THE BEST
 POSSIBLE REPRODUCTION DUE
 TO THE POOR QUALITY OF THE
 ORIGINAL DOCUMENT

CITY OF ALBUQUERQUE