


ALBUQUERQUE, NM

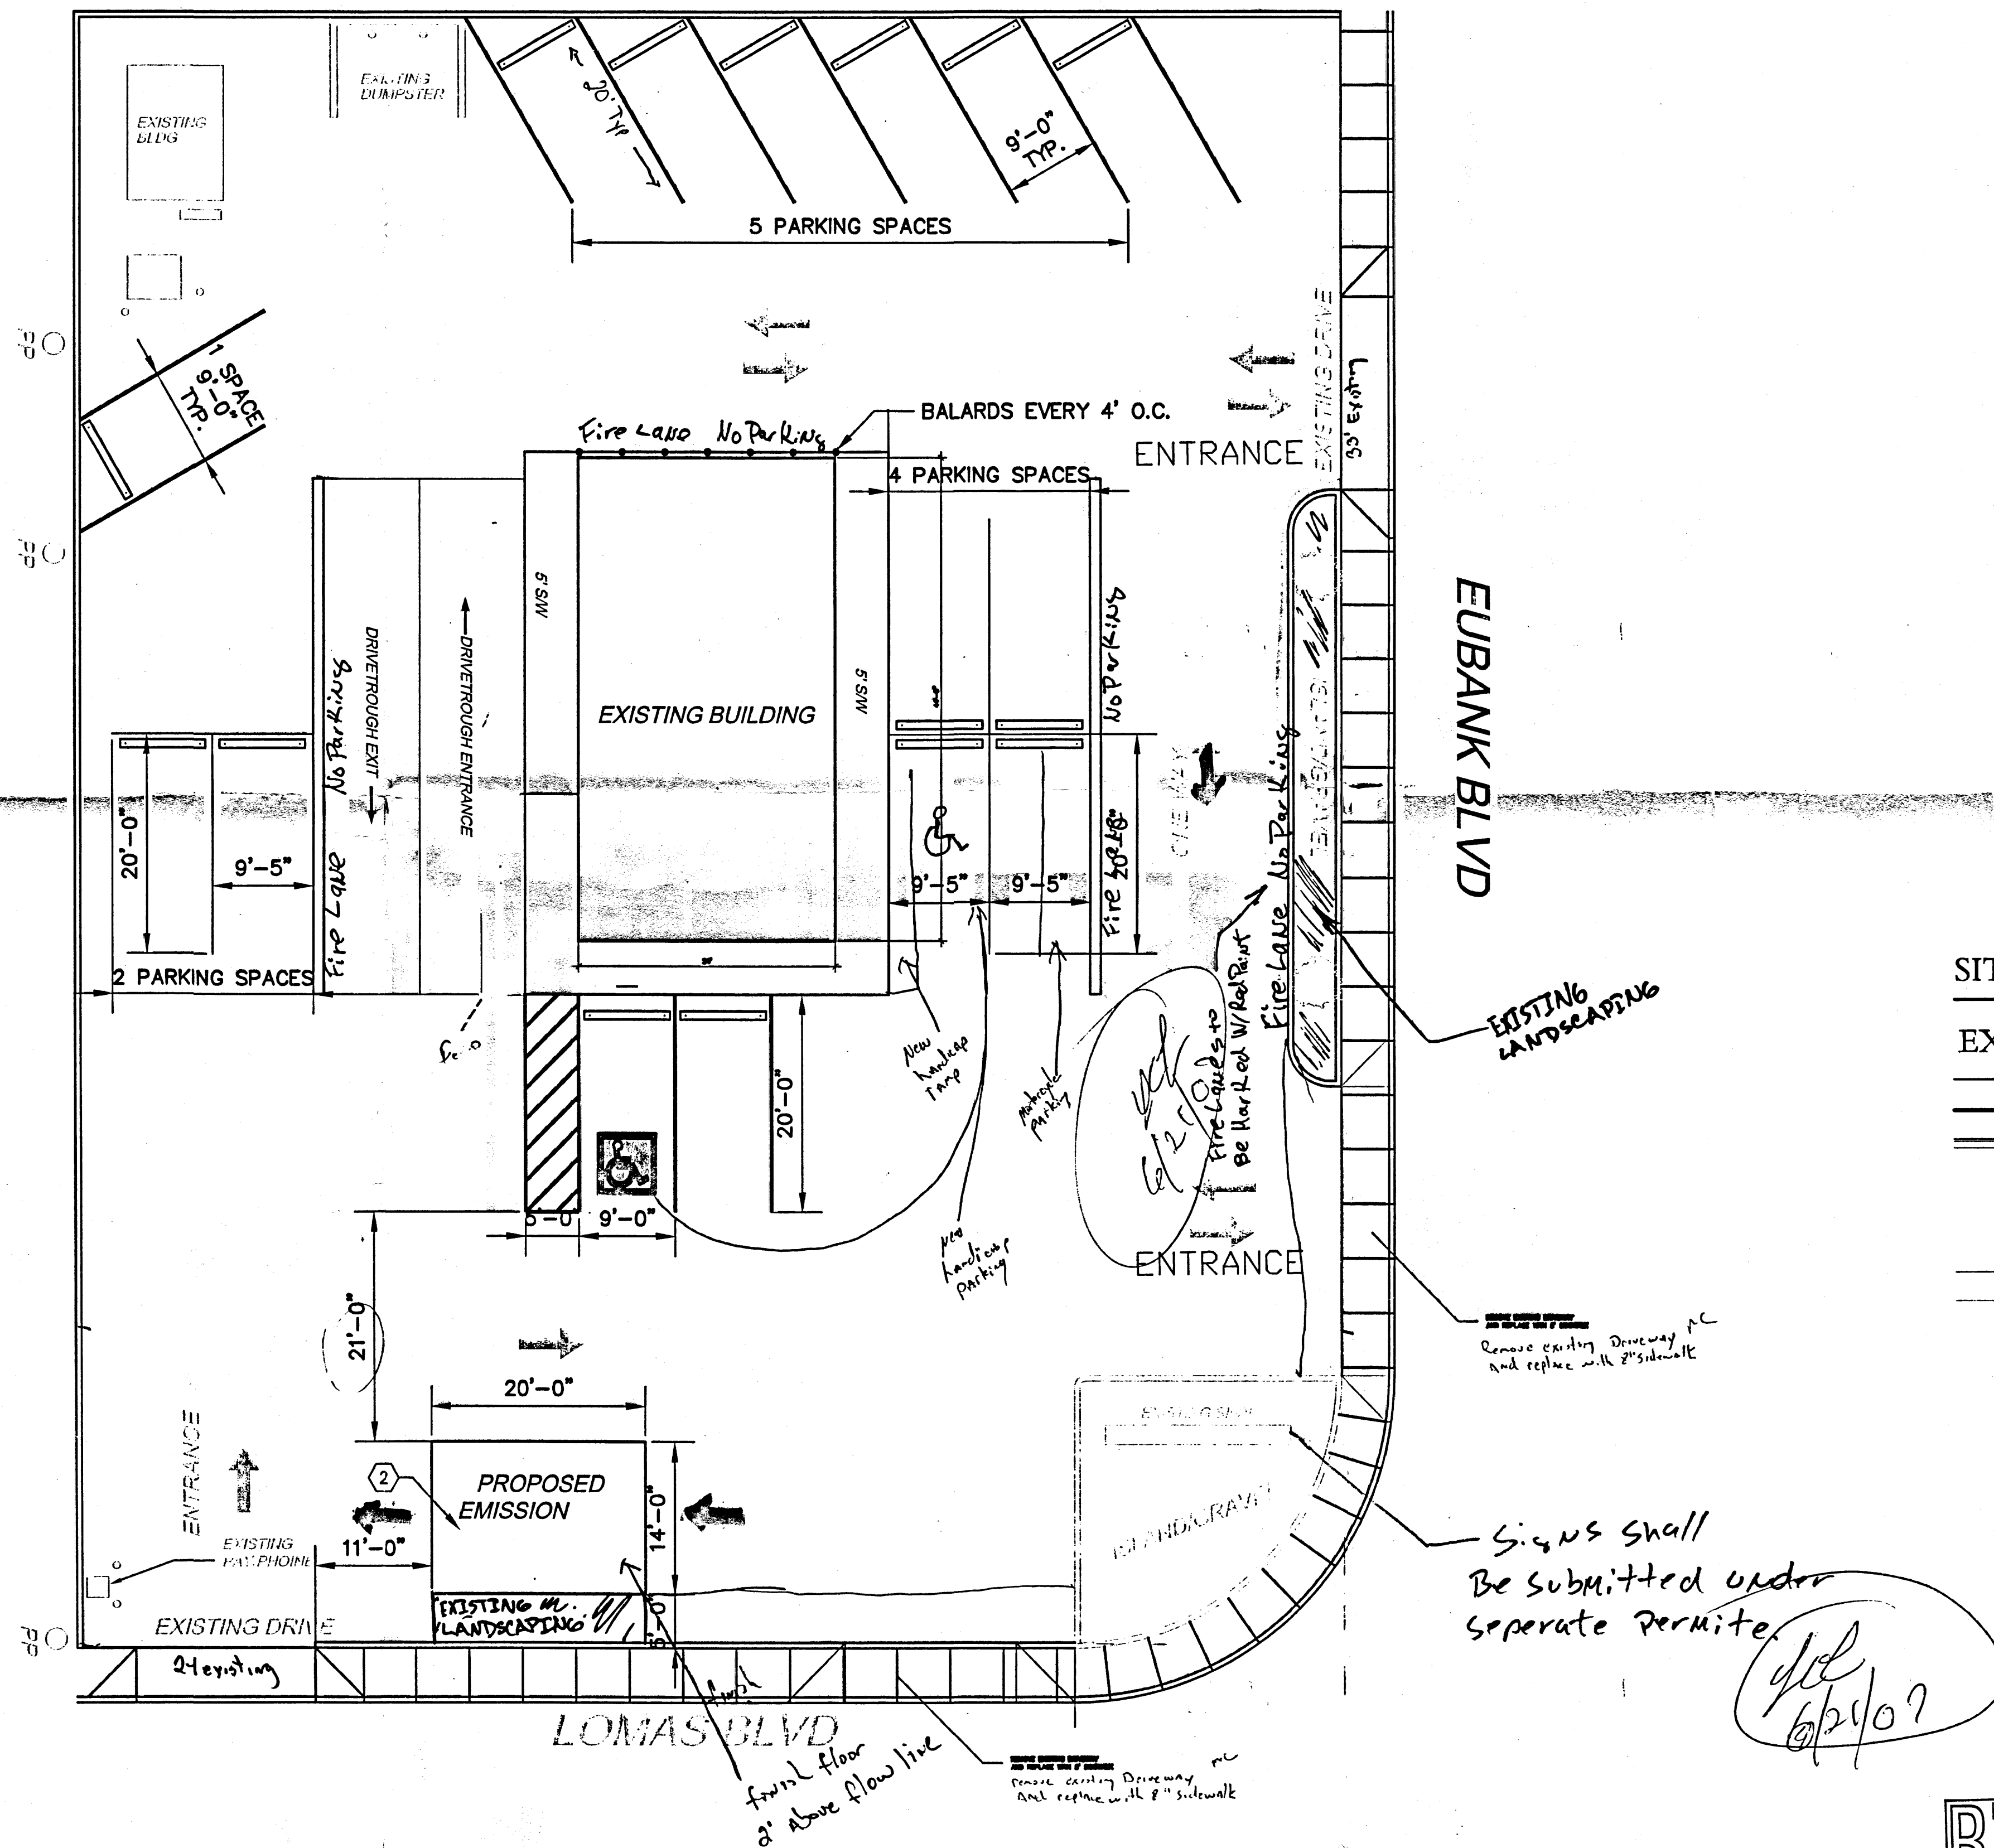

A1 NEW FLOOR PLAN
A2 ELEVATIONS
M1 MECHANICAL LAYOUT
P1 PLUMBING LAYOUT

E1 LIGHTING & POWER PLAN

A7 EMISSIONS FLOOR/FOUNDATION/FRAME
A8 ELEC/POWER/ELEVATION PLAN

0 10' 20' 40' 60'

SCALE: 1" = 10'

del
6/24/07

SCALE = 1" = 20'

