

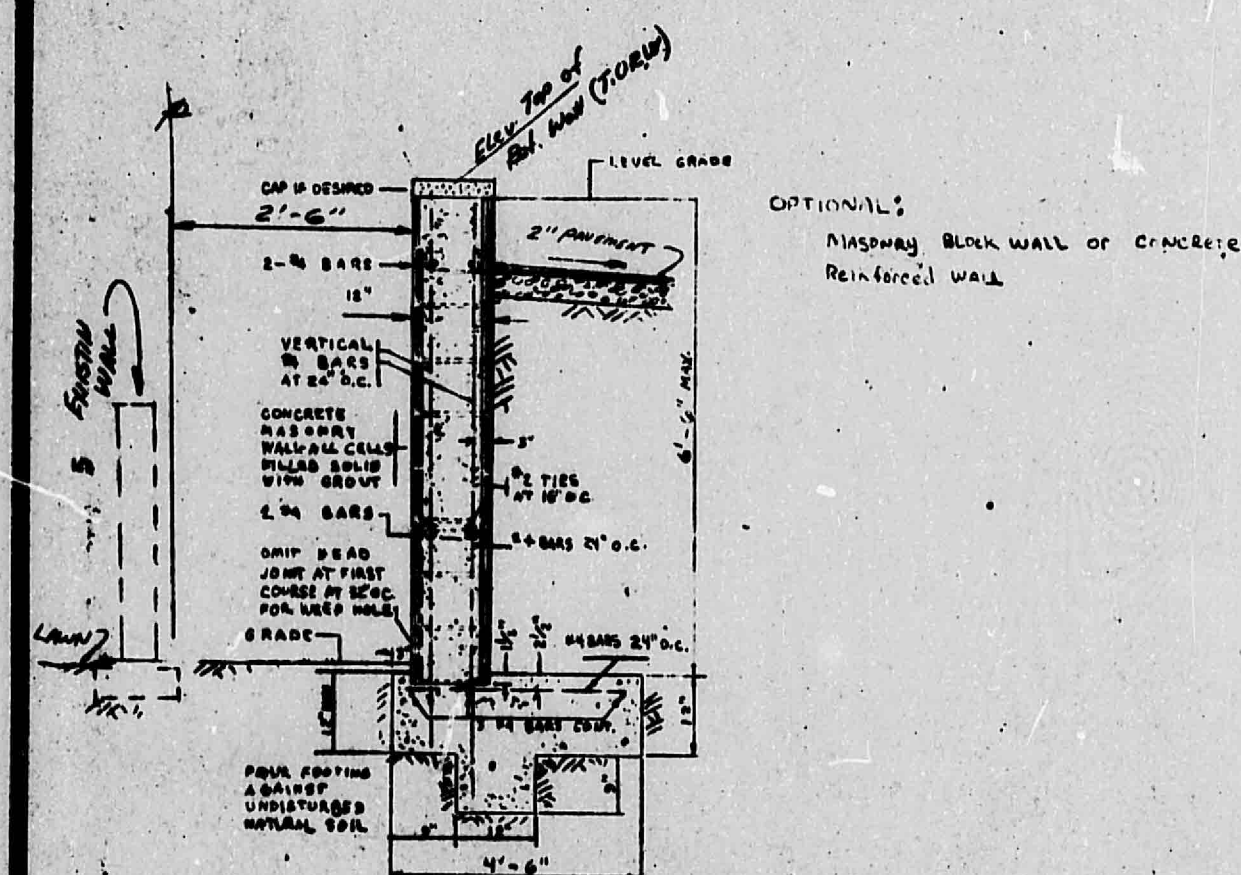
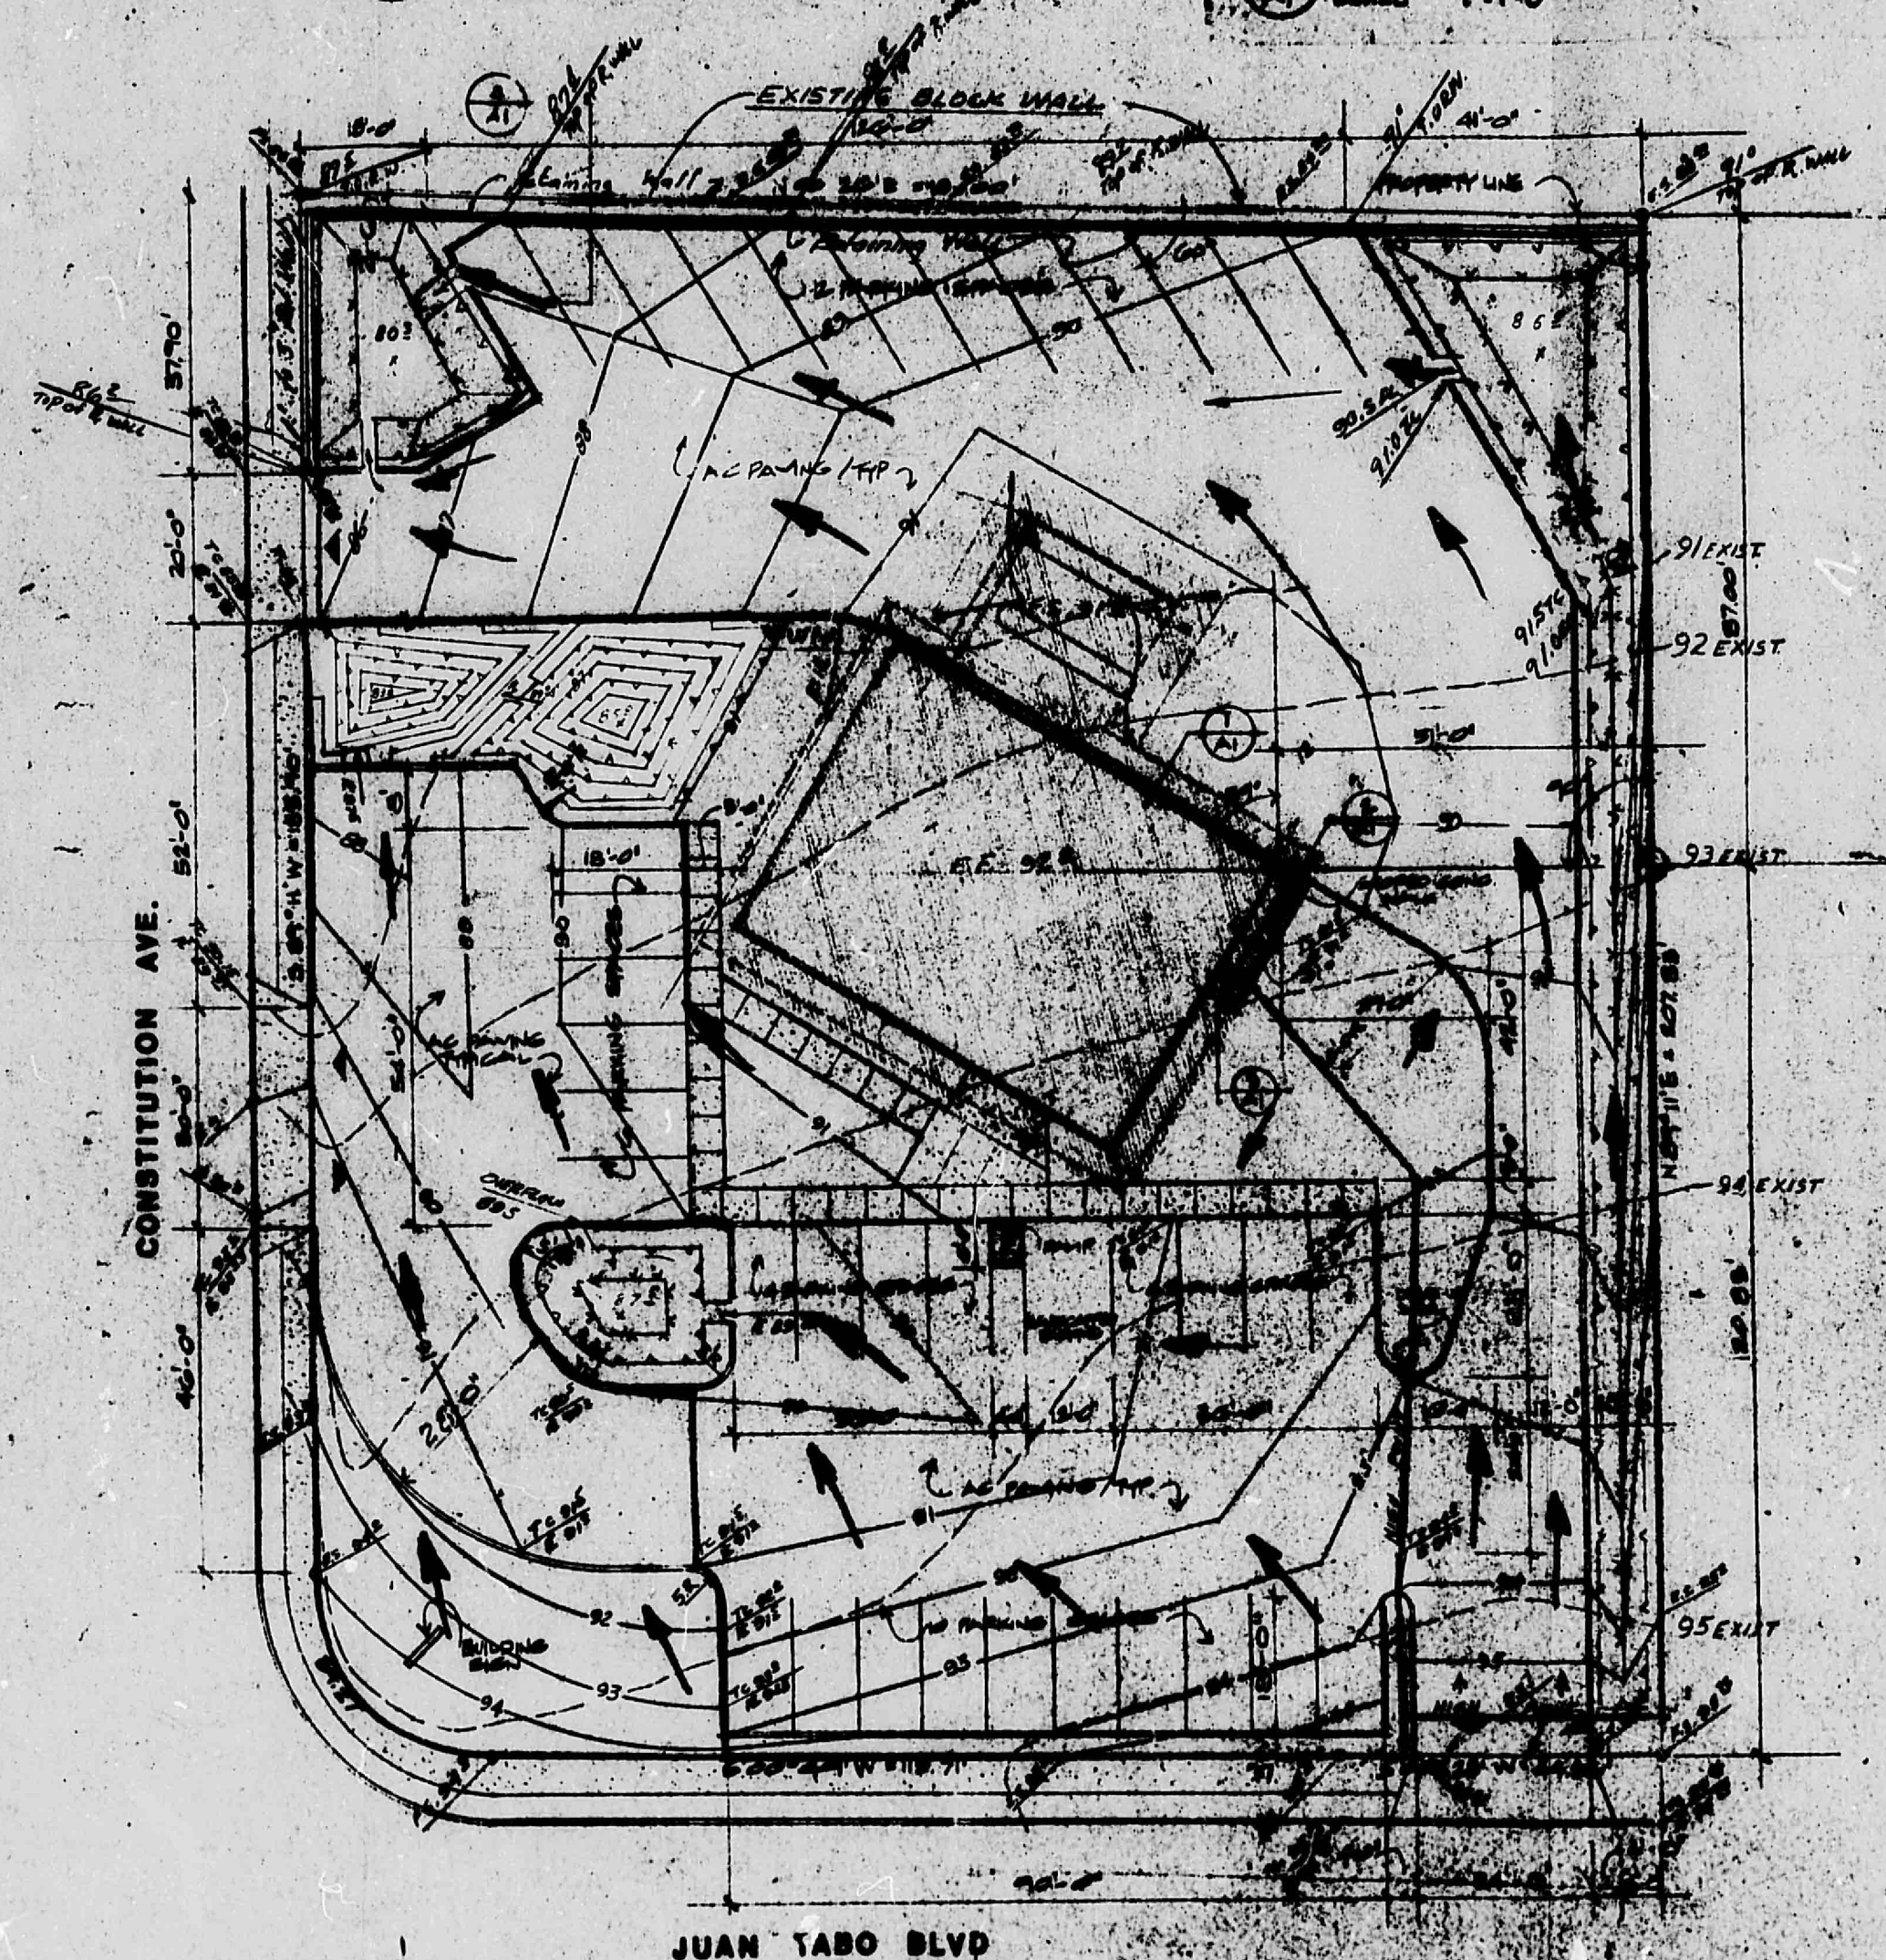
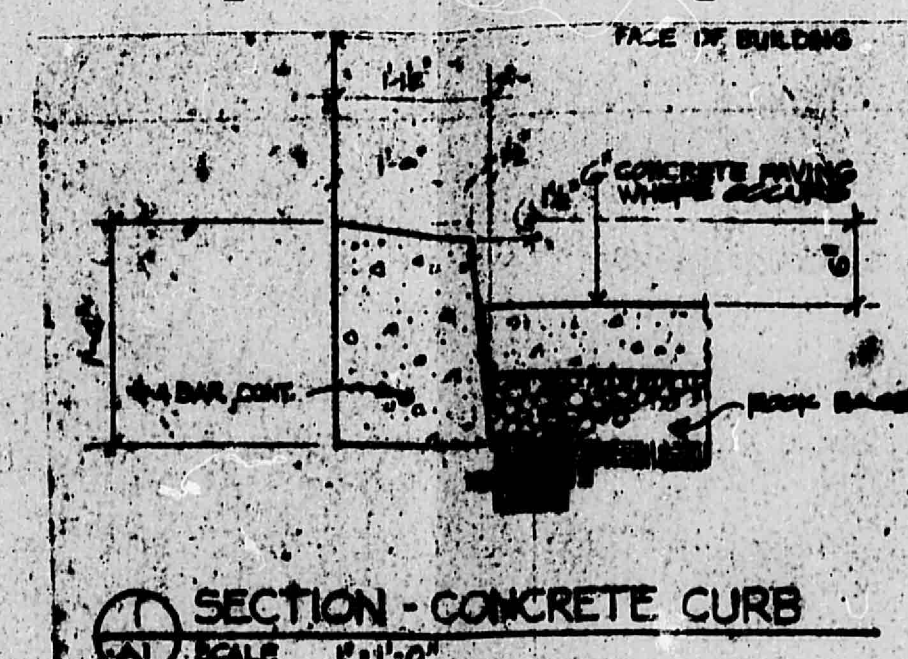


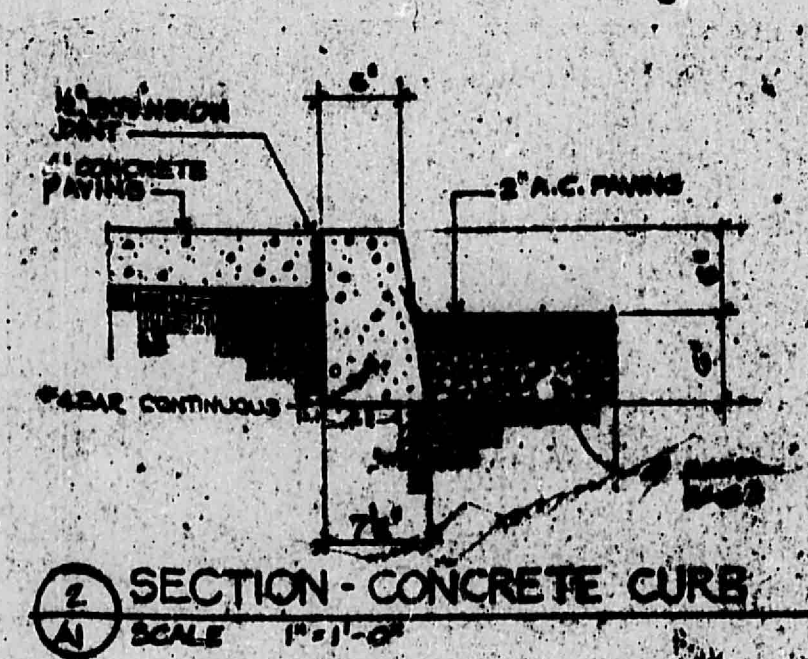


SECTION 4 - RETAINING WALL
SCALE 1" = 1'-0"

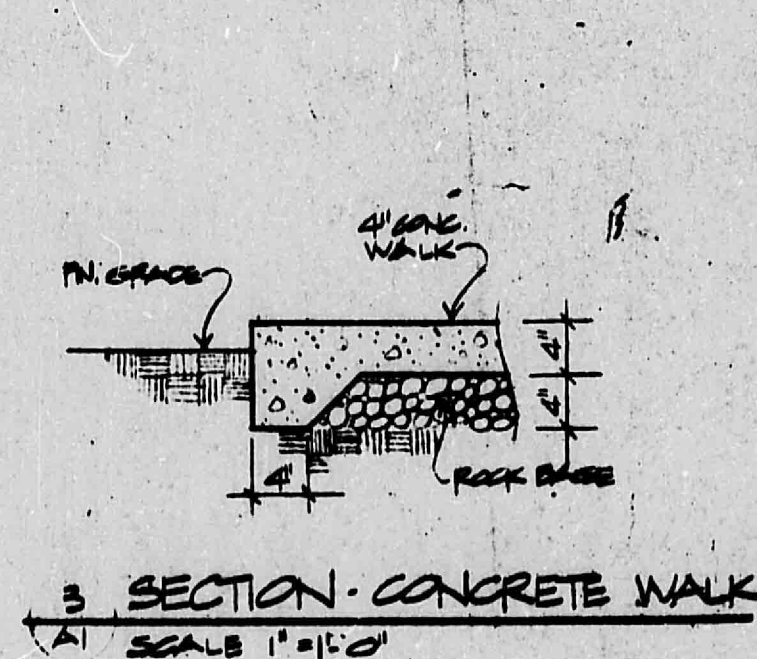

DRAINAGE PLAN
SCALE 1" = 1'-0"

A & E Engineering Inc.

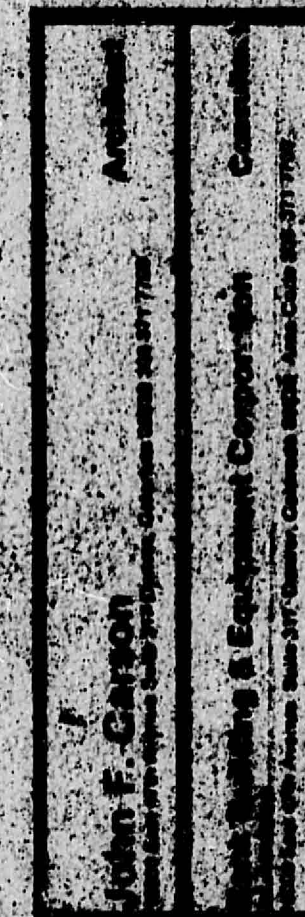

CITY OF ALBUQUERQUE
THIS MICROFILME IS THE BEST
POSSIBLE REPRODUCTION DUE
TO THE POOR QUALITY OF THE
ORIGINAL DOCUMENT

CITY OF ALBUQUERQUE