


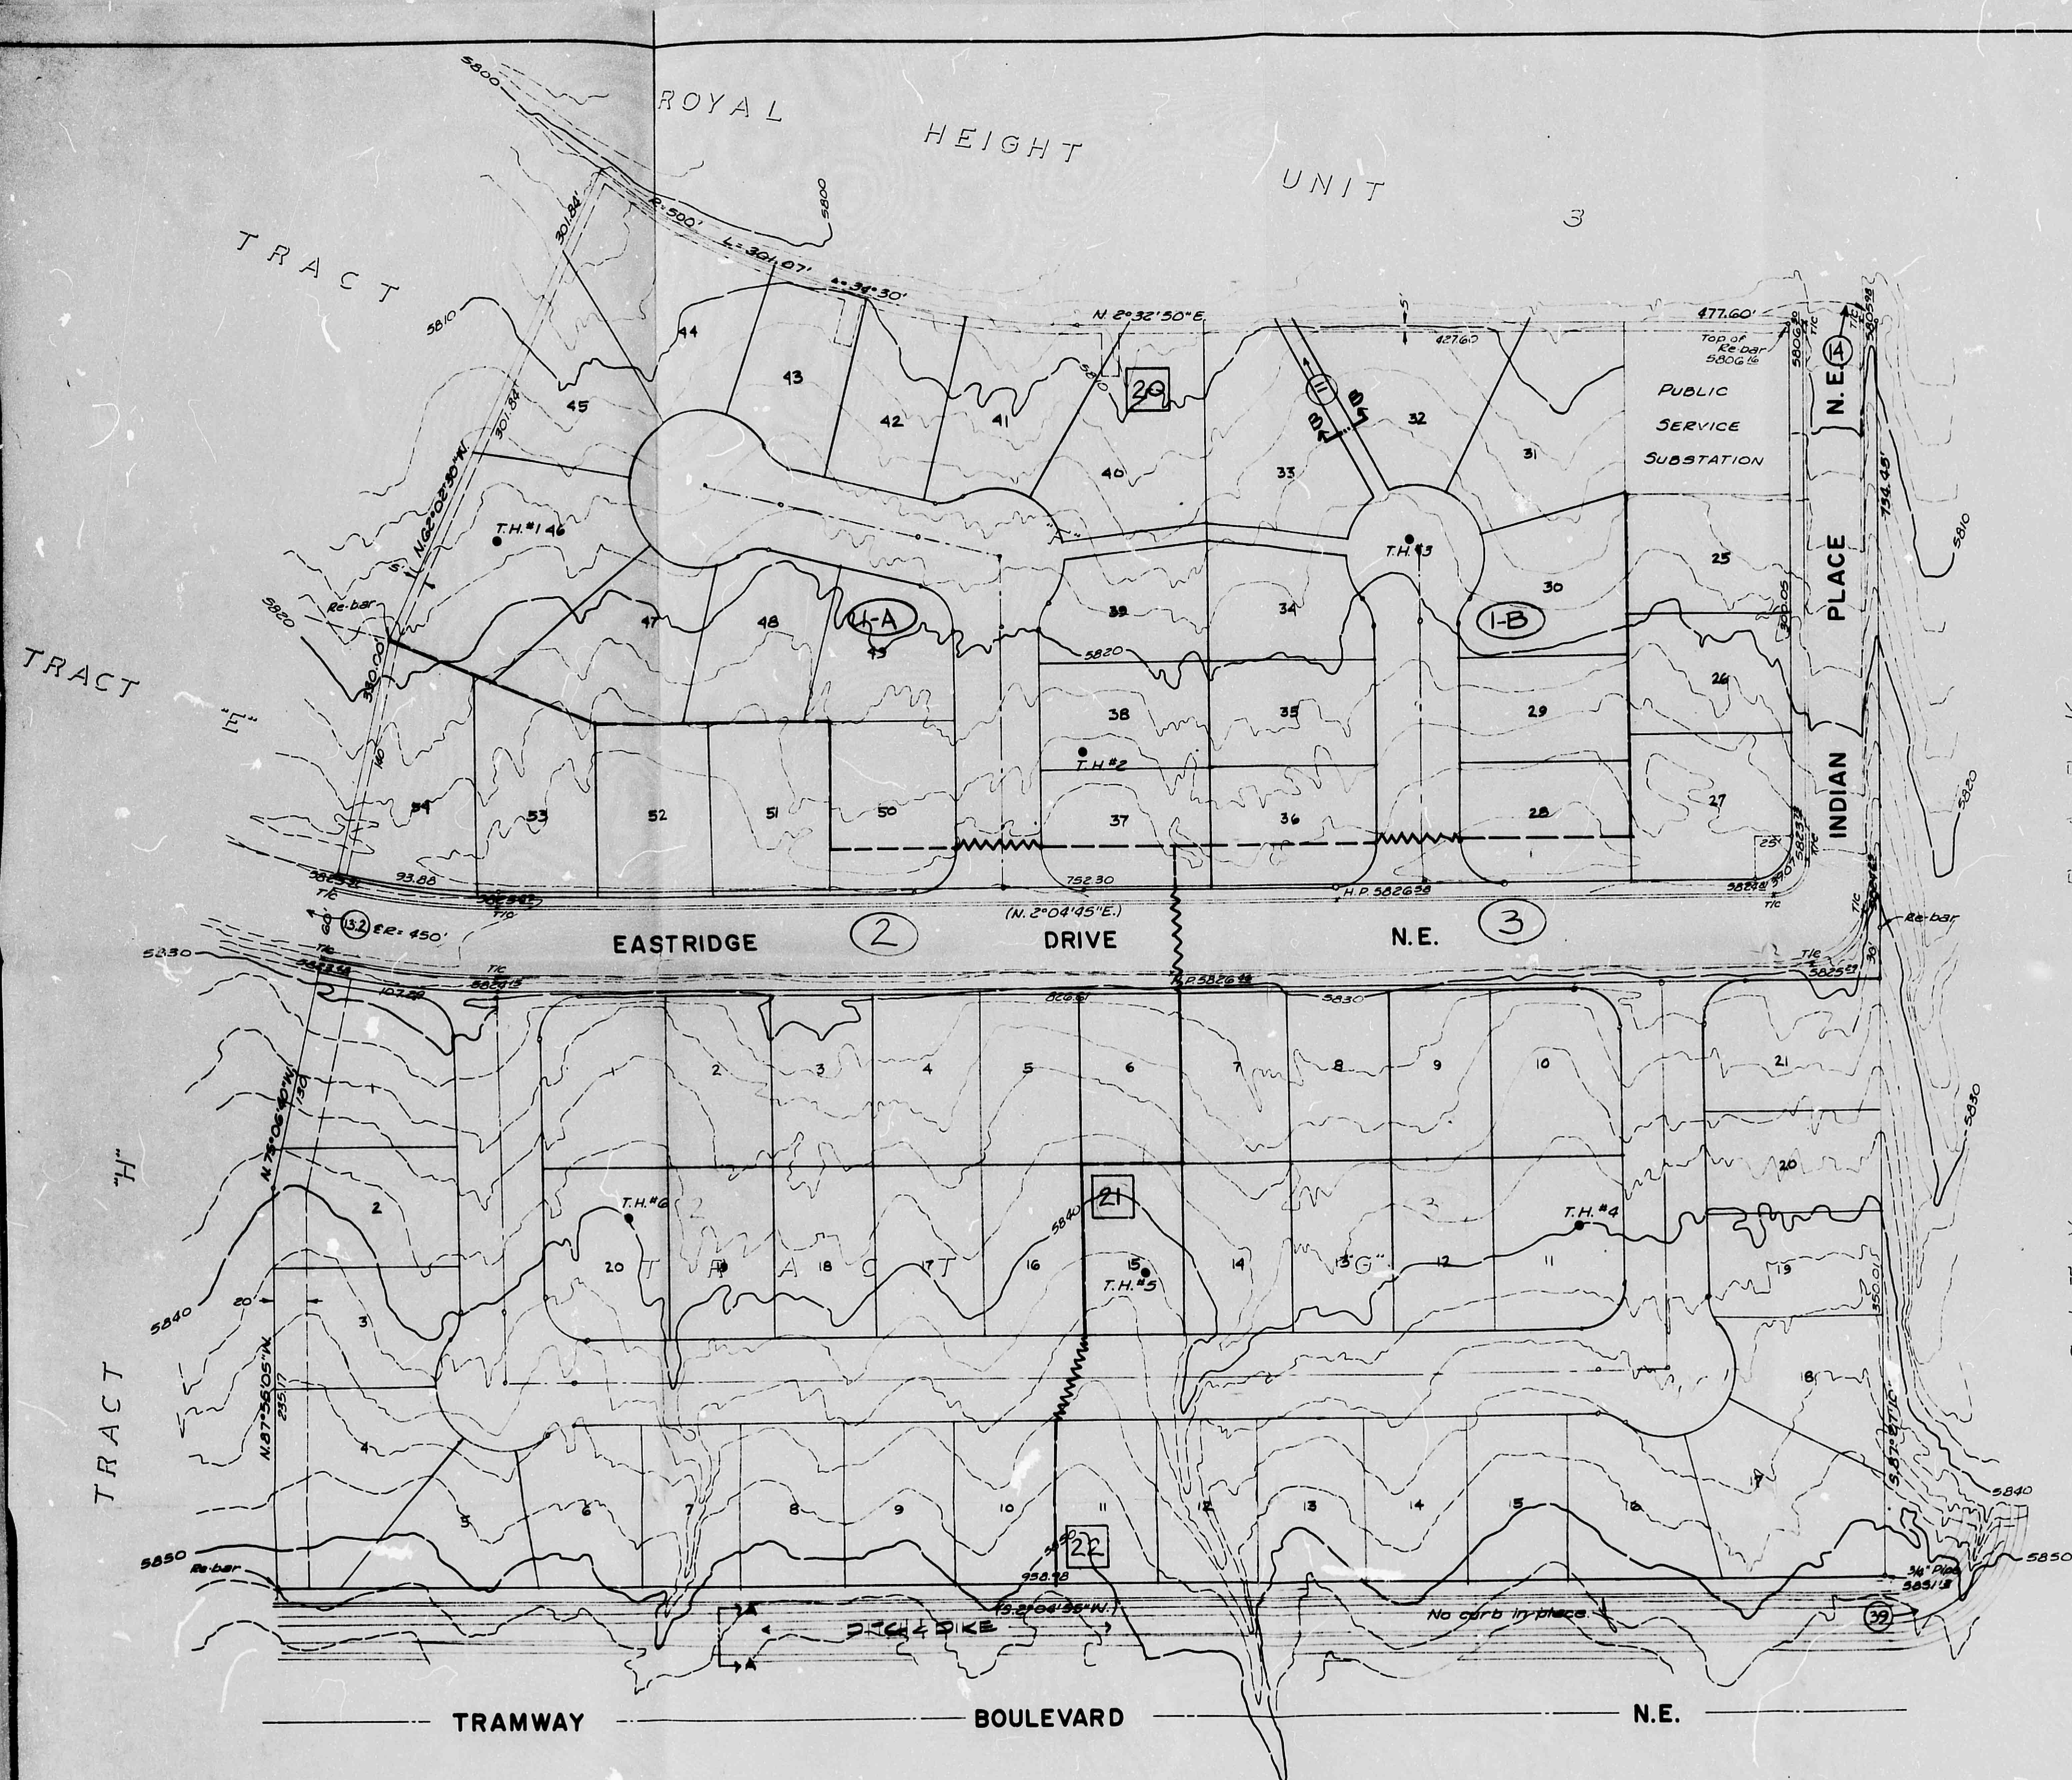

Scale: 1"=50'
Contour Interval: 2'

GENERAL NOTES:
 All elevations are City of Albuquerque datum. Topography by
 Koogle and Pauls Engineering, Inc.
 Sewer, water, and gas to be installed in streets.
 All utilities to be installed underground.

DRAINAGE PLAN
ROYAL HEIGHTS-UNIT 4
 ALBUQUERQUE, NEW MEXICO

RALPH K. HICKS & ASSOCIATES, INC.

Job No. 73-2-2

CITY OF ALBUQUERQUE
 THIS MICROFILM IS THE BEST
 POSSIBLE REPRODUCTION DUE
 TO THE POOR QUALITY OF THE
 ORIGINAL DOCUMENT

CITY OF ALBUQUERQUE

C

D

