

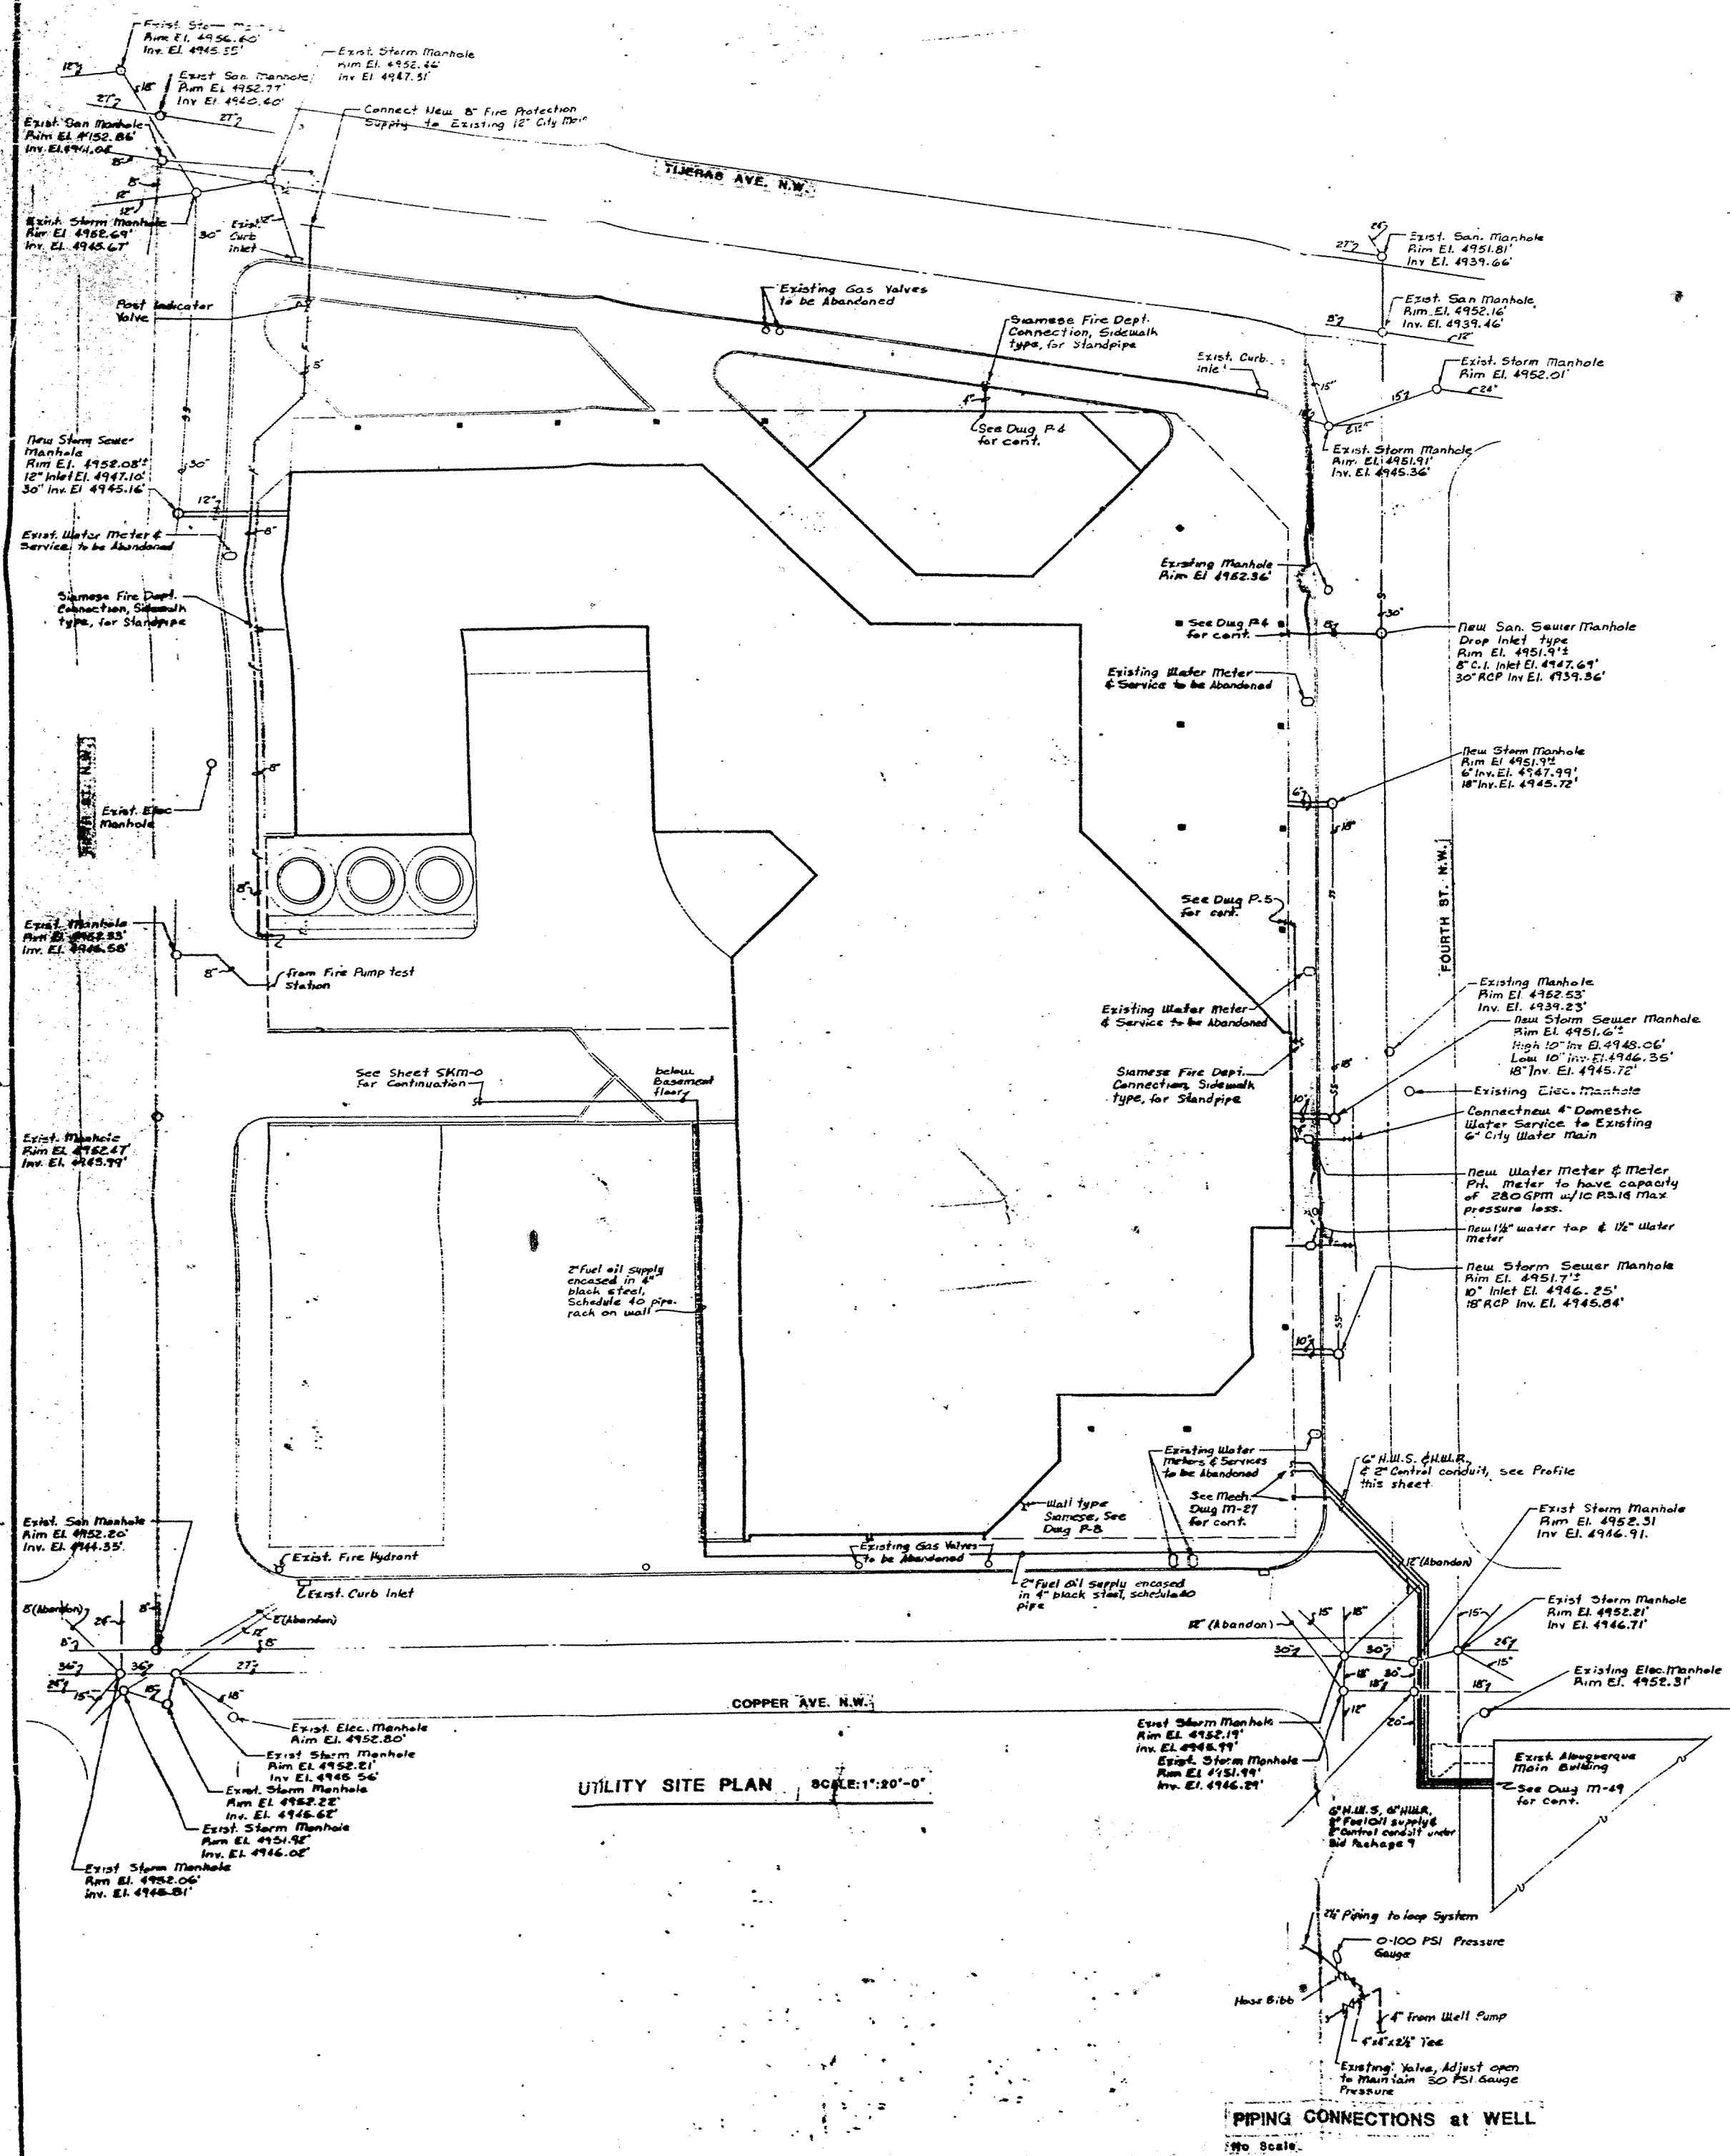


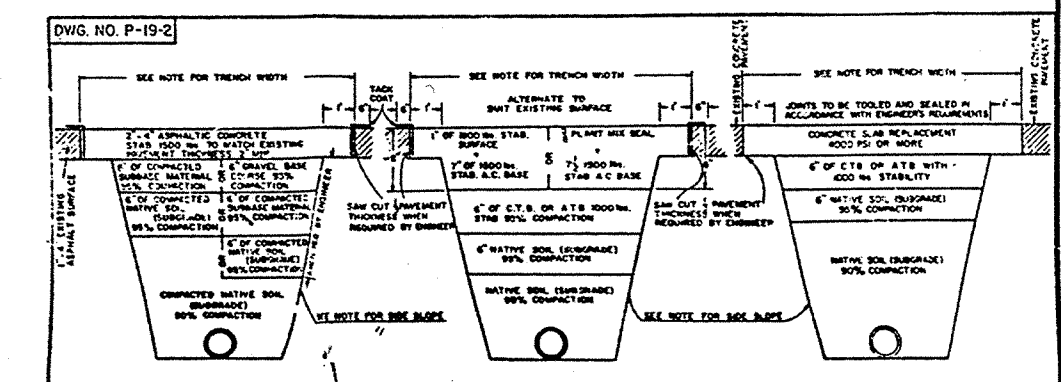

- LEGEND**
- Waste Piping
  - Sanitary Sewer
  - Vent Piping
  - Drainage Piping
  - Storm Sewer
  - Cold Water Piping
  - Hot Water Piping
  - Hot Water Return Piping
  - Fire Protection Piping
  - Gas Piping (Existing)

- C. Copper
- C.I. Cast Iron
- V. Vent
- C.O. Cleanout
- Inv. Invert
- EL. Elevation
- A.F.F. Above Finished Floor
- A.F.G. Above Finished Grade
- P.R.L. Pressure Relief Line
- Connection Point to Bid package 2
- P. Pressure Reducing Valve
- G.V. Gate Valve
- C.V. Check Valve
- U. Union
- P.I.V. Post Indicator Valve

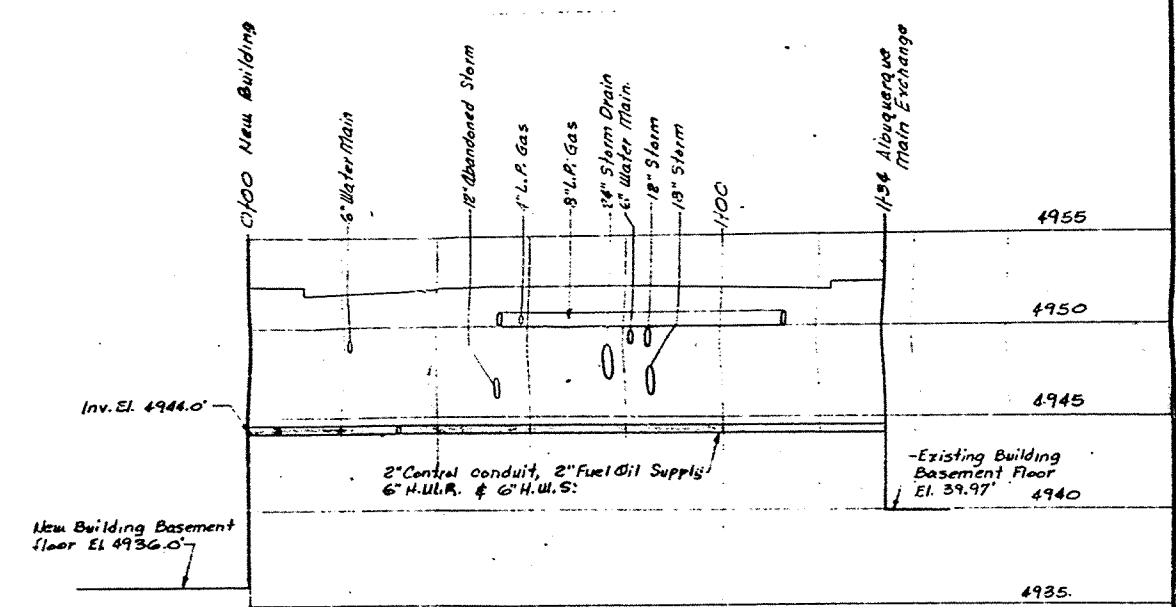

**NOTES**

- CONNECTION AT INTERSECTION OF 2" FUEL OIL SUPPLY TO 2" CENTRAL CONDUIT SHALL BE MADE IN ACCORDANCE WITH CITY ENGINEER'S REQUIREMENTS.
- ALL UTILITIES SHALL BE DEEPER THAN THE DEPTH SHOWN ON THIS PLAN.
- THE CITY ENGINEER SHALL BE NOTIFIED OF ANY CHANGES TO THE UTILITIES SHOWN ON THIS PLAN.
- ALL UTILITIES SHALL BE PROTECTED BY A MINIMUM OF 18" OF COVER.
- ALL UTILITIES SHALL BE PROTECTED BY A MINIMUM OF 18" OF COVER.

**Albuquerque, New Mexico**  
**PLAZA CAMPANA**  
**Area Processing And**  
**Accounting Center Project**

**Utilities Site Plan & Legend**

City of Albuquerque  
Engineering Department  
September 1990  
DWG. NO. P-19-2  
DESIGNED BY: STEVENS, MALLORY, PEARL & CAMPBELL  
CHECKED BY: CARROLL BOWLETT SCOTT  
DATE: 11-5-77  
APPROVED BY: [Signature]  
CITY OF ALBUQUERQUE  
Engineering Department  
September 1990  
DWG. NO. P-19-2  
DESIGNED BY: STEVENS, MALLORY, PEARL & CAMPBELL  
CHECKED BY: CARROLL BOWLETT SCOTT  
DATE: 11-5-77  
APPROVED BY: [Signature]