



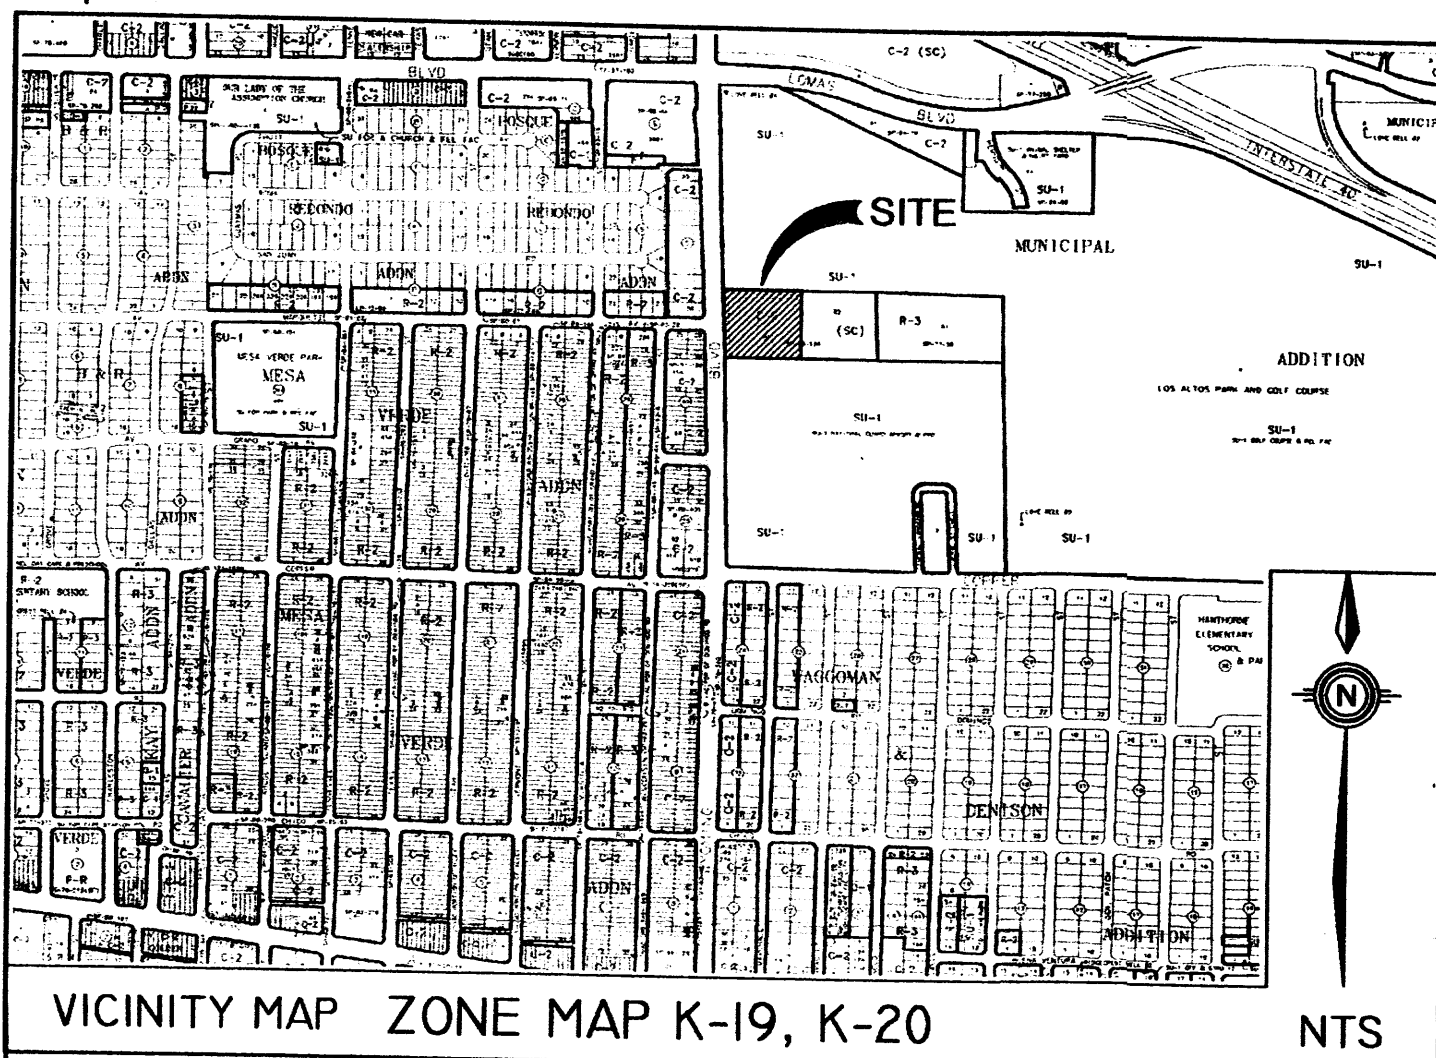

NOTES:




1. THE PURPOSE OF THIS PLAN IS FOR THE GRADING AND DRAINAGE OF THE BUILDING EXTENSION.
2. VERTICAL CONTROL BASED ON ACS 1.75" ALUMINUM DISK STAMPED "ACS BM, 22-K19", EPOXIED ON TOP OF THE CONCRETE CURB, AT CENTERLINE OF A DROP INLET, ON THE WEST SIDE OF WYOMING BLVD., 120 FT± NORTH OF CENTERLINE OF MARQUETTE AVE. NE

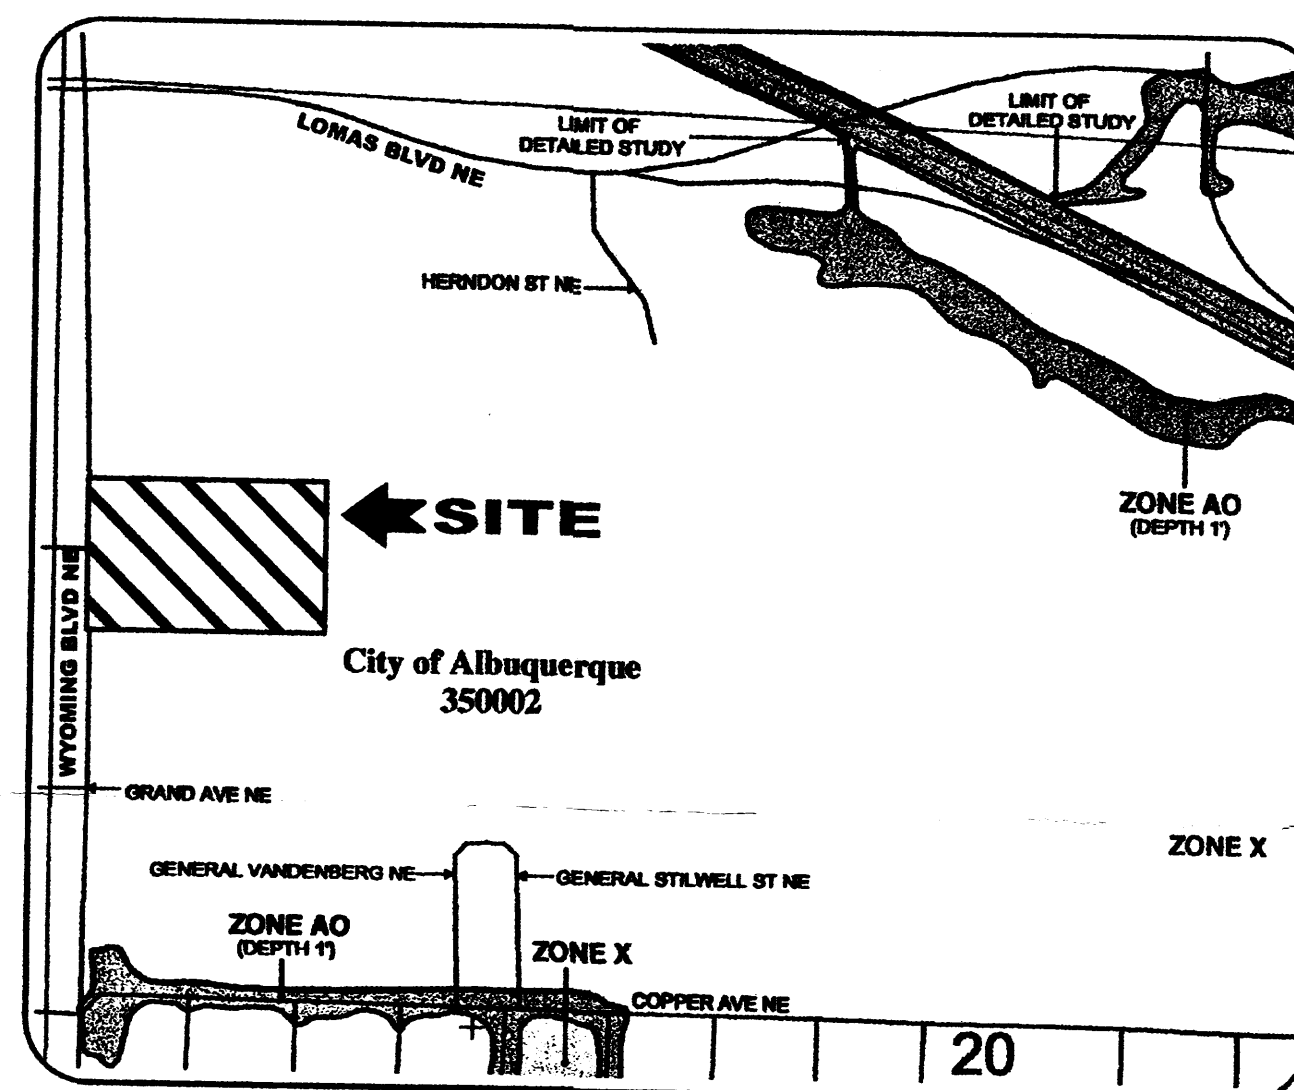

GRADING AND DRAINAGE PLAN
TRACT "B-1"
MUNICIPAL ADDITION NO. 2
SITUATE WITHIN
PROJECTED SECTION 20, T. 10 N., R. 4 E., N.M.P.M.
CITY OF ALBUQUERQUE
BERNALILLO COUNTY
STATE OF NEW MEXICO


LEGEND

- WATER METER
- FIRE HYDRANT
- WATER VALVE
- LIGHT POLE
- SIGN
- BOLLARD
- OVERHEAD UTILITY LINE
- NATURAL GROUND ELEVATION
- BACK OF CURB ELEVATION
- FLOWLINE ELEVATION
- TOP OF ASPHALT ELEVATION
- CHAIN LINK FENCE
- ELECTRIC METER
- UTILITY VAULT
- SANITARY SEWER MANHOLE
- STORM DRAIN MANHOLE
- DROP INLET
- CLEAN OUT
- RAIL FENCE
- STANDARD CURB & GUTTER
- GATE (TYP)
- EXISTING SWALE FLOWLINE
- PROPOSED SWALE FLOWLINE
- PROPOSED SWALE FLOWLINE ELEVATION
- FLOW ARROWS
- FOUND MONUMENT

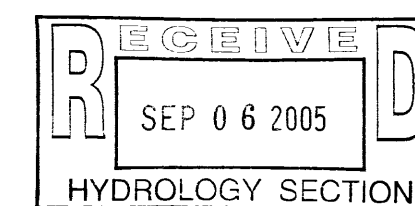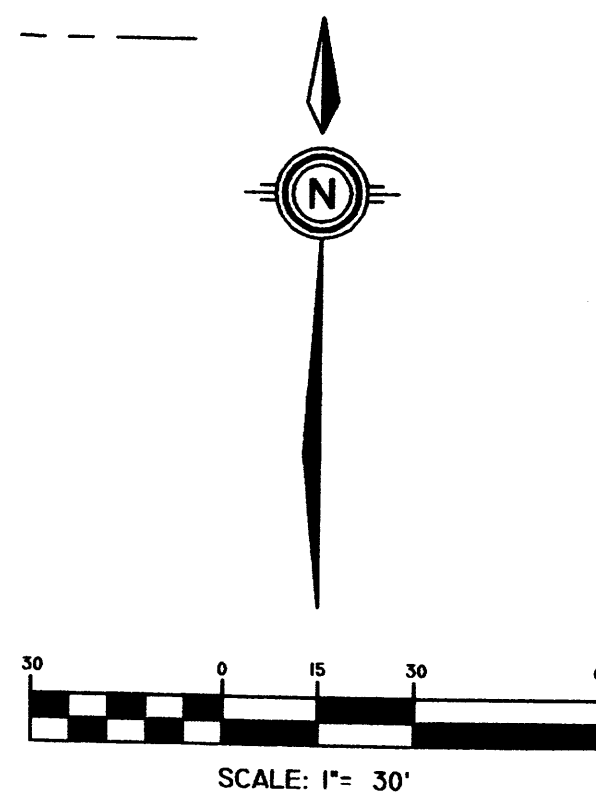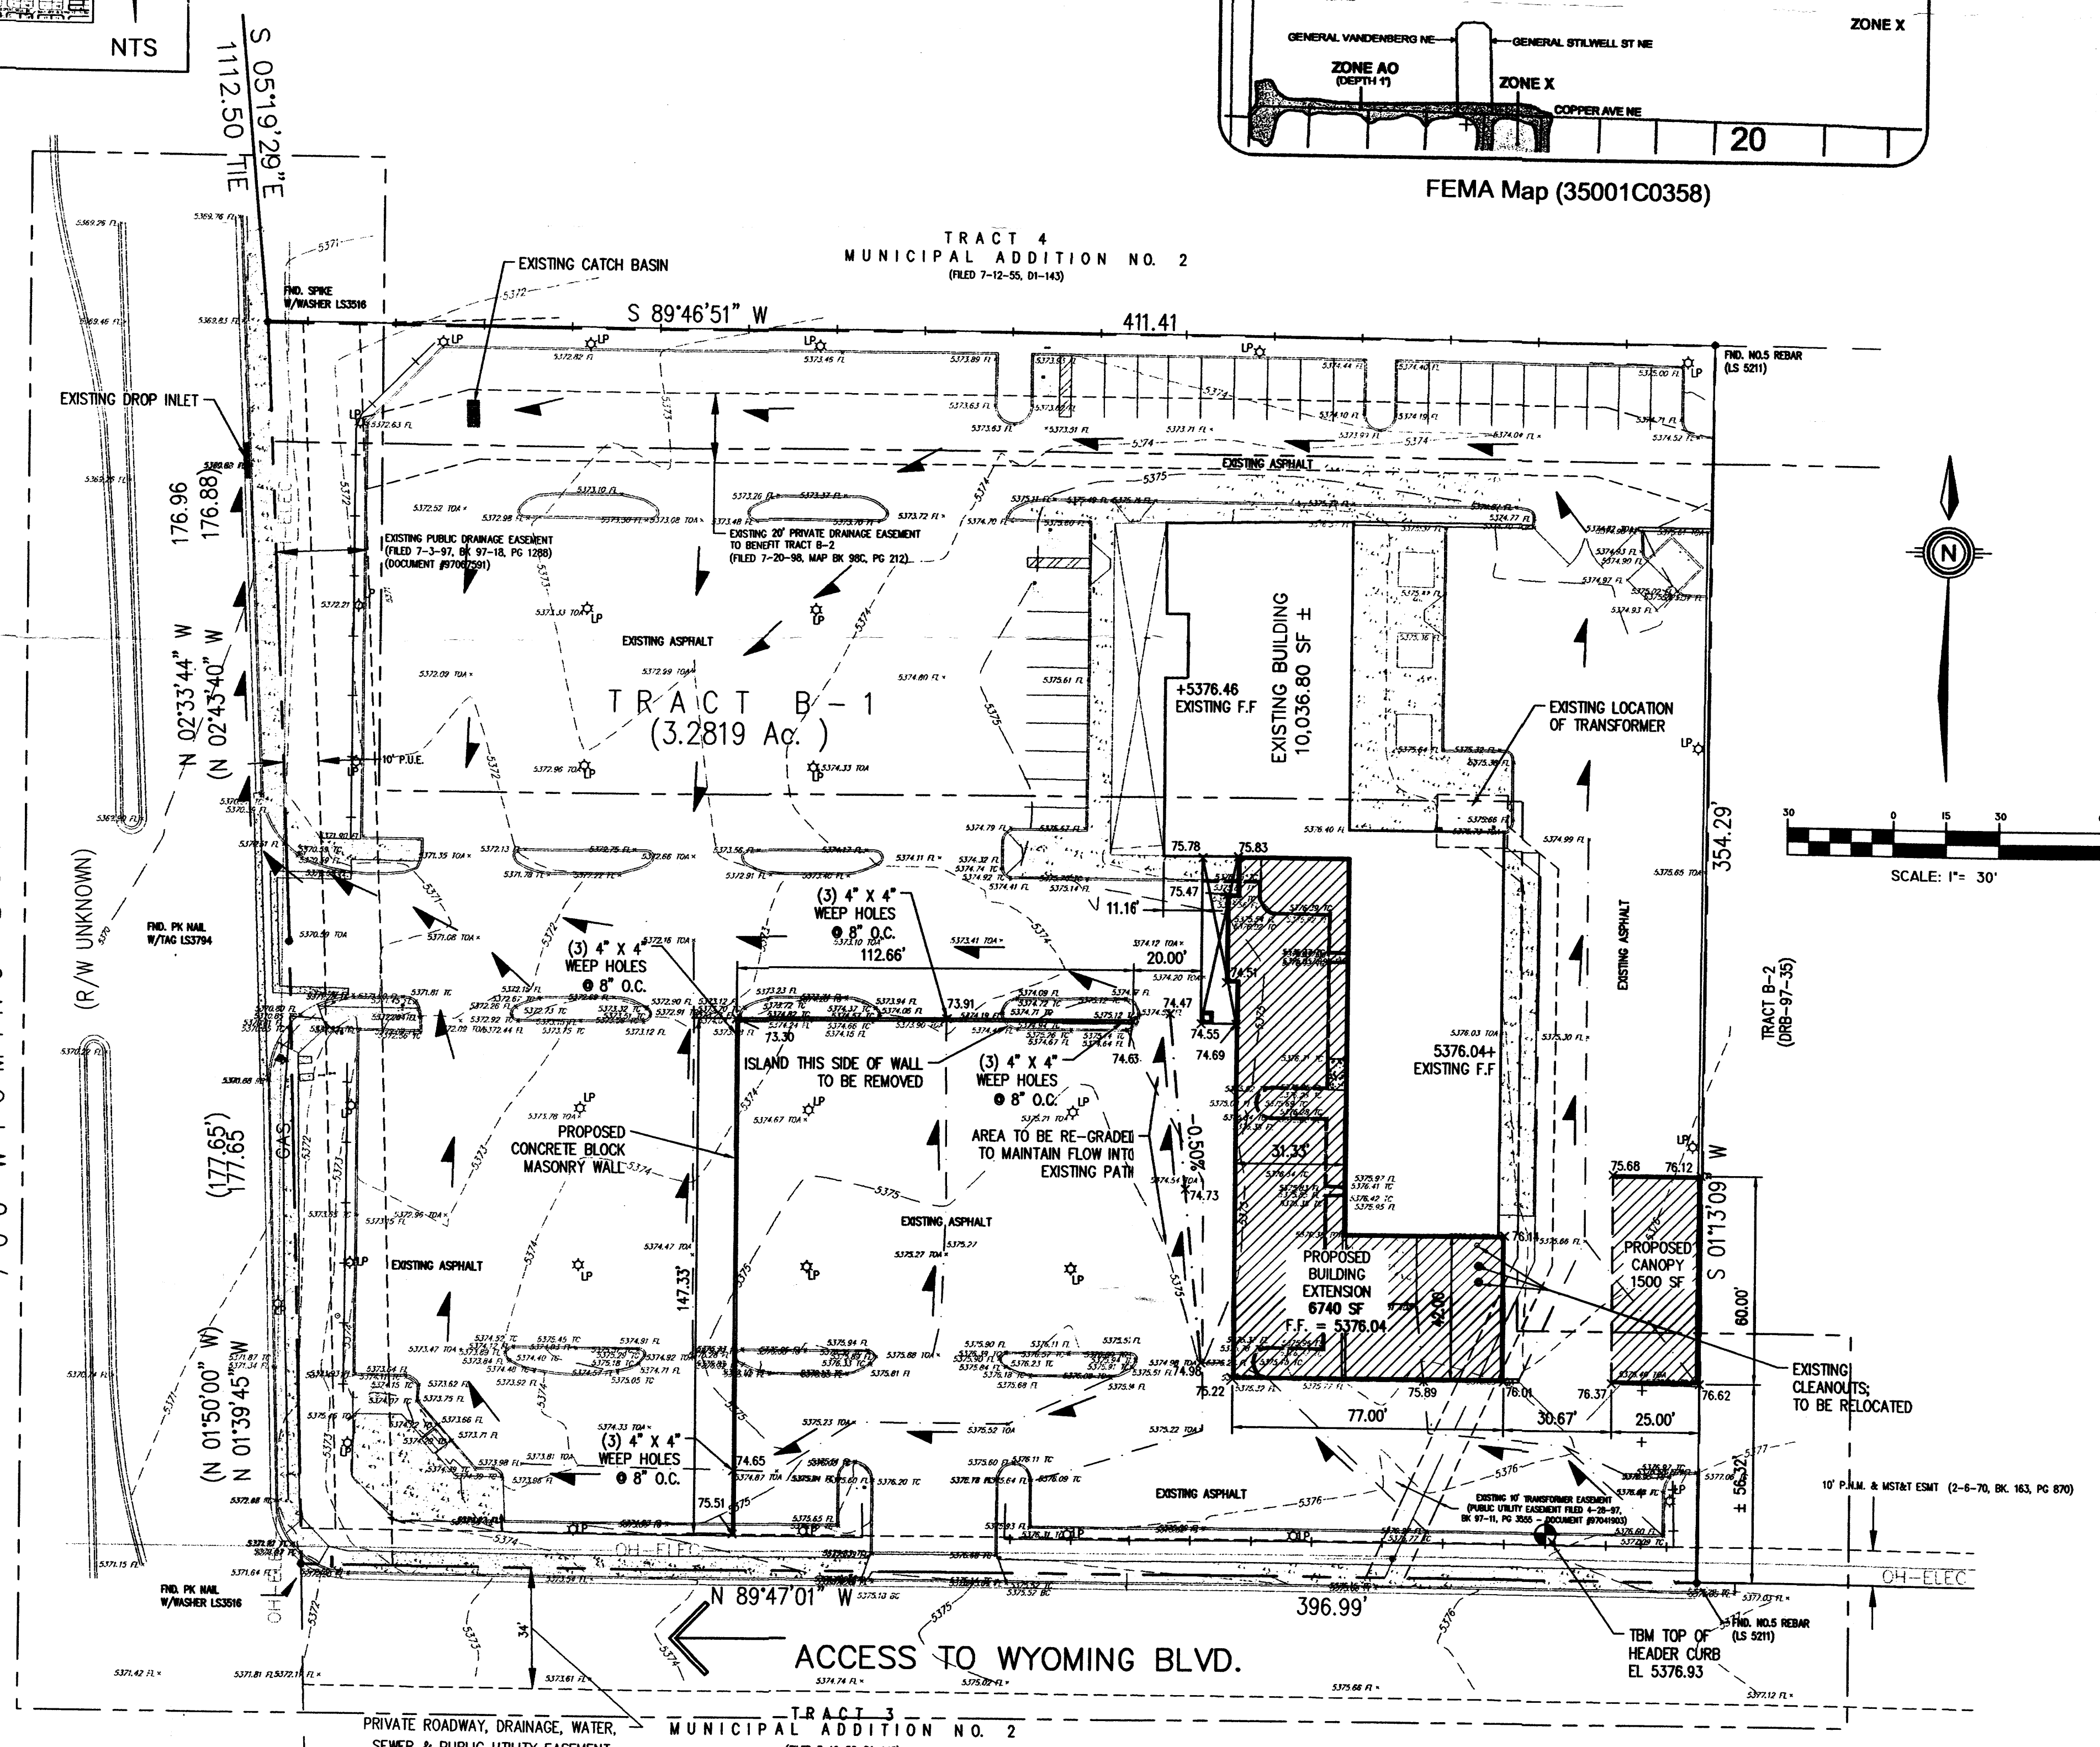


Community
Sciences
Corporation
LAND PLANNING ENGINEERING SURVEYING
P.O. Box 1328 Corrales, New Mexico 87048
JOB NO.: N726-02

CITY OF ALBUQUERQUE PLANNING DEPARTMENT HYDROLOGY DEVELOPMENT SECTION			
TITLE: DRIVETIME ADDITION GRADING & DRAINAGE PLAN			
Design Review Committee	City Engineer Approval	Mo./Day/Yr	Mo./Day/Yr
City Project No.	Zone Map No.	Sheet	of
N/A	K-20	1	1

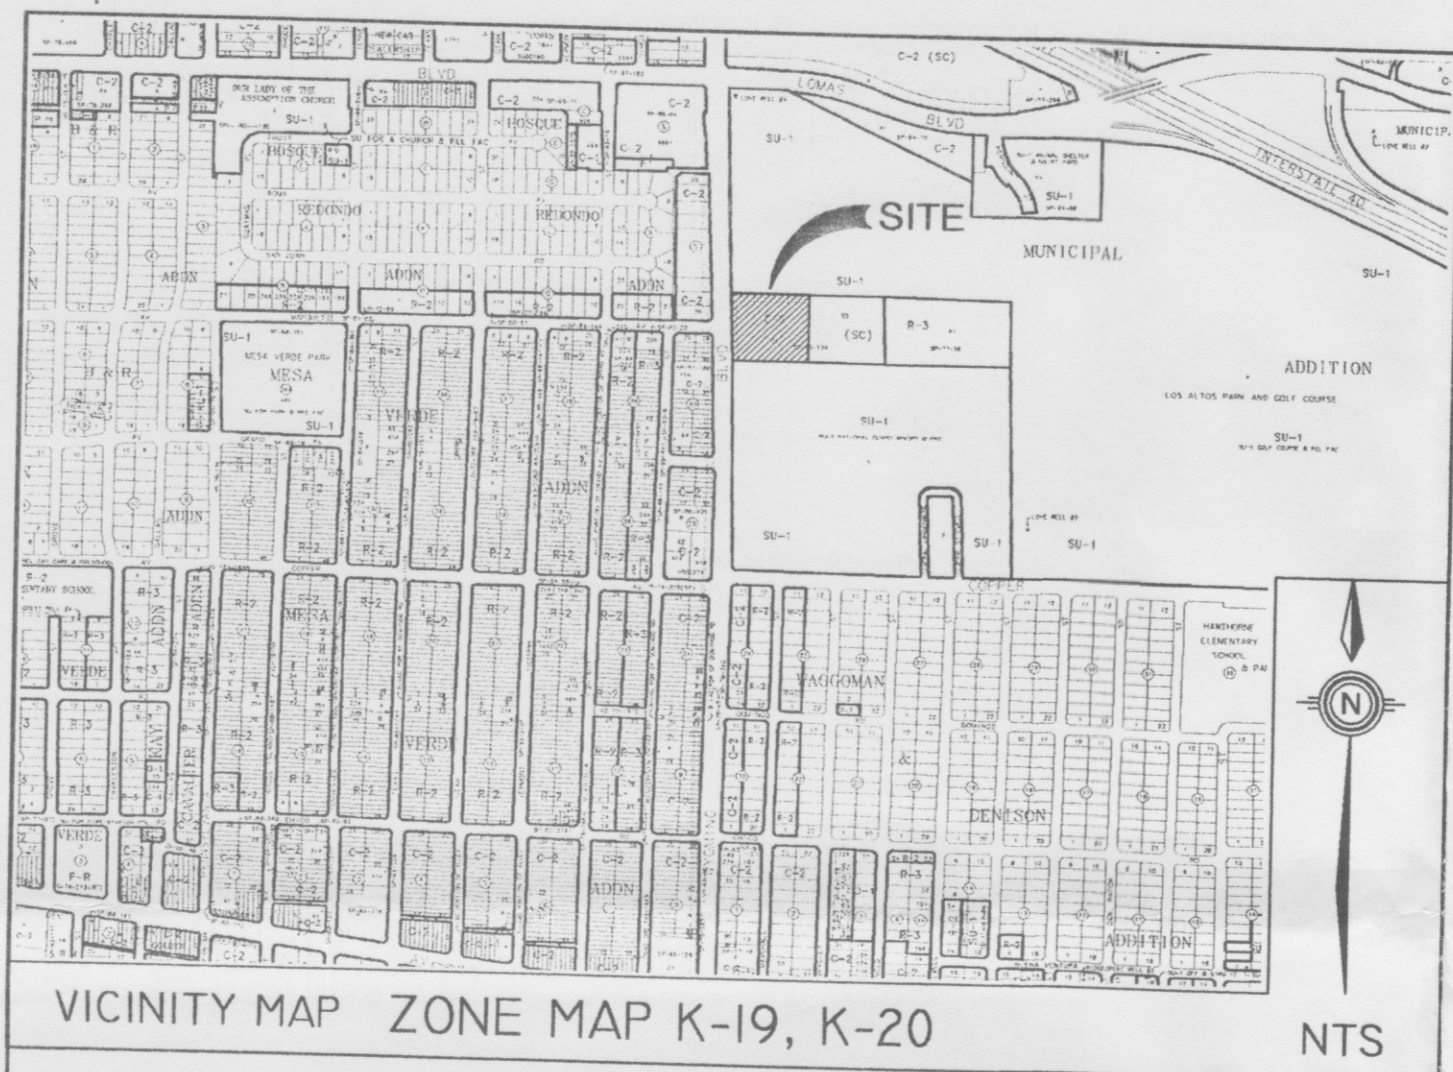

NOTES:

1. THE PURPOSE OF THIS PLAN IS FOR THE GRADING AND DRAINAGE OF THE BUILDING EXTENSION.
2. VERTICAL CONTROL BASED ON ACS 1.75" ALUMINUM DISK STAMPED "ACS BM, 22-K19", EPOXIED ON TOP OF THE CONCRETE CURB, AT CENTERLINE OF A DROP INLET, ON THE WEST SIDE OF WYOMING BLVD., 120 FT± NORTH OF CENTERLINE OF MARQUETTE AVE. NE

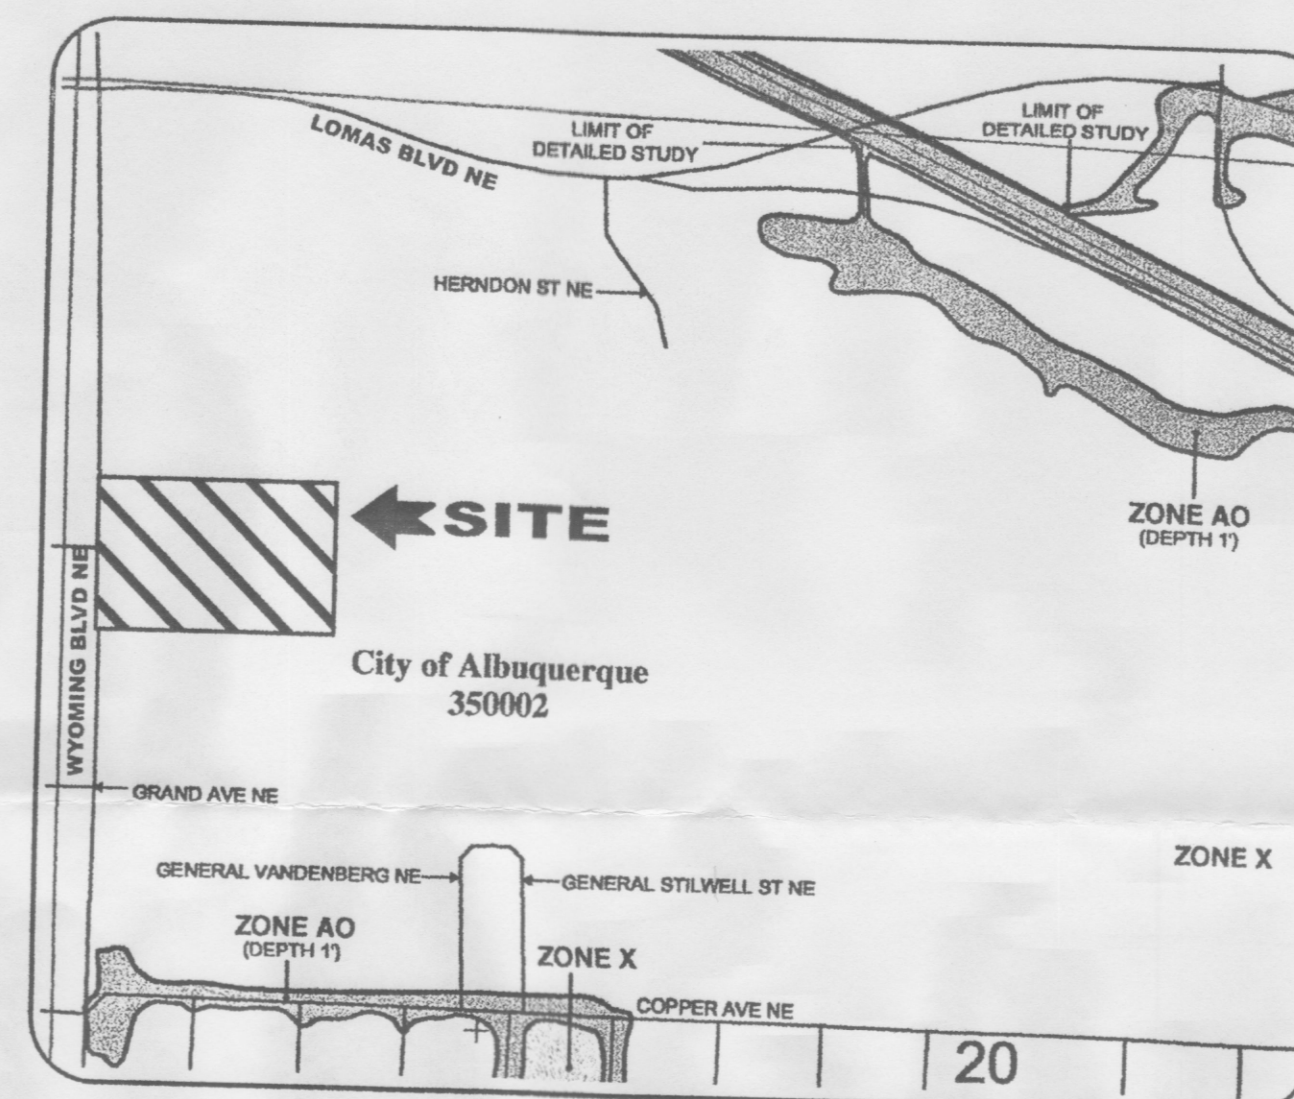


GRADING AND DRAINAGE PLAN TRACT "B-1" MUNICIPAL ADDITION NO. 2 SITUATE WITHIN PROJECTED SECTION 20, T. 10 N., R. 4 E., N.M.P.M. CITY OF ALBUQUERQUE BERNALILLO COUNTY STATE OF NEW MEXICO

LEGEND

- WATER METER
- FIRE HYDRANT
- WATER VALVE
- LIGHT POLE
- SIGN
- BOLLARD
- OVERHEAD UTILITY LINE
- NATURAL GROUND ELEVATION
- BACK OF CURB ELEVATION
- FLOWLINE ELEVATION
- TOP OF ASPHALT ELEVATION
- CHAIN LINK FENCE
- ELECTRIC METER
- UTILITY VAULT
- SANITARY SEWER MANHOLE
- STORM DRAIN MANHOLE
- DROP INLET
- CLEAN OUT
- RAIL FENCE
- STANDARD CURB & GUTTER
- GATE (TYP)
- EXISTING SWALE FLOWLINE
- PROPOSED SWALE FLOWLINE
- PROPOSED SWALE FLOWLINE ELEVATION
- FLOW ARROWS
- FOUND MONUMENT

700 WYOMING BOULEVARD, N.E.

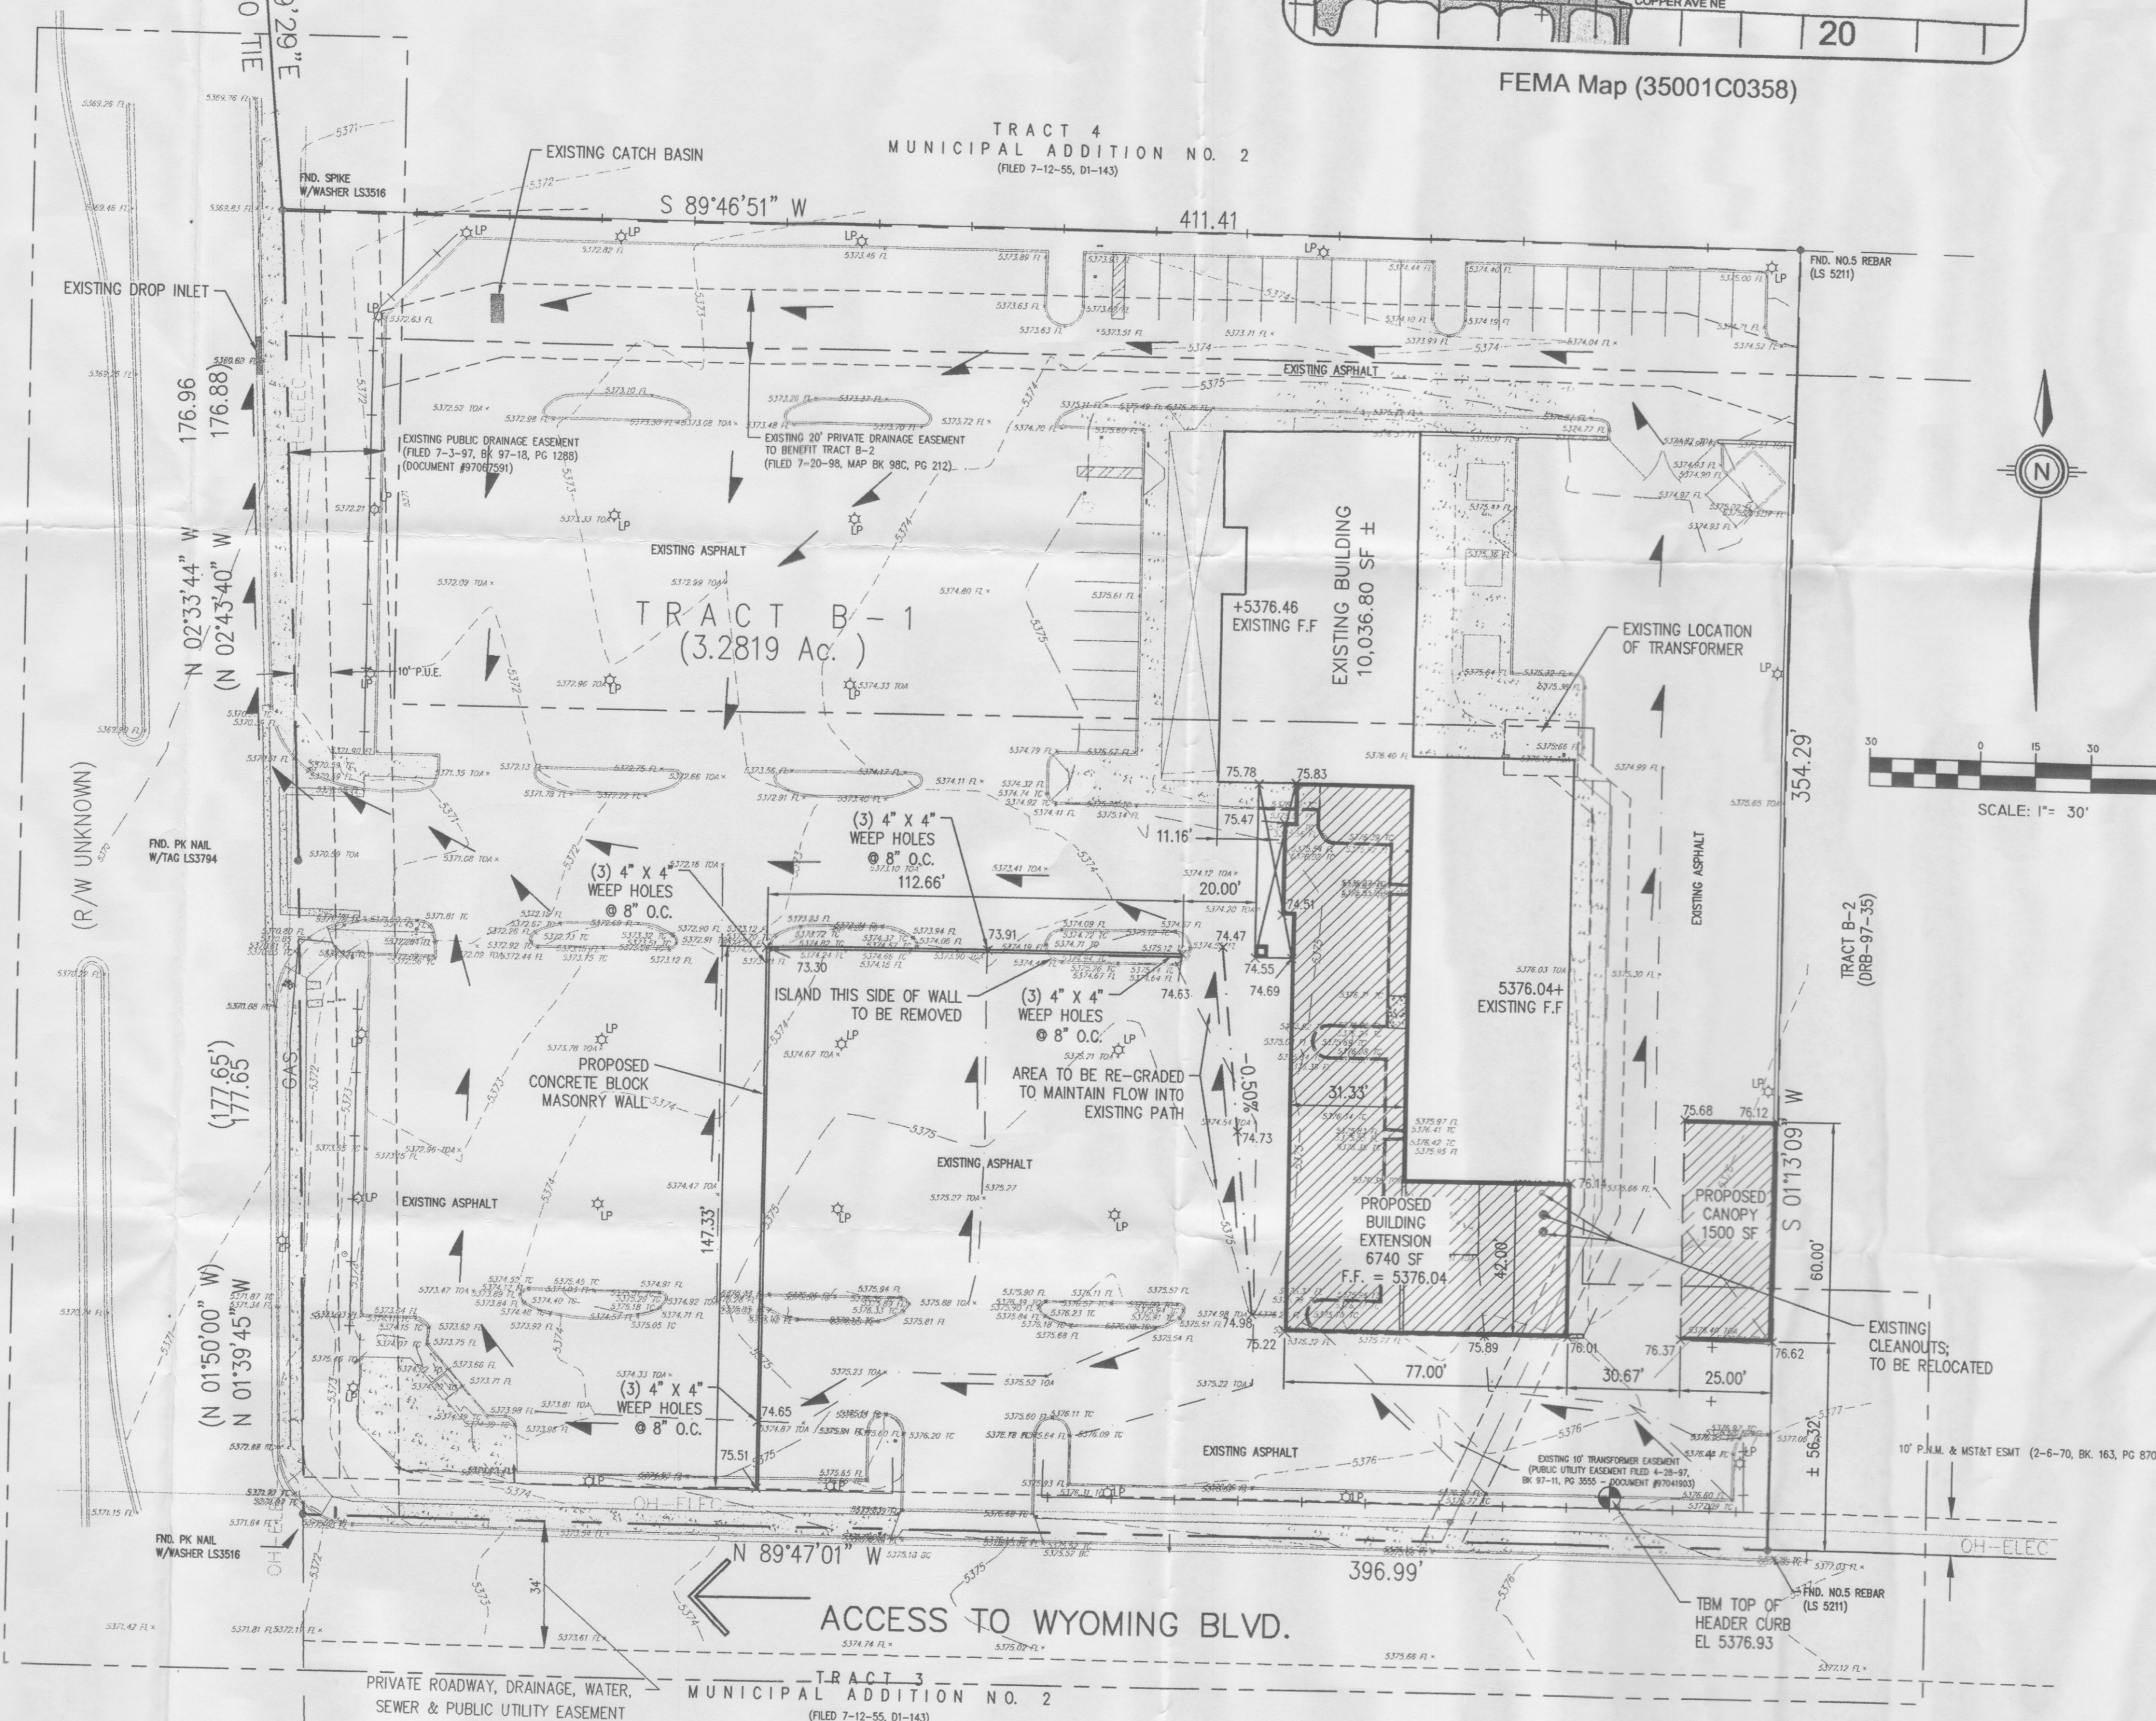

Community Sciences Corporation
LAND PLANNING ENGINEERING SURVEYING
P.O. Box 1328 Corrales, New Mexico 87048
JOB NO.: N726-02

CITY OF ALBUQUERQUE PLANNING DEPARTMENT HYDROLOGY DEVELOPMENT SECTION			
TITLE: DRIVETIME ADDITION GRADING & DRAINAGE PLAN			
Design Review Committee	City Engineer Approval	Mo./Day/Yr	Mo./Day/Yr
City Project No.	Zone Map No.	Sheet	of
N/A	K-20	1	1
DESIGNED BY JGG	DATE 09/2005	REVISIONS	DESIGN
DRAWN BY JGG	DATE 09/2005	CHECKED BY BLS	