


ALL GENERAL NOTES APPLY TO BOTH THE PUBLIC WORKS CONTRACT WORK AND TO PARKS AND GENERAL SERVICES WORK UNLESS OTHERWISE NOTED.

ALL WORK WHICH IS PART OF THE PUBLIC WORKS CONTRACT IS INDICATED AS SUCH BY A REFERENCE TO "PWC".

ALL WORK WHICH IS PART OF THE PARKS AND GENERAL SERVICES WORK IS INDICATED AS SUCH BY A REFERENCE TO "PARKS".

SEE LEGEND FOR EXISTING SITE ELEMENTS TO REMAIN. ALL ELEMENTS SHALL REMAIN UNLESS OTHERWISE NOTED.

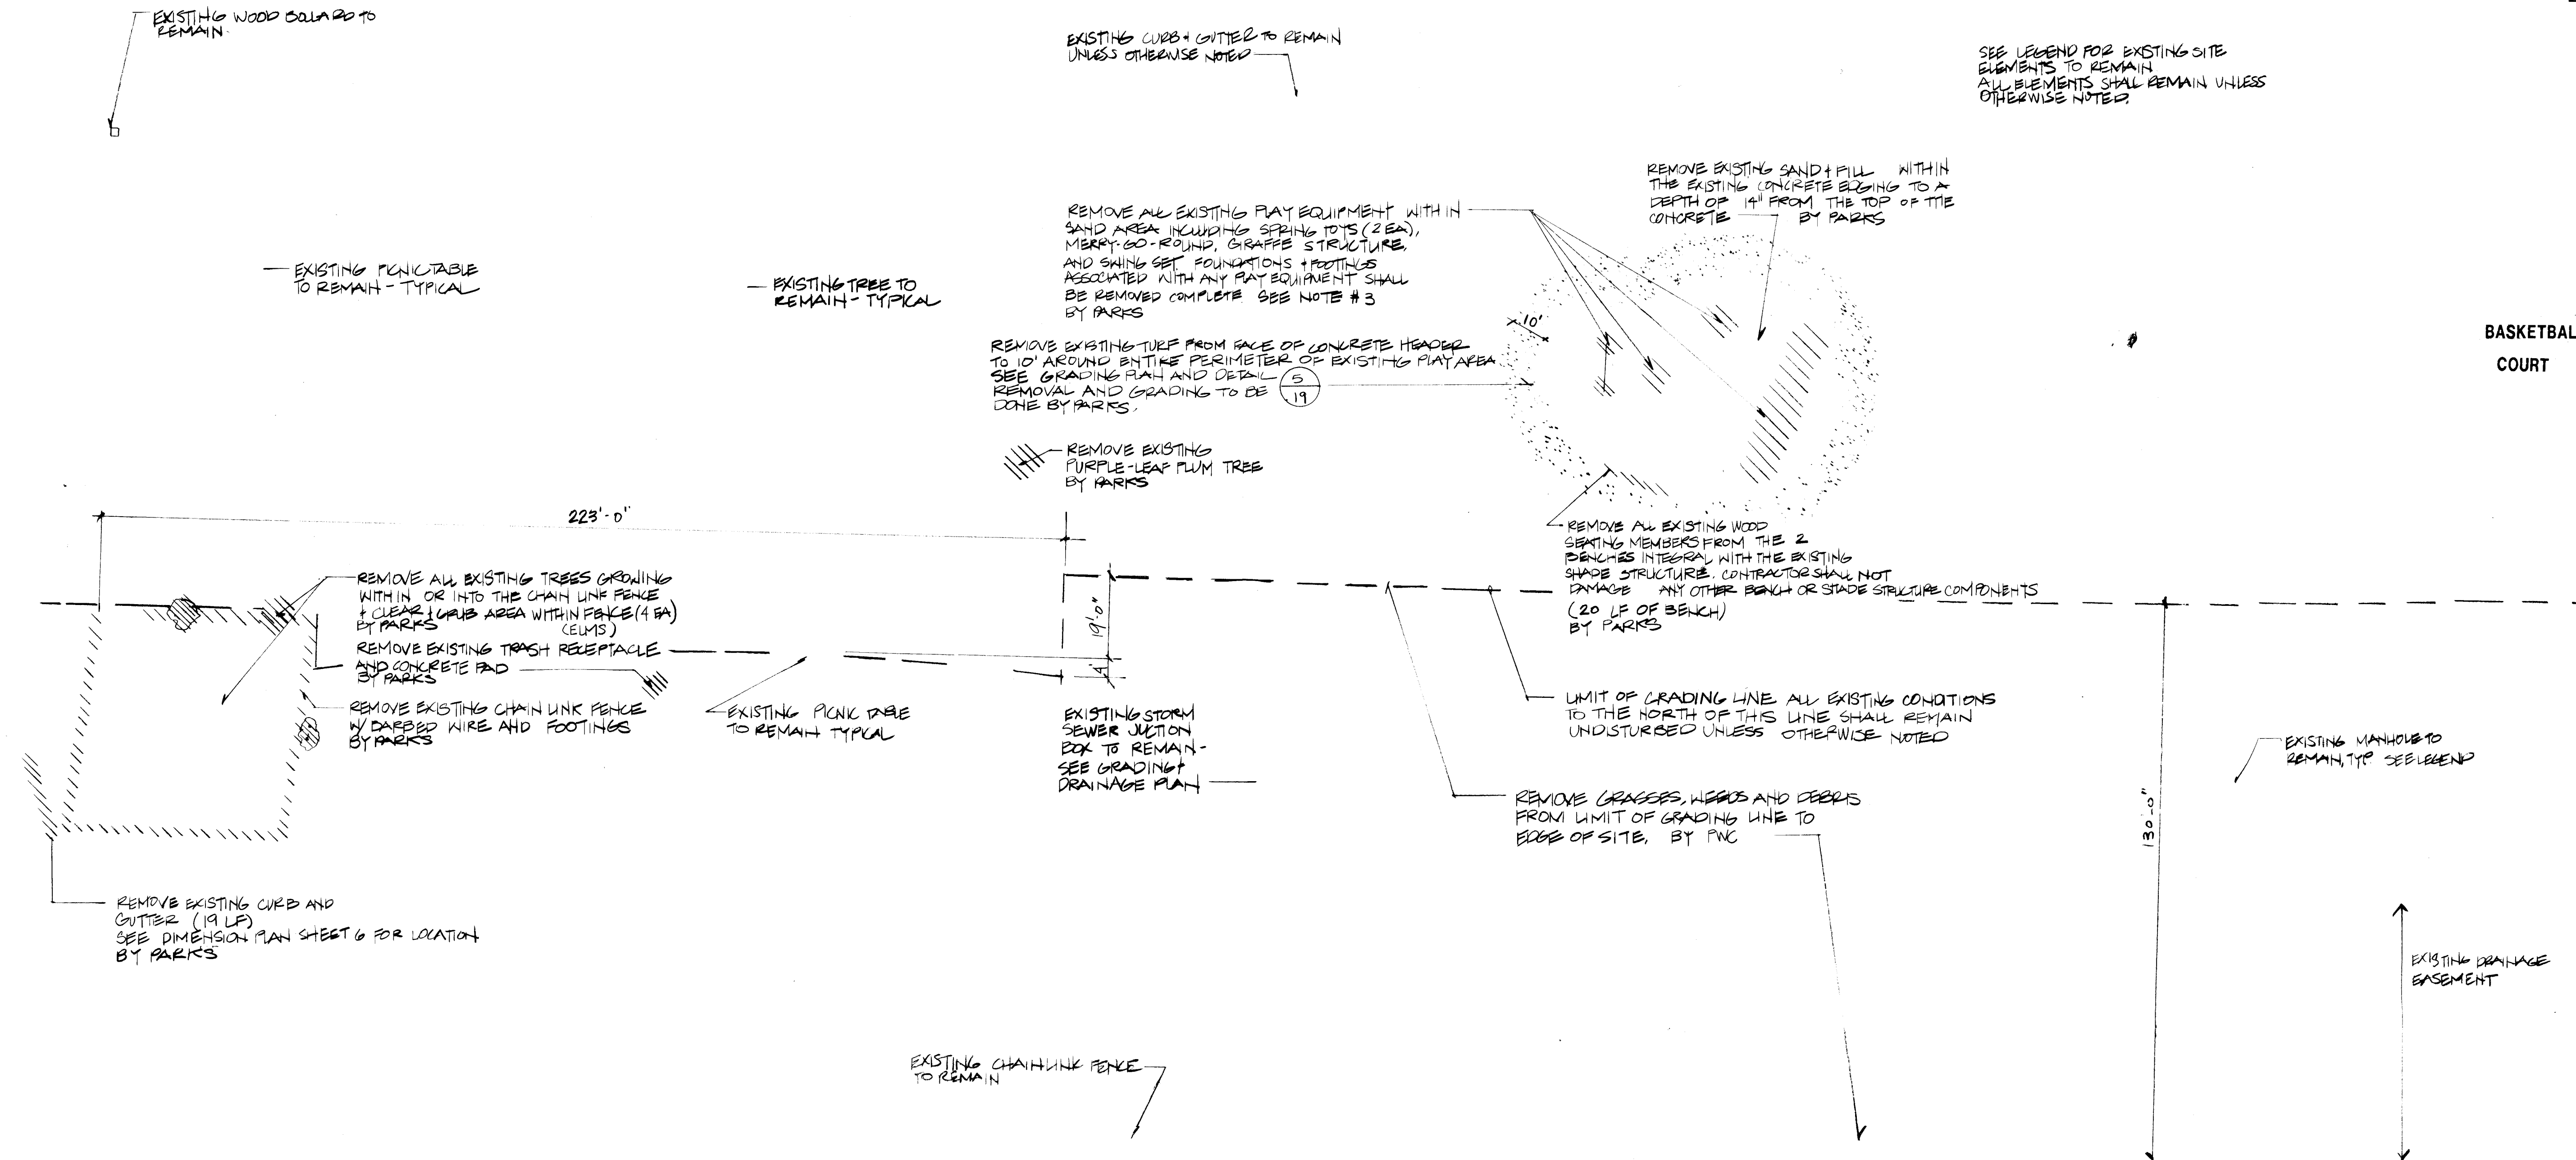

LEGEND	
•	TRAVERSE POINT
•	METAL POST
□	CABLE TV RISER
○	MANHOLE
○	DRAIN INLET
○	ELECTRIC MANHOLE
○	TELEPHONE MANHOLE
+	TRAFFIC SIGNAL
+	WATER VALVE
+	GAS RISER
+	WATER RISER
+	ELECTRIC RISER
+	TELEPHONE RISER
+	POWER POLE WITH LIGHT
+	POWER POLE
+	FIRE HYDRANT
+	SIGN POST
+	DECIDUOUS TREE
+	CONIFEROUS TREE
+	BUSH
-X-	CHAIN LINK FENCE
-OH-	OVER HEAD WIRE
-UGP-	UNDER GROUND PIPE
-GAS-	UNDER GROUND GAS LINE
-SAN-	SANITARY SEWER LINE
-W-	WATER LINE

GENERAL DEMOLITION NOTES


- ALL EXISTING IMPROVEMENTS ARE TO REMAIN UNLESS OTHERWISE INDICATED. CONTRACTOR SHALL PROTECT EXISTING IMPROVEMENTS AND SHALL REPAIR ITEMS DAMAGED DURING CONSTRUCTION TO THEIR ORIGINAL CONDITION AT NO ADDITIONAL COST TO THE OWNER.
- SPECIAL CARE SHALL BE TAKEN NOT TO DAMAGE EXISTING TREES, SHRUBS, OR TURF EXCEPT AS NOTED ON THE PLANS. NO ALTERATION OF GRADE SHALL BE PERMITTED AND NO COMPACTION SHALL BE PERMITTED WITHIN THE DRIPLINE OF ANY TREE WITHOUT PRIOR APPROVAL OF THE LANDSCAPE ARCHITECT.
- COORDINATE REMOVAL OF ALL PLAY EQUIPMENT AND OTHER SALVAGEABLE MATERIAL WITH PARK MANAGEMENT FOR DIRECTION ON WHICH ITEMS THE OWNER WILL RETAIN AND WHERE THEY SHALL BE DELIVERED. THIS SHALL BE DONE AT NO ADDITIONAL COST TO THE OWNER. ALL OTHER ITEMS SHALL BE PROPERLY DISPOSED OF.

SCANNED BY
BY LASON

1 2 3 4 5 6 7 8 9 10 11 12 13 14 15
24-14349-1.90-19290

0 10' 20' 40' 60'
1" = 20'-0"

MORROW & COMPANY, LTD.
LANDSCAPE ARCHITECTS
210 La Veta N.E.
Albuquerque, N.M. 87108
PH: 505 265-2266 FAX: 505 265-9637

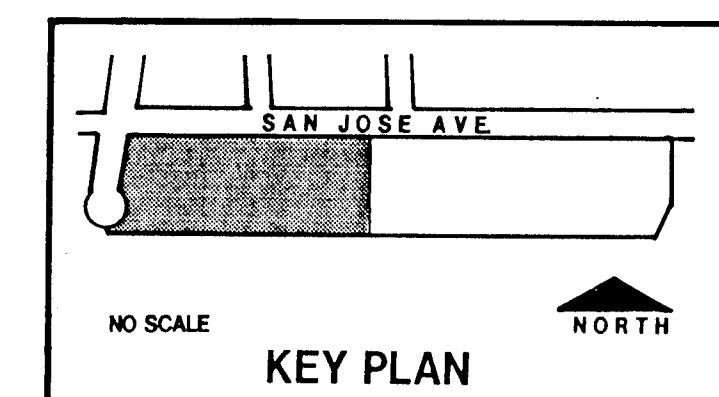


NOVEMBER 19, 1992 20/01037.14001/S/PARK1/5-20-92/DLM

CITY OF ALBUQUERQUE
PARKS/GENERAL SERVICES
DESIGN & DEVELOPMENT


TITLE: SOUTH SAN JOSE PARK RENOVATION
DEMOLITION PLAN, WEST

APPROVALS	ENGINEER	DATE	APPROVALS	ENGINEER	DATE
DRC CHAIRMAN	<i>[Signature]</i>	12-10-92	WATER	N/A RWK	11-30-92
TRANSPORTATION	<i>[Signature]</i>	12-10-92	WASTE WATER	N/A RWK	11-30-92
HYDROLOGY	<i>[Signature]</i>	12-8-92			
PARKS	<i>[Signature]</i>	11/30/92			
PROJECT NO.	4349.90	MAP NO.	M-14-Z	SHEET	2 OF 20

ALL WORK WHICH IS PART OF THE PARKS AND GENERAL SERVICES WORK IS INDICATED AS SUCH BY A REFERENCE TO "PARKS".

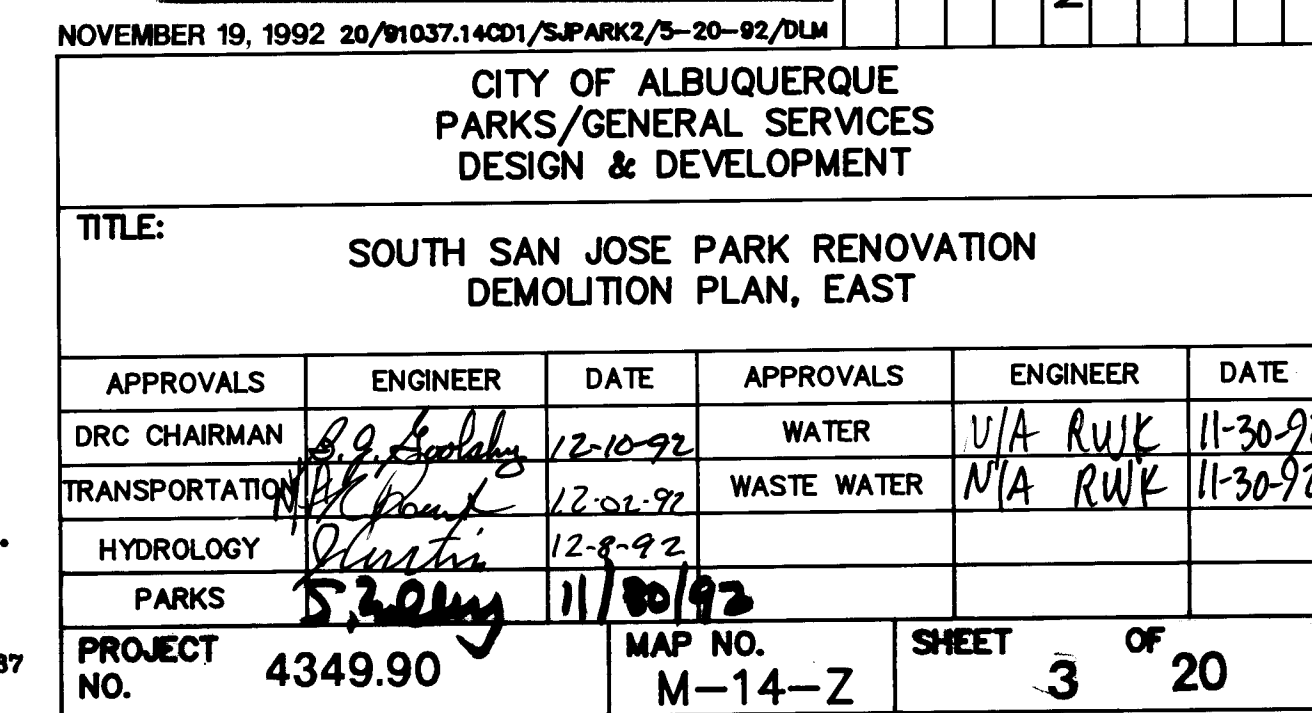[illegible]

ALL WORK WHICH IS PART OF THE PARKS AND GENERAL SERVICES WORK
WILL BE INDICATED AS SUCH BY A REFERENCE TO "PARKS".

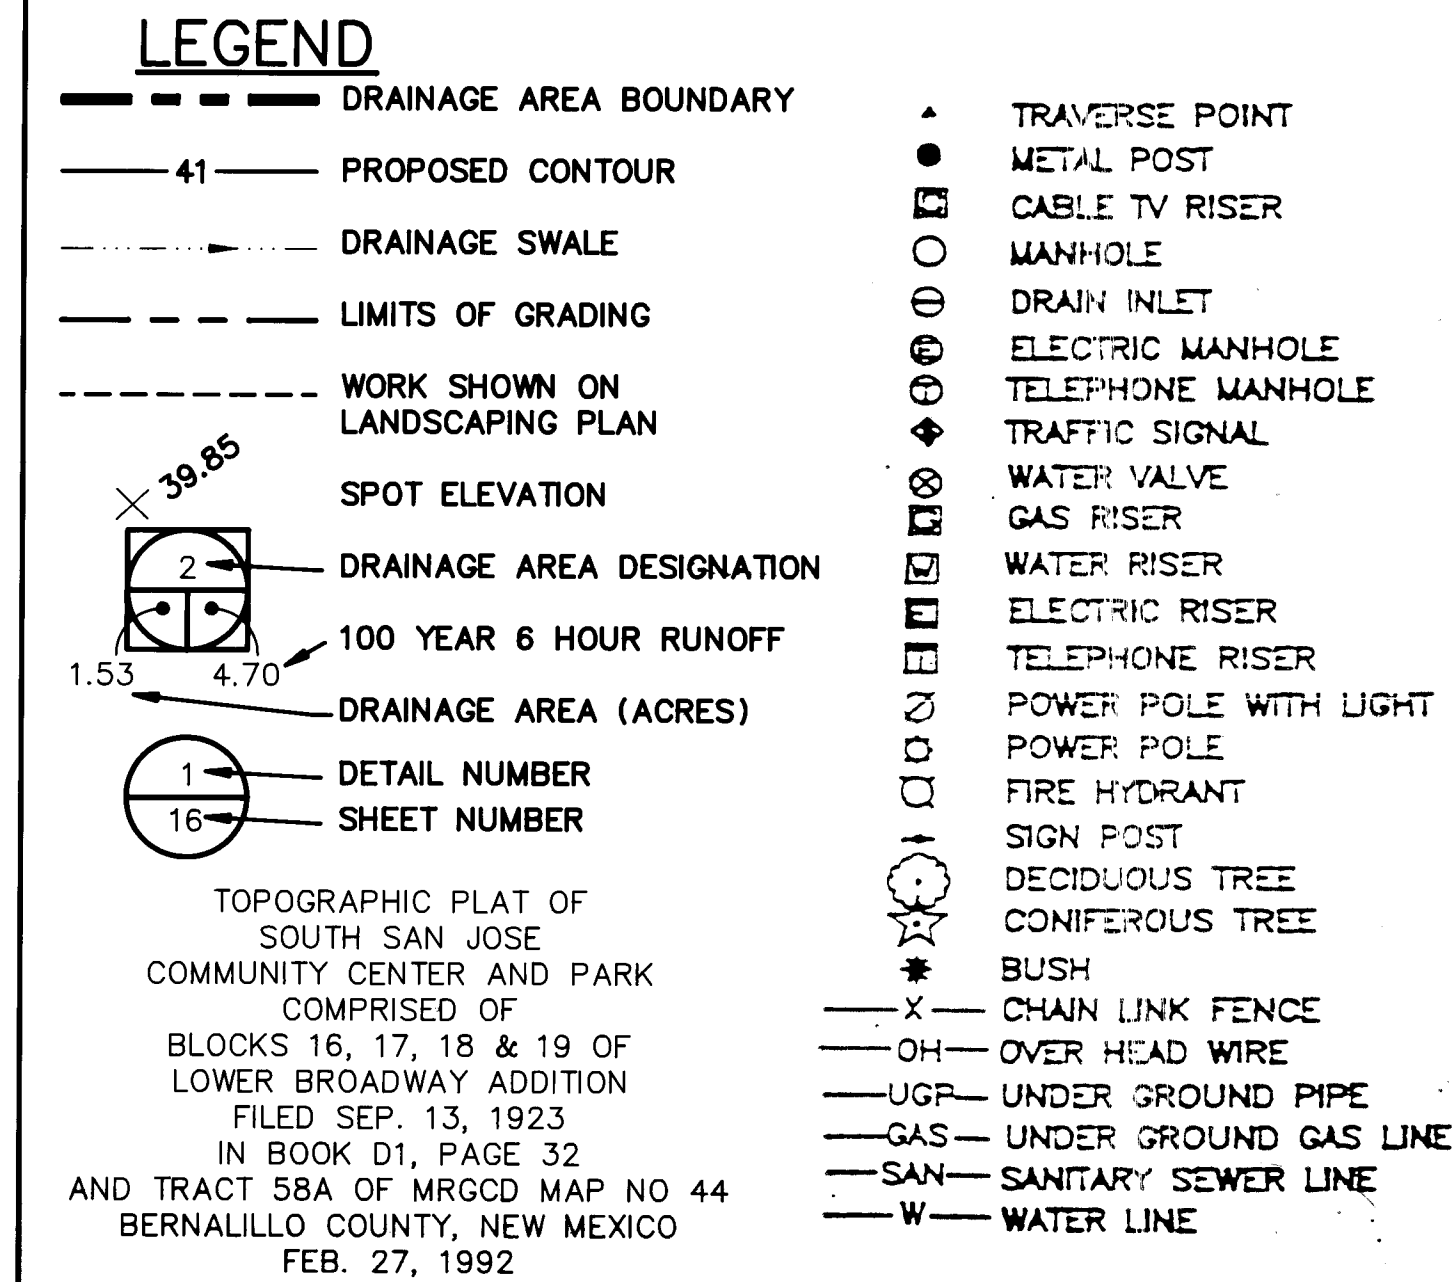


ENGINEER: LEEDSHILL--HERKENHOFF, INC.
500 COPPER AVENUE, NW
ALBUQUERQUE, NEW MEXICO, 87103
ATTENTION: SUSAN M. ALVAREZ, P.E.
(505) 246-0294

SURVEYOR: SURVEY PROVIDED BY THE CITY OF ALBUQUERQUE
PUBLIC WORKS DEPARTMENT, ENGINEERING GROUP
SURVEY SECTION. DATE OF SURVEY: FEBRUARY 1992

BENCHMARK: ACS BENCHMARK "11-M14", 1-3/4" ALUMINUM DISK
SET IN TOP OF CURB, ELEVATION = 4941.07 FT.
N 1475451.5967
E 380842.4688

AREA: 6.49 ACRES, APPROXIMATELY 282,558 SQ FT

FLOOD HAZARD: NO PART OF THIS PARK NOR OF THE ADJACENT PUBL
ROADWAYS ARE SUBJECT TO A FLOOD HAZARD AREA
DETERMINED BY COMMUNITY PANEL NO. 350002 0034
THE FEMA FLOOD INSURANCE RATE MAPS EFFECTIVE
OCTOBER 14, 1983. THE PROJECT AREA IS INDICATED
AS A "ZONE C", AN AREA OF MINIMAL FLOODING.

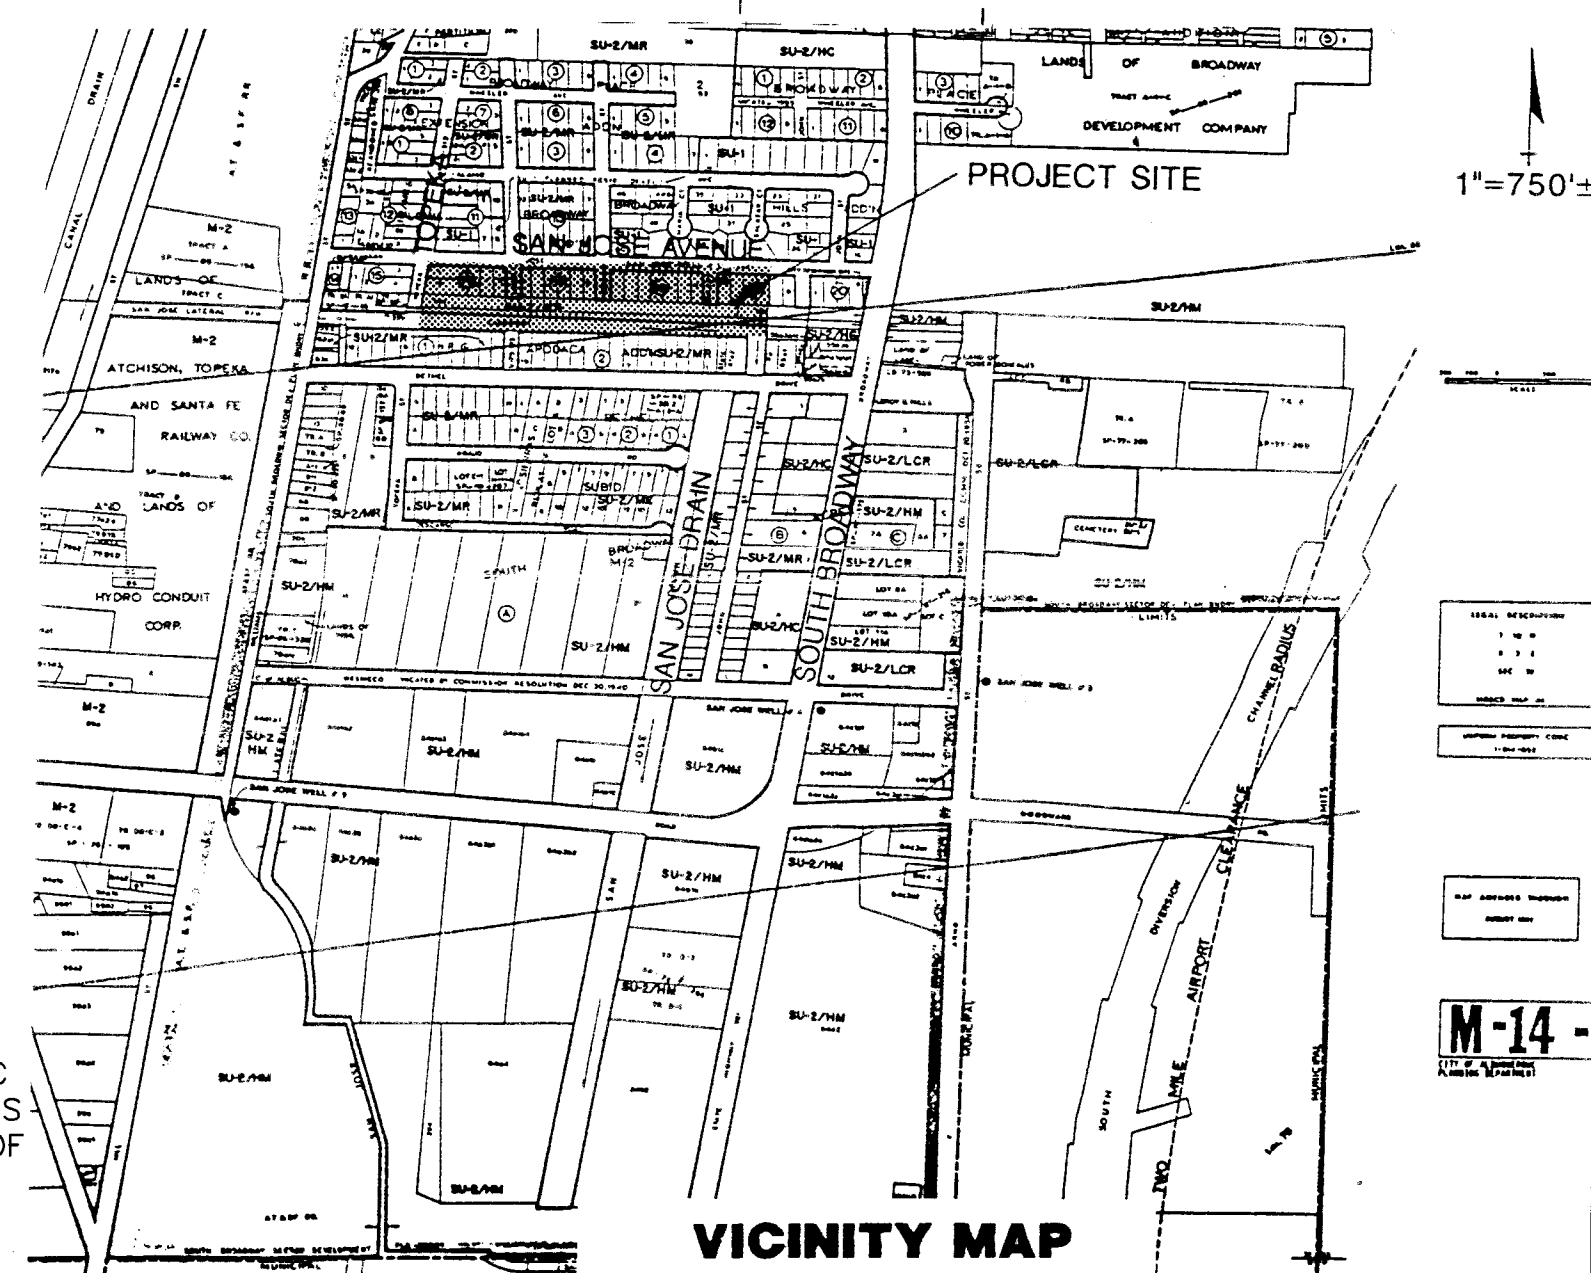

NOVEMBER 19, 1992 0/91037.14CD2/SJGRDNG1/11-02-92/KHK

CITY OF ALBUQUERQUE
PARKS/GENERAL SERVICES
DESIGN & DEVELOPMENT

TITLE: SOUTH SAN JOSE PARK RENOVATION
GRADING & DRAINAGE PLAN WEST

APPROVALS		ENGINEER	DATE	APPROVALS		ENGINEER	DATE
DRC CHAIRMAN		<i>24. S. S. S.</i>	<i>12-10-92</i>	WATER		<i>N/A RWK</i>	<i>11-30-92</i>
TRANSPORTATION		<i>24. S. S. S.</i>	<i>12-10-92</i>	WASTE WATER		<i>N/A RWK</i>	<i>11-30-92</i>
HYDROLOGY		<i>RPC</i>	<i>12-8-92</i>				
PARKS		<i>S. S. S.</i>	<i>11/30/92</i>				
PROJECT NO.		<i>4349-90</i>		MAP NO.		<i>14-7</i>	
				SHEET		OF	
				<i>4</i>		<i>20</i>	

MATCHLINE SEE SHEET 5

SURVEY INFORMATION			BENCH MARKS		AS BUILT INFORMATION	
FIELD NOTES						
NO.	BY	DATE	ACS BENCH MARK "11-M14" 1-3/4" ALUMINUM		CONTRACTOR	
COA		2/27/92	DISK SET IN TOP OF CURB.		WORK STARTED BY	DATE
			ELEV = 4941.07 FT		INSPECTED BY	DATE
			N 1475451.5987		FIELD VERIFICATION BY	DATE
			E 3808442.4688		CORRECTED BY	DATE
					MICRO-FILM INFORMATION	
					RECORDED BY	DATE
					NO.	

ENGINEER'S SEAL

REVISIONS		BY
NO.	DATE	
DESIGN		
DESIGNED BY	S. ALVAREZ	DATE -
DRAWN BY	-	DATE -
CHECKED BY	-	DATE -


November 2, 1997

MATCHLINE SEE SHEET 4

ALL GENERAL NOTES APPLY TO BOTH THE PUBLIC WORKS CONTRACT WORK AND TO PARKS AND GENERAL SERVICES WORK UNLESS OTHERWISE NOTED.

ALL WORK WHICH IS PART OF THE PUBLIC WORKS CONTRACT
WILL BE INDICATED AS SUCH BY A REFERENCE TO "PWC".

ALL WORK WHICH IS PART OF THE PARKS AND GENERAL SERVICES WORK WILL BE INDICATED AS SUCH BY A REFERENCE TO "PARKS".

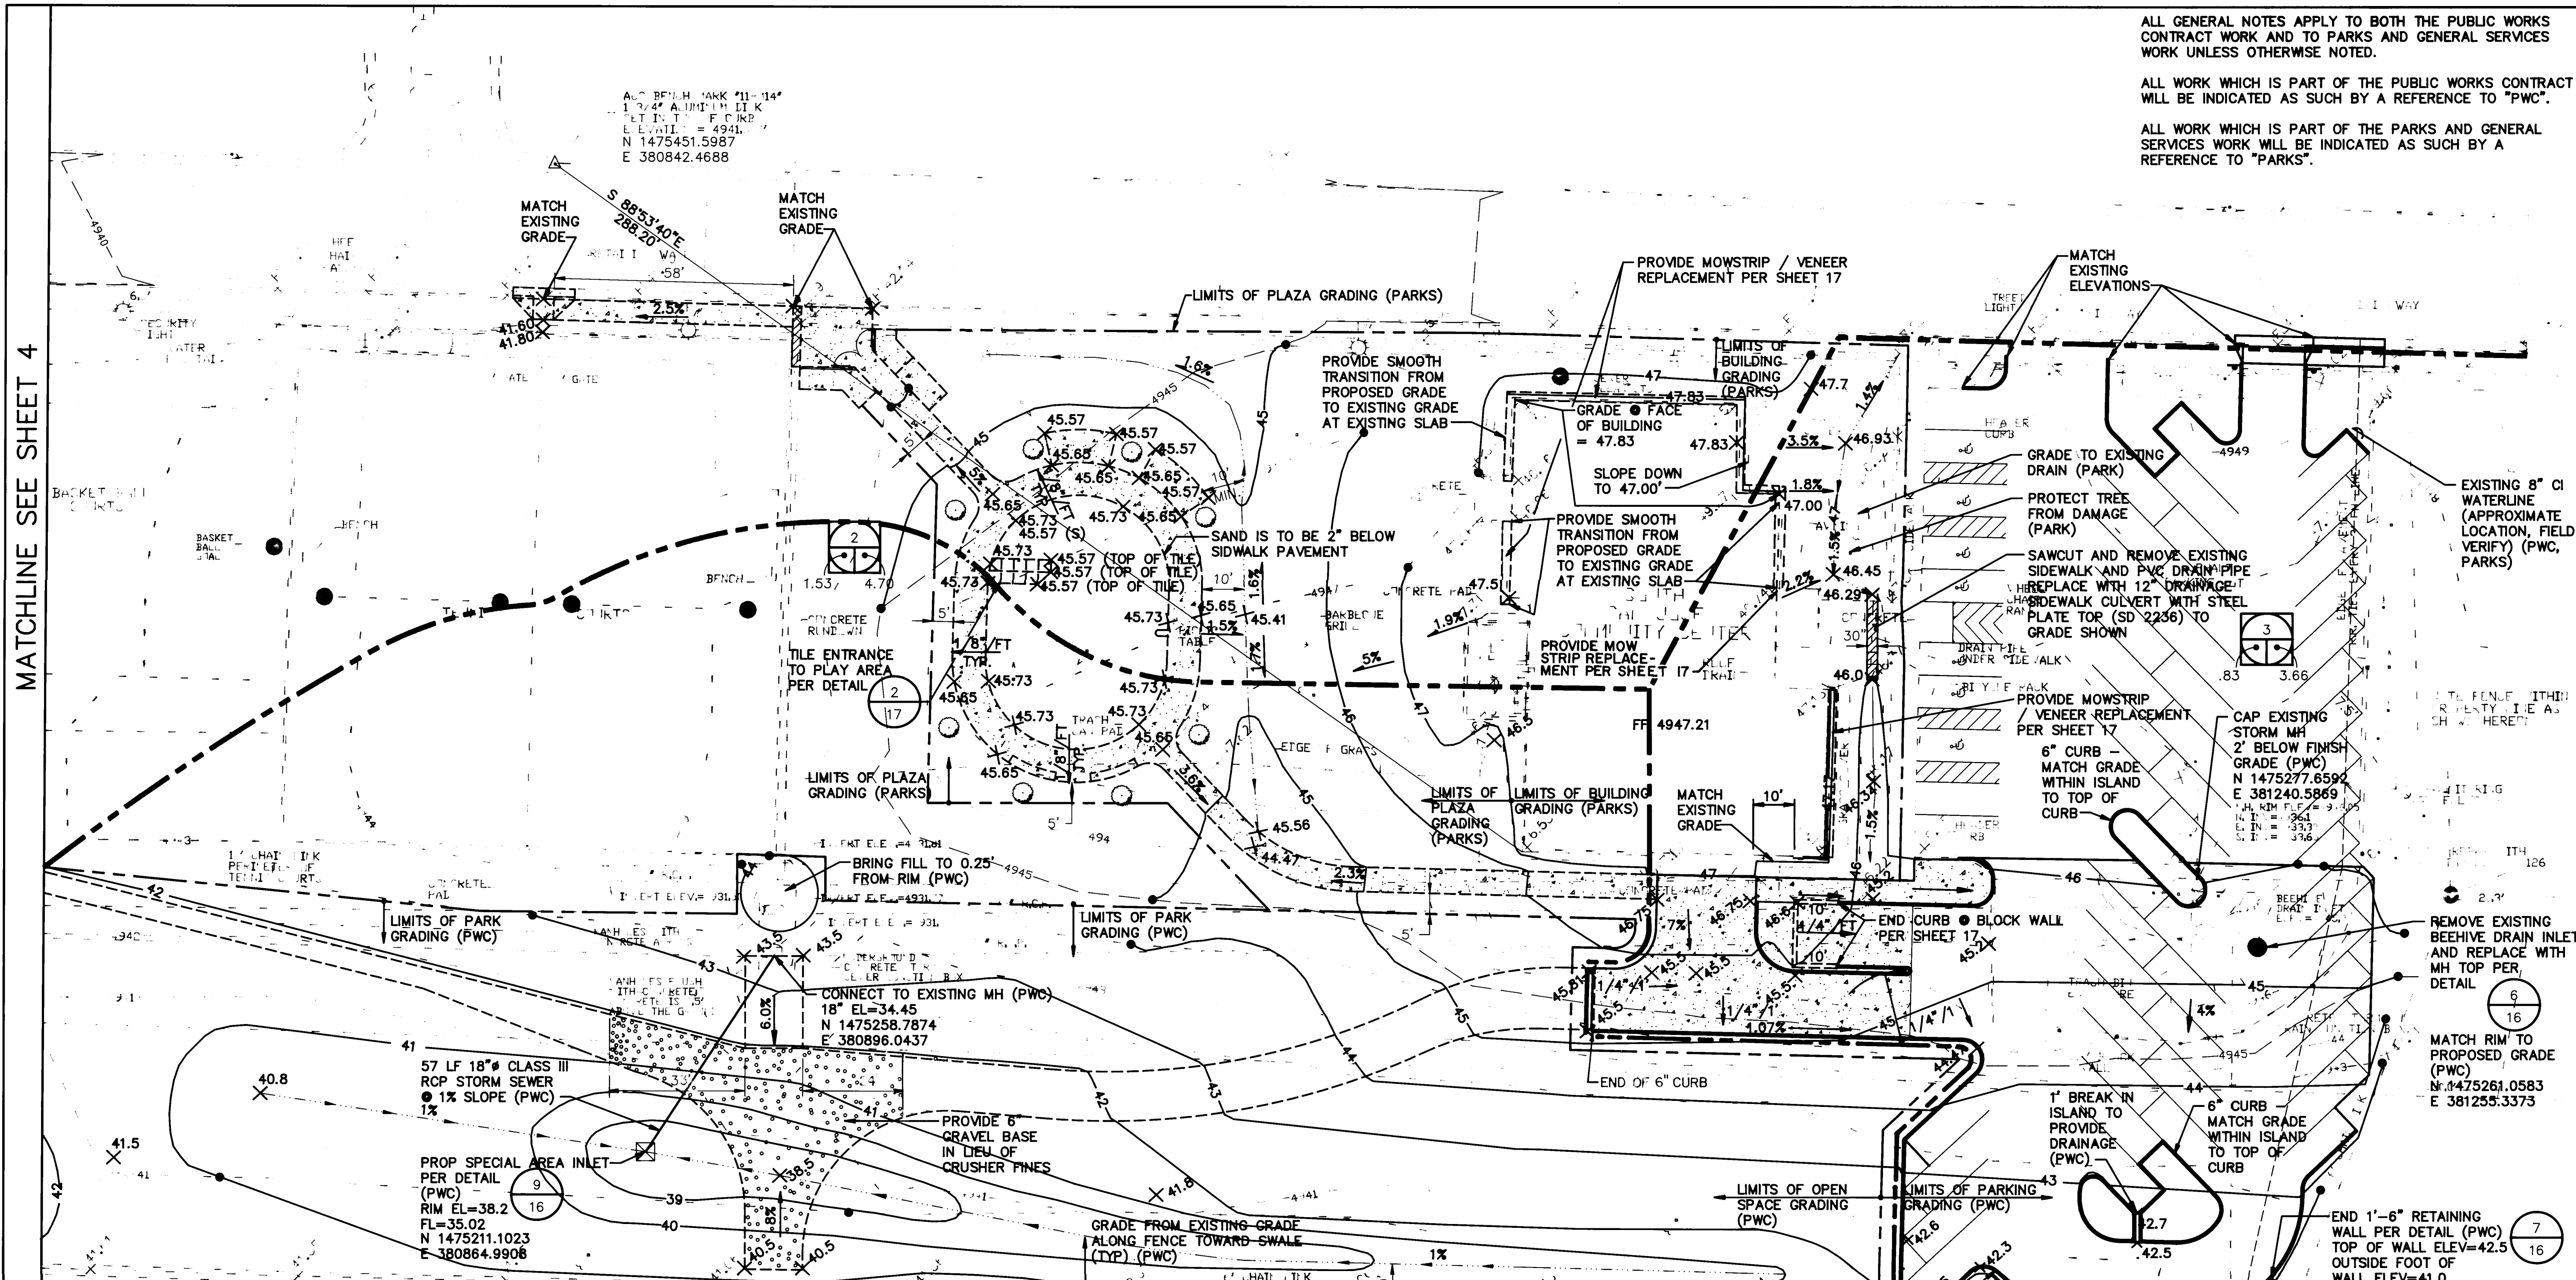

LEGEND

- LEGEND**

	DRAINAGE AREA BOUNDARY		TRAVERSE POINT
	PROPOSED CONTOUR		METAL POST
	DRAINAGE SWALE		CABLE TV RISER
	LIMITS OF GRADING		MANHOLE
	WORK SHOWN ON LANDSCAPING PLAN		DRAIN INLET
	SPOT ELEVATION		ELECTRIC MANHOLE
	DRAINAGE AREA DESIGNATION		TELEPHONE MANHOLE
	100 YEAR 6 HOUR RUNOFF		TRAFFIC SIGNAL
	DRAINAGE AREA (ACRES)		WATER VALVE
	DETAIL NUMBER		GAS RISER
	SHEET NUMBER		WATER RISER
			ELECTRIC RISER
			TELEPHONE RISER
			POWER POLE WITH LIGHT
			POWER POLE
			FIRE HYDRANT
			SIGN POST
			DECIDUOUS TREE
			CONIFEROUS TREE
			BUSH
			CHAIN LINK FENCE
			OVER HEAD WIRE
			UNDER GROUND PIPE
			UNDER GROUND GAS LINE
			SANITARY SEWER LINE
			WATER LINE

TOPOGRAPHIC PLAT OF
SOUTH SAN JOSE
COMMUNITY CENTER AND PARK
COMPRISED OF
BLOCKS 16, 17, 18 & 19 OF
LOWER BROADWAY ADDITION
FILED SEP. 13, 1923
IN BOOK D1, PAGE 32
AND TRACT 58A OF MRCD MAP NO 44
BERNALILLO COUNTY, NEW MEXICO
FEB. 27, 1992

GENERAL NOTES


ENGINEER: LEEDSHILL--HERKENHOFF, INC.
500 COPPER AVENUE, NW
ALBUQUERQUE, NEW MEXICO, 87103
ATTENTION: SUSAN M. ALVAREZ, P.E.
(505) 247-0294

SURVEYOR: SURVEY PROVIDED BY THE CITY OF ALBUQUERQUE
PUBLIC WORKS DEPARTMENT, ENGINEERING GROUP
SURVEY SECTION. DATE OF SURVEY: FEBRUARY 1992

BENCHMARK: ACS BENCHMARK "11-M14", 1-3/4" ALUMINUM DISK
SET IN TOP OF CURB, ELEVATION = 4941.07 FT.
N 1475451.5967
E 380842.4688

AREA: 6.49 ACRES, APPROXIMATELY 282,558 SQ FT

FLOOD HAZARD: NO PART OF THIS PARK NOR OF THE ADJACENT PUBLIC
ROADWAYS ARE SUBJECT TO A FLOOD HAZARD AREA
DETERMINED BY COMMUNITY PANEL NO. 350002 0034
THE FEMA FLOOD INSURANCE RATE MAPS EFFECTIVE
OCTOBER 14, 1983. THE PROJECT AREA IS INDICATED
AS A "ZONE C", AN AREA OF MINIMAL FLOODING.

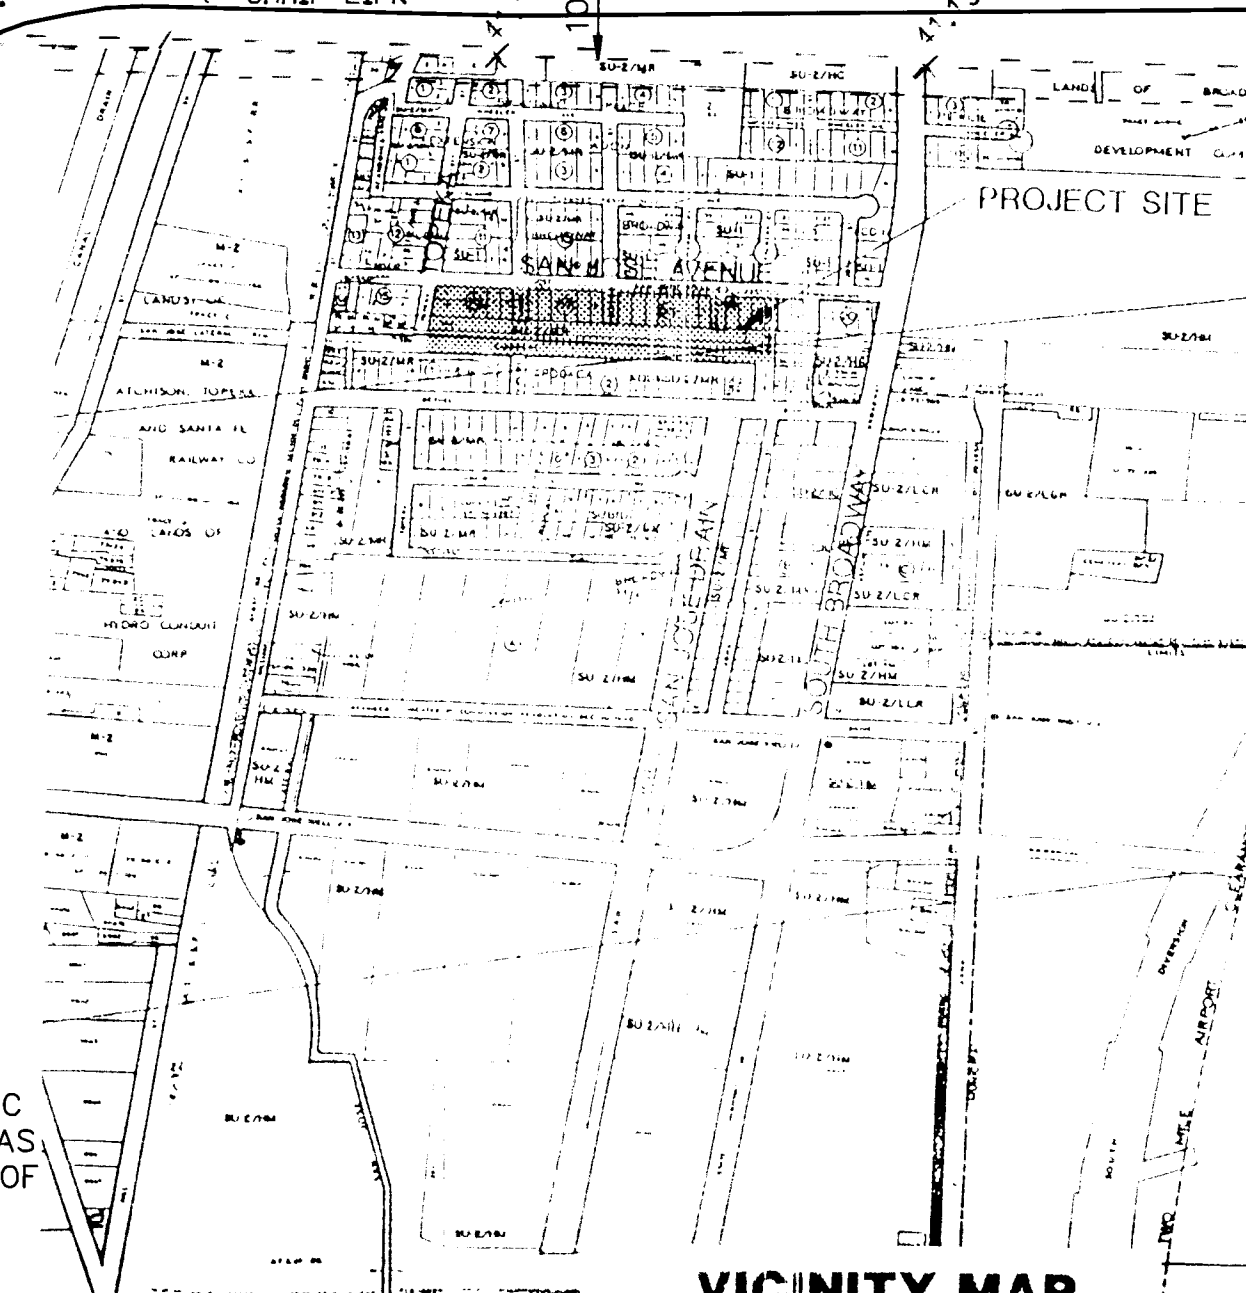

BEGIN 1'-6" RETAINING
WALL PER DETAIL
(PWC)
TOP OF WALL
ELEV=42.5
OUTSIDE FOOT OF WALL
ELEV=41.0
N 1475182.30
E 341191.68

TYPE D GRATE INLET
PER CITY STANDARD
DETAIL #2206 (PWC)
RIM EL=41.5
24" FL=38.5
N 1475175.3081
E 381225.1314

24 LF 18" Ø CMP
STORM SEWER ● 1%
SPECIAL CMP MH ON
EXISTING 12'x6' STEEL PLATE
PIPE PER DETAIL
(PWC)
RIM ELEV=41.8
FL=4930.70
N 1475174.9055
E 381248.6286

SCANNED BY
BY LASON

20/91037.14CD2/UPDATE/12-14-92/MRL


TITLE: SOUTH SAN JOSE PARK RENOVATION
GRADING DRAINAGE AND PLAN EAST

APPROVALS		ENGINEER	DATE	APPROVALS		ENGINEER	DATE
DRC CHAIRMAN		<i>RA Ladd</i>	<i>12-10-92</i>	WATER		<i>NA RWK</i>	<i>11-30-92</i>
TRANSPORTATION		<i>NACAP</i>	<i>12-01-92</i>	WASTE WATER		<i>NA RWK</i>	<i>11-30-92</i>
HYDROLOGY		<i>JPC</i>	<i>11-8-92</i>				
PARKS		<i>Stacy</i>	<i>11/30/92</i>				
PROJECT NO.		4349.90		MAP NO.		SHEET 5 OF 20	
		M-14-7					

SURVEY INFORMATION			BENCH MARKS		AS BUILT INFORMATION	
NO.	FIELD NOTES		ACS BENCH MARK	DISK SET IN TOP OF CURB	CONTRACTOR	DATE
	COA	BY				
		2/27/92		ELEV = 4941.07	WORK STARTED BY	DATE
				N 1475451.5987	ADJUSTED BY	DATE
				E 380842.4688	FIELD VERIFICATION BY	DATE
					CORRECTED BY	DATE
					MICRO-FILM INFORMATION	
					RECORDED BY	DATE
					NO.	

[illegible]

QUE VICES MENT		
RENOVATION PLAN EAST		
VALS	ENGINEER	DATE
TER	N/A RWE	11-30-9
WATER	N/A RWE	11-30-9
7	SHEET 5 OF	20

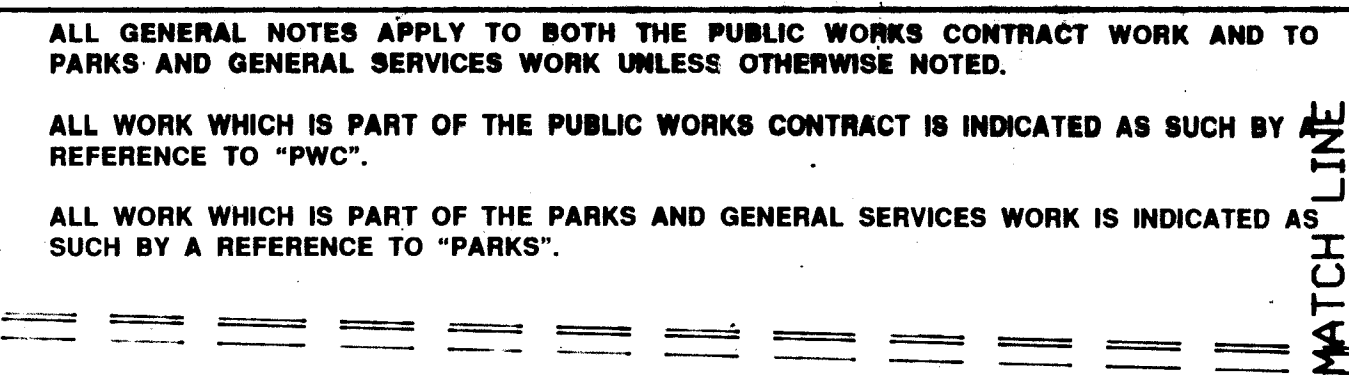



A key plan map showing the project location in San Jose, California. The map features a street grid with "SAN JOSE AVE" labeled. A shaded rectangular area indicates the project site. A north arrow is located in the bottom right corner, pointing upwards. The text "NO SCALE" is present in the bottom left corner.


0 10' 20' 40' 60'
1" = 20'-0"

 **MORROW & COMPANY, LTD.**
LANDSCAPE ARCHITECTS
210 La Veta N.E.
Birmingham, N.M. 87108

NOVEMBER 19, 1992 20/01037.14C01 /2-PARK/11-20-92/DLM						1
CITY OF ALBUQUERQUE PARKS/GENERAL SERVICES DESIGN & DEVELOPMENT						
TITLE: SOUTH SAN JOSE PARK RENOVATION DIMENSION PLAN, WEST						
APPROVALS	ENGINEER	DATE	APPROVALS	ENGINEER	DATE	
DRC CHAIRMAN	<i>A. J. Acosta</i>	<i>12-10-92</i>	WATER	<i>N/A RWK</i>	<i>11-30-92</i>	
TRANSPORTATION	<i>N/A LHO</i>	<i>12-2-92</i>	WASTE WATER	<i>N/A RWK</i>	<i>11-30-92</i>	
HYDROLOGY	<i>LPC</i>	<i>12-8-92</i>				
PARKS	<i>F. Salas</i>	<i>11-30-92</i>				
PROJECT NO.	4349.90	MAP NO.	M-14-Z	SHEET	6	OF 20

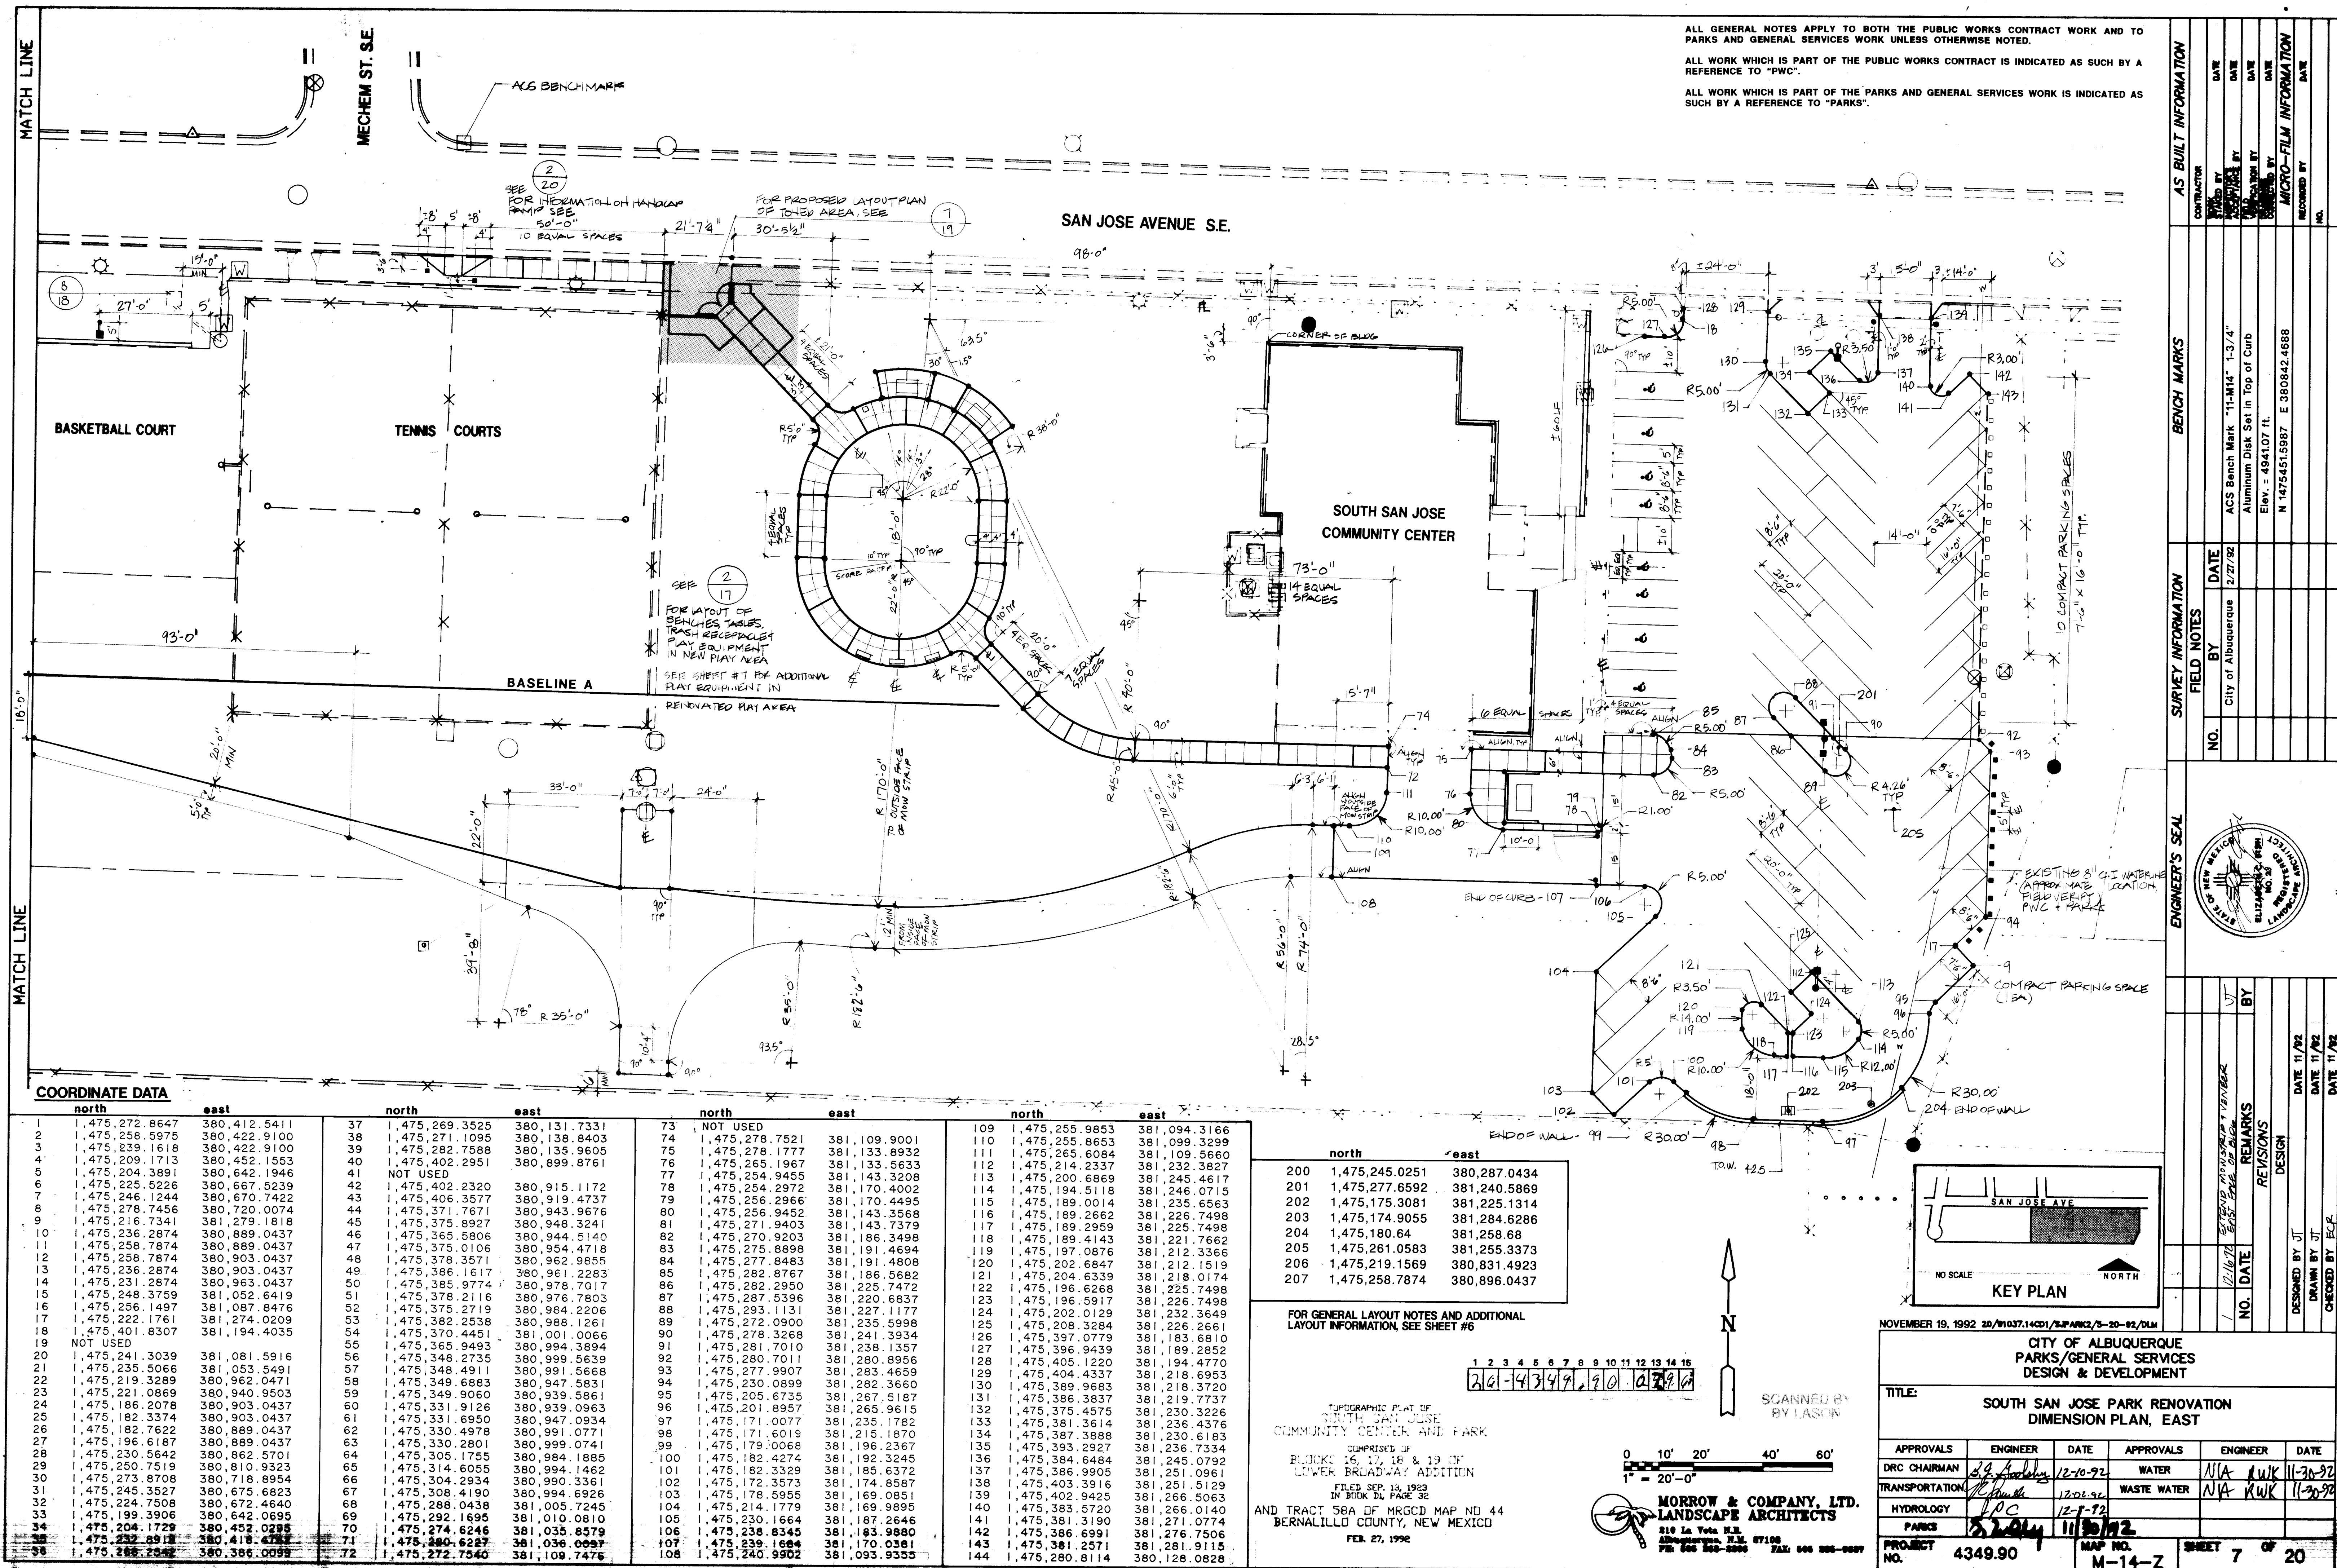

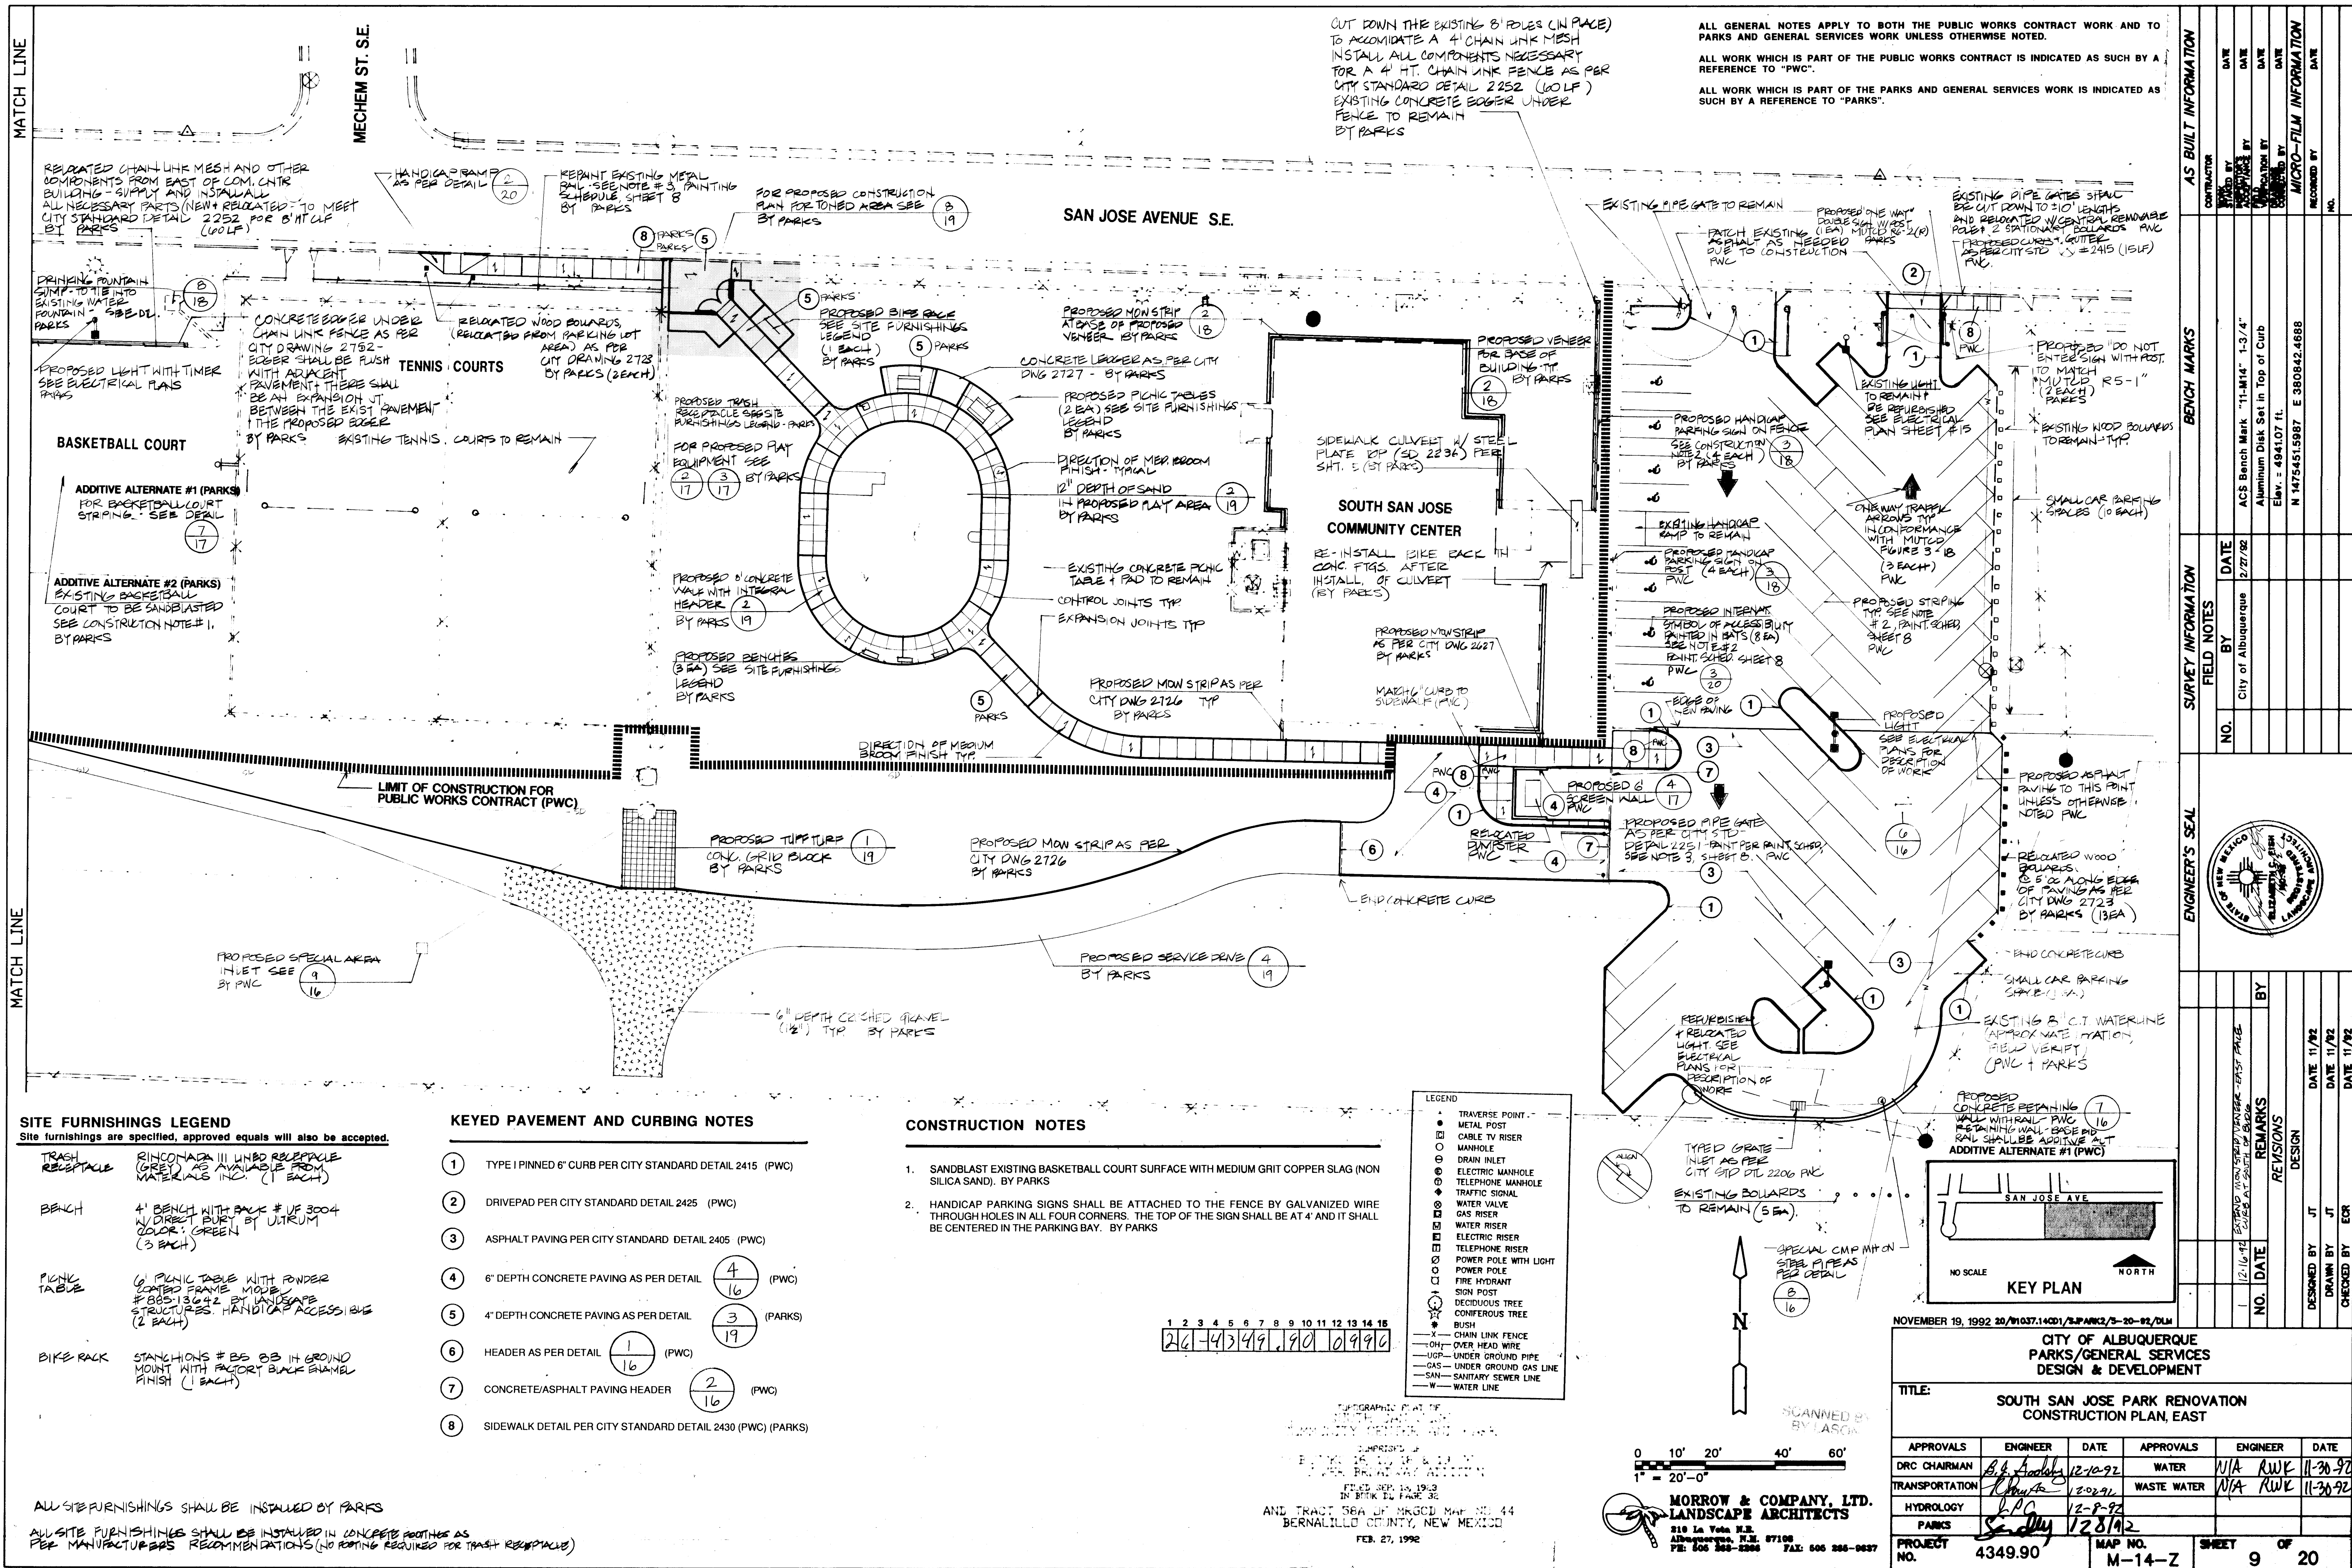

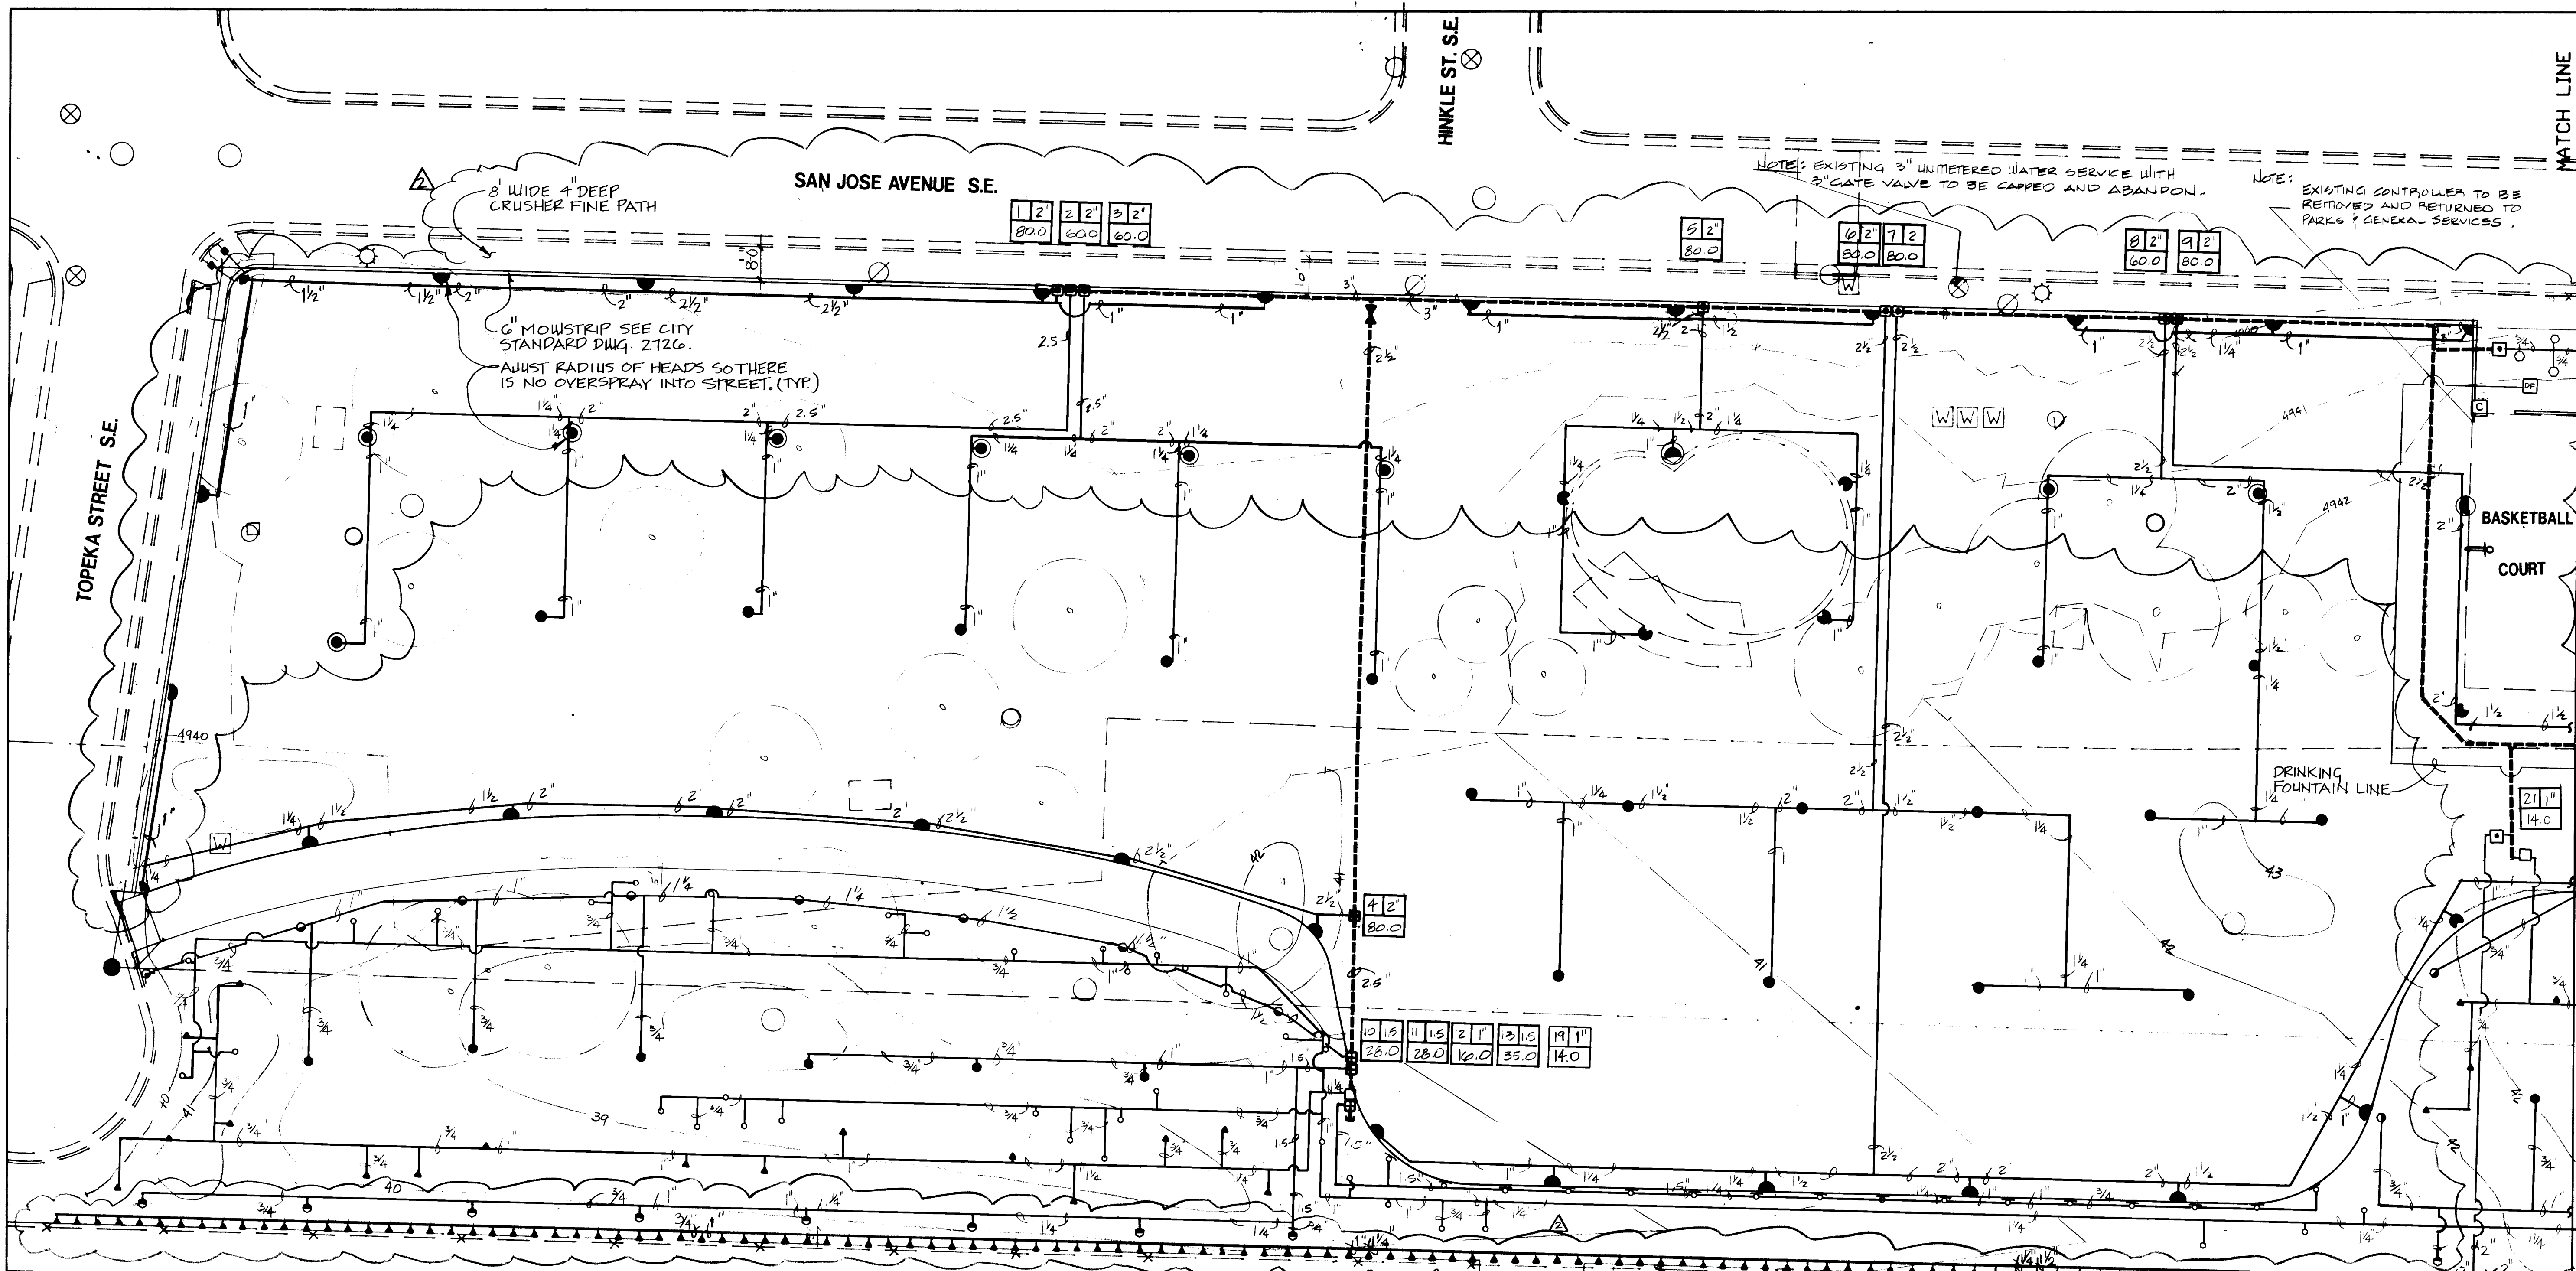


IRRIGATION LEGEND

- 2" PROPOSED TURBINE WATER METER (TO CITY STANDARDS)
- 2" FERCQ 765 PRESSURE VACUUM BREAKER BACKFLOW PREVENTER W/ 2" BERMAD 910-P FLOW METER SEE CITY DETAIL #2702
- MOTOROLA MIR-5000 F 26 STATION SATELLITE CONTROLLER W/ STRONG BOX SB-24-SS/MMB STEEL ENCLOSURE SEE CITY DETAIL
- RAINBIRD 100-PEB 1" AUTOMATIC VALVE ASSEMBLY SEE CITY DETAIL #2703
- RAINBIRD 150-PEB 1-1/2" AUTOMATIC VALVE ASSEMBLY SEE CITY DETAIL #2703
- RAINBIRD 200-PEB 2" AUTOMATIC VALVE ASSEMBLY
- RAINBIRD RB-2AV2" AIR RELEASE VALVE SEE CITY DETAIL #2705
- PGL B-68 2-1/2" BRASS GATE VALVE ASSEMBLY SEE CITY DETAIL #2706
- TORO 570C-4P 4" POP-UP SPRAY SEE CITY DETAIL #2709
- 15Q-PC 15" RADIUS 90° ARC, 1.0 GPM @ 50 PSI
- 15H-PC 15" RADIUS 180° ARC, 1.9 GPM @ 50 PSI
- 15F-PC 15" RADIUS 360° ARC, 3.9 GPM @ 50 PSI
- 15TQ-PC 15" RADIUS 270° ARC, 2.9 GPM @ 50 PSI
- 10H-PC 15" RADIUS 180° ARC, 5.0 GPM @ 50 PSI
- 10Q-PC 15" RADIUS 90° ARC, 1.0 GPM @ 50 PSI
- TORO 570C-4P 4" POP-UP STREAM SHRUB SPRAY SEE CITY DETAIL #2709
- 10-SSH 180° ARC W/PCD .50 GPM @ 50 PSI
- 10-SSQ 90° ARC W/PCD .25 GPM @ 50 PSI
- 10-SSF 360° ARC W/PCD .70 GPM @ 50 PSI
- TORO S700 (LAWN) ROTOR 4" POP-UP (NATIVE AREA) SEE CITY DETAIL #2709
- #2.0 NOZ. 180° ARC, 40" RADIUS 2.11 GPM @ 50 PSI
- #1.5 NOZ. 90° ARC, 40" RADIUS 1.64 GPM @ 50 PSI
- #3.0 NOZ. 360° ARC, 40" RADIUS 3.52 GPM @ 50 PSI

- TORO S600 4" POP-UP ROTOR (LAWN AREA) SEE CITY DETAIL #2709
- #2.5 NOZ. 180° ARC, 40" RADIUS 3.34 GPM @ 50 PSI
- #1.3 NOZ. 90° ARC, 40" RADIUS 1.61 GPM @ 50 PSI
- #5.0 NOZ. 360° ARC, 40" RADIUS 6.71 GPM @ 50 PSI
- TORO S610 4" POP-UP ROTOR (LAWN) SEE CITY DETAIL #2709
- #9 NOZ. 360° ARC 50" RADIUS 10.0 GPM @ 50 PSI
- #9 NOZ. 180° ARC 50" RADIUS 10.0 GPM @ 50 PSI
- #6 NOZ. 90° ARC 50" RADIUS 8.0 GPM @ 50 PSI
- TORO 570C-3P 3" POP-UP BUBBLER SEE CITY DETAIL #2710
- FB-100-PC 1.0 GPM FLOOD BUBBLER NOZZLE.
- PEPCO OCTA-BUBBLER 8 OUTLET LOW-FLOW PRESSURE COMPENSATING BUBBLER ASSEMBLY W/BUE PORTS .25 GPM/OUTLET @ 40 PSI @ BUBBLER HEAD OUTLETS/BUBBLER .03 GPM EACH SEE DETAIL
- TORO #300 SERIES STREAM ROTOR SEE CITY DETAIL #2709
- #03 NOZZLE 3.23 GPM 30 RADIUS @ 50 PSI
- #02 NOZZLE 1.61 GPM 30 RADIUS @ 50 PSI
- #03 NOZZLE 6.45 GPM 30 RADIUS @ 50 PSI
- 3" CLASS 200 O-RING END TYPE PVC MAINLINE PIPE 18" BURY
- 2-1/2" SCH. 40 PVC PIPE MAINLINE 18" BURY
- SCH. 40 PVC SOLVENT WELD LATERAL PIPE 18" BURY
- OL 200 PVC SLEEVE 2 SIZE LARGER THAN PIPE BEING SLEEVED
- CL 200 PVC 1-1/4" WIRE SLEEVE TYPICAL

ALL IRRIGATION WORK ON THE IRRIGATION PLANS SHALL BE DONE BY PARKS EXCEPT FOR THE FOLLOWING ITEMS, WHICH SHALL BE DONE BY PWC:

A. TRENCHING AND INSTALLATION OF REQUIRED SLEEVES WITHIN THE PARKING LOT.

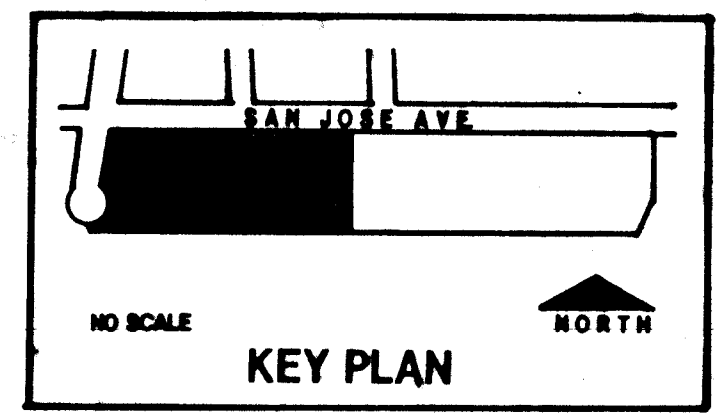


TOPOGRAPHIC PLAT OF SOUTH SAN JOSE COMMUNITY CENTER AND PARK COMPRISED OF BLOCKS 16, 17, 18 & 19 OF LOWER BROADWAY ADDITION FILED SEP. 13, 1923 IN BOOK DL PAGE 32 AND TRACT 58A OF MRGCD MAP NO. 44 BERNALILLO COUNTY, NEW MEXICO FEB. 27, 1992

0 10' 20' 40' 60' 1" = 20'-0"

MORROW & COMPANY, LTD. LANDSCAPE ARCHITECTS 210 La Toya N.E. ALBUQUERQUE, N.M. 87102 TEL: 505 255-2888 FAX: 505 255-0887

CITY OF ALBUQUERQUE PARKS/GENERAL SERVICES DESIGN & DEVELOPMENT					
TITLE: SOUTH SAN JOSE PARK RENOVATION IRRIGATION PLAN, WEST					
APPROVALS	ENGINEER	DATE	APPROVALS	ENGINEER	DATE
DRG CHAIRMAN	<i>[Signature]</i>	12-10-92	WATER	N/A RWK	11-30-92
TRANSPORTATION	<i>[Signature]</i>	12-07-92	WASTE WATER	N/A RWK	11-30-92
HYDROLOGY	<i>[Signature]</i>	12-8-92			
PARKS	<i>[Signature]</i>	11/30/92			
PROJECT NO.	4349.90	MAP NO.	M-14-Z	SHEET	10 OF 20

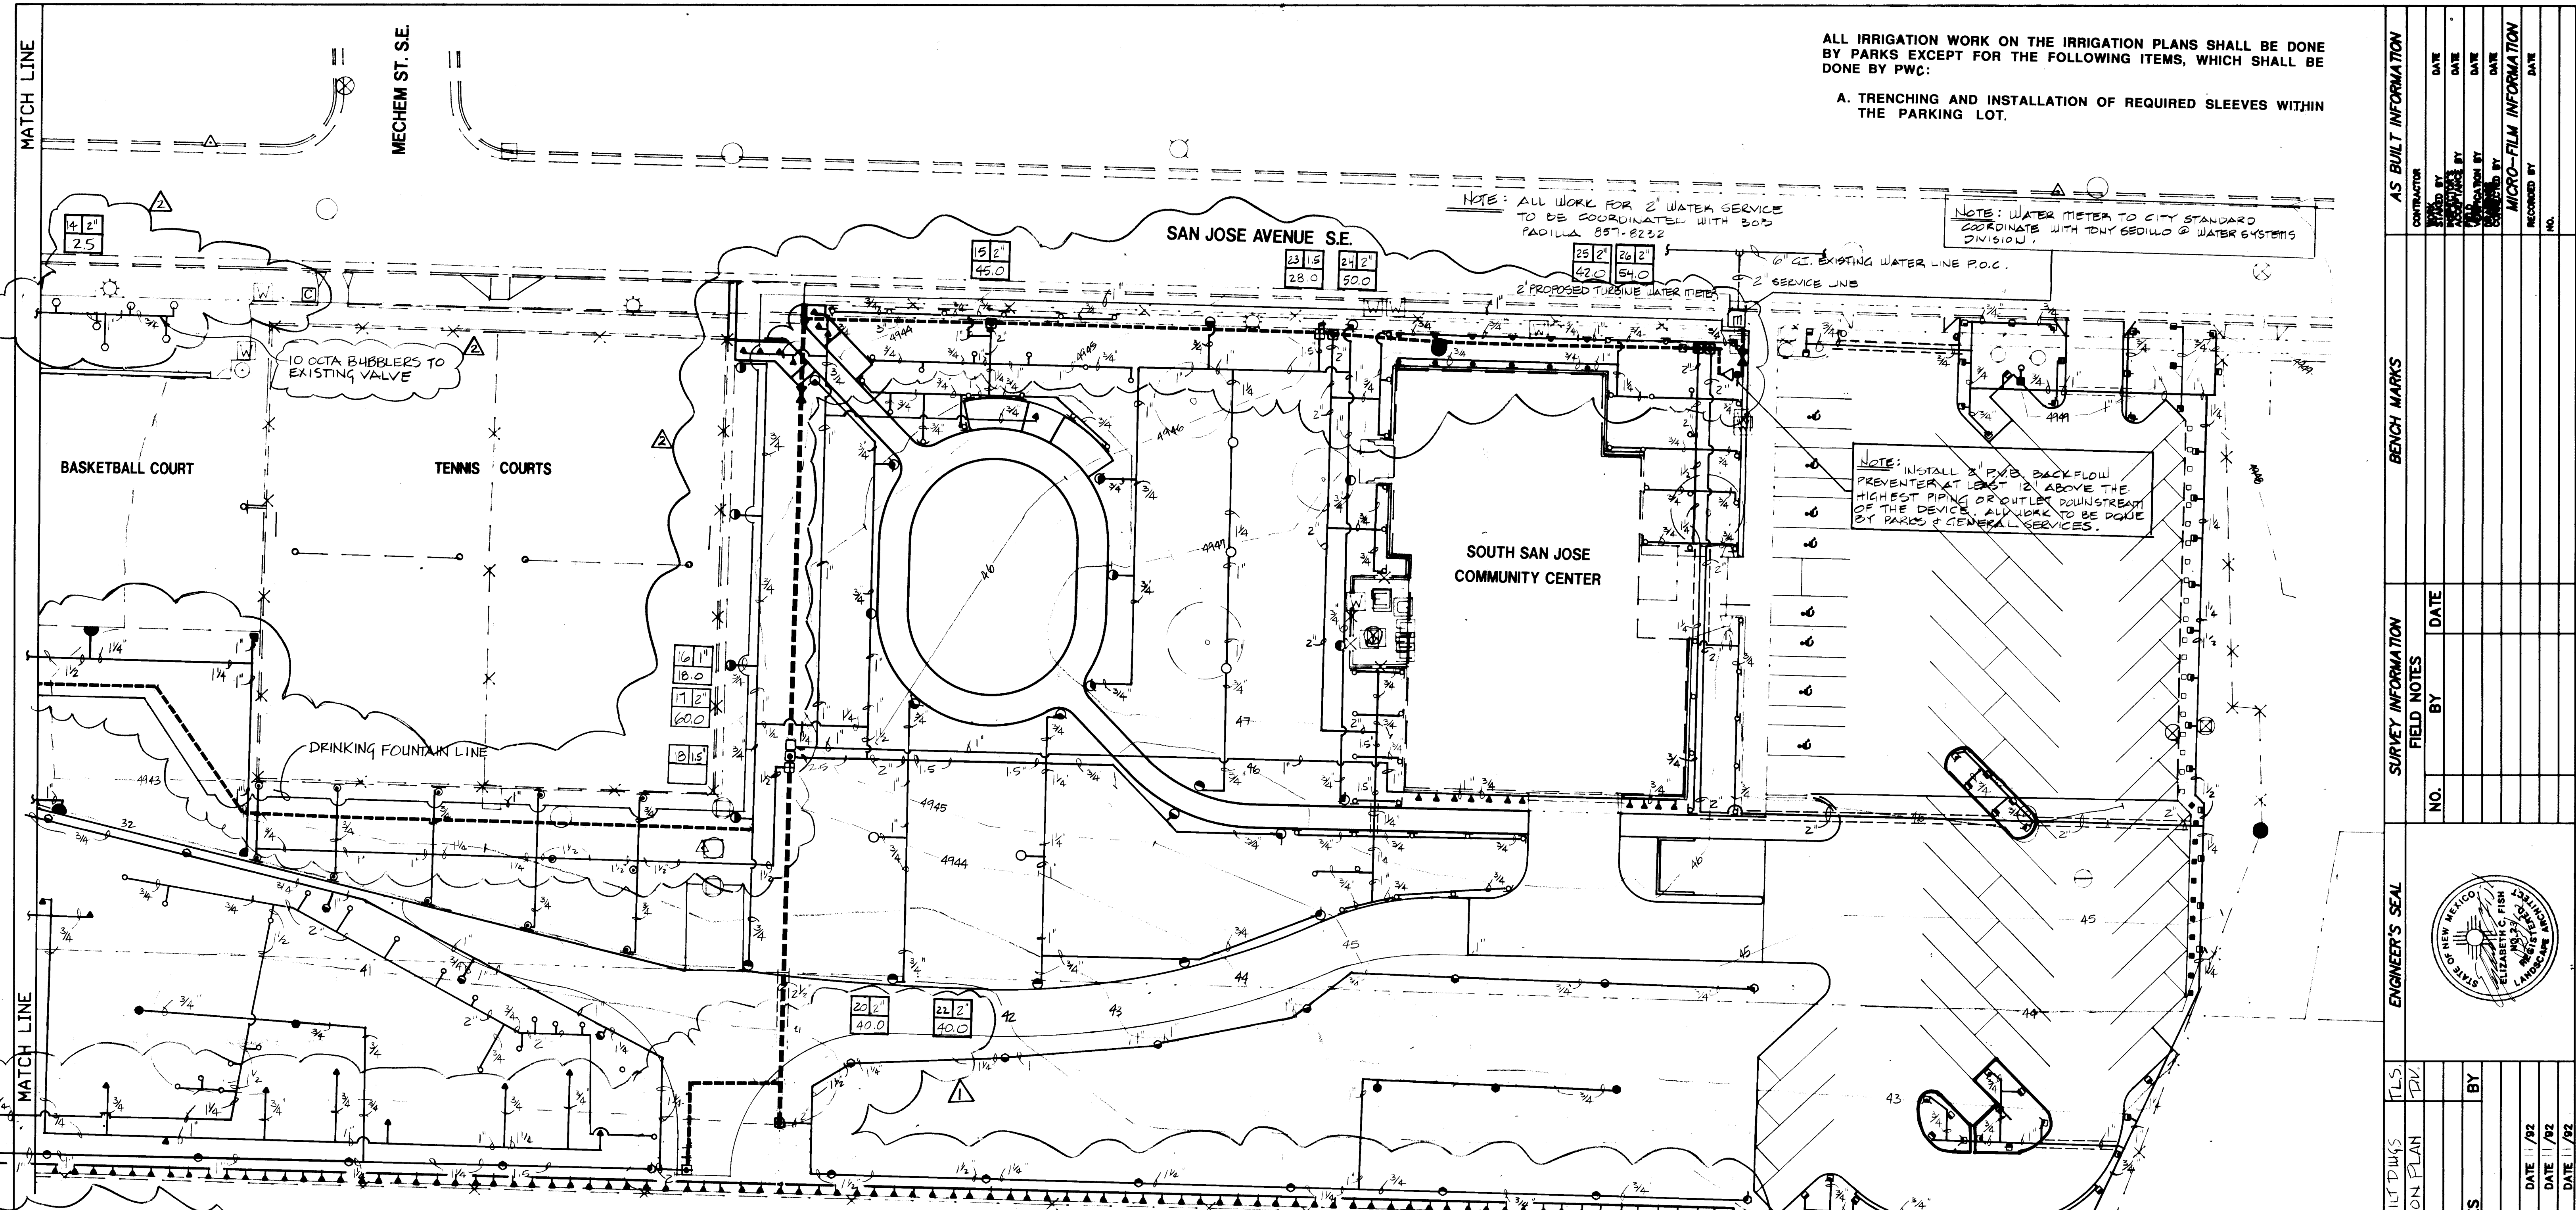

ALL IRRIGATION WORK ON THE IRRIGATION PLANS SHALL BE DONE BY PARKS EXCEPT FOR THE FOLLOWING ITEMS, WHICH SHALL BE DONE BY PWC:

A. TRENCHING AND INSTALLATION OF REQUIRED SLEEVES WITHIN THE PARKING LOT.


NOTE: ALL WORK FOR 2" WATER SERVICE TO BE COORDINATED WITH BOD PADILLA 887-8222

NOTE: WATER METER TO CITY STANDARD COORDINATE WITH DUTY SEDILL & WATER SYSTEMS DIVISION

NOTE: INSTALL 2" P.V.C. BACKFLOW PREVENTER AT LEAST 12" ABOVE THE HIGHEST PIPING OR OUTLET DOWNSTREAM OF THE DEVICE. ALL WORK TO BE DONE BY PARKS & GENERAL SERVICES.

IRRIGATION NOTES

- "REMOVE ALL EXISTING IRRIGATION EQUIPMENT" SHALL BE DEFINED AS REMOVING AND PROPERLY DISPOSING OF ALL EXISTING MANUAL VALVES, AUTOMATIC VALVES, BACKFLOW PREVENTERS, RISERS, SPRINKLER HEADS, BUBBLER HEADS, CONTROLLERS 120 VOLT CONDUIT AND CONDUCTORS, MANUAL DRAINS AND VALVE BOXES. EXISTING PIPING SHALL BE CAPPED AND ABANDONED.
- ALL IRRIGATION EQUIPMENT REMOVED FROM SOUTH SAN JOSE PARK SHALL BE RETURNED TO CITY OF ALBUQUERQUE, PARKS AND GENERAL SERVICES.
- ALL VALVE BOXES FOR AUTOMATIC VALVES SHALL BE INSTALLED AT A MINIMUM OF 12" FROM EDGES OF TURF.
- ALL VALVE BOXES SHALL BE SUPPORTED BY CINDER BLOCKS, (MINIMUM 2 PER VALVE BOX). INSTALL BLOCKS IN A MANNER WHICH WILL PREVENT CONTACT WITH PIPING, WIRES, VALVES, ETC.
- MARK ALL 24-VOLT WIRE ENDS WITH 3M STD-09 WIRE MARKER TAPE AT THE VALVE BOX AND CONTROLLER LOCATIONS.
- ALL 24-VOLT WIRE SHALL BE MARKED WITH A 4" WIDE YELLOW MARKER TAPE AND MARKED "WARNING-ELECTRICAL". LAY MARKER TAPE HORIZONTALLY 6" ABOVE WIRE.
- 24-VOLT WIRE SHALL BE IN COMMON TRENCH WITH MAINLINE AND SHALL HAVE SEPARATE SLEEVE WHERE CROSSING ALL HARD CONSTRUCTION. ALL SLEEVE PIPING FOR 24-VOLT WIRE SHALL BE 1-1/4" CLASS 200 PVC.
- CONTRACTOR SHALL EXTEND 120-VOLT A.C. FROM EXISTING POWER TO PROPOSED CONTROLLER LOCATION. ALL ELECTRICAL WORK SHALL BE PER LOCAL CODES AND N.E.C. STANDARDS.
- WHERE PROPOSED PIPING CROSSES EXISTING ASPHALT AND/OR CONCRETE, THE CONTRACTOR SHALL SAW-CUT, REMOVE AND PROPERLY DISPOSE OF WASTE, EXCAVATE, INSTALL SLEEVE PIPING, MAINS AND LATERALS, BACKFILL AND COMPACT TO 95%. CONTRACTOR SHALL REPLACE ASPHALT AND/OR CONCRETE TO MATCH EXISTING.
- THE CONTRACTOR SHALL ADJUST ALL VALVES, BUBBLERS, AND SPRINKLERS FOR OPTIMUM COVERAGE, AND SHALL PROVIDE AND INSTALL NOZZLES OTHER THAN THOSE SPECIFIED AS INSTRUCTED BY THE LANDSCAPE ARCHITECT AT NO ADDITIONAL COST TO THE OWNER.
- CONTRACTOR SHALL INSTALL ALL BUBBLERS ON HIGH SIDE OF TREE WELLS.
- CONTRACTOR SHALL TAPE CLOSED ALL SLEEVE PIPE OPENINGS USING DUCT TAPE TO PREVENT DEBRIS FROM ENTERING SLEEVES.
- ALL EXISTING DISTRIBUTION LINE LOCATIONS ARE SCHEMATIC. IT SHALL BE THE CONTRACTOR'S RESPONSIBILITY TO POT HOLE AND FIELD CHECK TO DETERMINE ACTUAL LOCATIONS AS AN INCIDENTAL REQUISITE TO THE CONSTRUCTION CONTRACT.
- THE PROPOSED CONTROLLER LOCATIONS INDICATED ON THE PLANS ARE APPROXIMATE. ACTUAL LOCATIONS OF THE CONTROLLER SHALL BE DETERMINED BY OWNERS REPRESENTATIVE IN THE FIELD.

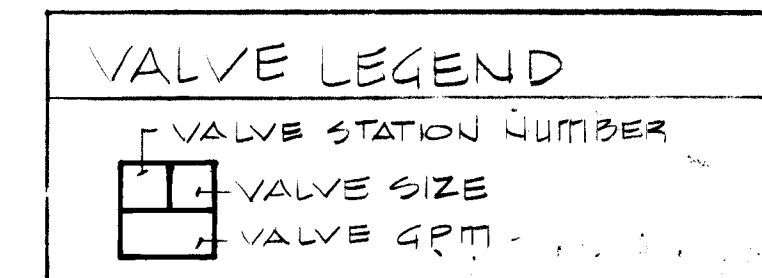

SEE DETAIL 4-20 FOR ITEMIZED VALVING LEGEND

TOPOGRAPHIC PLAT OF SOUTH SAN JOSE COMMUNITY CENTER AND PARK

COMPRISED OF BLOCKS 16, 17, 18 & 19 OF LOWER BROADWAY ADDITION

FILED SEP. 13, 1992 IN BOOK DL PAGE 32


AND TRACT 58A OF MRGCD MAP NO 44 BERNALILLO COUNTY, NEW MEXICO

FEB. 27, 1992


0 10' 20' 40' 60'

1" = 20'-0"

MORROW & COMPANY, LTD.
LANDSCAPE ARCHITECTS
510 La Veta N.E.
ALBUQUERQUE, N.M. 87106
PH: 505 265-2288 FAX: 505 265-9087

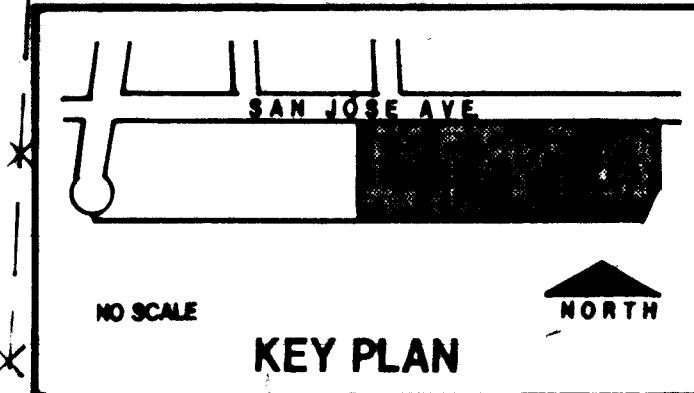

NOVEMBER 19, 1992 20/11037.14031/21PARKS/2-20-92/PLM					
CITY OF ALBUQUERQUE PARKS/GENERAL SERVICES DESIGN & DEVELOPMENT					
TITLE: SOUTH SAN JOSE PARK RENOVATION IRRIGATION PLAN, EAST					
APPROVALS	ENGINEER	DATE	APPROVALS	ENGINEER	DATE
DRC CHAIRMAN	12-10-92	12-10-92	WATER	N/A RWE	11-30-92
TRANSPORTATION	12-01-92	12-01-92	WASTE WATER	N/A RWE	11-30-92
HYDROLOGY	12-01-92	12-01-92			
PARKS	11-30-92	11-30-92			
PROJECT NO.	4349.90	MAP NO.	M-14-Z	SHEET	11 OF 20

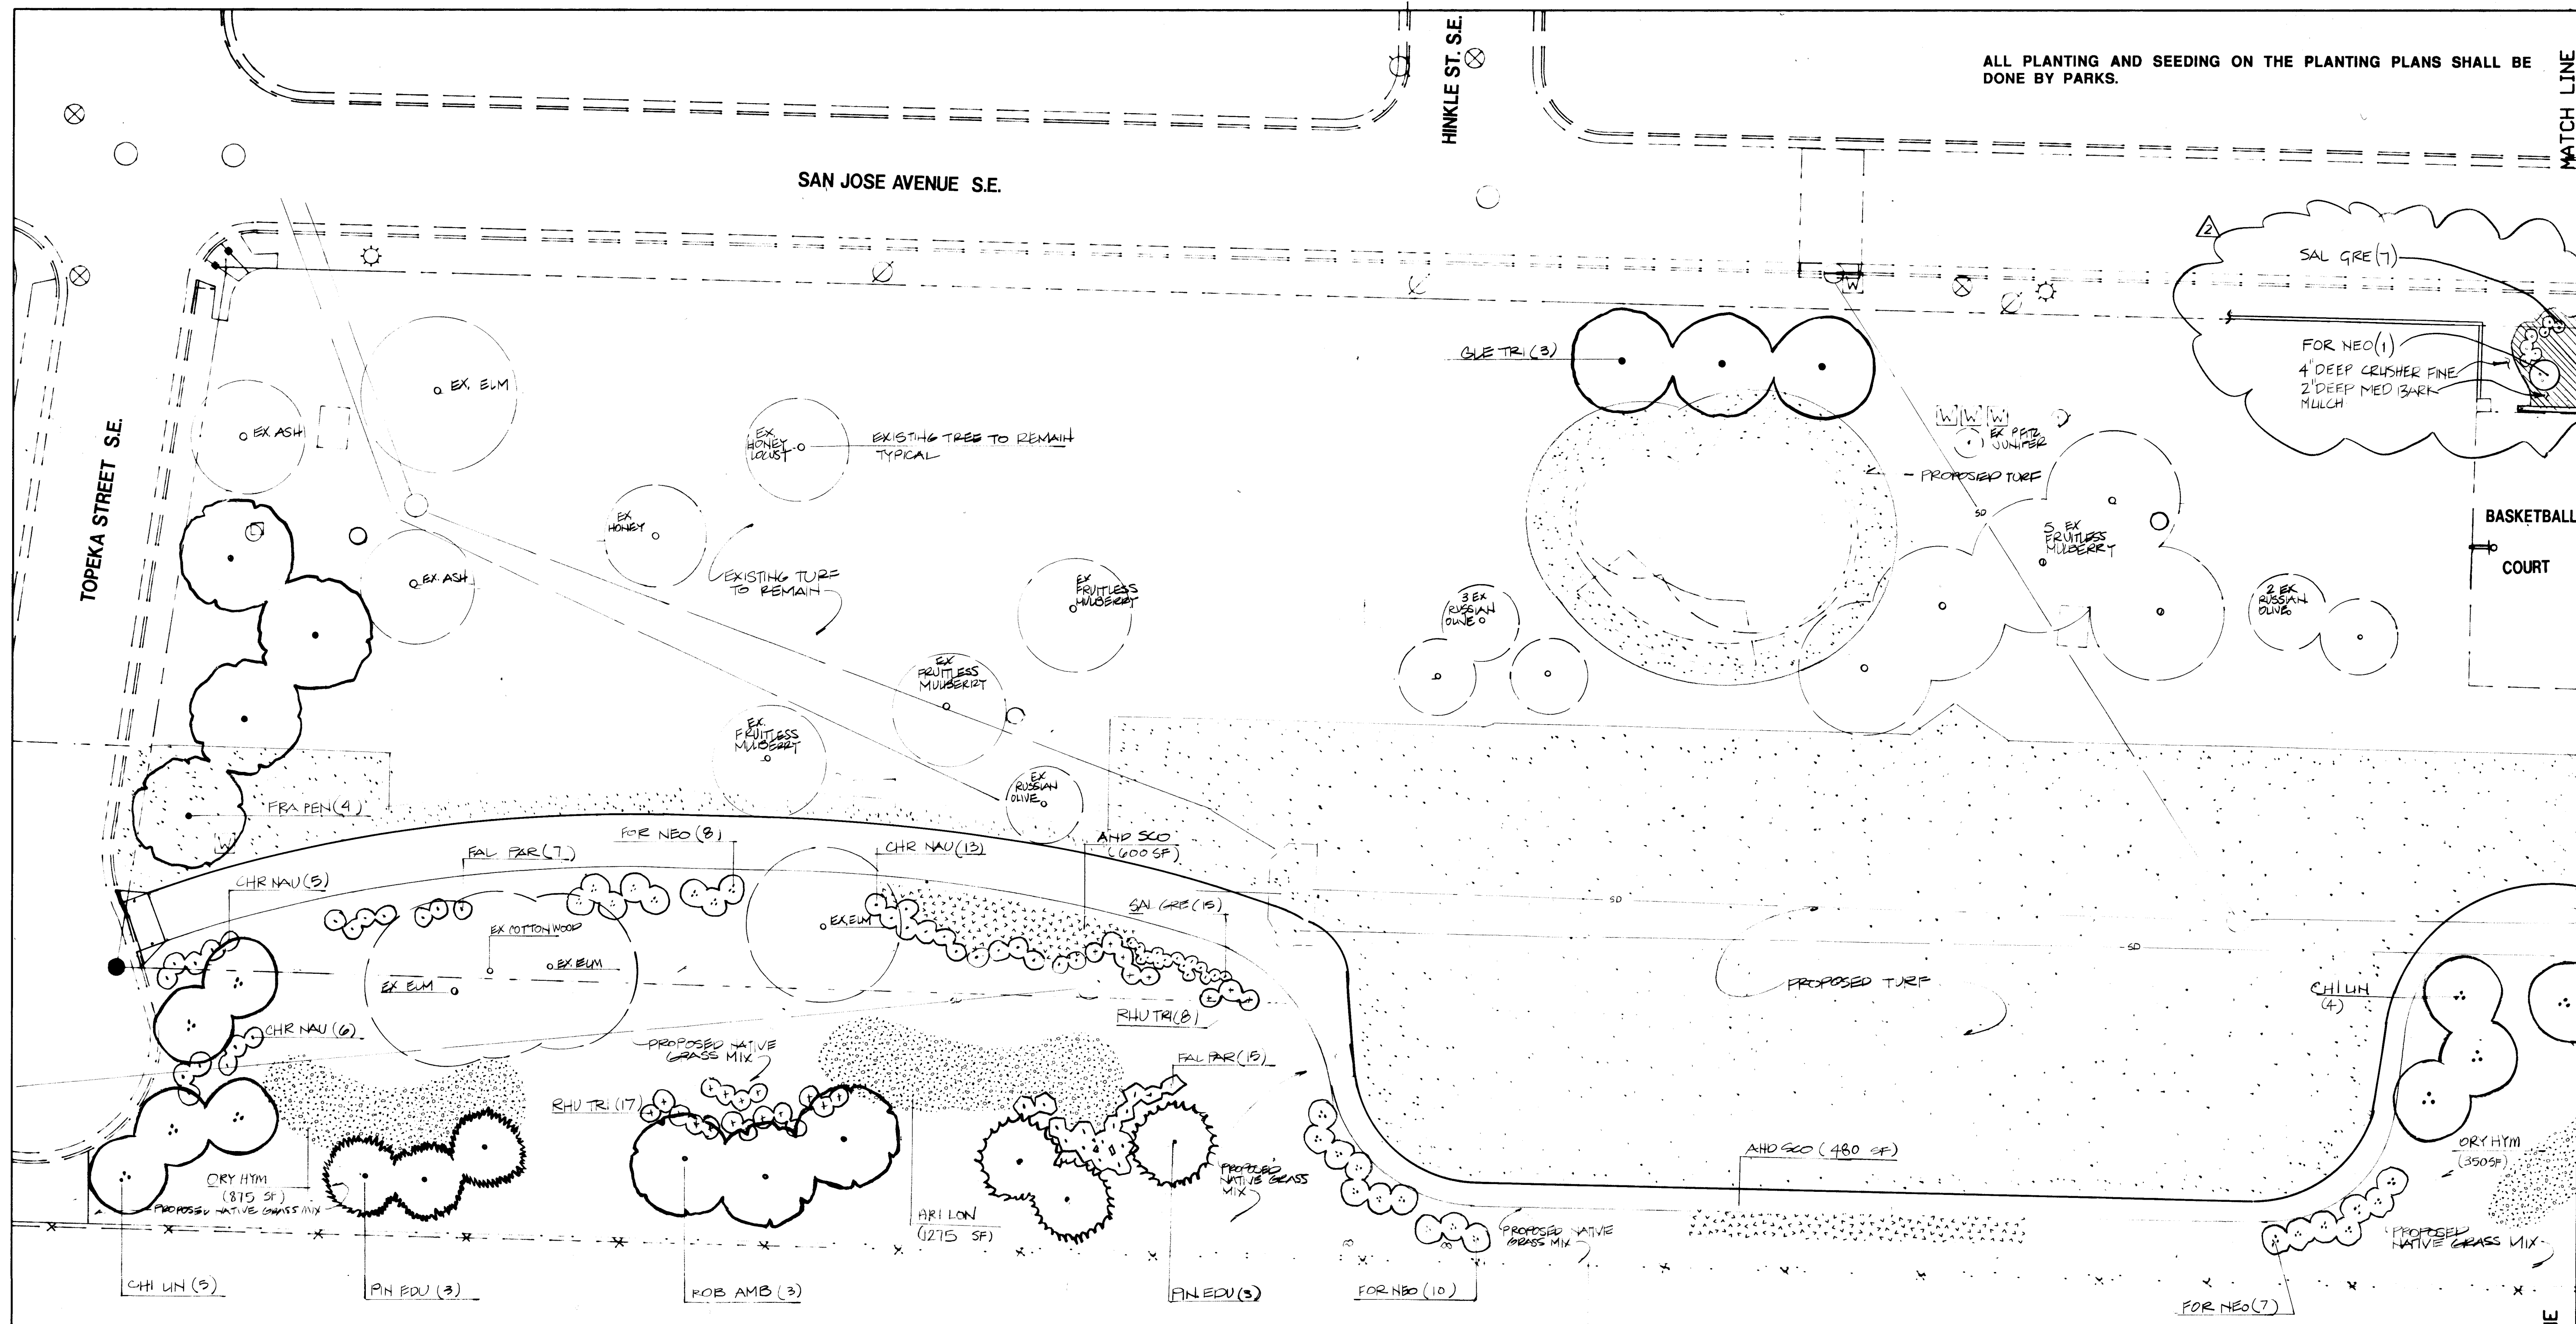


ALL PLANTING AND SEEDING ON THE PLANTING PLANS SHALL BE DONE BY PARKS.

PLANT LIST

SYMBOL	BOTANICAL NAME	COMMON NAME	QUANTITY	INSTALLED	MATURE	REMARKS
TREES						
CHI LIN	Chilopsis linearis	Desert Willow	13	2" cal., 10'-12" ht., 3' min. spd.	25' ht., 20' spd.	24" box
FRA PEN	Fraxinus pennsylvanica 'Marshall'	'Marshall' Seedless Green Ash	12	2" cal., 12'-14" ht., 3' min. spd.	50' ht., 40' spd.	24" box
FRA VEL	Fraxinus velutina 'Modesto'	Modesto Ash	2	2" cal., 12'-14" ht., 3' min. spd.	50' ht., 30' spd.	24" box
GLE TRI	Gleditsia triacanthos 'Imperial'	Imperial Honey Locust	5	2" cal., 12'-14" ht., 3' min. spd.	35' ht., 35' spd.	24" box
KOE PAN	Koelerutaria paniculata	Goldenrain Tree	6	2" cal., 12'-14" ht., 3' min. spd.	25' ht., 25' spd.	24" box
PIN EDU	Pinus edulis	Pinon Pine	4	6'-8" ht., 3' min. spd.	15' ht., 13' spd.	24" box
PIN NIG	Pinus nigra	Austrian Pine	3	6'-8" ht., 3' min. spd.	30' ht., 20' spd.	24" box
ROB AMB	Robinia ambigua 'Purple Robe'	Purple Robe Locust	3	2" cal., 12'-14" ht., 3' min. spd.	45' ht., 30' spd.	24" box
SHRUBS						
CHR NAU	Chrysothamnus nauseosus	Rubber Rabbitbrush	75	2'-3" ht.	6' ht.	5 gallon
FAL PAR	Fallugia paradoxa	Apache Plume	49	2'-3" ht.	6' ht.	5 gallon
FOR NEO	Forestiera neomexicana	New Mexico Privet	25	2'-3" ht.	12' ht.	5 gallon

SYMBOL	BOTANICAL NAME	COMMON NAME	QUANTITY	INSTALLED	MATURE	REMARKS
JUN SAB	Juniperus sabina 'Tamariscifolia'	Tam Juniper	87 41	1' ht., 18" spd.	1'-1/2' ht. 10" spd.	5 gallon
RHU TRI	Rhus trilobata	Skunkbush	74 54	2'-3" ht., 18" min. spd.	5' ht.	5 gallon
SAL GRE	Salvia gregii	Autumn Sage	74	1' ht., 1' spd.	3' ht., 3' spd.	5 gallon
TURF GRASS MIX			65500 SF			
	Festuca elatior 'Falcon' Lolium perenne 'Pennington' Poa pratensis 'Adelphi'	Falcon Fescue Penfline Perennial Ryegrass Adelphi Blue Grass		Seed	---	Seed at 250 lbs PLS per acre with equal amounts (by weight) of each.
NATIVE GRASS MIX			51700 SF			
	Buchloe dactyloides Bouteloua gracilis	Buffalo Grass Blue Grama		Seed	1'-1/2' ht.	Seed @ 50 lbs PLS per acre with equal amounts weight) of each.
NATIVE ACCENT GRASSES AND FLOWERS						
AND SCO	Andropogon scoparius	Little Bluestem	1,680 SF	Seed	2' ht.	Seed @ 4 lbs. PLS/1000 SF
ARL LON	Aristida longistata	Purple Threawn	1,275 SF	Seed	1' ht.	Seed @ 4 lbs. PLS/1000 SF
ORY HYM	Oryzopsis hymenoides	Indian Ricegrass	1,975 SF	Seed	1'-2" ht.	Seed @ 4 lbs. PLS/1000 SF

FOR GENERAL PLANTING NOTES SEE SHEET 13

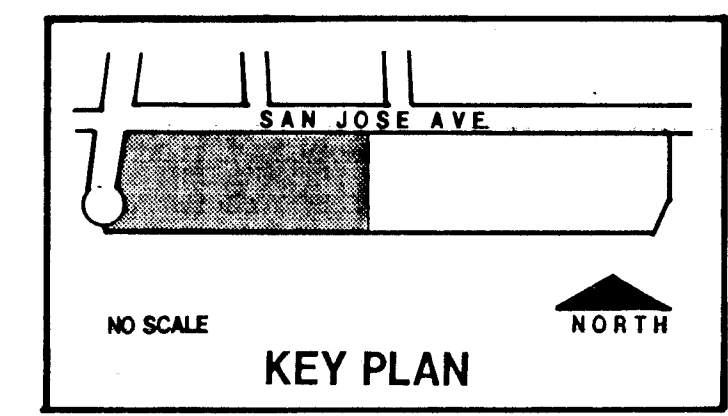


24-4349.1901296

TOPOGRAPHIC PLAN OF SOUTH SAN JOSE COMMUNITY CENTER AND PARK. COMPILED BY BLUICKS 16, 17, 18 & 19 OF LOWER BROADWAY ADDITION. FILED SEP. 13, 1963 IN BOOK DL PAGE 32. AND TRACT SBA OF MRCO MAP NO. 44 BERNALILLO COUNTY, NEW MEXICO. FEB. 27, 1992

0 10' 20' 40' 60' 1" = 20'-0"

MORROW & COMPANY, LTD. LANDSCAPE ARCHITECTS. 810 La Torre N.E. ALBUQUERQUE, N.M. 87106. TEL: 253-2500 FAX: 253-2500


NOVEMBER 19, 1992 20/11037.14021/24/PAK/2-30-92/DLM					
CITY OF ALBUQUERQUE PARKS/GENERAL SERVICES DESIGN & DEVELOPMENT					
TITLE: SOUTH SAN JOSE PARK RENOVATION PLANTING PLAN, WEST					
APPROVALS	ENGINEER	DATE	APPROVALS	ENGINEER	DATE
DRC CHAIRMAN	B. B. B. B.	12-10-92	WATER	N/A R/W	11-30-92
TRANSPORTATION	N/A R/W	12-02-92	WASTE WATER	N/A R/W	11-30-92
HYDROLOGY	N/A R/W				
PARCE	S. B. B.	11/10/92			
PROJECT NO.	4349.90		MAP NO.	M-14-Z	
			SHEET	12	20

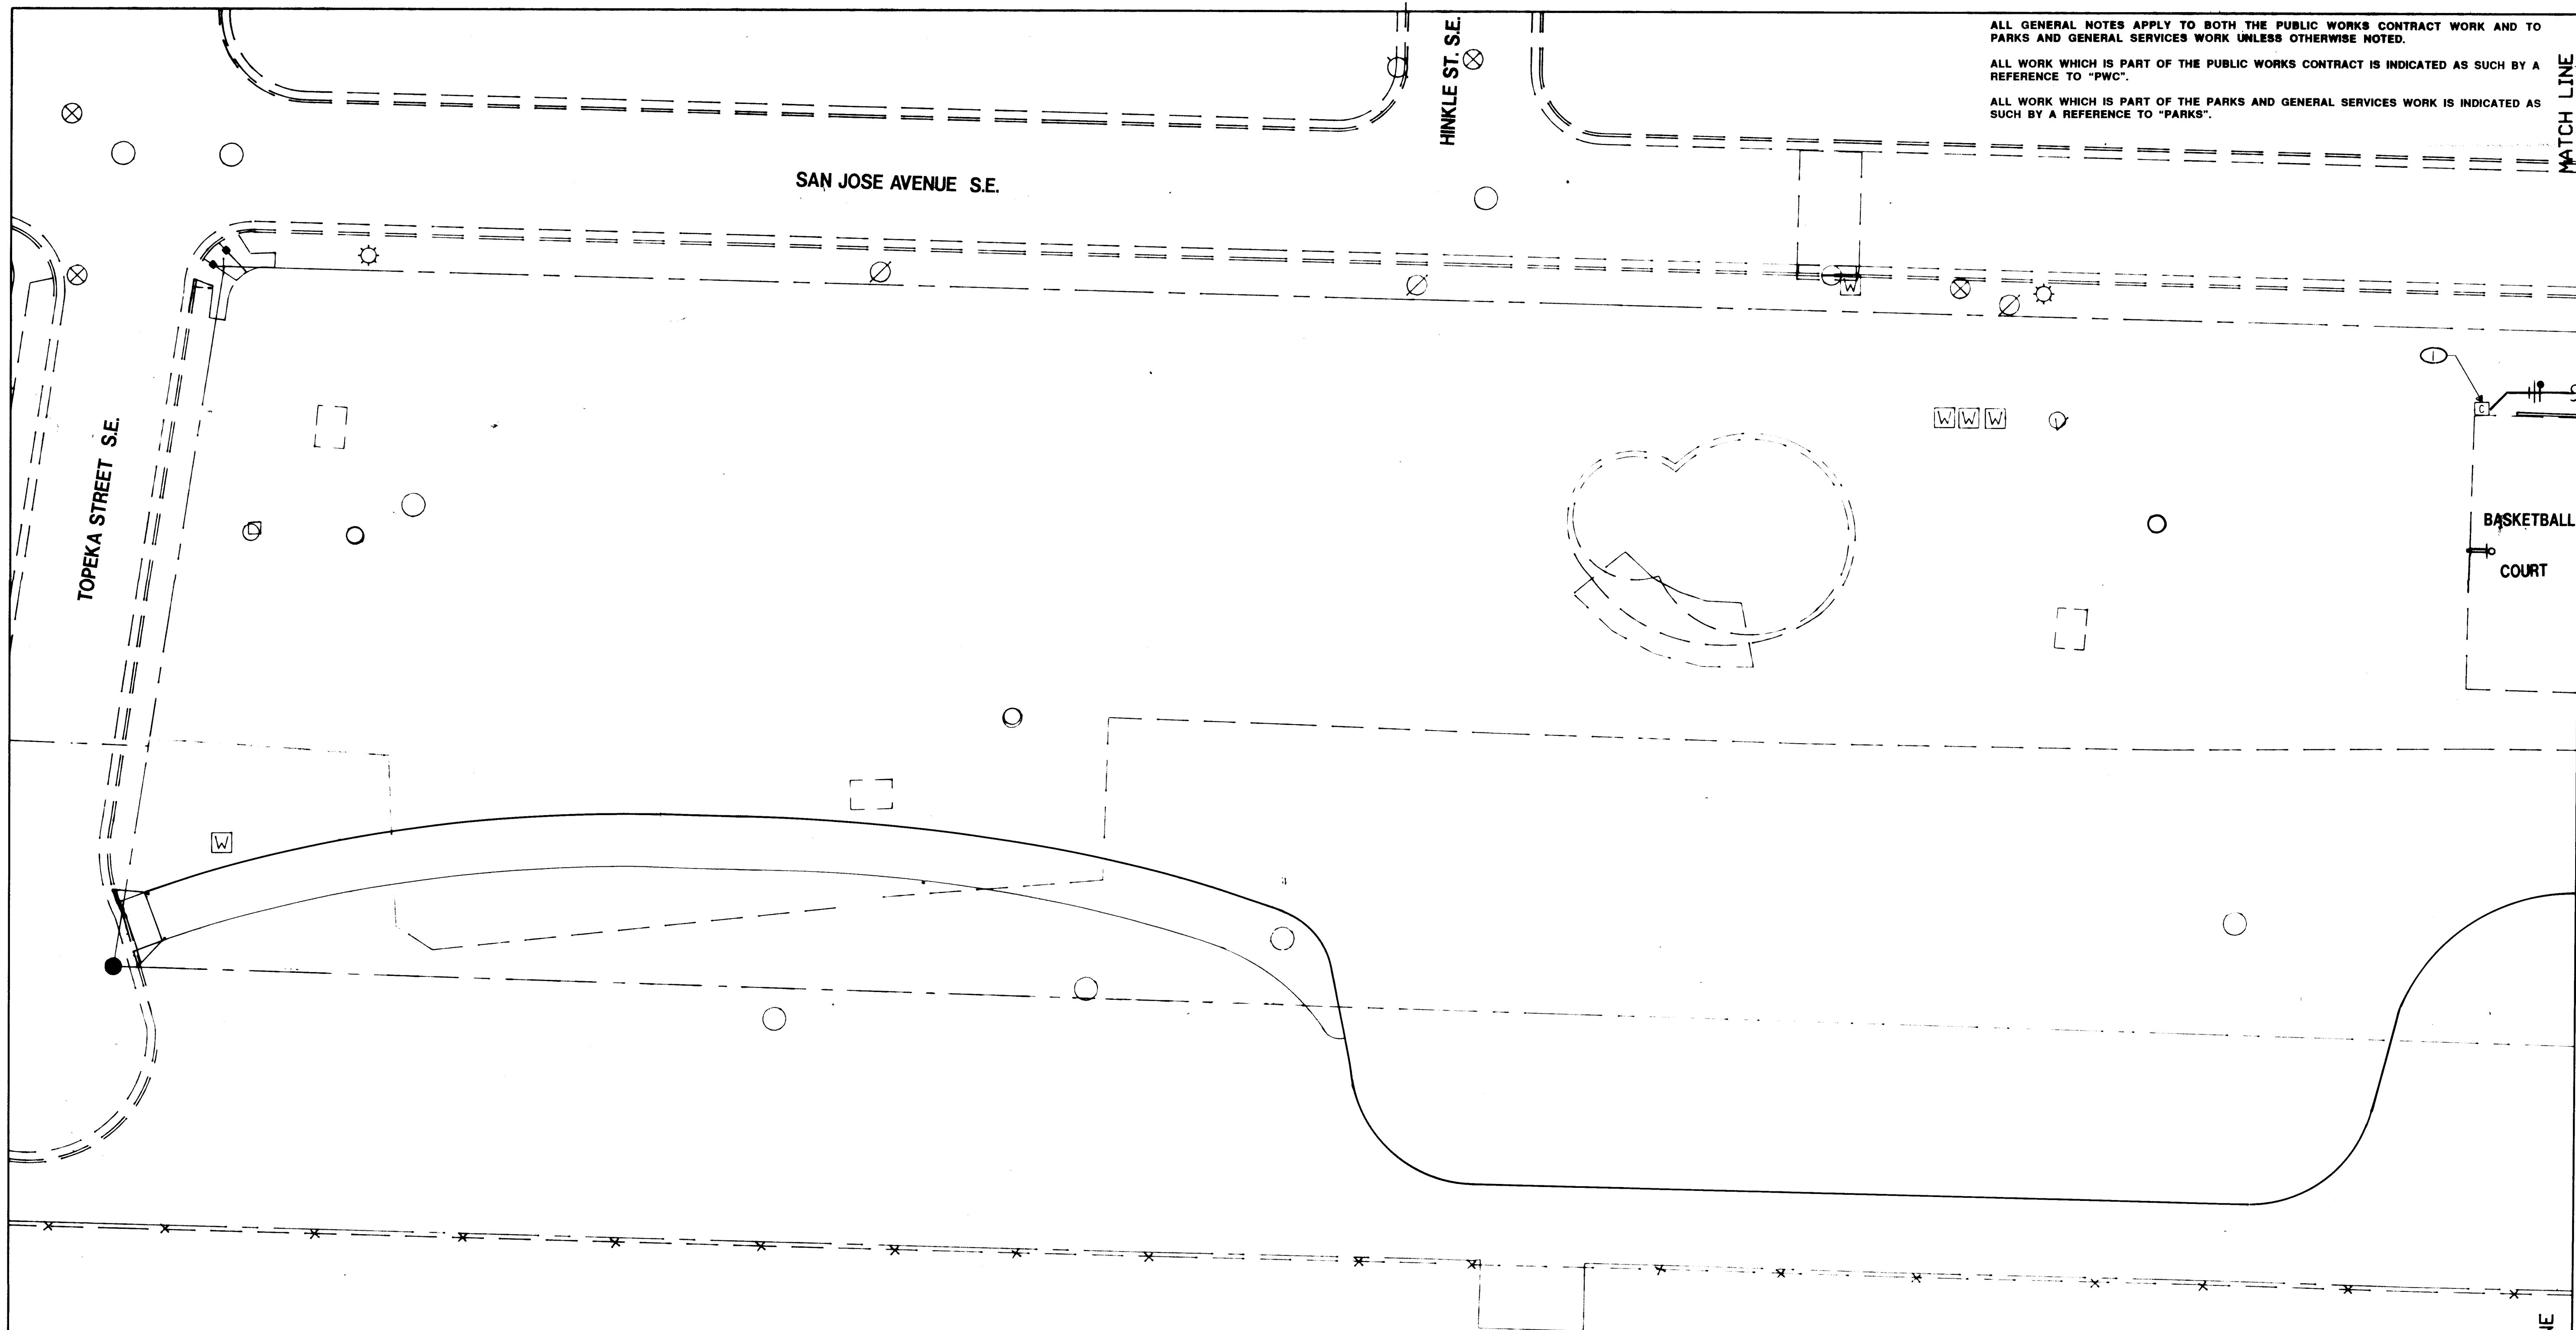

ALL GENERAL NOTES APPLY TO BOTH THE PUBLIC WORKS CONTRACT WORK AND TO PARKS AND GENERAL SERVICES WORK UNLESS OTHERWISE NOTED.


ALL WORK WHICH IS PART OF THE PUBLIC WORKS CONTRACT IS INDICATED AS SUCH BY A REFERENCE TO "PWC".

ALL WORK WHICH IS PART OF THE PARKS AND GENERAL SERVICES WORK IS INDICATED AS SUCH BY A REFERENCE TO "PARKS".

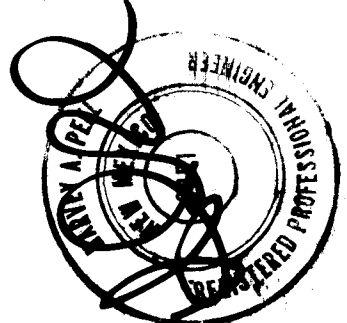AS BUILT INFORMATION			BENCH MARKS			SURVEY INFORMATION			ENGINEER'S SEAL		
CONTRACTOR	DATE	BY	CONTRACTOR	DATE	BY	NO.	BY	DATE	 11-2-92		
FIELD BY	DATE	BY	FIELD BY	DATE	BY	NO.	BY	DATE			
REVISION BY	DATE	BY	REVISION BY	DATE	BY	NO.	BY	DATE			
REVISION BY	DATE	BY	REVISION BY	DATE	BY	NO.	BY	DATE			
MICRO-FILM INFORMATION			MICRO-FILM INFORMATION			MICRO-FILM INFORMATION			MICRO-FILM INFORMATION		
RECORDED BY	DATE	BY	RECORDED BY	DATE	BY	RECORDED BY	DATE	BY	RECORDED BY	DATE	BY

KEYED NOTES

- ① NEW IRRIGATION CONTROLLER, RECONNECT TO EXISTING 120 VOLT CIRCUIT. (WORK BY PARKS)

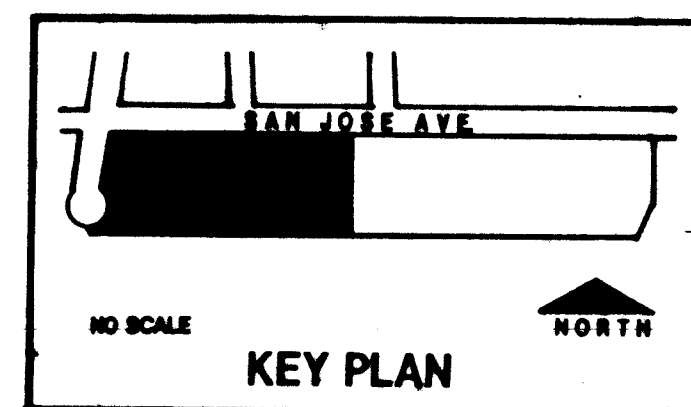

1 2 3 4 5 6 7 8 9 10 11 12 13 14 15
26-4349-190-1496


TOPOGRAPHIC PLAT OF
SOUTH SAN JOSE
COMMUNITY CENTER AND PARK
COMPRISED OF
BLOCKS 16, 17, 18 & 19 OF
LOWER BROADWAY ADDITION
FILED SEP. 13, 1923
IN BOOK DL PAGE 32
AND TRACT 58A OF MRGCD MAP NO. 44
BERNALILLO COUNTY, NEW MEXICO
FEB. 27, 1992


0 10' 20' 40' 60'
1" = 20'-0"

SCANNED BY
BY LASON


 **MORROW & COMPANY, LTD.**
LANDSCAPE ARCHITECTS
210 La Toma N.E.
ALBUQUERQUE, N.M. 87102
PH: 505 262-2800 FAX: 505 262-0087

NOVEMBER 19, 1992 20/21037.1401/S/PARK/5-20-92/DLM					
CITY OF ALBUQUERQUE PARKS/GENERAL SERVICES DESIGN & DEVELOPMENT					
TITLE: SOUTH SAN JOSE PARK RENOVATION ELECTRICAL PLAN, WEST					
APPROVALS	ENGINEER	DATE	APPROVALS	ENGINEER	DATE
DRC CHAIRMAN	<i>[Signature]</i>	12-10-92	WATER	N/A RWK	11-30-92
TRANSPORTATION	N/A RHW	12-02-92	WASTE WATER	N/A RWK	11-30-92
HYDROLOGY	N/A RWC	11-8-92			
PARKS	<i>[Signature]</i>	11/30/92			
PROJECT NO.	4349.90	MAP NO.	M-14-Z	SHEET	14 OF 20

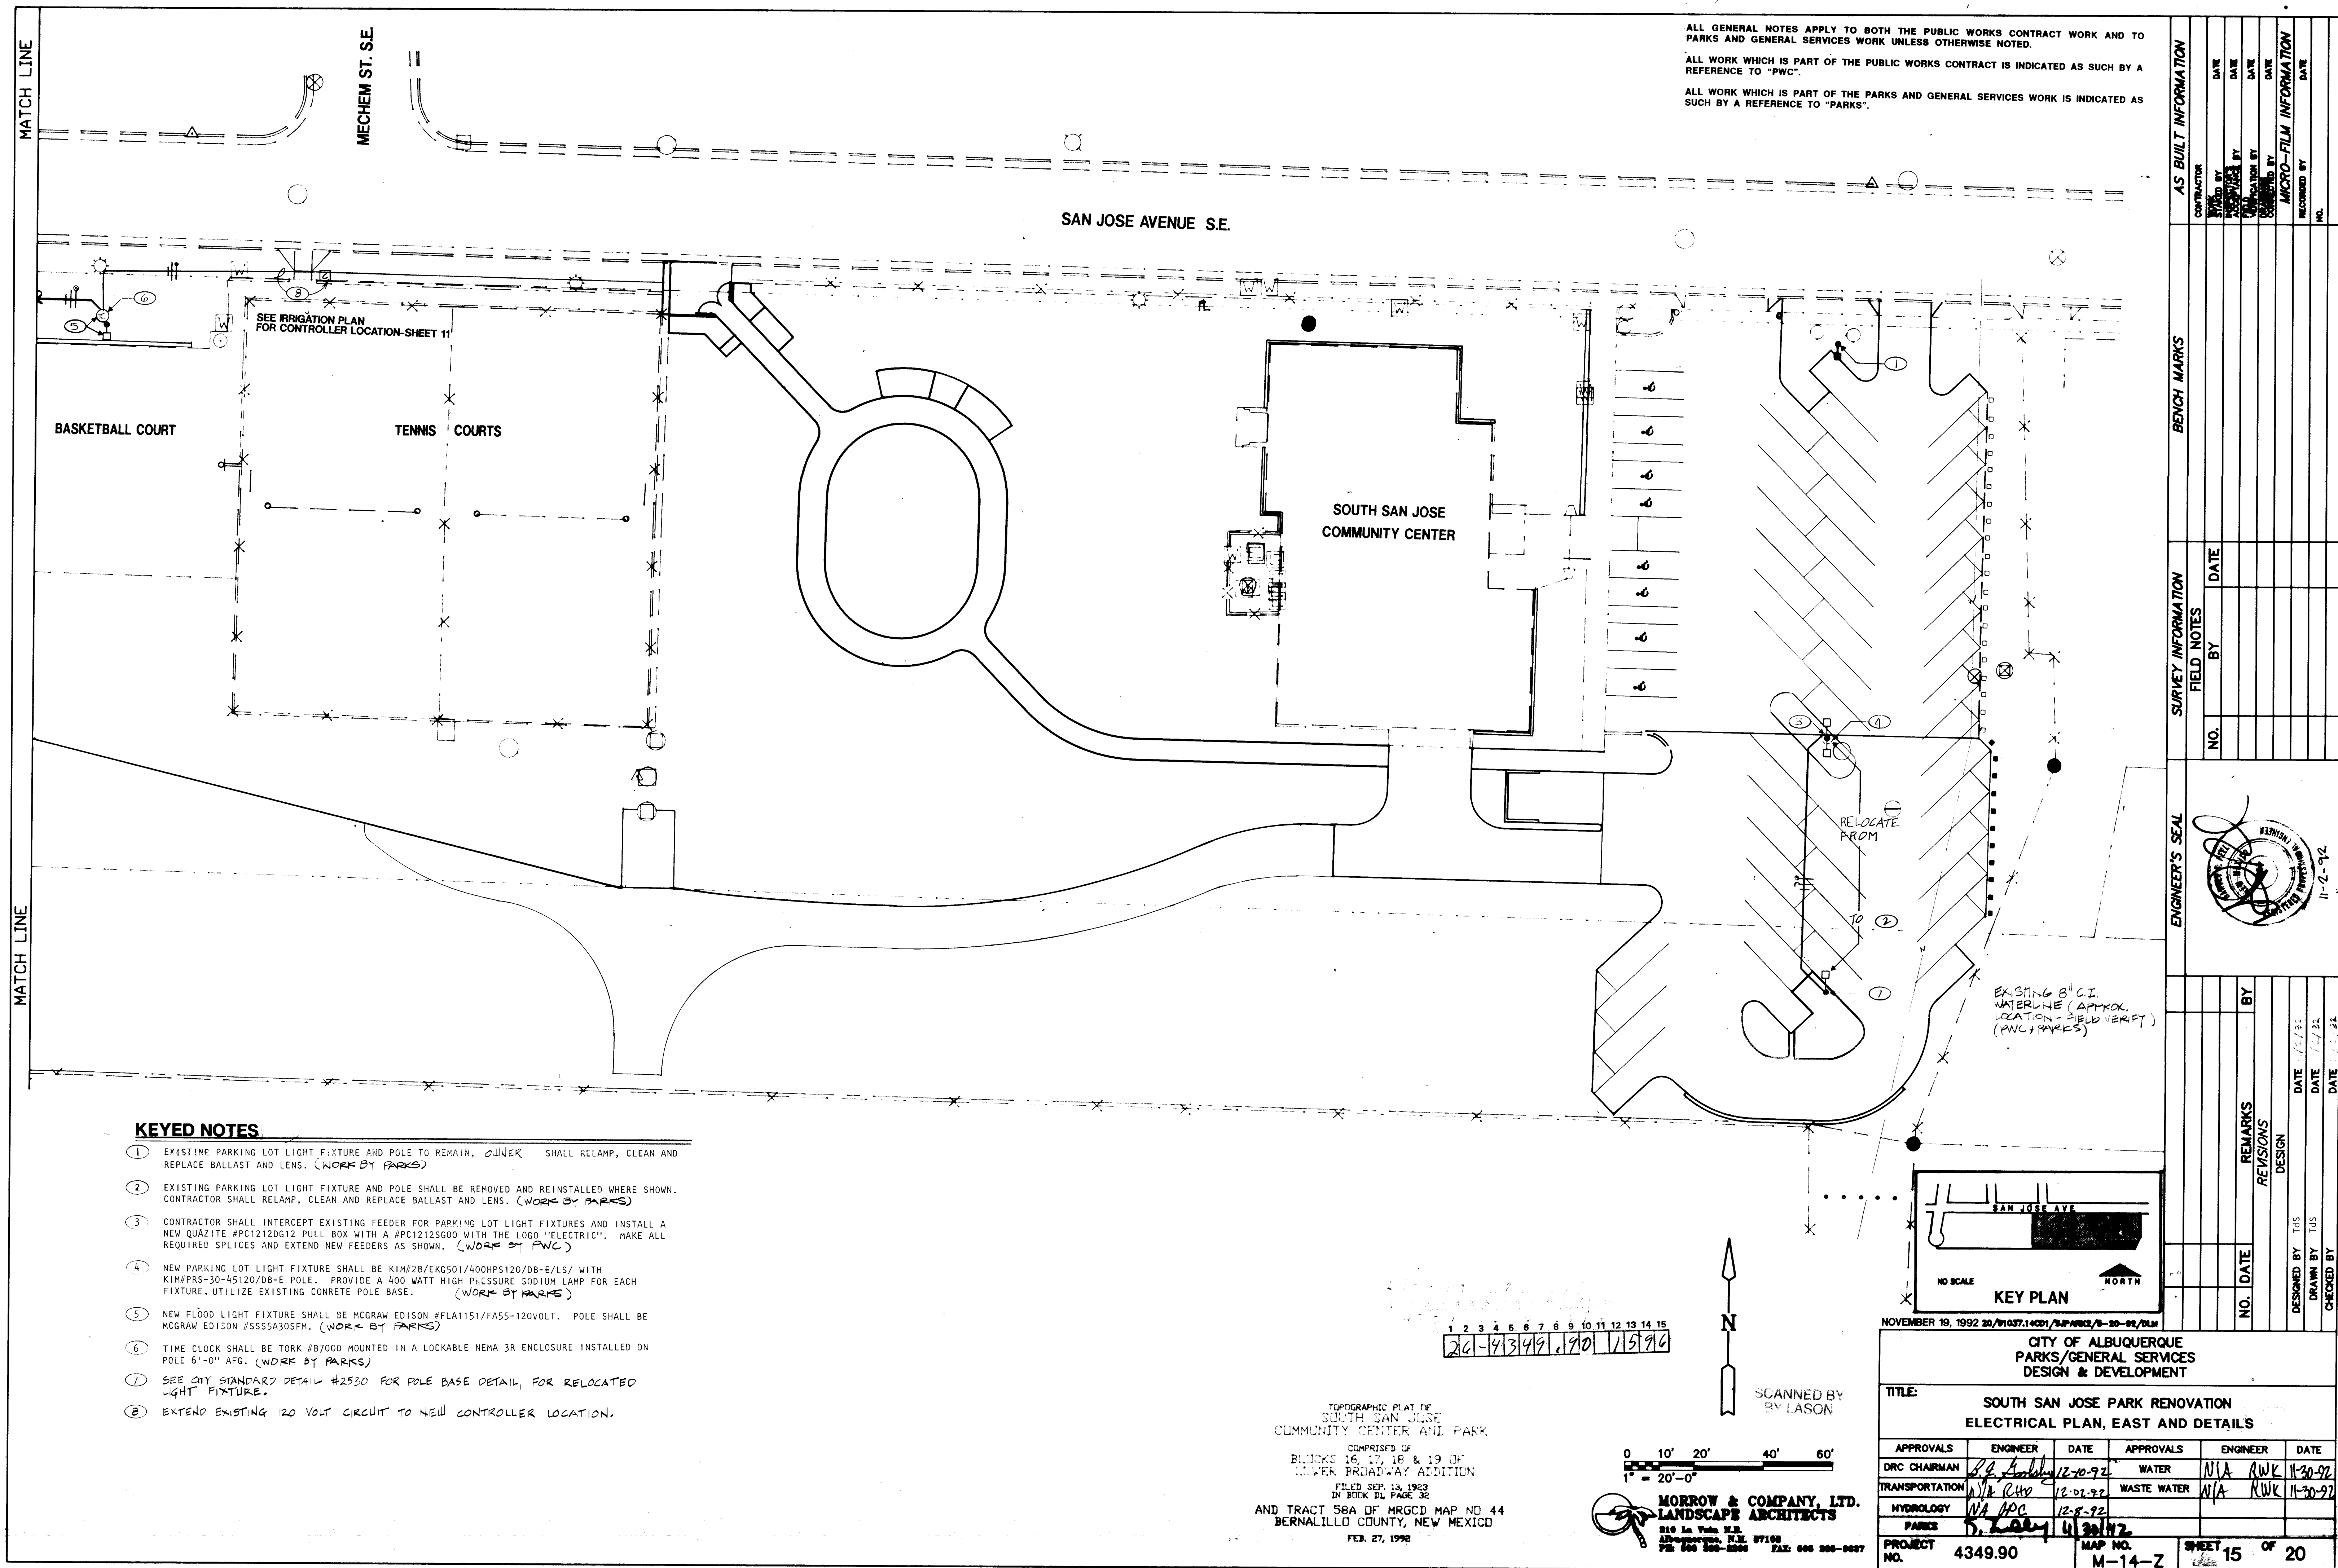


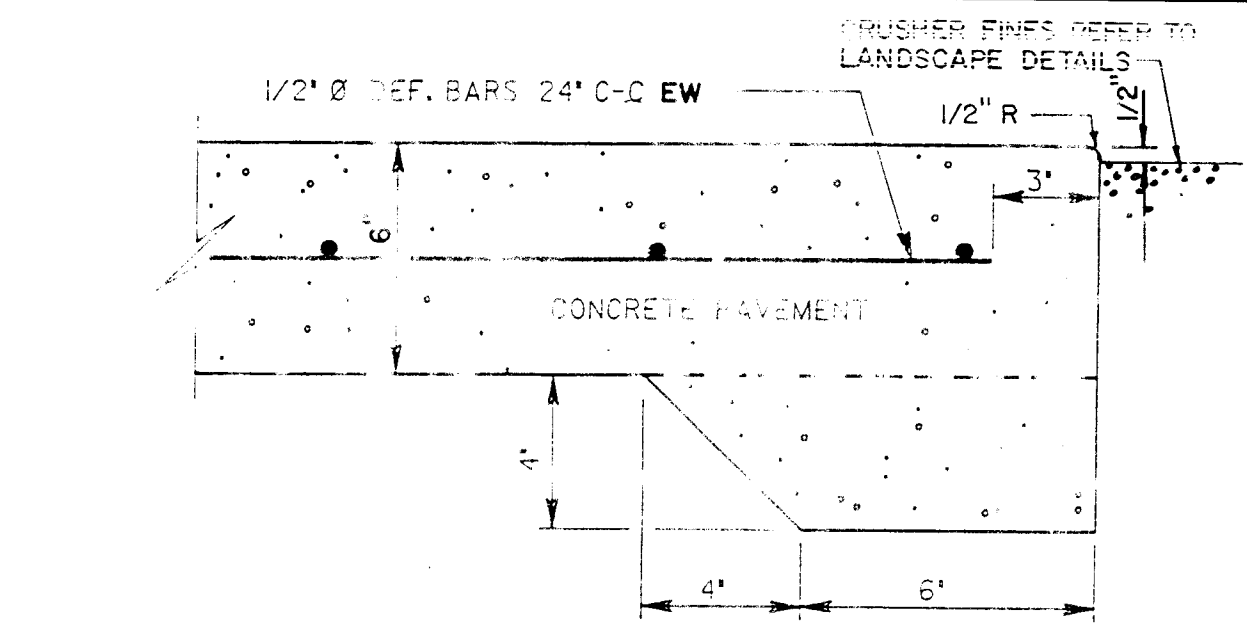


1
16
STANDARD PAVING HEADER
NOT TO SCALE

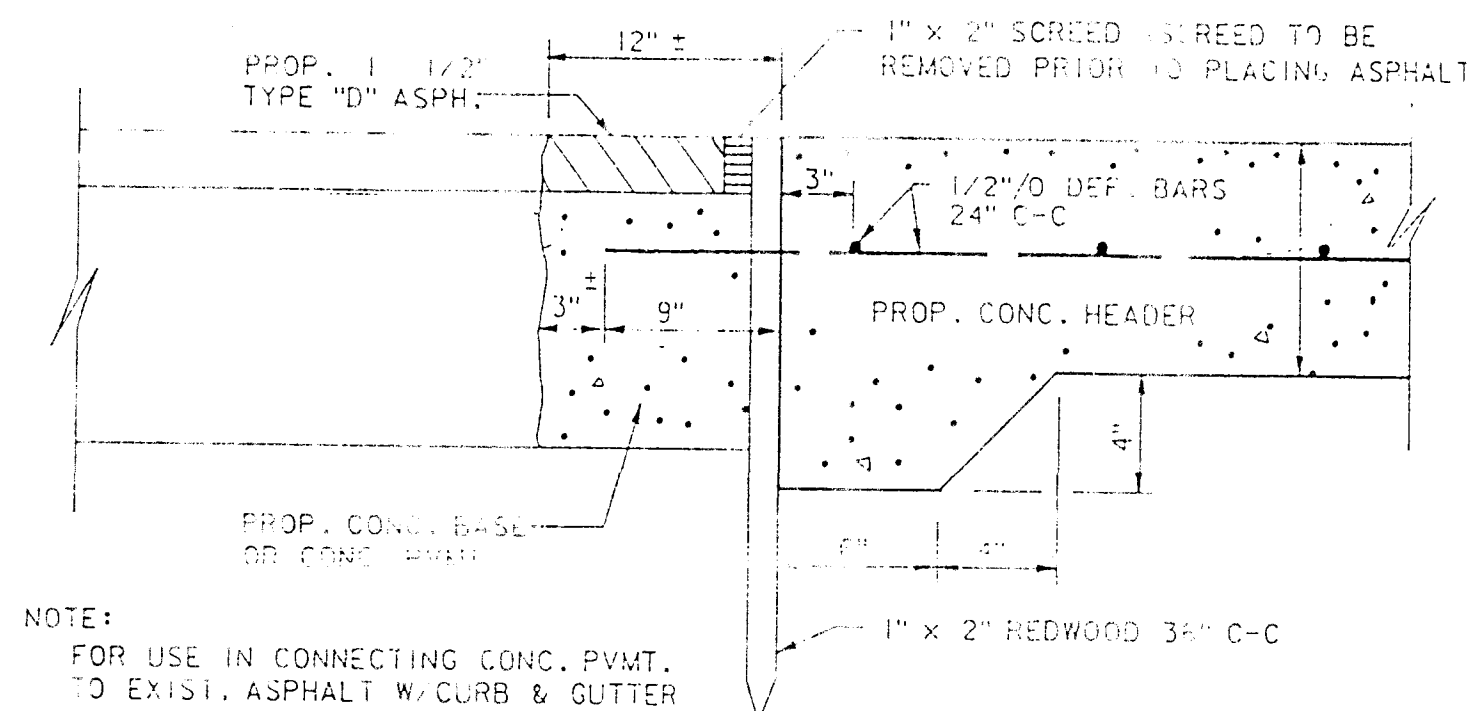


2
16
CONCRETE / ASPHALT
PAVING HEADER

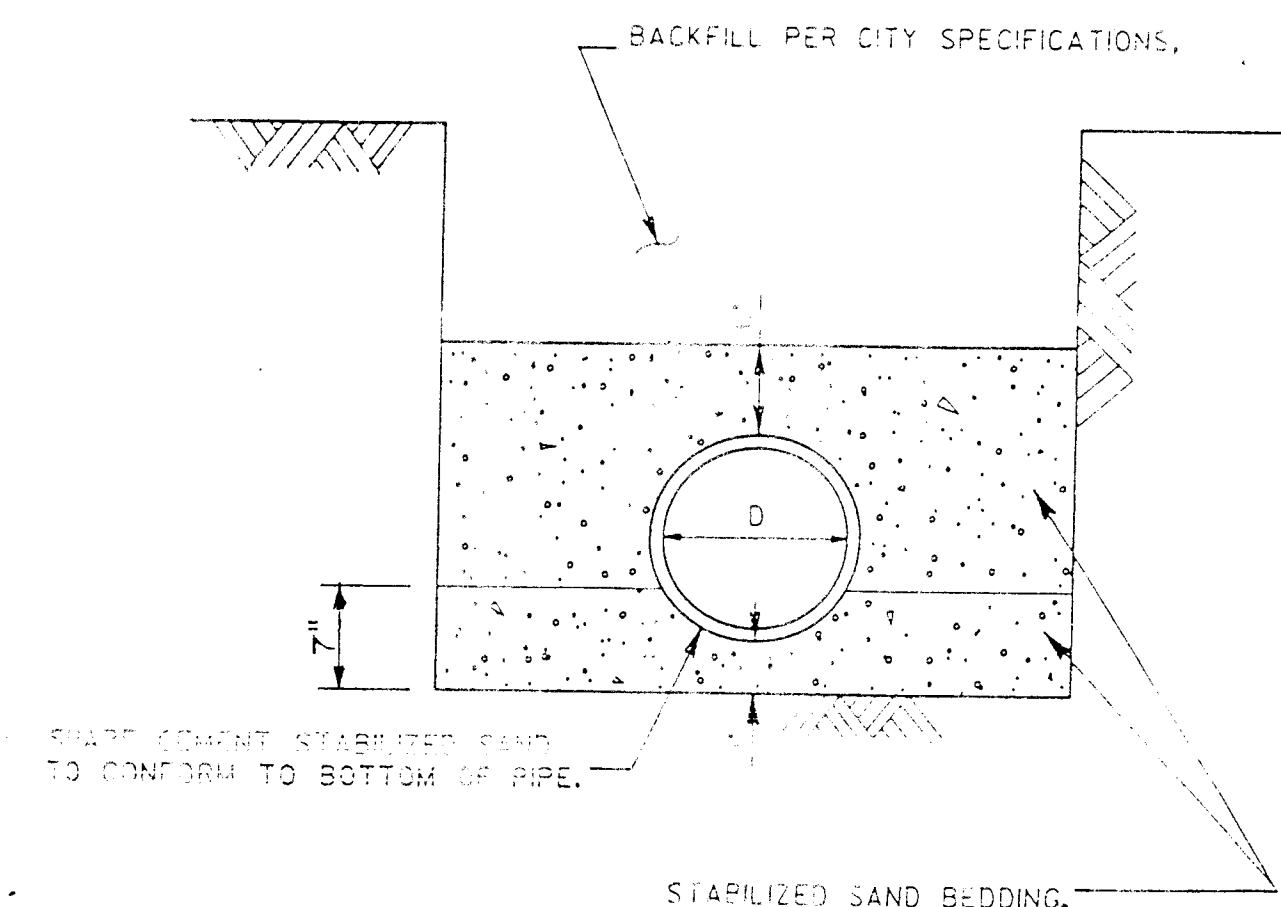


3
16
BEDDING DETAILS FOR 36" DIA.
& SMALLER REINFORCED CONCRETE
PIPE STORM SEWERS
NOT TO SCALE

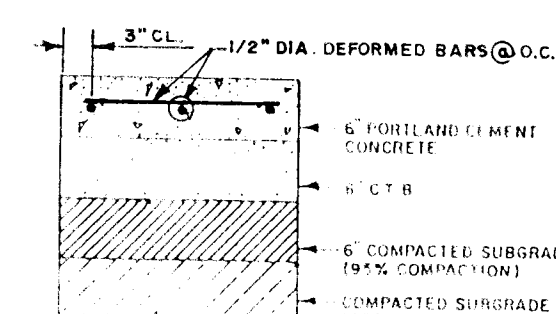


4
16
CONCRETE PAVING DETAIL

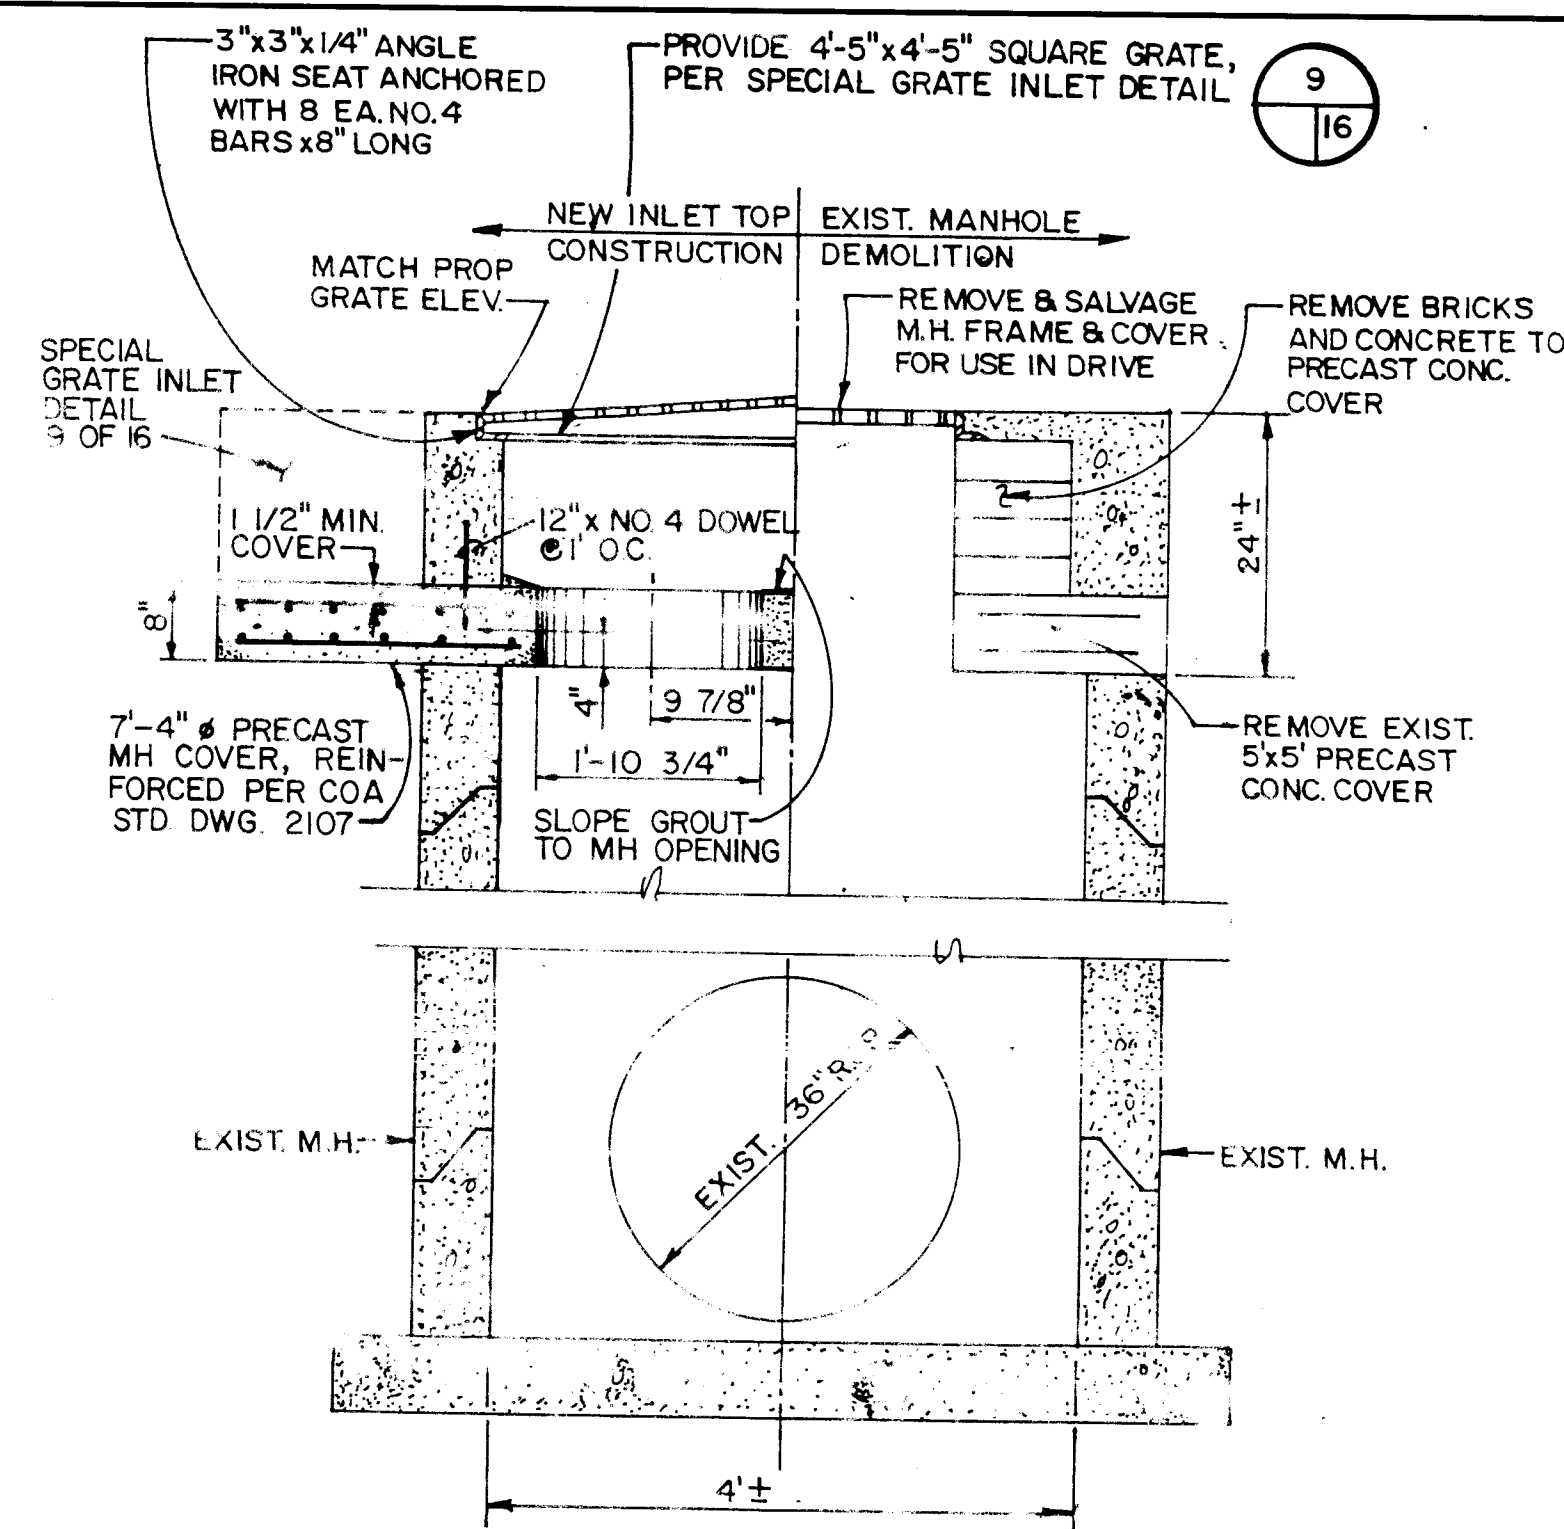


5
16
DETAIL FOR SPECIAL GRATE INLET
ON EXISTING STORM MANHOLE

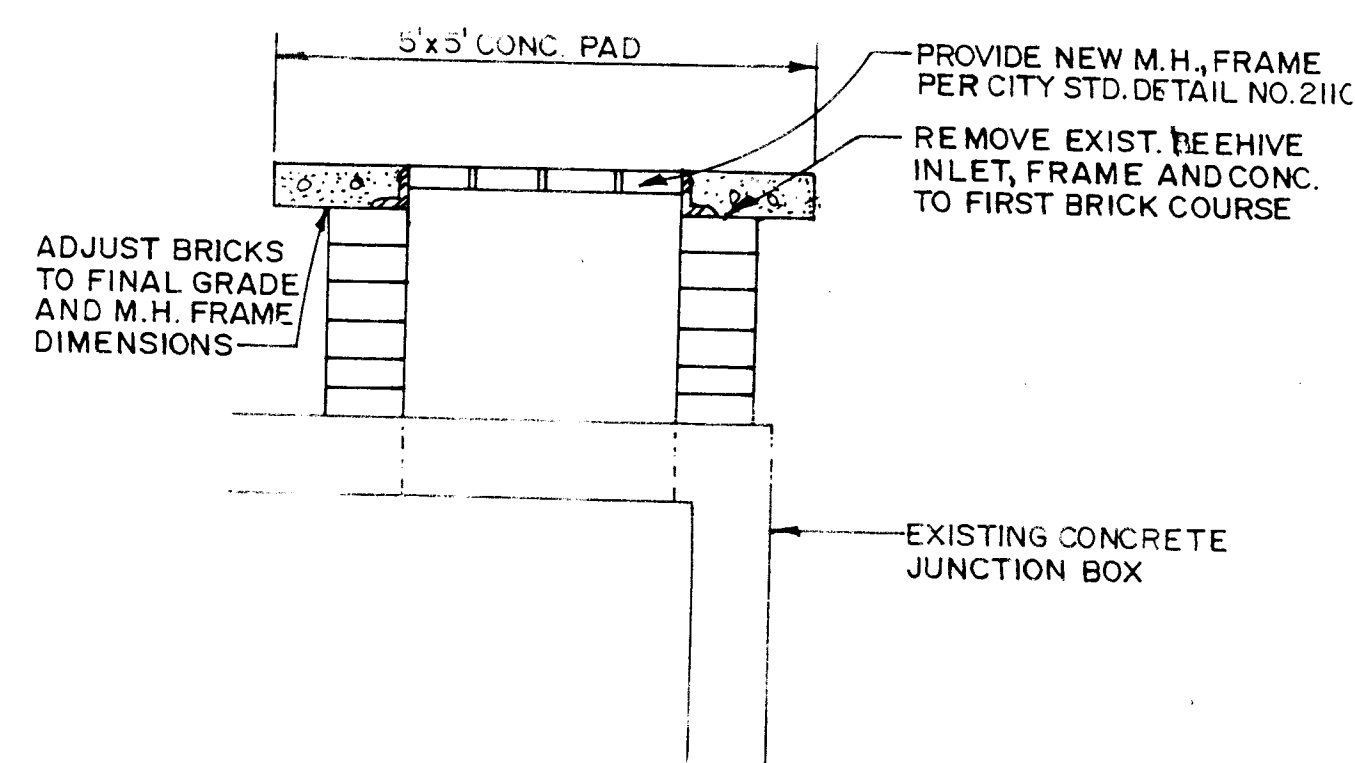


6
16
DETAIL FOR CONVERTING BEEHIVE
INLET TO STORM MANHOLE

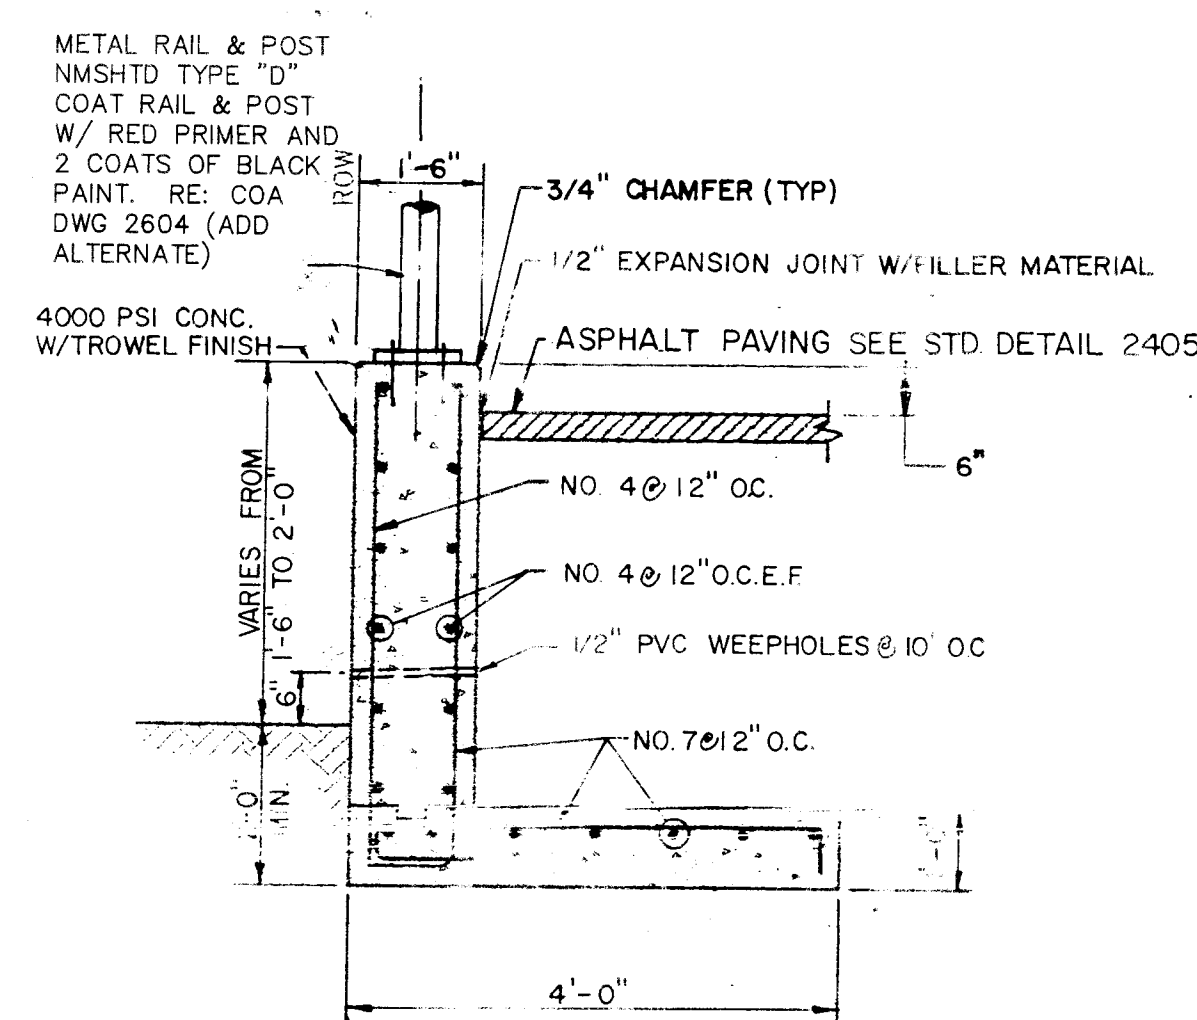


7
16
RETAINING WALL SECTION
NOT TO SCALE

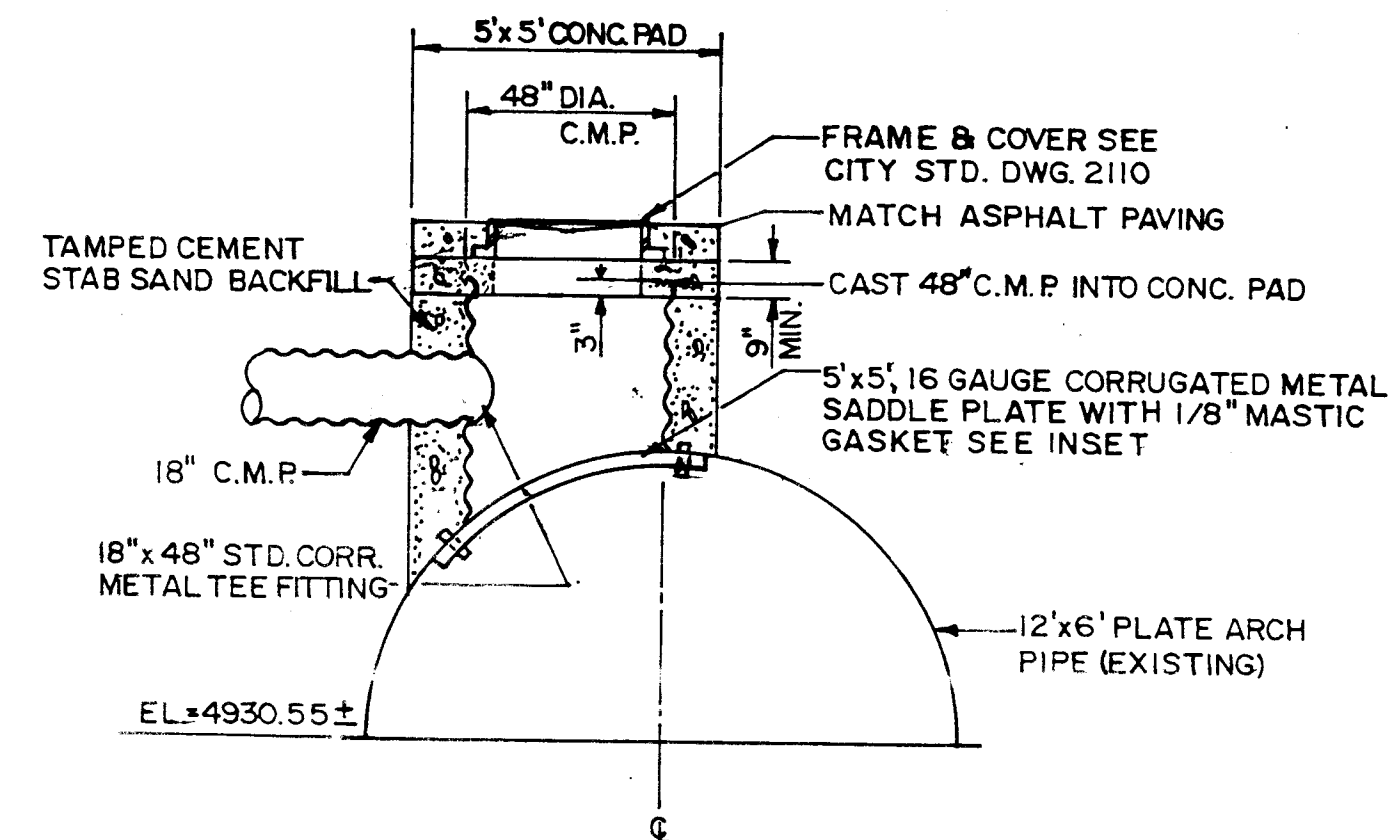

8
16
DETAIL FOR SPECIAL CMP MANHOLE
ON EXISTING PLATE ARCH PIPE
NOT TO SCALE

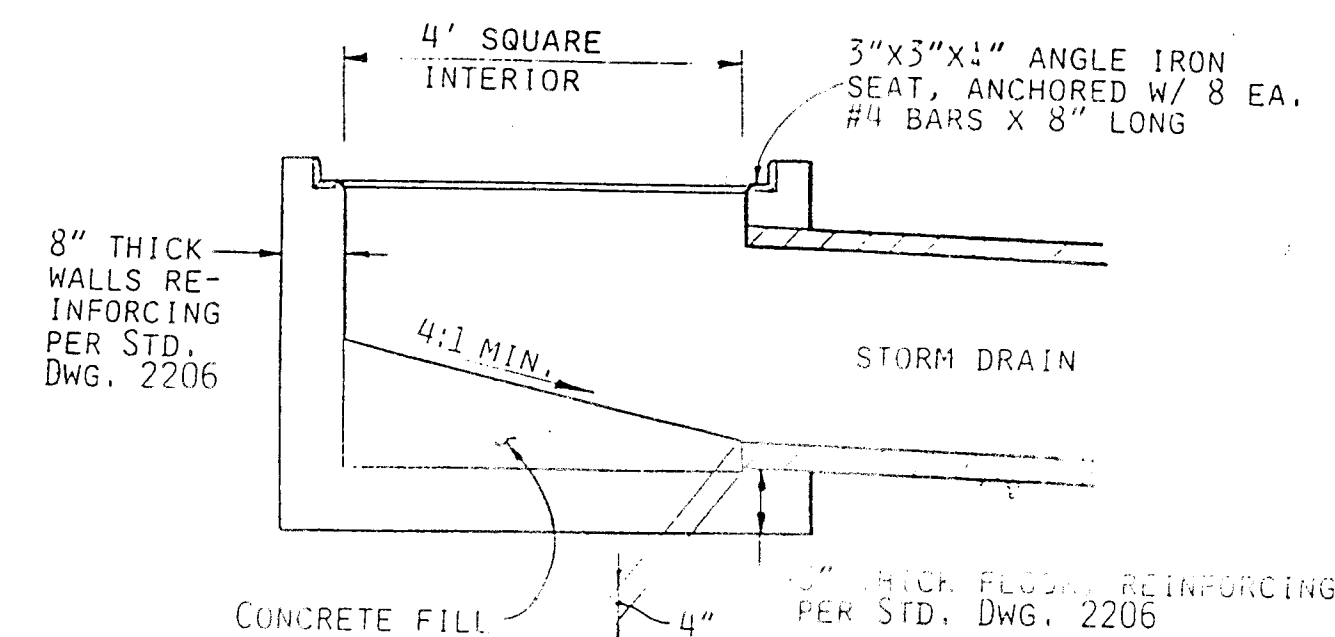

9
16
SPECIAL GRATE INLET DETAIL

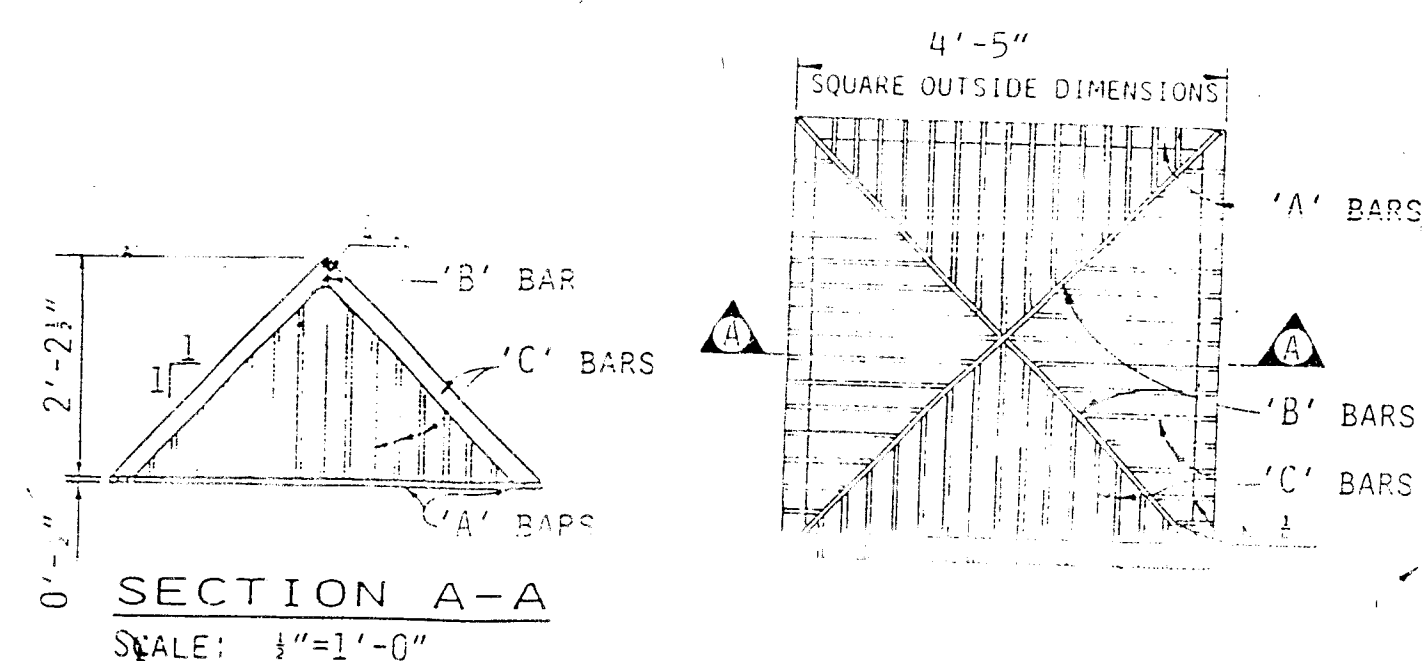

GRATE PLAN
SCALE: 1/4"=1'-0"

BAR	SIZE	SPACING
'A'	1/2"x2-1/2"	--
'B'	1/2"x2-1/2"	--
'C'	3/8"x2"	3" O.C.

MORROW & COMPANY, LTD.
LANDSCAPE ARCHITECTS
210 La Veta N.E.
Albuquerque, N.M. 87108
PH: 505 265-2266 FAX: 505 265-9837






LEEDSHILL-HERKENHOFF, INC.
ARCHITECTS ENGINEERS
ALBUQUERQUE SANTA FE SAN DIEGO

CITY OF ALBUQUERQUE PARKS/GENERAL SERVICES DESIGN & DEVELOPMENT					
TITLE: SOUTH SAN JOSE PARK RENOVATION MISCELLANEOUS DETAILS					
APPROVALS	ENGINEER	DATE	APPROVALS	ENGINEER	DATE
DRG CHAIRMAN	<i>[Signature]</i>	12-10-92	WATER	MA RWK	11-30-92
TRANSPORTATION	<i>[Signature]</i>	12-06-92	WASTE WATER	MA RWK	11-30-92
HYDROLOGY	<i>[Signature]</i>	12-08-92			
PARKS	<i>[Signature]</i>	12-08-92			
PROJECT NO.	4349.90	MAP NO.	M-14-Z	SHEET	16 OF 20

AS BUILT INFORMATION					
CONTRACTOR	DATE	CONTRACTOR	DATE	CONTRACTOR	DATE
ALUMINUM		ALUMINUM		ALUMINUM	
DISK SET IN TOP OF CURB		DISK SET IN TOP OF CURB		DISK SET IN TOP OF CURB	
NO.	COA	NO.	COA	NO.	COA
DATE	2/27/92	DATE	2/27/92	DATE	2/27/92
BY	N 1475451.5887	BY	N 1475451.5887	BY	N 1475451.5887
DATE	E 380842.4888	DATE	E 380842.4888	DATE	E 380842.4888
RECORDED BY		RECORDED BY		RECORDED BY	
NO.		NO.		NO.	

SURVEY INFORMATION					
FIELD NOTES	DATE	BY	NO.	COA	DATE
NO.	2/27/92	BY		COA	
DATE	2/27/92	DATE		DATE	
BY	N 1475451.5887	BY		BY	
NO.	E 380842.4888	NO.		NO.	
DATE		DATE		DATE	
BY		BY		BY	
NO.		NO.		NO.	

ENGINEER'S SEAL					
<i>[Signature]</i> November 2, 1992					
NO.	DATE	REMARKS	NO.	DATE	REMARKS
		DESIGN			DESIGN
		DESIGNED BY S. ALVAREZ			DESIGNED BY S. ALVAREZ
		DRAWN BY			DRAWN BY
		CHECKED BY			CHECKED BY

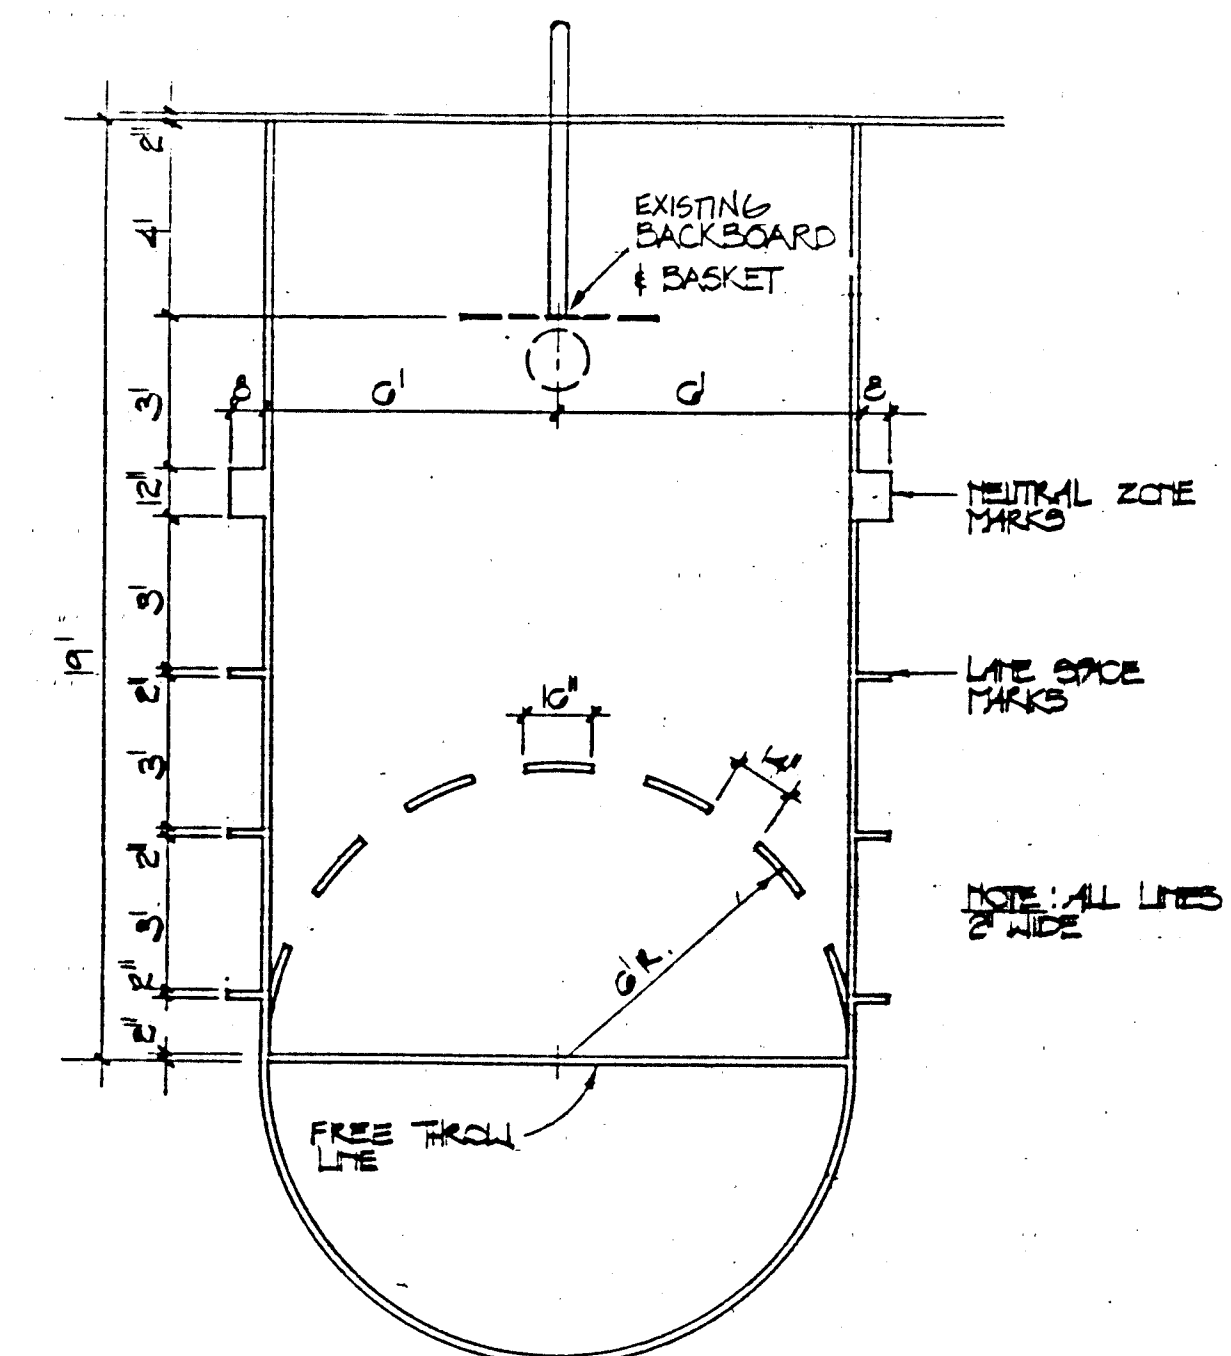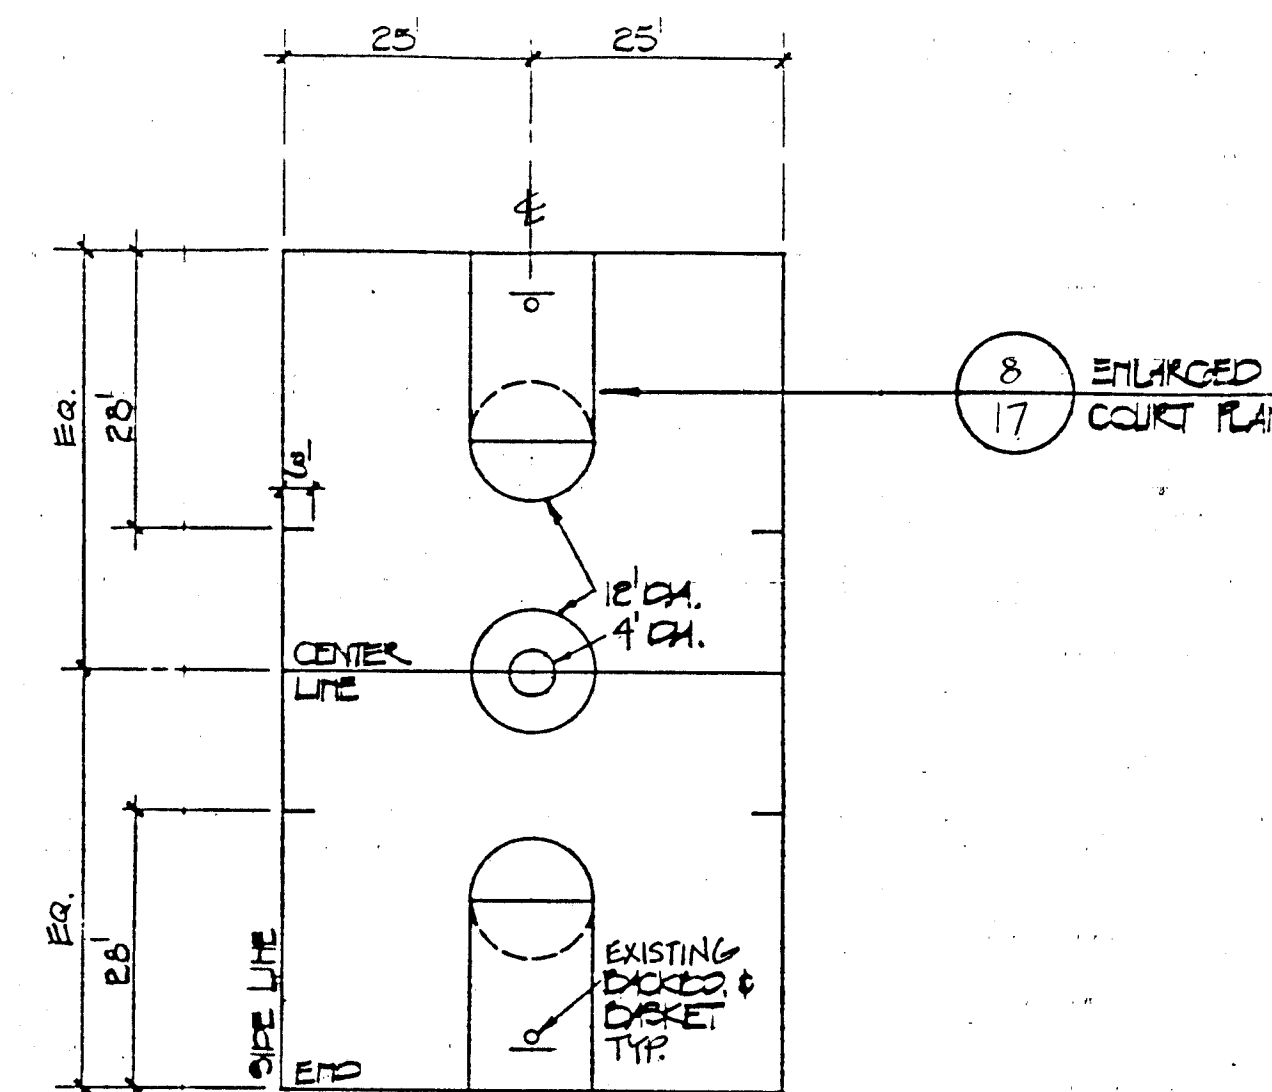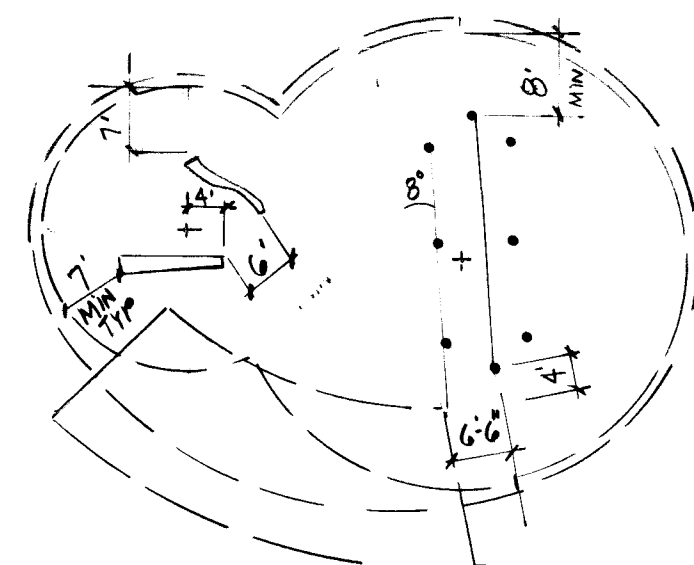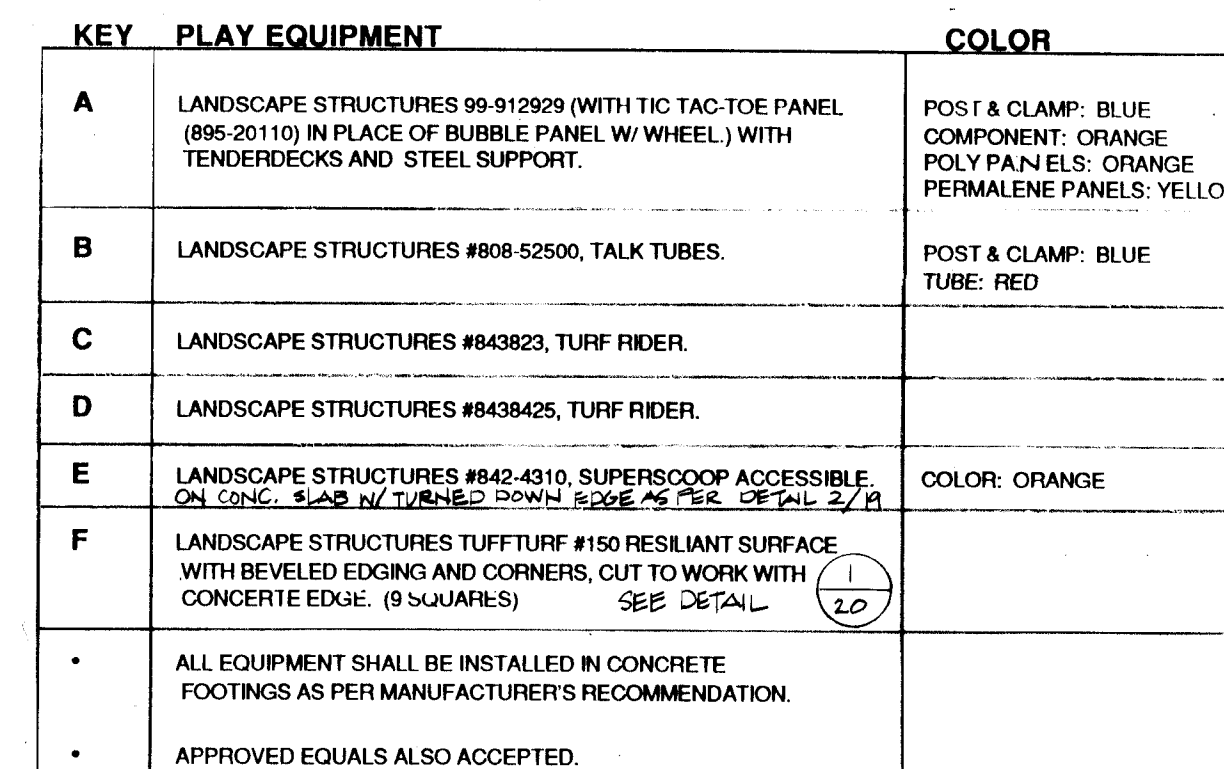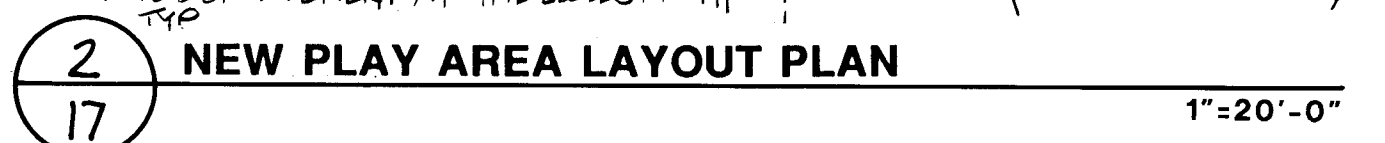[illegible]

					
ENGINEER'S SEAL					
NO.	DATE	REMARKS REVISONS	BY		
DESIGN					
DESIGNED BY	JT	DATE	11/92		
DRAWN BY	JT	DATE	11/92		
CHECKED BY	ECR	DATE	11/92		


NOVEMBER 19, 1992 20/91037.14CD1/SJPARK2/5-20-92/DLM

CITY OF ALBUQUERQUE
PARKS/GENERAL SERVICES
DESIGN & DEVELOPMENT


TITLE: SOUTH SAN JOSE PARK RENOVATION
CONSTRUCTION DETAILS

APPROVALS		ENGINEER	DATE	APPROVALS		ENGINEER	DATE
DRC CHAIRMAN		<i>B.G. Gadhvi</i>	<i>12-02-92</i>	WATER		<i>N/A RUV</i>	<i>11-30-92</i>
TRANSPORTATION		<i>N/A CUV</i>	<i>12-02-92</i>	WASTE WATER		<i>N/A RUV</i>	<i>11-30-92</i>
HYDROLOGY		<i>N/A GBO</i>	<i>12-5-92</i>				
PARKS		<i>S. Kelly</i>	<i>11/10/92</i>				
PROJECT NO.		4349.90		MAP NO.		M-14-Z	
				SHEET		OF 17 20	


MORROW & COMPANY, LTD.
LANDSCAPE ARCHITECTS
210 La Veta N.E.
Albuquerque, N.M. 87108
PH: 505 268-2286 FAX: 505 265-9833

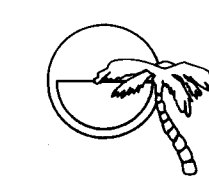

CARE SHALL BE TAKEN NOT TO DAMAGE ANY EXISTING WALL SURFACES.

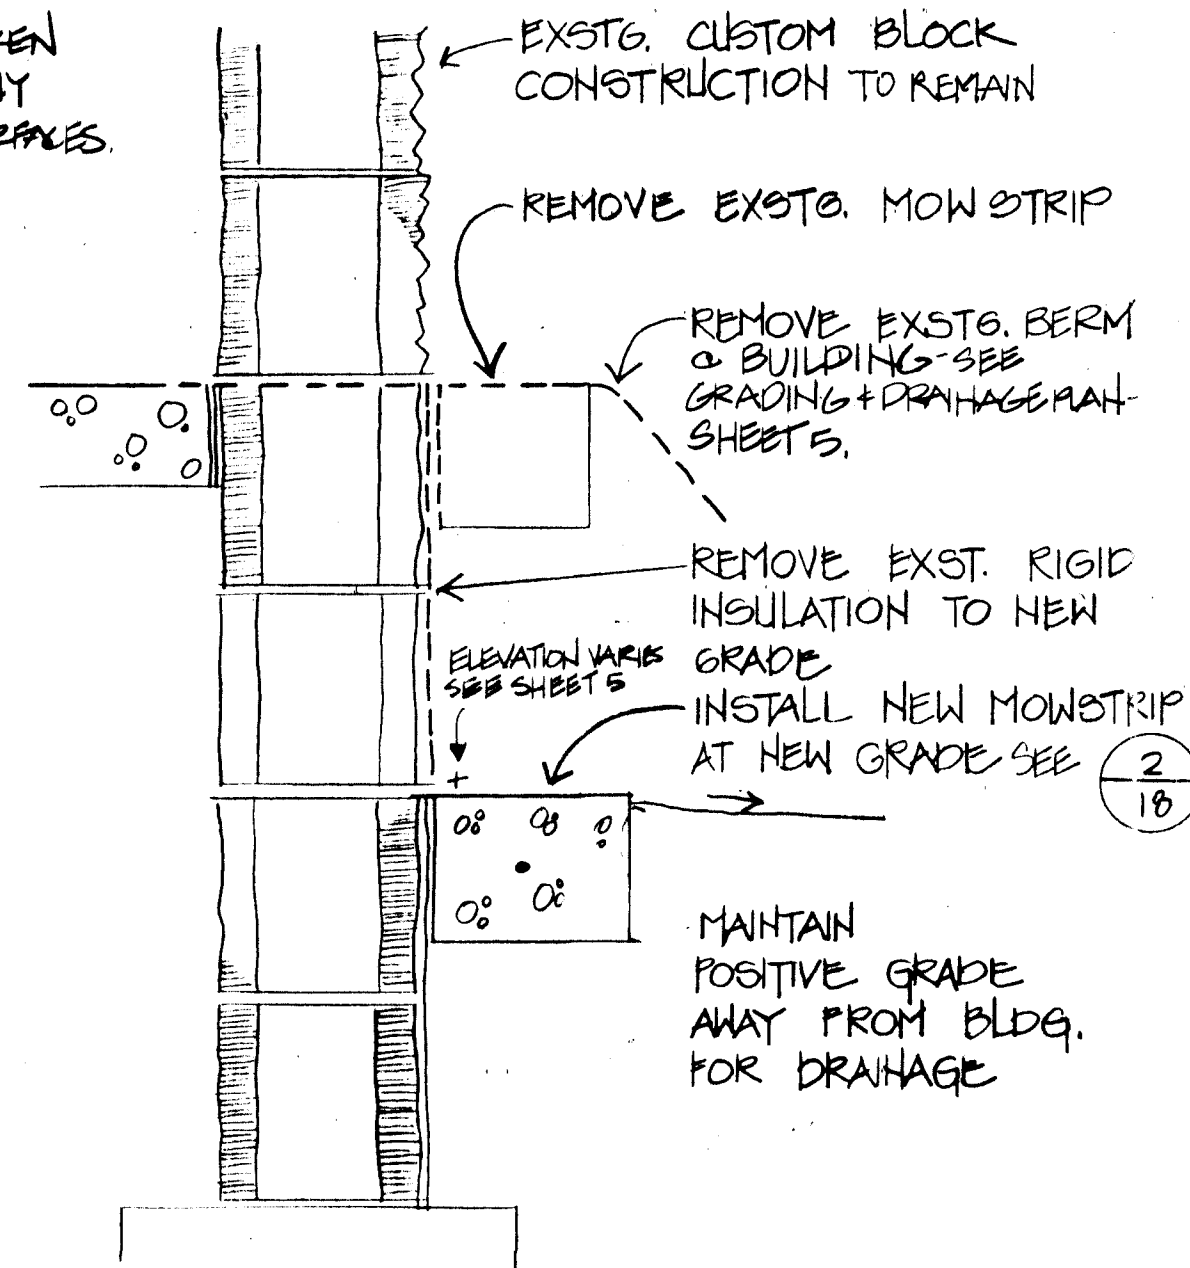


1 REMOVAL/PREPARATION FOR VENEER AT BUILDING
1"=1'-0"

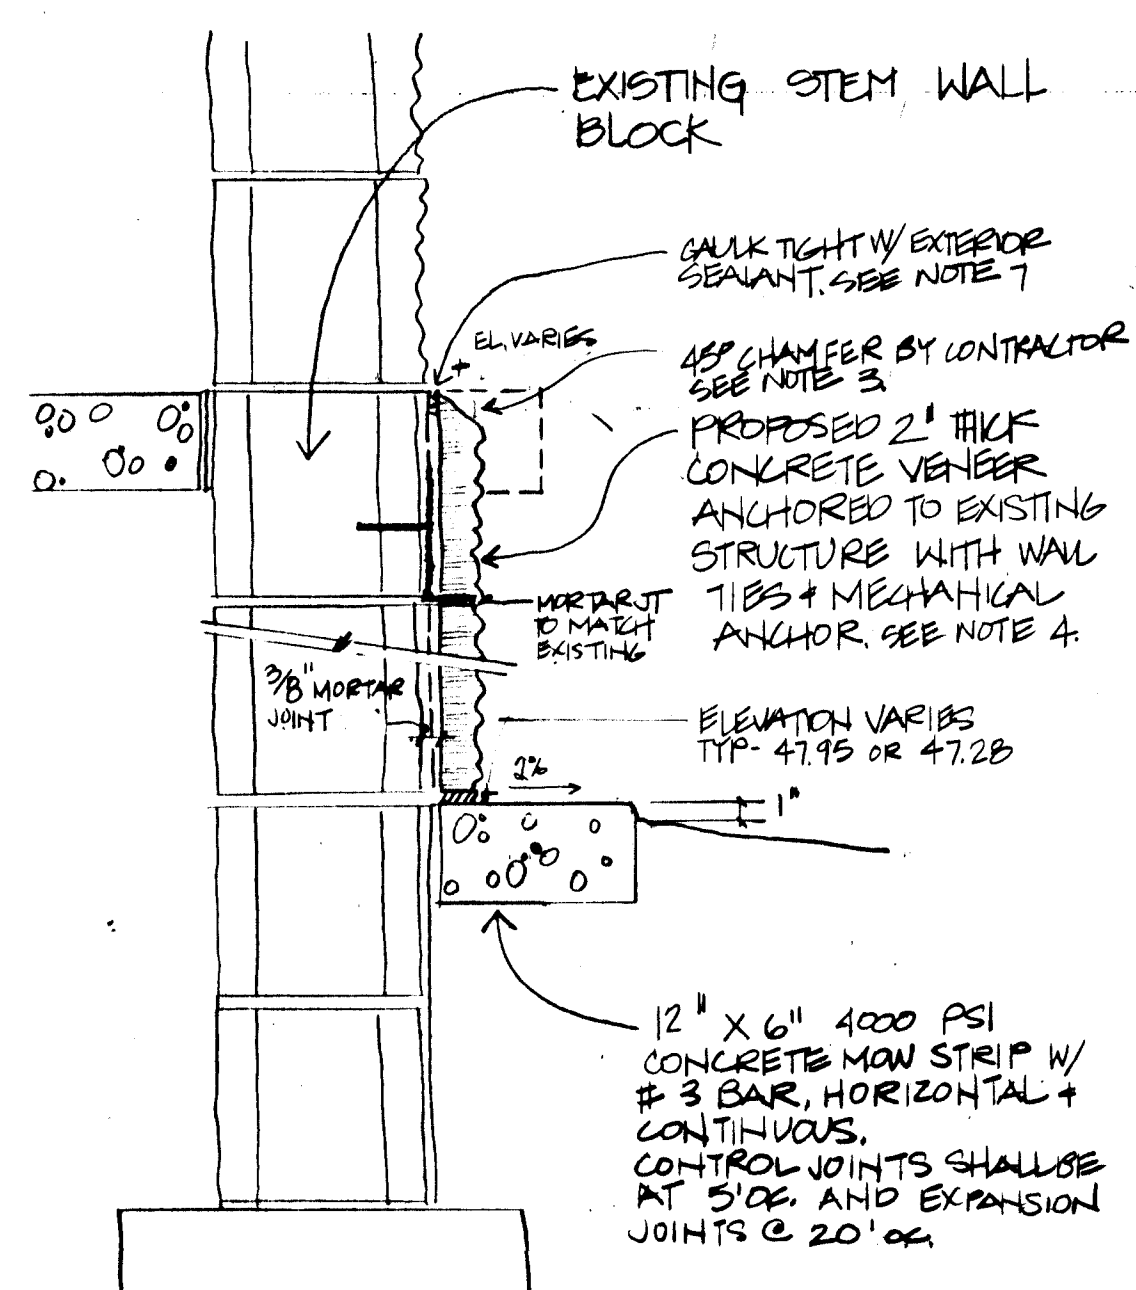


2 VENEER AT BUILDING DETAIL AND NOTES
1"=1'-0"


1. VENEER SHALL BE INTEGRALLY COLORED SINGLE SPILT FACE 8" X 2 1/4" SLAB BLOCK TO MATCH EXISTING - AVAILABLE FROM CRECO BLOCK CO. OR APPROVED EQUAL.
2. VENEER SHALL BE STAINED WITH MASONRY STAIN TO MATCH EXISTING WALL. STAIN SHALL BE "CONFORMAL" BY CEMPROBE CORP. AVAILABLE FROM CRECO BLOCK CO. OR APPROVED EQUAL.
3. CONTRACTOR SHALL CUT BLOCK VENEER FOR CONTINUOUS 45° CHAMFER AND AS REQUIRED SO THAT BOTTOM BLOCK MEETS PROPOSED GRADES. CONTRACTOR SHALL USE A WET MASONRY SAW WHEN CUTTING BLOCK VENEER.
4. WALL TIES AND ANCHOR SHALL BE CORRUGATED WALL TIES STANDARD 1/8" WIDE X 6 3/4" LONG IN 26 GAUGE WITH MECHANICAL ANCHOR 16" O.C. HORIZONTALLY - TYP. & ONE FOR EVERY TWO BLOCKS VERTICALLY.
5. MORTAR JOINTS SHALL BE SET & MORTARED TO MATCH EXIST. JOINTS OF ADJACENT WALL. MORTAR COLOR SHALL MATCH EXISTING. EXTERIOR MORTAR AVAILABLE FROM CRECO BLOCK CO. OR APPROVED EQUAL.
6. CLEAR COAT WATER REPELLENT "CONFORMAL" BY CEMPROBE CO. SHALL BE APPLIED TO PROPOSED VENEER, AVAILABLE FROM CRECO BLOCK CO. OR APPROVED EQUAL.
7. EXTERIOR SEALANT SHALL BE SONNEBORN SONOSTIC HP2 NON SAG URETHANE OR APPROVED EQUAL. COLOR SHALL MATCH WALL COLOR AND SHALL BE APPROVED BY LANDSCAPE ARCHITECT.
8. CONTRACTOR SHALL VERIFY EXISTING CONDITIONS IN FIELD AND MAKE FIELD ADJUSTMENTS AS NEEDED TO TIE INTO EXISTING CONDITIONS.

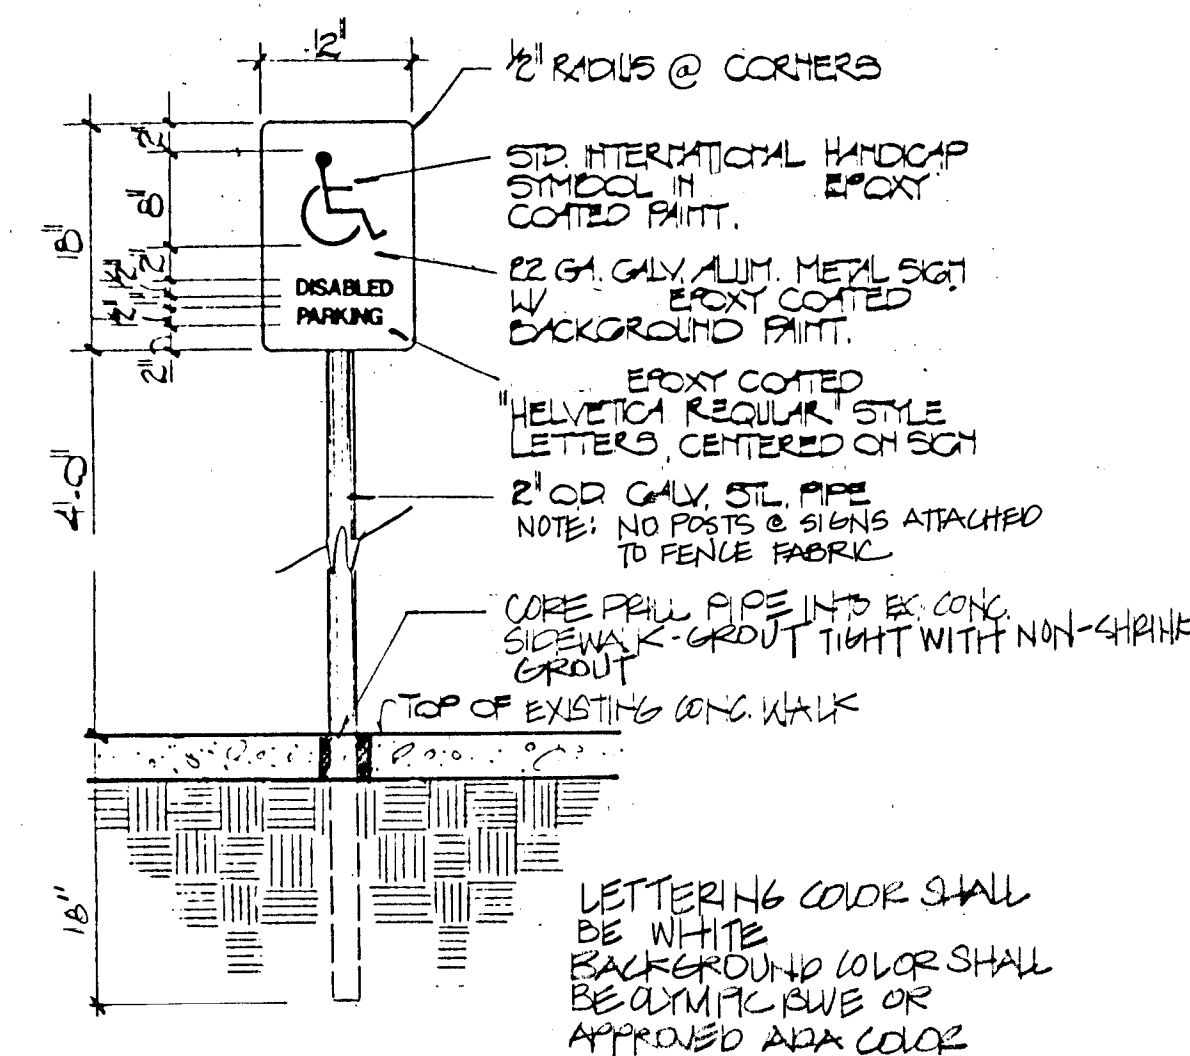


3 HANDICAP PARKING SIGN
3/4"=1'-0"

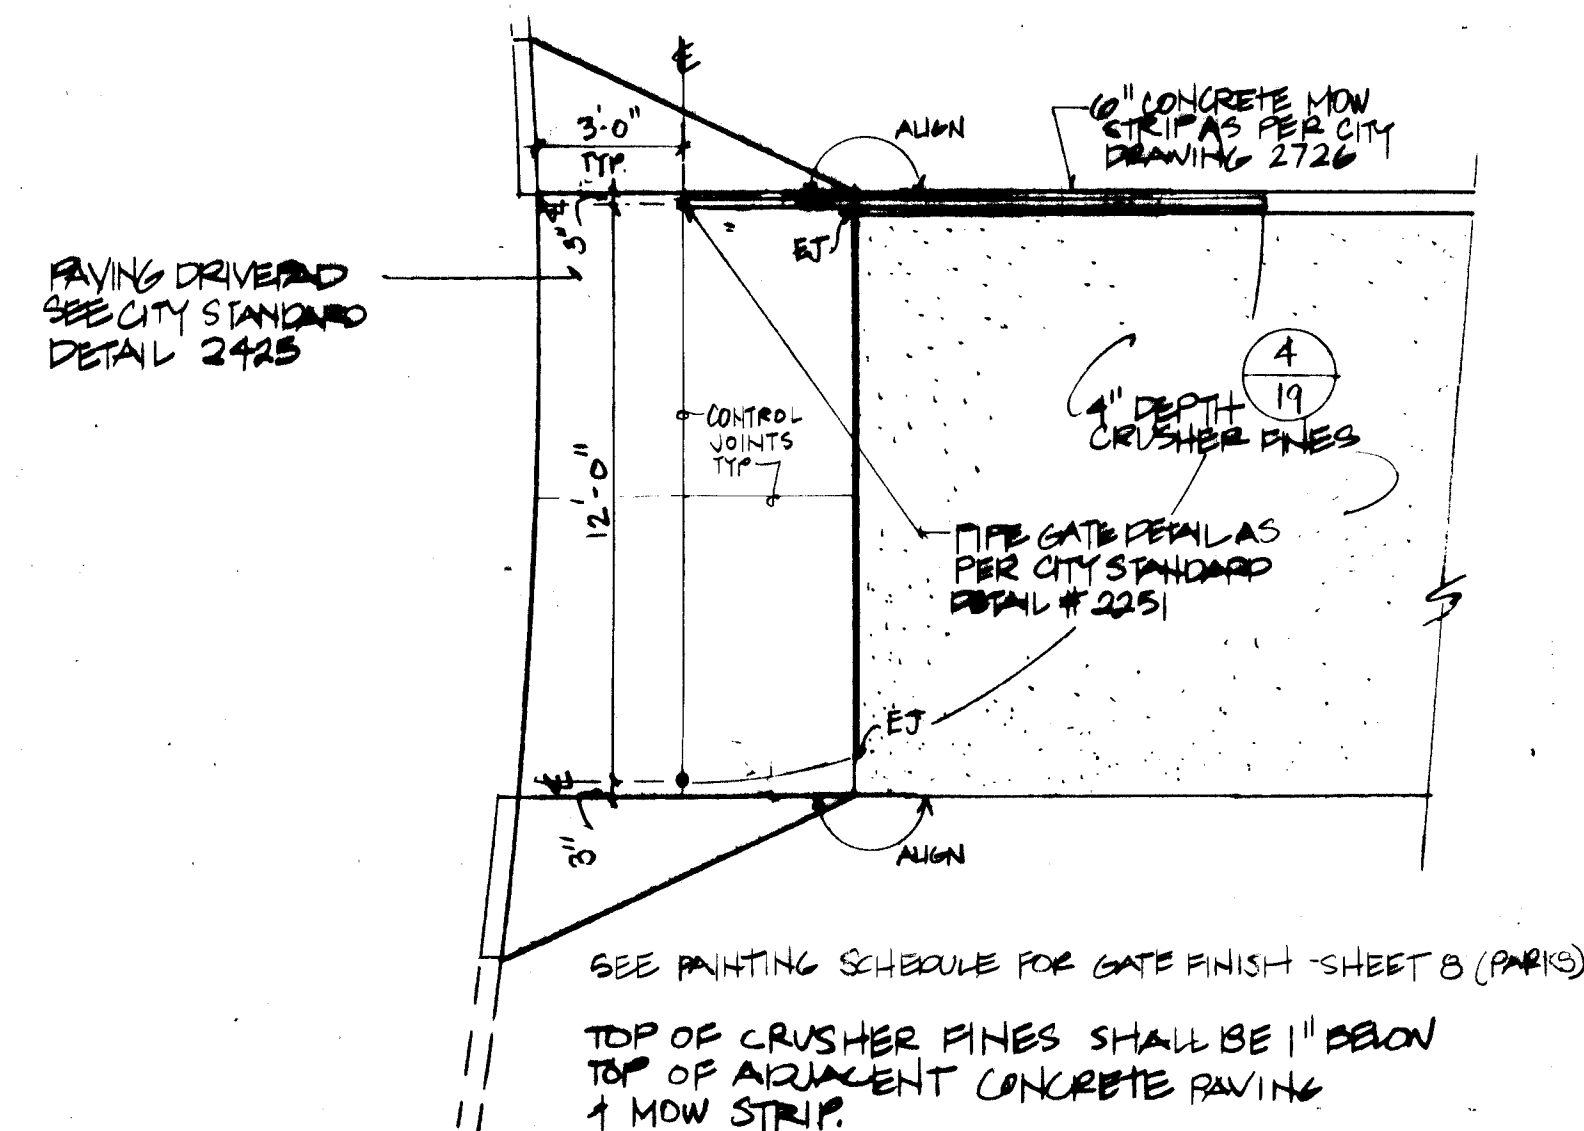


4 DRIVE PAD AND SERVICE ROAD ENTRANCE DETAIL
N.T.S.

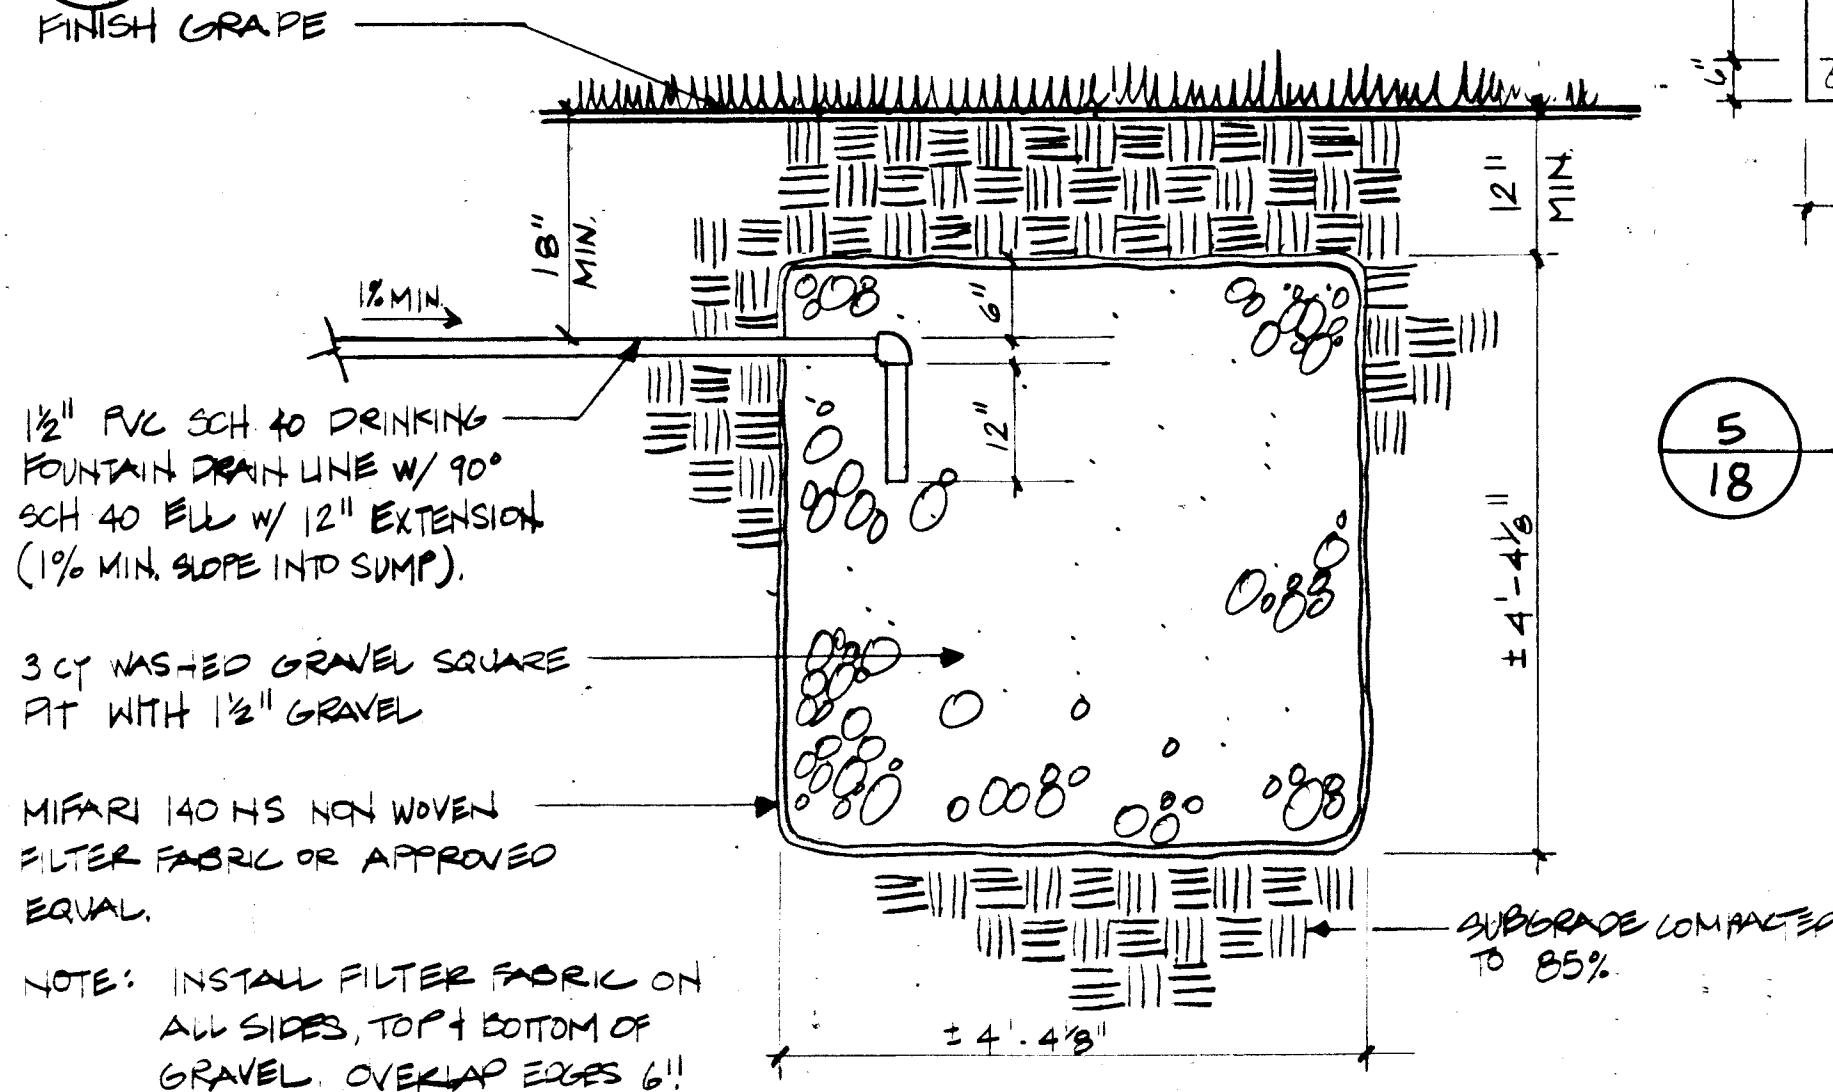

5 STEEL ARCH DETAIL
N.T.S.

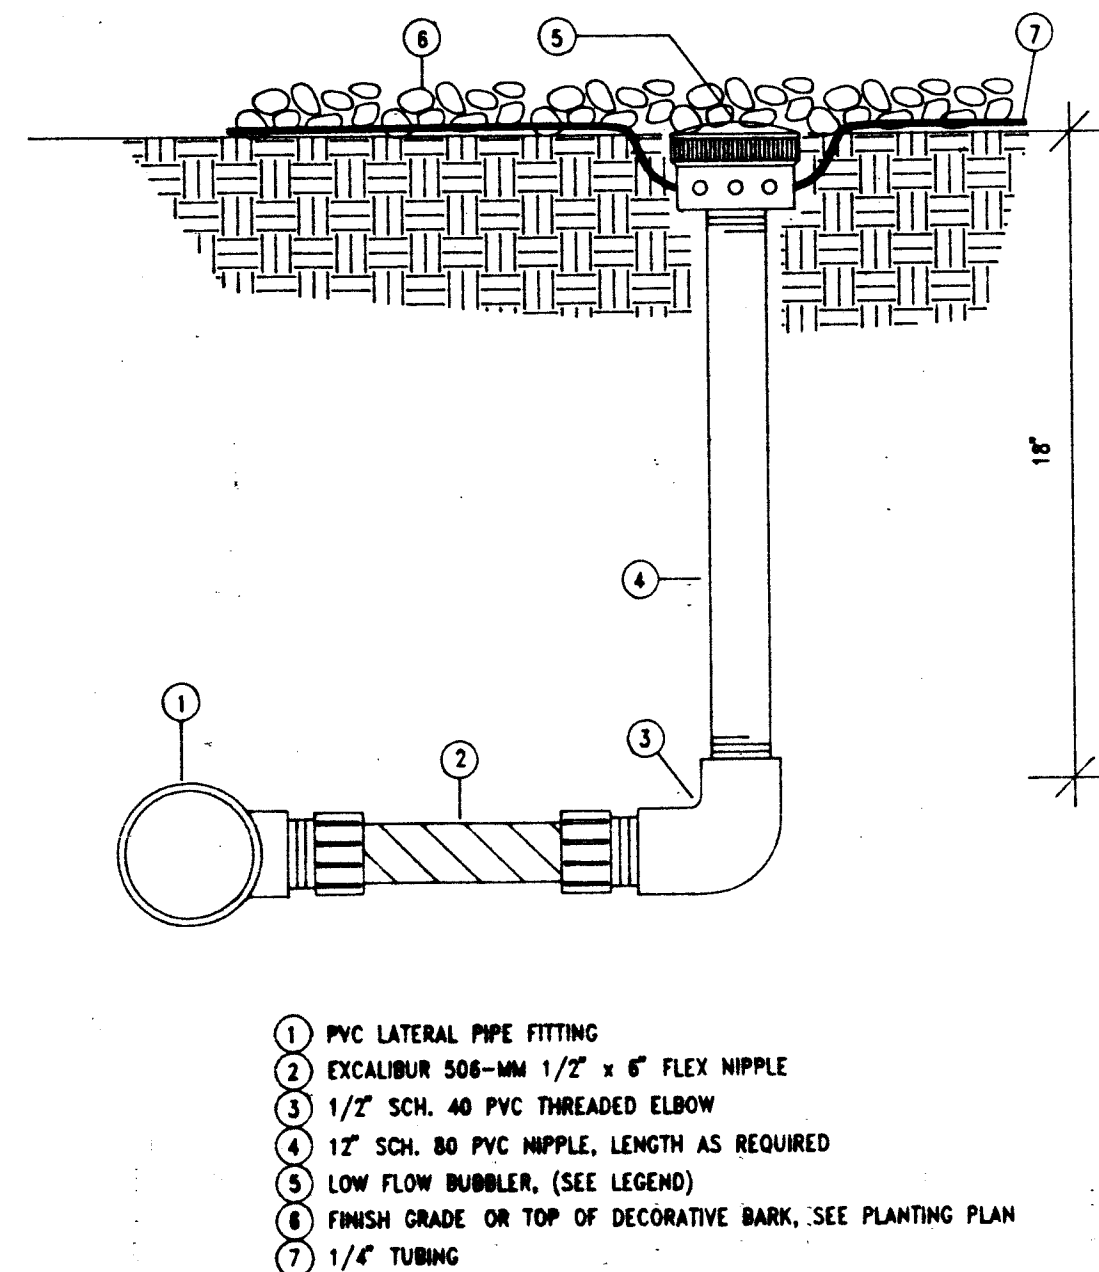

6 LOW FLOW BUBBLER ASSEMBLY
N.T.S.

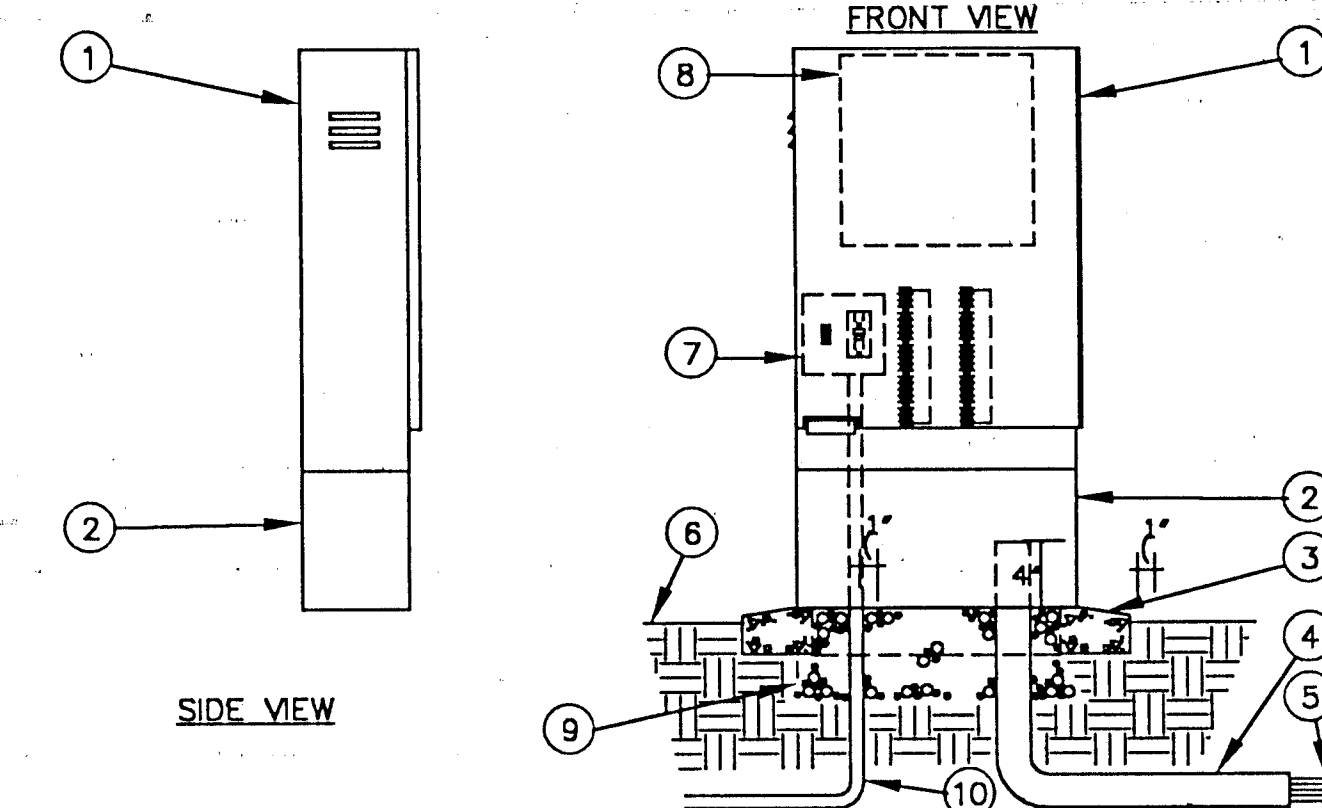


7 CONTROLLER ENCLOSURE
N.T.S.

8 DRINKING FOUNTAIN SUMP
3/4"=1'-0"

NOVEMBER 19, 1992 20/91037.14CD1/SJ/PARK2/5-20-92/DLM


CITY OF ALBUQUERQUE PARKS/GENERAL SERVICES DESIGN & DEVELOPMENT					
TITLE: SOUTH SAN JOSE PARK RENOVATION CONSTRUCTION DETAILS					
APPROVALS	ENGINEER	DATE	APPROVALS	ENGINEER	DATE
DRC CHAIRMAN	<i>B. B. B. B.</i>	12-10-92	WATER	<i>N/A RWK</i>	11-30-92
TRANSPORTATION	<i>N/A RWK</i>	12-02-92	WASTE WATER	<i>N/A RWK</i>	11-30-92
HYDROLOGY	<i>N/A RWK</i>	12-02-92			
PARKS	<i>N/A RWK</i>	12-02-92			
PROJECT NO.	4349.90	MAP NO.	M-14-Z	SHEET	18 OF 20

MORROW & COMPANY, LTD.
LANDSCAPE ARCHITECTS
210 La Veta N.E.
Albuquerque, N.M. 87108
PH: 505 268-2266 FAX: 505 265-9637

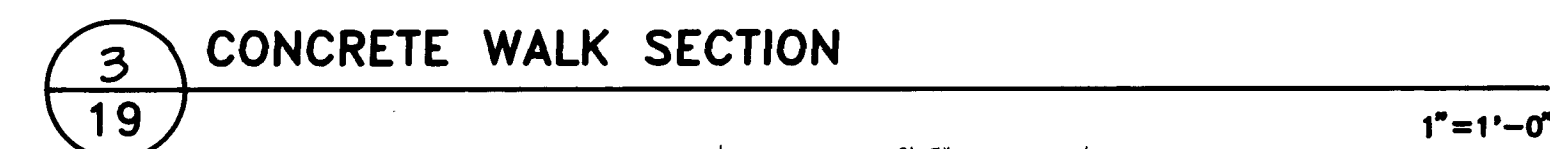

NOVEMBER 19, 1992 20/91037.1ACDI/SJ/PARK2/5-20-92/DLM						
CITY OF ALBUQUERQUE PARKS/GENERAL SERVICES DESIGN & DEVELOPMENT						
TITLE: SOUTH SAN JOSE PARK RENOVATION CONSTRUCTION DETAILS						
APPROVALS	ENGINEER	DATE	APPROVALS	ENGINEER	DATE	
DRC CHAIRMAN	<i>S. J. Sanchez</i>	<i>12-10-92</i>	WATER	<i>N/A RWK</i>	<i>11-30-92</i>	
TRANSPORTATION	<i>N/A RWK</i>	<i>12-02-92</i>	WASTE WATER	<i>N/A RWK</i>	<i>11-30-92</i>	
HYDROLOGY	<i>N/A RWK</i>	<i>12-8-92</i>				
PARKS	<i>S. J. Sanchez</i>	<i>11/30/92</i>				
PROJECT NO.	4349.90		MAP NO.	M-14-7		
			SHEET	OF 19 20		

TUFF TURF SURFACE SHALL BE FLUSH WITH ADJUTING CONCRETE WALK
TOWARDS
PLAY BOOSTER. CROSS SLOPE
NOTED ON DRAWING SHEET L-5

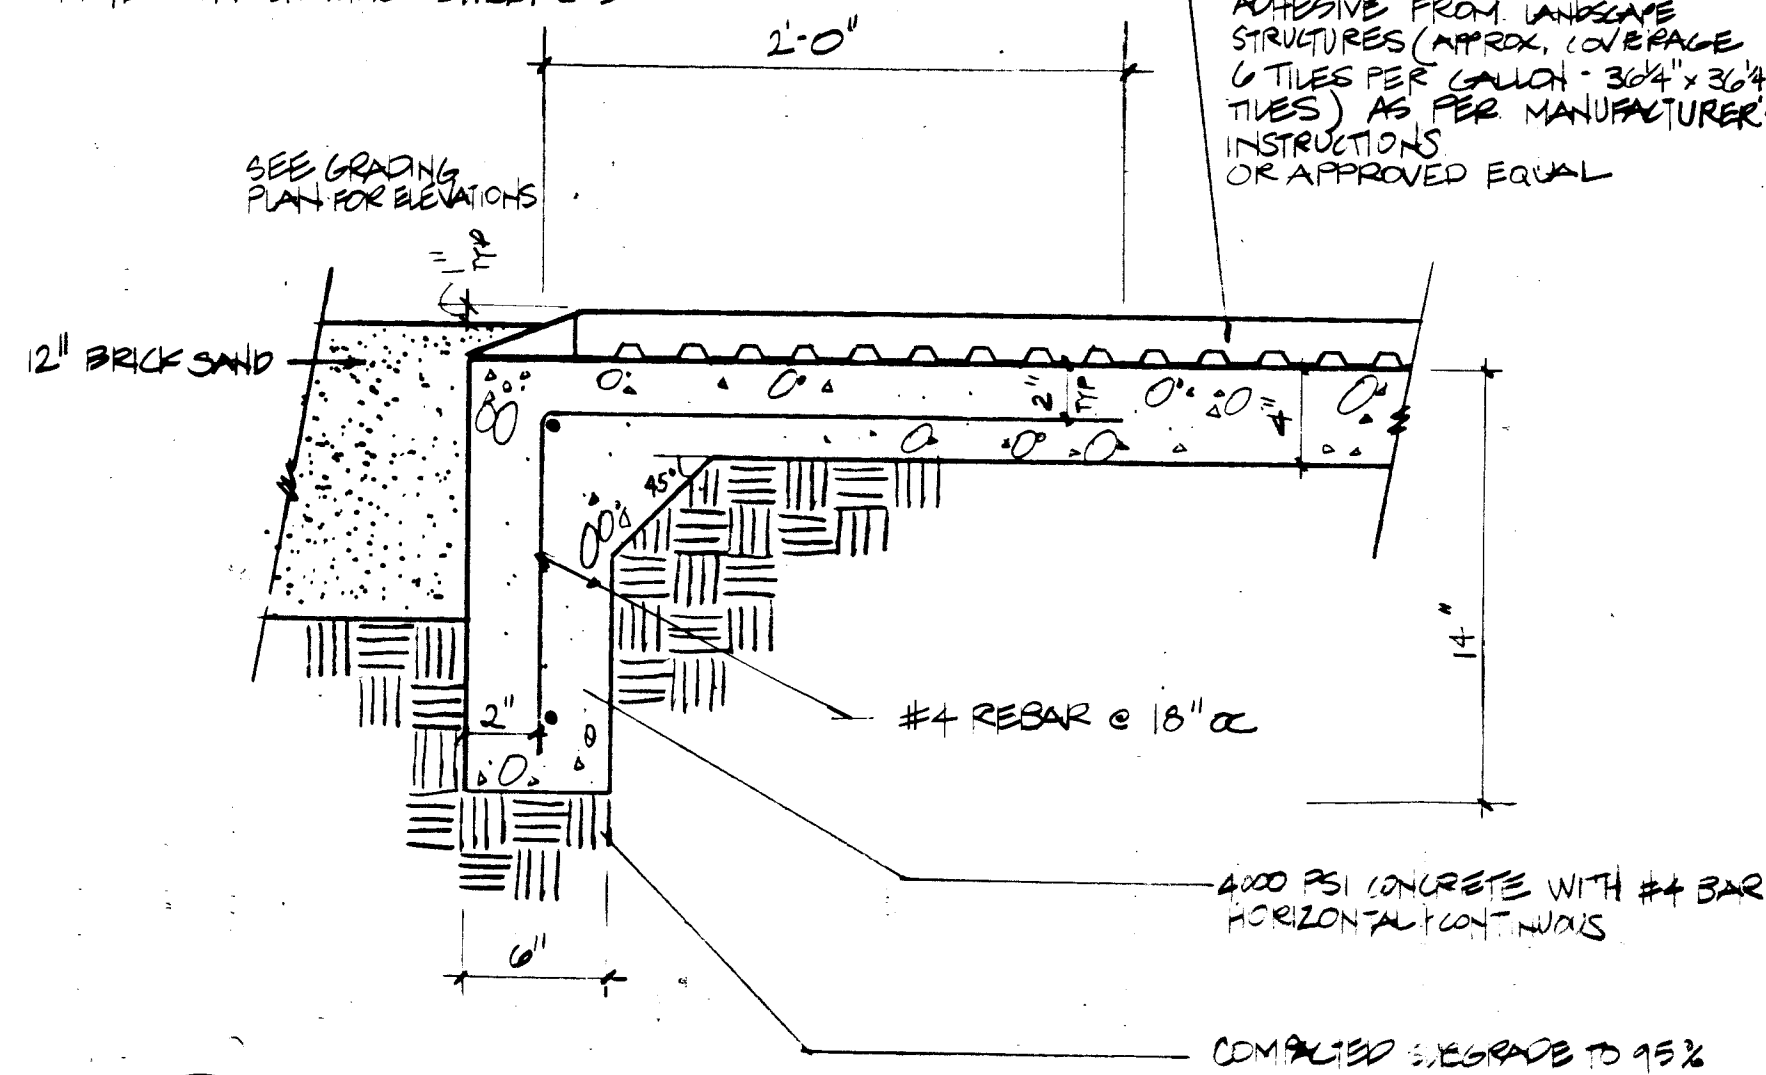


1
20
PLAY AREA RESILIENT SURFACE DETAIL

1 1/2"=1'-0"

VALVING LEGEND


STATION	VALVE NO.	VALVE SIZE	TOTAL GPM	HEAD TYPE	AREA TYPE
	V-1	2"	80.0	S610	TUFF
	V-2	2"	60.0	S610	TUFF
	V-3	2"	60.0	S610	TUFF
	V-4	2"	80.0	S610	TUFF
	V-5	2"	80.0	S610	TUFF
	V-6	2"	80.0	S610	TUFF
	V-7	2"	80.0	S610	TUFF
	V-8	2"	60.0	S610	TUFF
	V-9	2"	80.0	S610	TUFF
	V-10	1.5"	28.0	S700	TUFF
	V-11	1.5"	28.0	S700	TUFF
	V-12	1"	16.0	BUBBLER	SHRUBS/TREES
	V-13	1.5"	35.0	S70C	NATIVE
	V-14	2"	45.0	S70C	TUFF
	V-15	2"	45.0	S70C	TUFF
	V-16	1"	18.0	BUBBLER	SHRUBS/TREES
	V-17	2"	60.0	S600	TUFF
	V-18	1.5"	35.0	#300	TUFF
	V-19	2"	50.0	BUBBLER	SHRUBS/TREES
	V-20	2"	40	S700	TUFF
	V-21	2"	33.0	BUBBLER	SHRUBS/TREES
	V-22	2"	40.0	S700	TUFF
	V-23	1.5"	28.0	S600	TUFF
	V-24	2"	50.0	S70C	TUFF
	V-25	2"	42.0	S70C	TUFF
	V-26	2"	54.0	S70C	SHRUBS

4
20
VALVING LEGEND

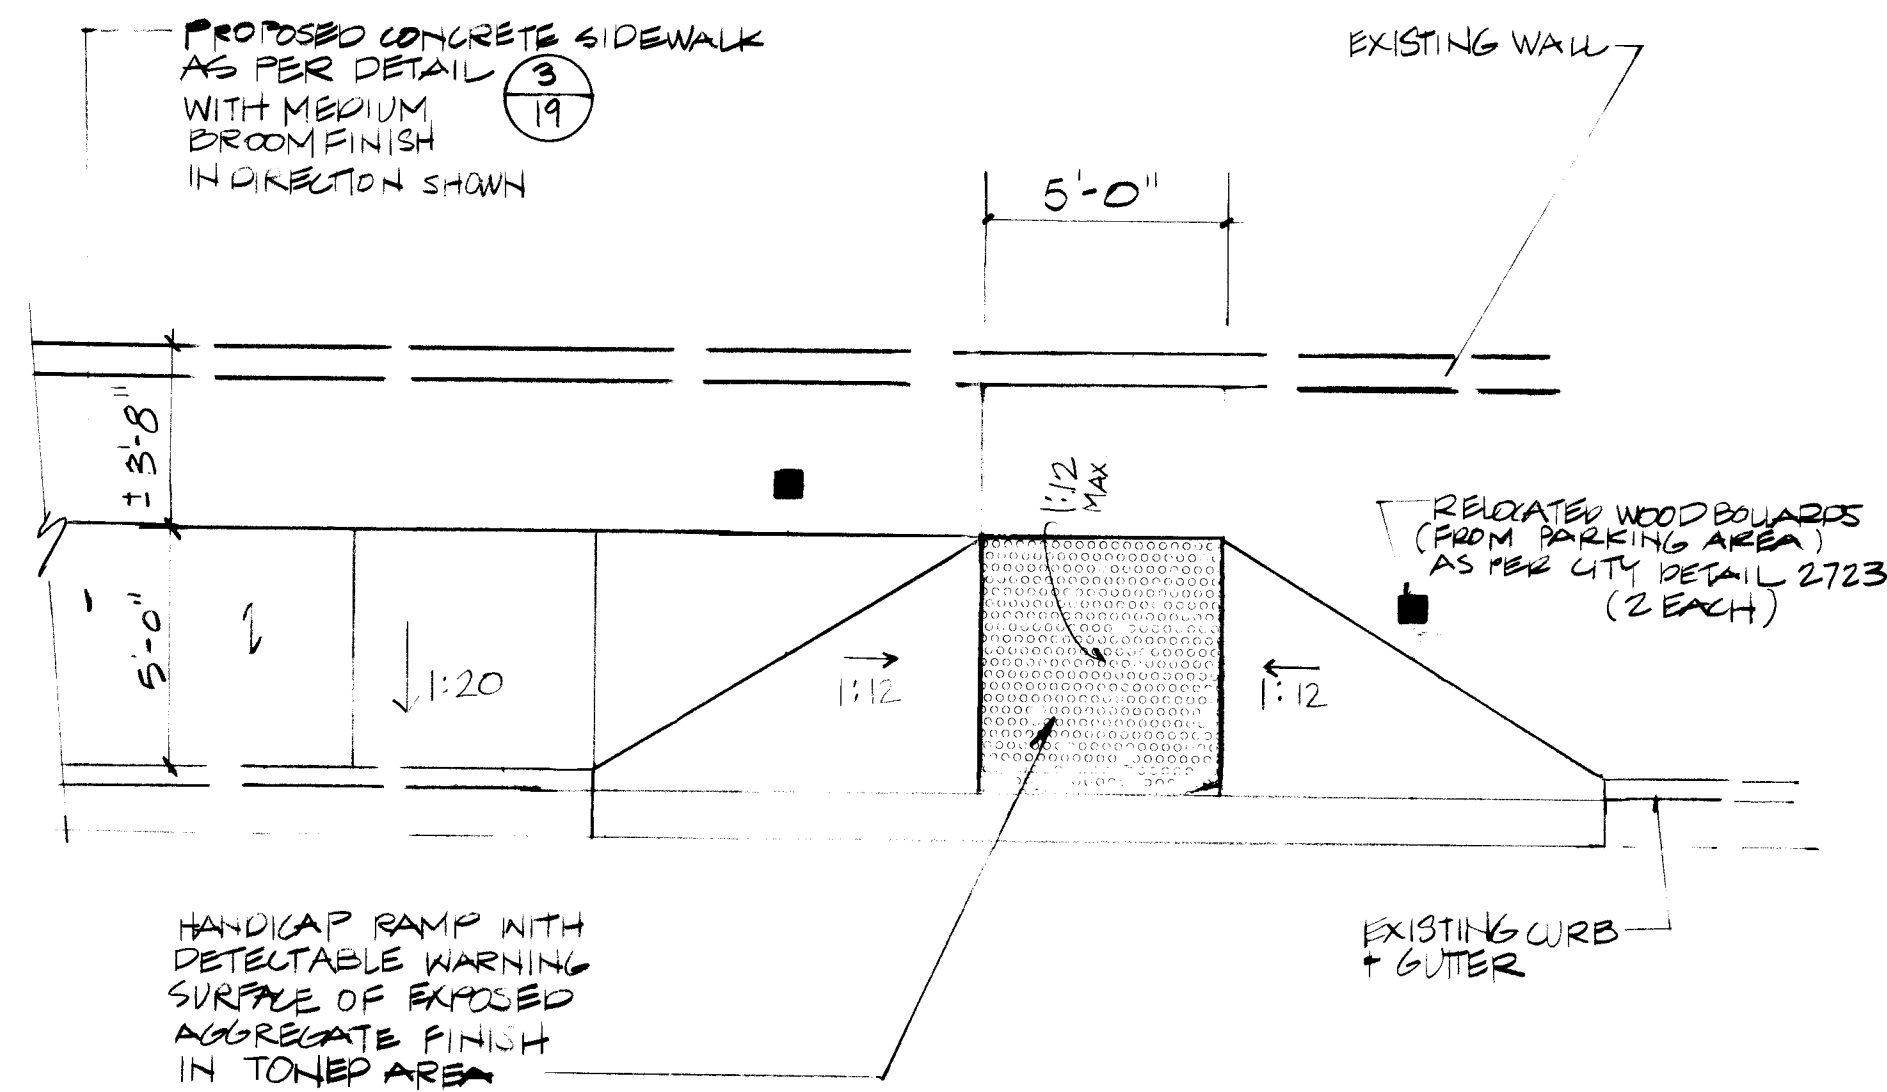

2
20
HANDICAP RAMP DETAIL


1/4"=1'-0"

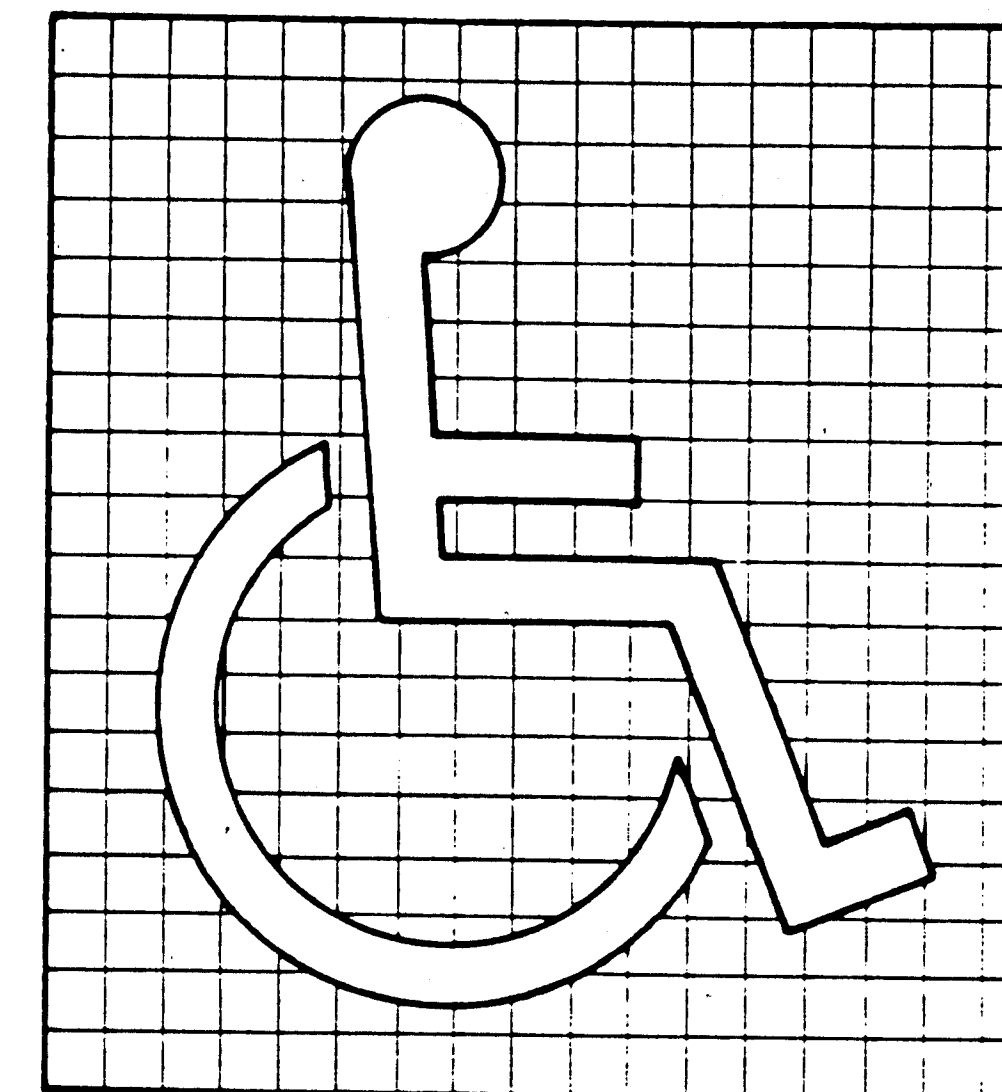

(a) Proportions

3
20
ACCESSIBILITY SYMBOL

AS BUILT INFORMATION			BENCH MARKS			SURVEY INFORMATION			ENGINEER'S SEAL		
CONTRACTOR	DATE	NO.	BY	DATE	NO.	BY	DATE	NO.	BY	DATE	NO.
WORK	DATE	NO.	BY	DATE	NO.	BY	DATE	NO.	BY	DATE	NO.
INSPECTED BY	DATE	NO.	BY	DATE	NO.	BY	DATE	NO.	BY	DATE	NO.
FIELD	DATE	NO.	BY	DATE	NO.	BY	DATE	NO.	BY	DATE	NO.
REVISION	DATE	NO.	BY	DATE	NO.	BY	DATE	NO.	BY	DATE	NO.
CORRECTED BY	DATE	NO.	BY	DATE	NO.	BY	DATE	NO.	BY	DATE	NO.
MICRO-FILM INFORMATION			MICRO-FILM INFORMATION			MICRO-FILM INFORMATION			MICRO-FILM INFORMATION		
RECORDED BY	DATE	NO.	BY	DATE	NO.	BY	DATE	NO.	BY	DATE	NO.
NO.	DATE	NO.	BY	DATE	NO.	BY	DATE	NO.	BY	DATE	NO.

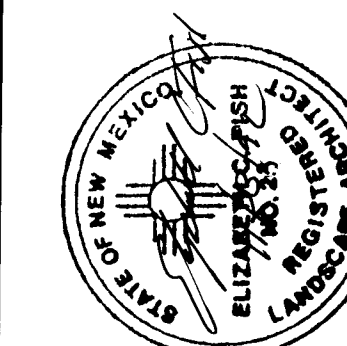

1 2 3 4 5 6 7 8 9 10 11 12 13 14 15
2619349.90 20916

MORROW & COMPANY, LTD.
LANDSCAPE ARCHITECTS
210 La Veta N.E.
Albuquerque, N.M. 87108
PH: 505 265-2266 FAX: 505 265-9837

NOVEMBER 19, 1992 20/91037.14CD1/SJ/PARK2/5-20-92/DLM					
CITY OF ALBUQUERQUE PARKS/GENERAL SERVICES DESIGN & DEVELOPMENT					
TITLE: SOUTH SAN JOSE PARK RENOVATION CONSTRUCTION DETAILS					
APPROVALS	ENGINEER	DATE	APPROVALS	ENGINEER	DATE
DRC CHAIRMAN	24/10/92	12-10-92	WATER	N/A RUK	11-30-92
TRANSPORTATION	NA RUC	12-02-92	WASTE WATER	N/A RUK	11-30-92
HYDROLOGY	NA RUC	12-02-92			
PARKS	24/10/92	11-30-92			
PROJECT NO.	4349.90	MAP NO.	M-14-Z	SHEET	20 OF 20