
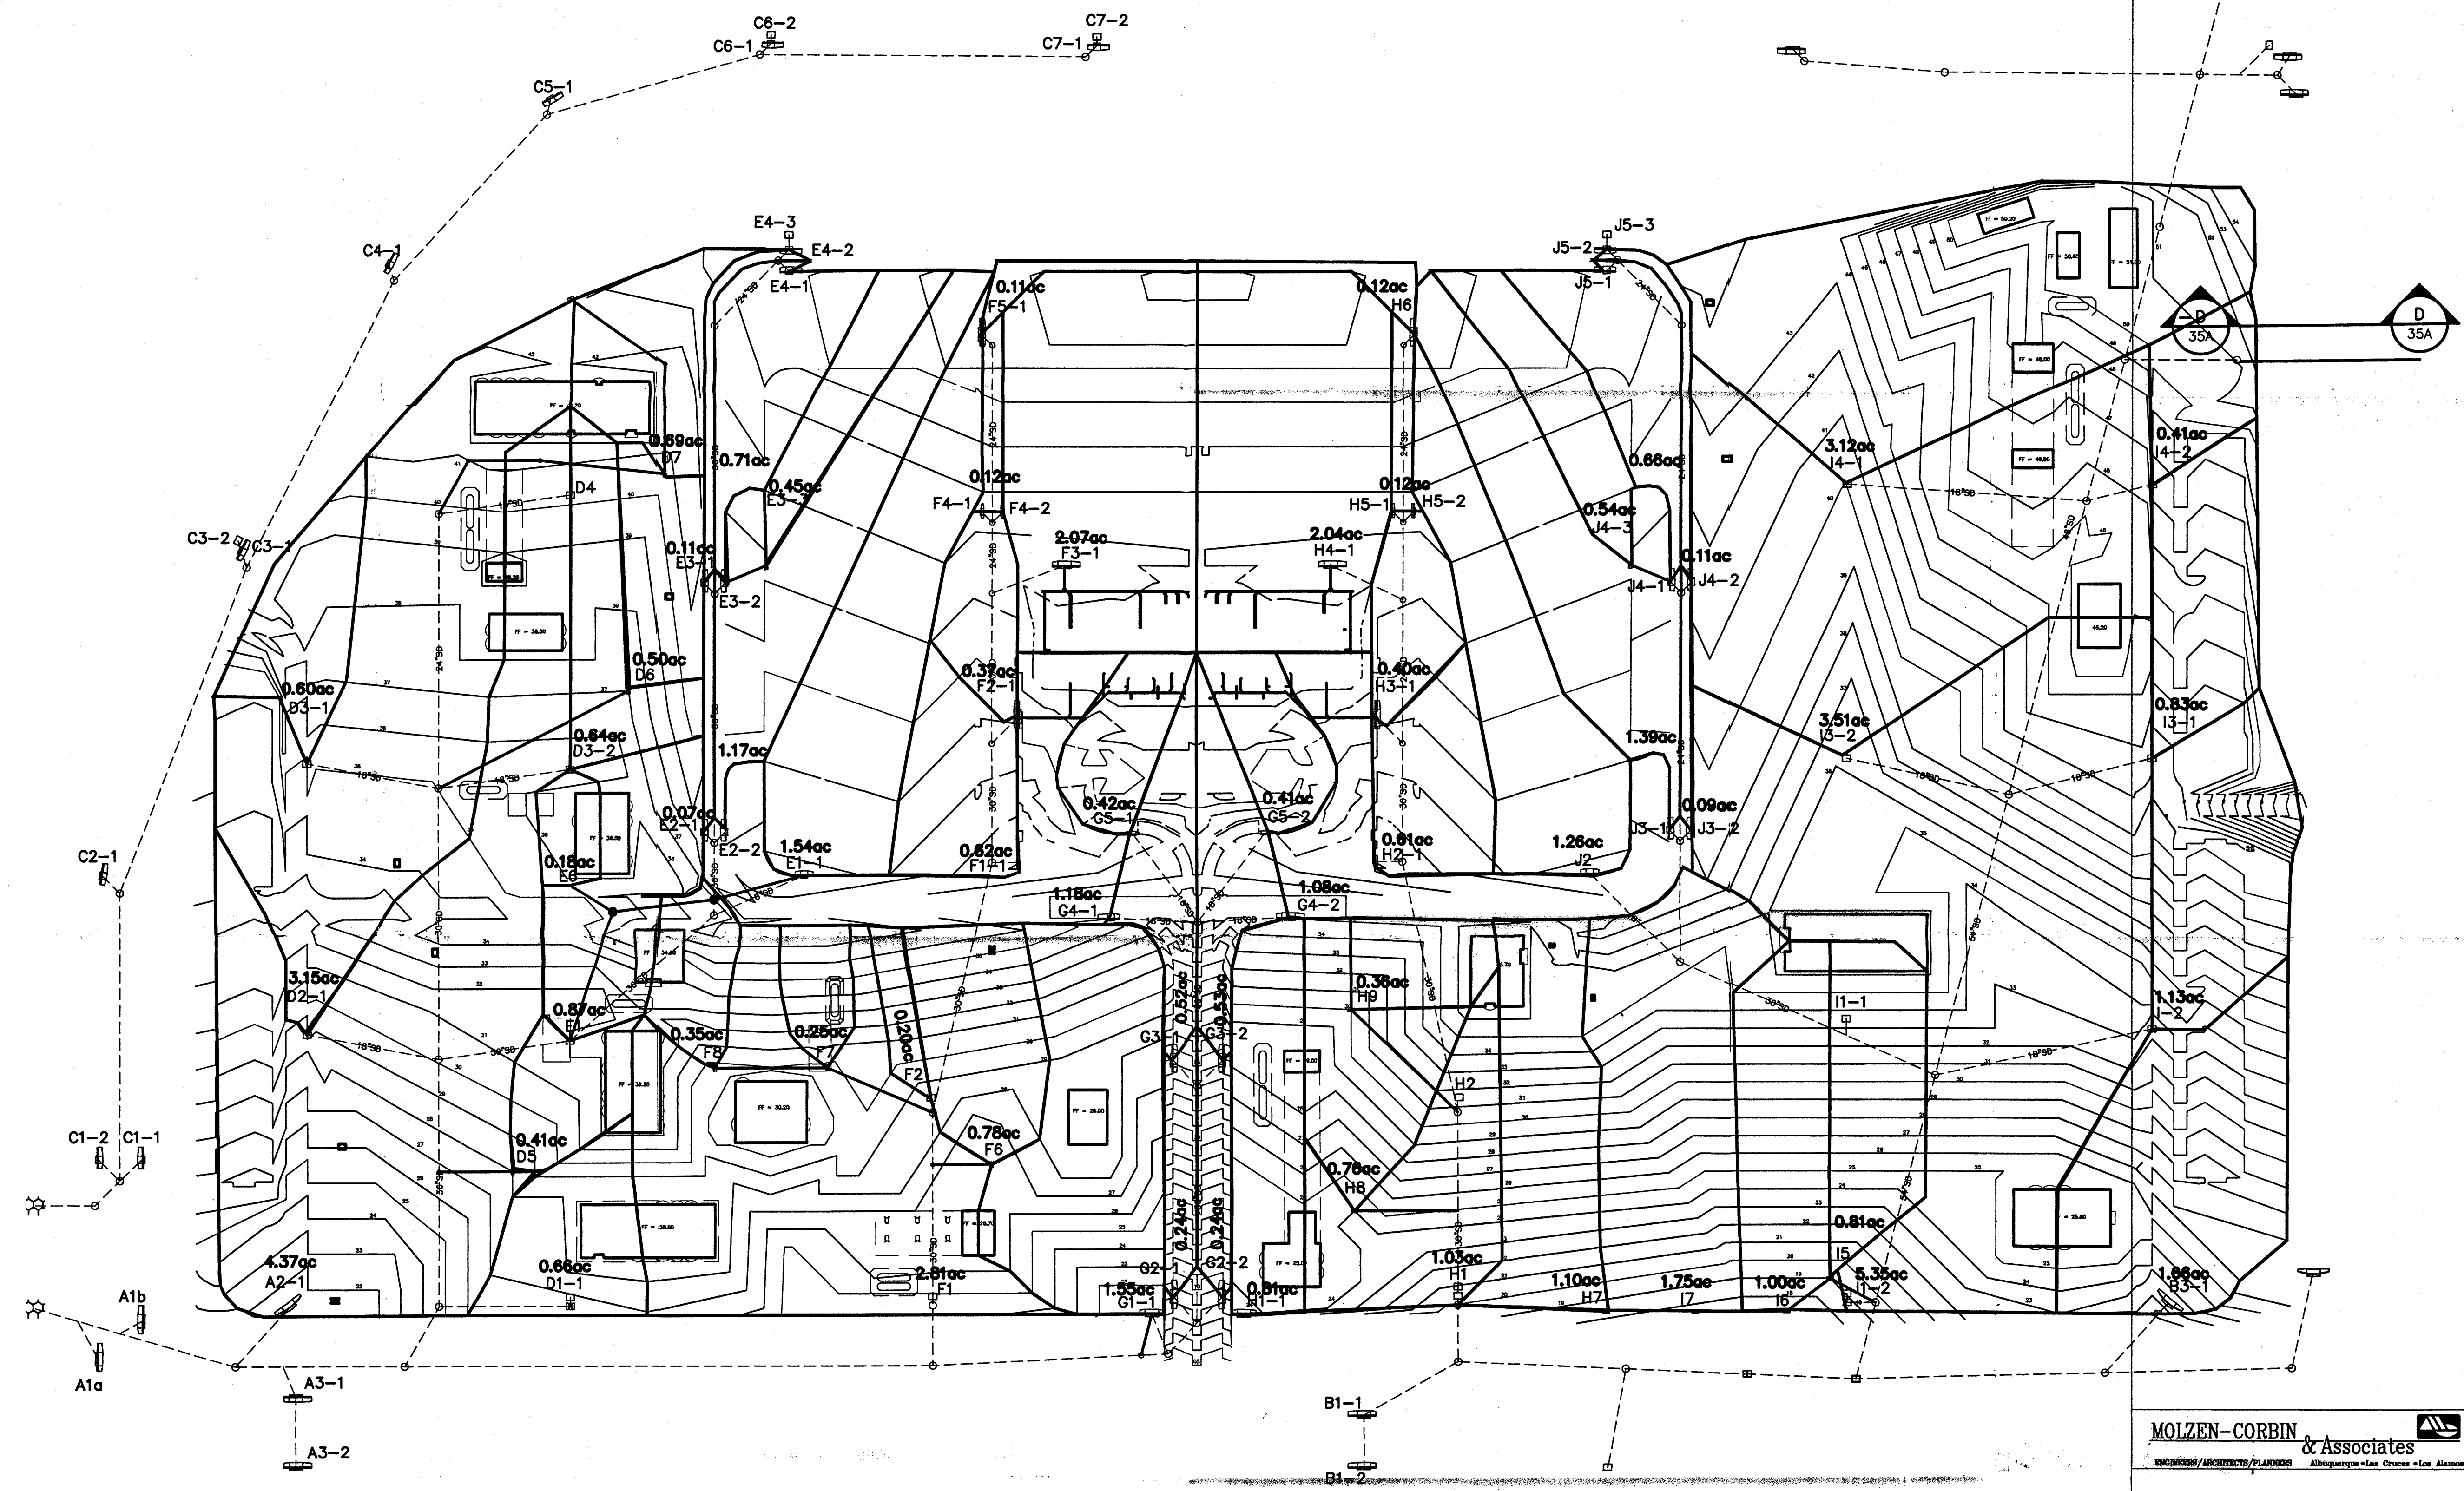


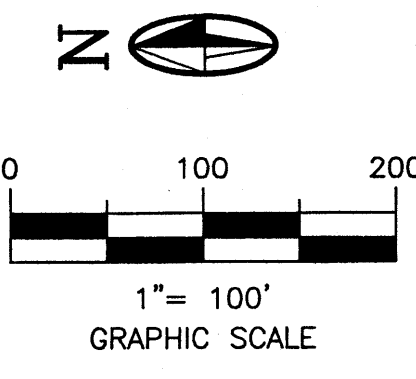

TOTAL AREA = 60.94ac



MOLZEN-CORBIN & Associates
ENGINEERS/ARCHITECTS/PLANNERS Albuquerque • Las Cruces • El Paso • Alamogordo

BPLW
Architects & Engineers, Inc.
8200 Uptown Blvd. NE Suite 400 Albuquerque, New Mexico 87110 (505) 881-2759
49 West First Street Suite 100 Santa Fe, New Mexico 87501 (505) 827-2759
Designing to Shape the Future

CITY OF ALBUQUERQUE PUBLIC WORKS DEPARTMENT ENGINEERING DEVELOPMENT GROUP	
TITLE: Remote Car Rental Facility Drainage Plan (Plate 7)	
Design Review Committee	City Engineer Approval
City Project No. 6101.91	Zone Map No. N-15-Z
Sheet 1	Of 1

ENGINEER'S STAMP & SIGNATURE		SURVEY INFORMATION		BENCH MARKS		AS BUILT INFORMATION	
		No.	Field Notes	Date		Contractor	Work
		2050	URS GREINER	12/98		By	By
			WOODWARD CLYDE	THRU BLVD. AND APPROX. 100 FT SSE OF A CHAIN		Field	Field
				2/99 GATE ALIGNED EAST TO WEST.		Accepted	Accepted
				ELEVATION = 5308.73		By	By
						Checked	Checked
						Recorded	Recorded
						By	By
						Date	Date


cbowar2 09-07-99

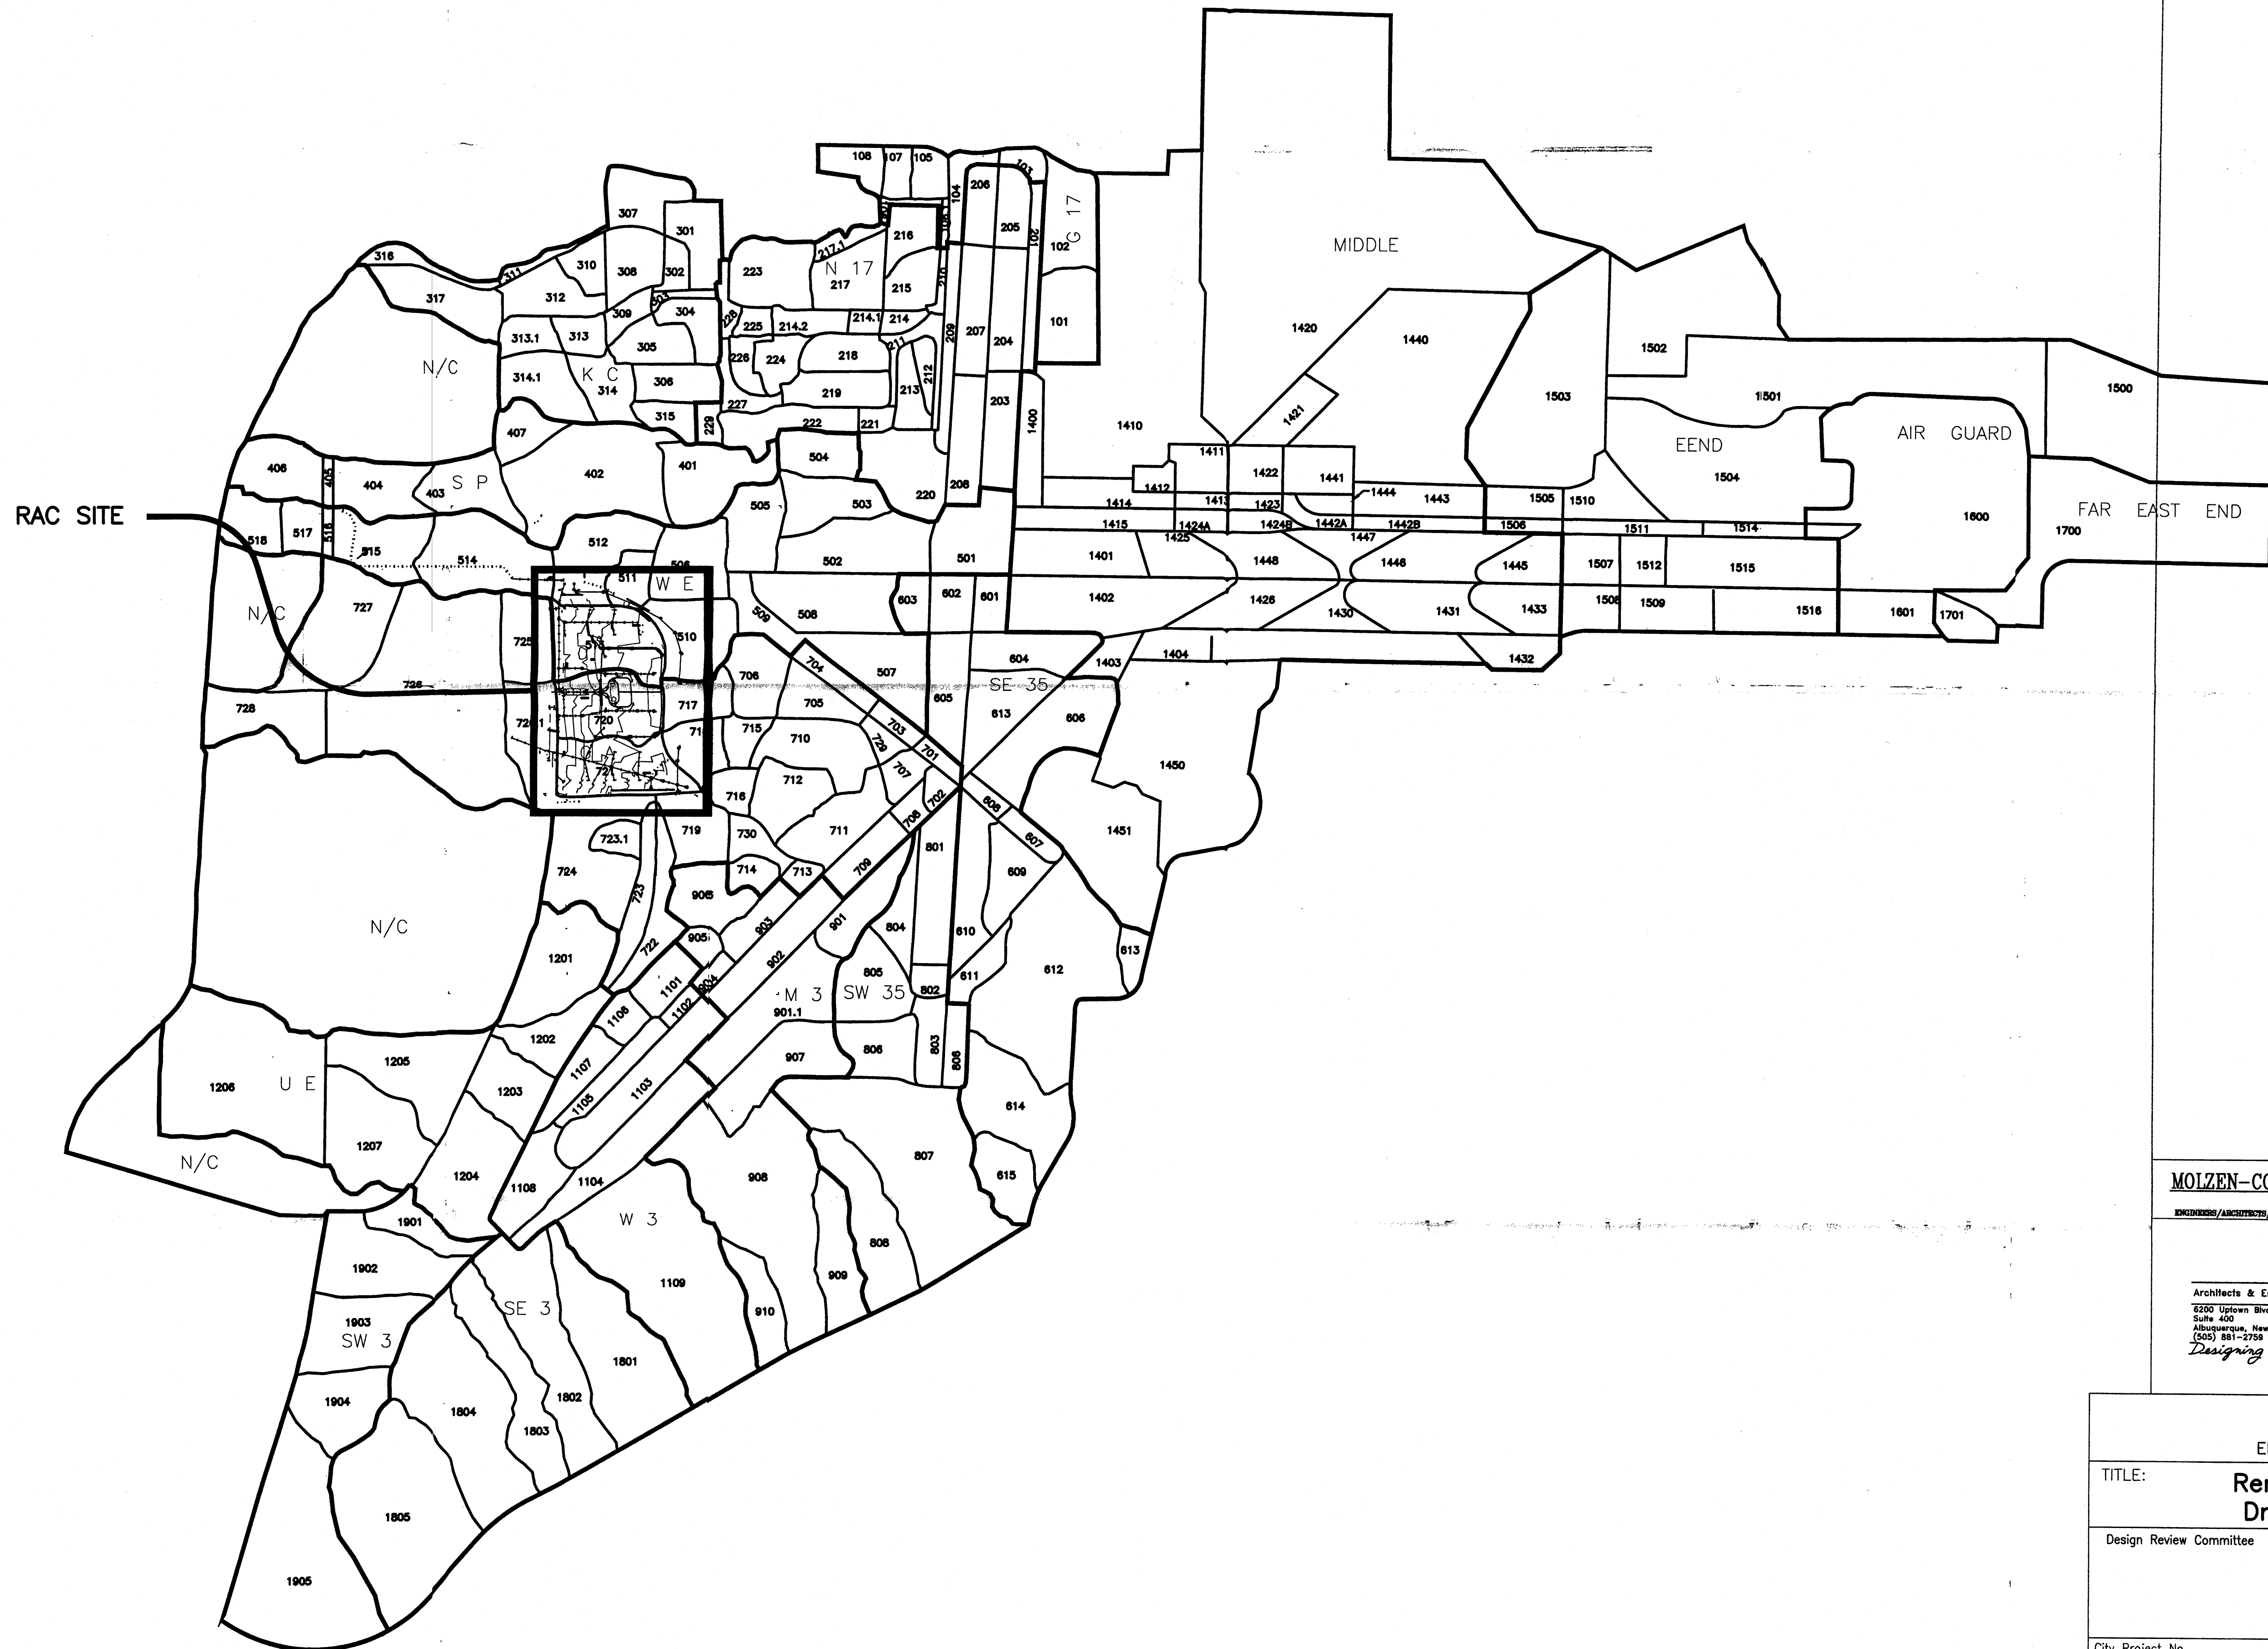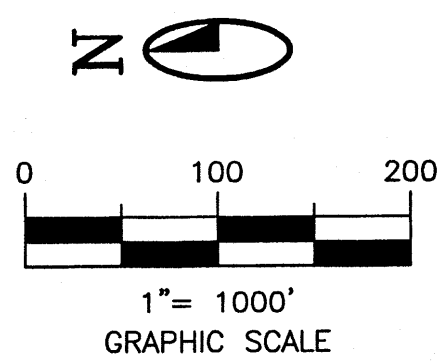

MOLZEN-CORBIN & Associates
ENGINEERS/ARCHITECTS/PLANNERS Albuquerque • Las Cruces • Los Alamos

Architects & Engineers, Inc.
6200 Uptown Blvd. NE Suite 400
Albuquerque, New Mexico 87110
(505) 881-2758
Designing to Shape the Future


49 West First Street Suite 100
Mesa, Arizona 85201
(602) 827-2759

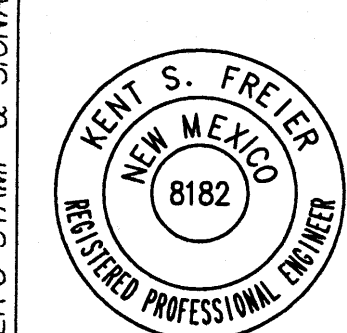

CITY OF ALBUQUERQUE PUBLIC WORKS DEPARTMENT ENGINEERING DEVELOPMENT GROUP			
TITLE: Remote Car Rental Facility Drainage Plan (Plate 5)			
Design Review Committee	City Engineer Approval	Last Design Update	
City Project No.	Zone Map No.	Sheet	Of
6101.91	N-15-Z	1	1

SURVEY INFORMATION		BENCH MARKS		AS BUILT INFORMATION	
Field Notes					
No.	By	Date		Contractor	
				Work	
				Staked By	Date
				Checked By	Date
				Approved By	Date
				Field	Date
				Drawings	Date
				Corrected By	Date
			MICRO-FILM INFORMATION		
			Recorded By	No.	Date

plate5 09-13-99

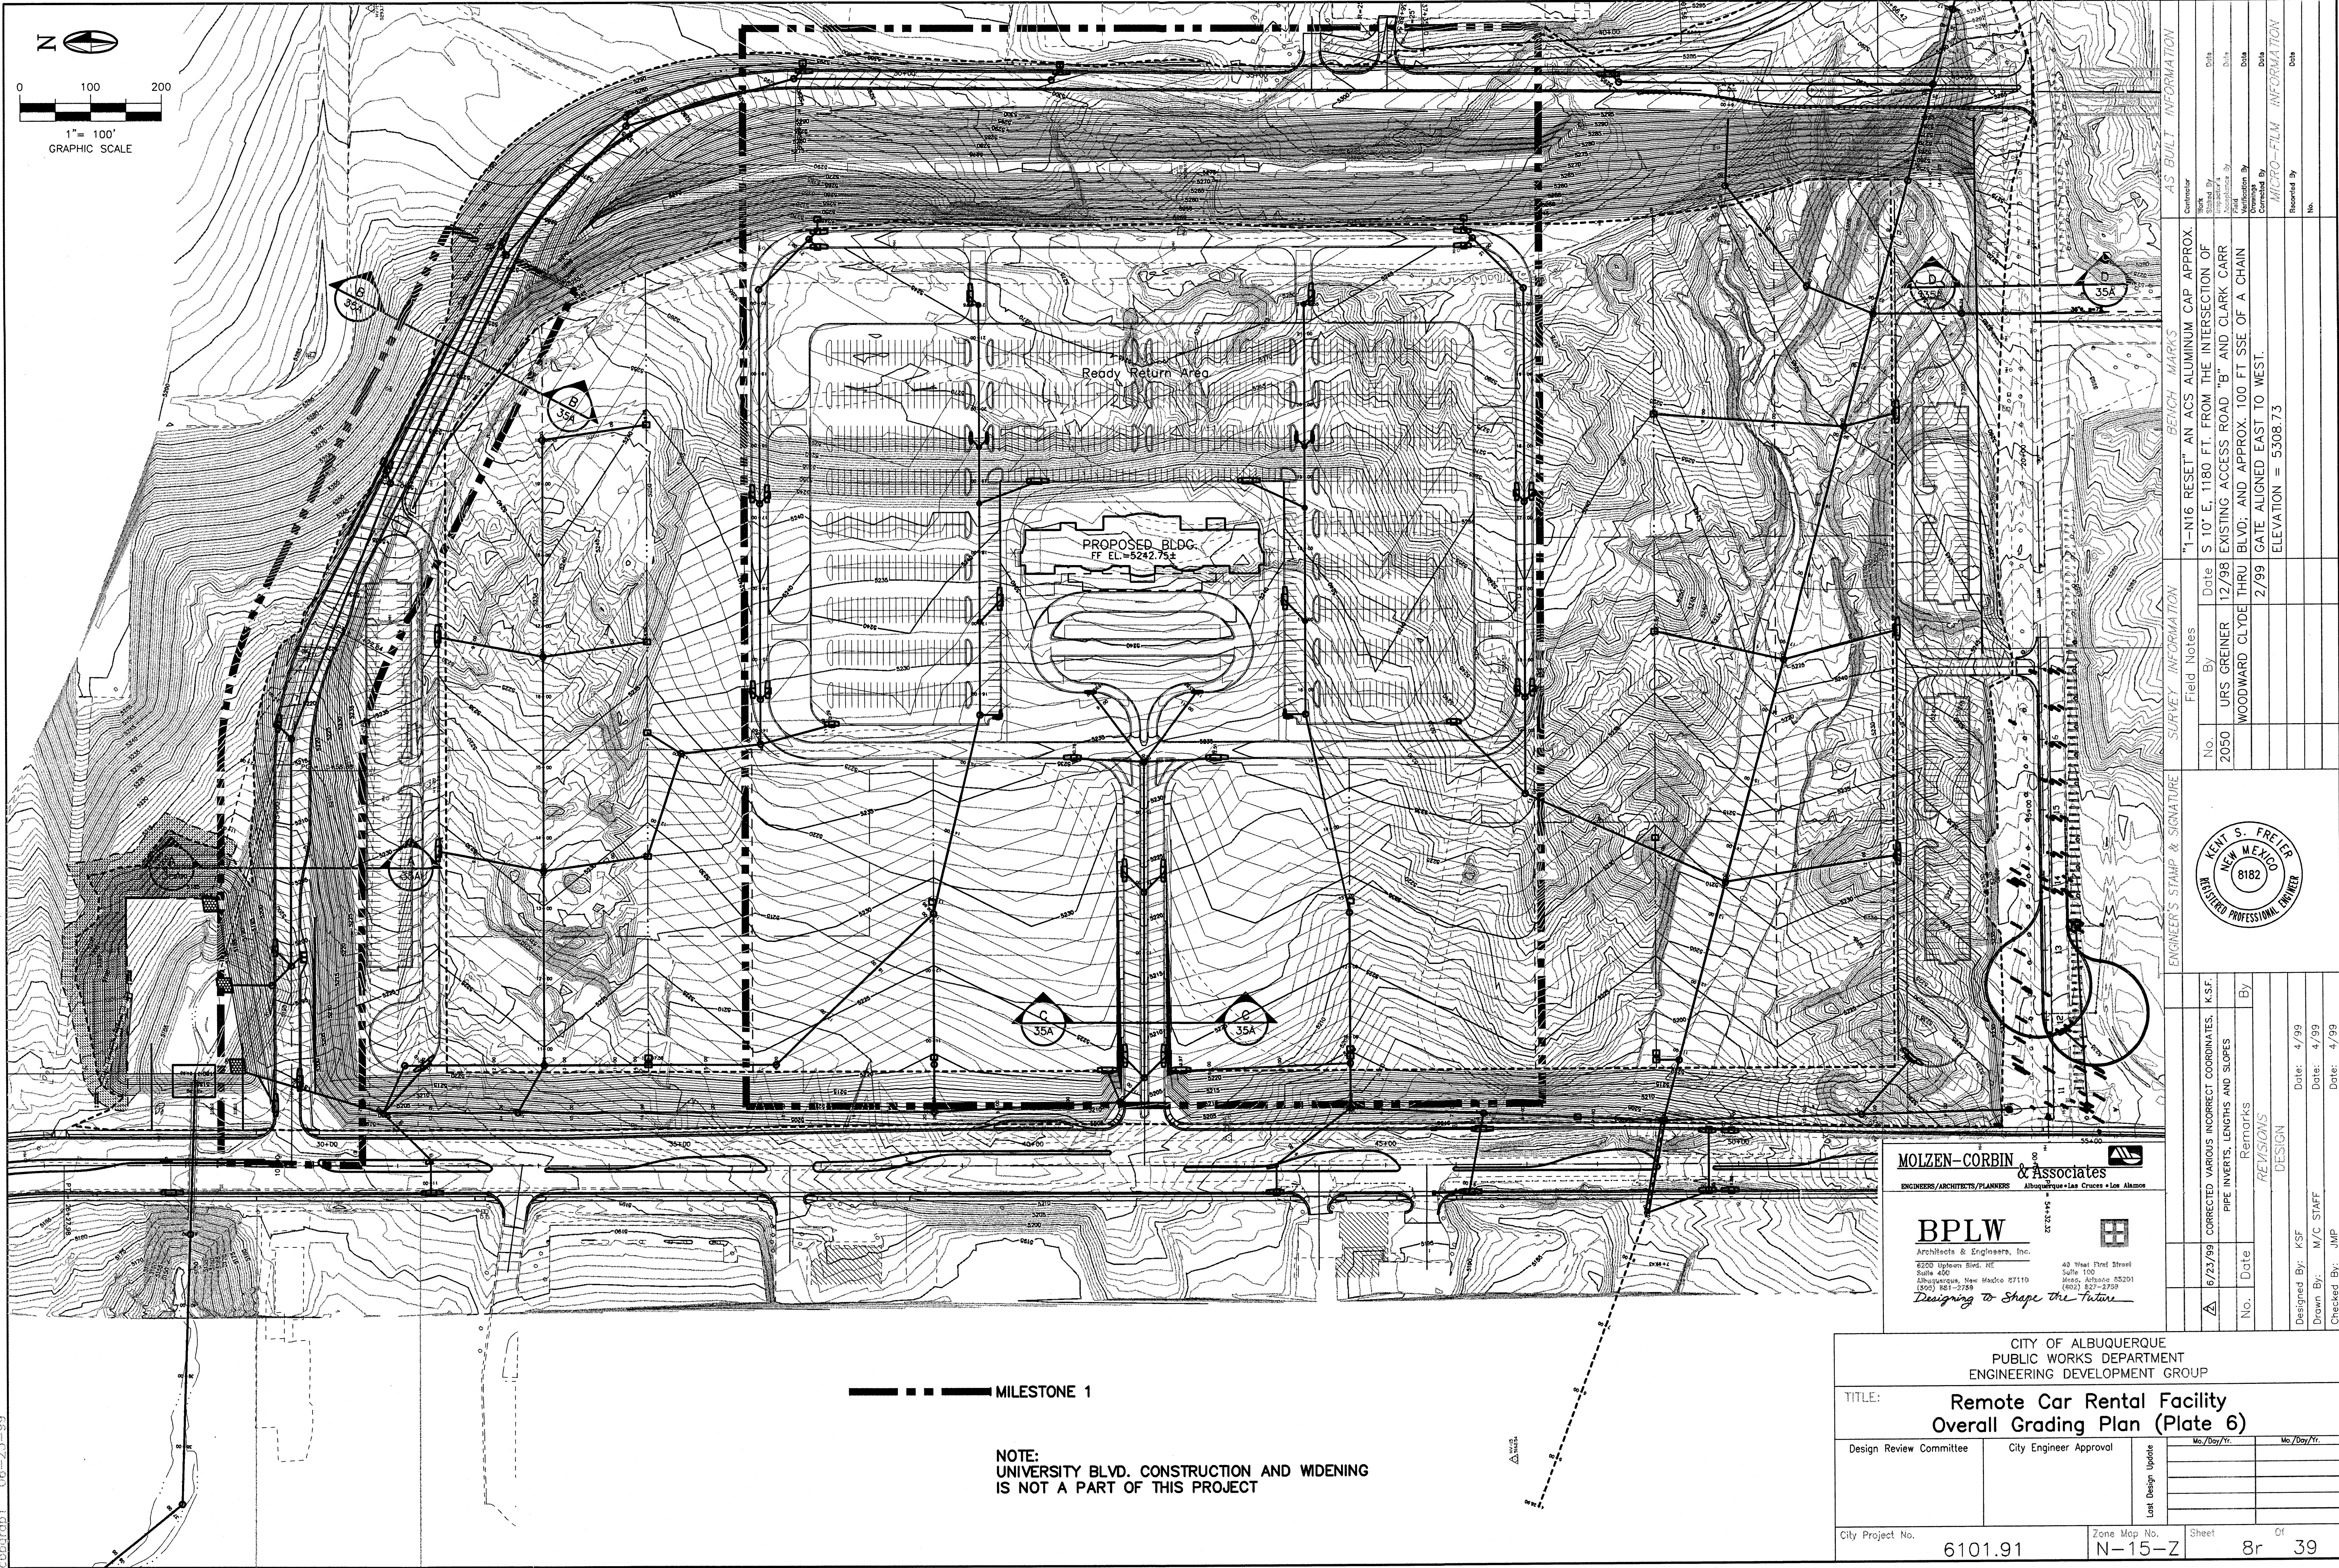

06-23-99

MILESTONE 1

NOTE:
UNIVERSITY BLVD. CONSTRUCTION AND WIDENING
IS NOT A PART OF THIS PROJECT

MOLZEN-CORBIN & Associates
ENGINEERS/ARCHITECTS/PLANNERS
Albuquerque • Las Cruces • Los Alamos

BPLW
Architects & Engineers, Inc.






6200 Updown Blvd. NE
Suite 400
Albuquerque, New Mexico 87110
(505) 881-2789
Designing to Shape the Future

40 West Third Street
Suite 100
Albuquerque, New Mexico 87102
(505) 827-2789




ENGINEER'S STAMP & SIGNATURE		SURVEY INFORMATION		BENCH MARKS		AS BUILT INFORMATION	
No.	2050	Field Notes	By	Date	12/98	Contractor	1-T-N16 RESET AN ACS ALUMINUM CAP APPROX. S 10' E, 1180 FT. FROM THE INTERSECTION OF EXISTING ACCESS ROAD "B" AND CLARK CARR THRU BLVD. AND APPROX. 100 FT SSE OF A CHAIN 2/99 GATE ALIGNED EAST TO WEST. ELEVATION = 5308.73
Remarks		By	URS GREINER	Date	12/98	Work Sheet By	
REVISIONS		By	WOODWARD CLYDE	Date	2/99	Checked By	
DESIGN		By		Date		Recorded By	
Designed By: KSF	Date: 4/99						
Drawn By: M/C STAFF	Date: 4/99						
Checked By: JMP	Date: 4/99						


CITY OF ALBUQUERQUE PUBLIC WORKS DEPARTMENT ENGINEERING DEVELOPMENT GROUP			
TITLE: Remote Car Rental Facility Overall Grading Plan (Plate 6)			
Design Review Committee	City Engineer Approval	Mo./Day/Yr.	Mo./Day/Yr.
City Project No.	Zone Map No.	Sheet	Of
6101.91	N-15-Z	8r	39

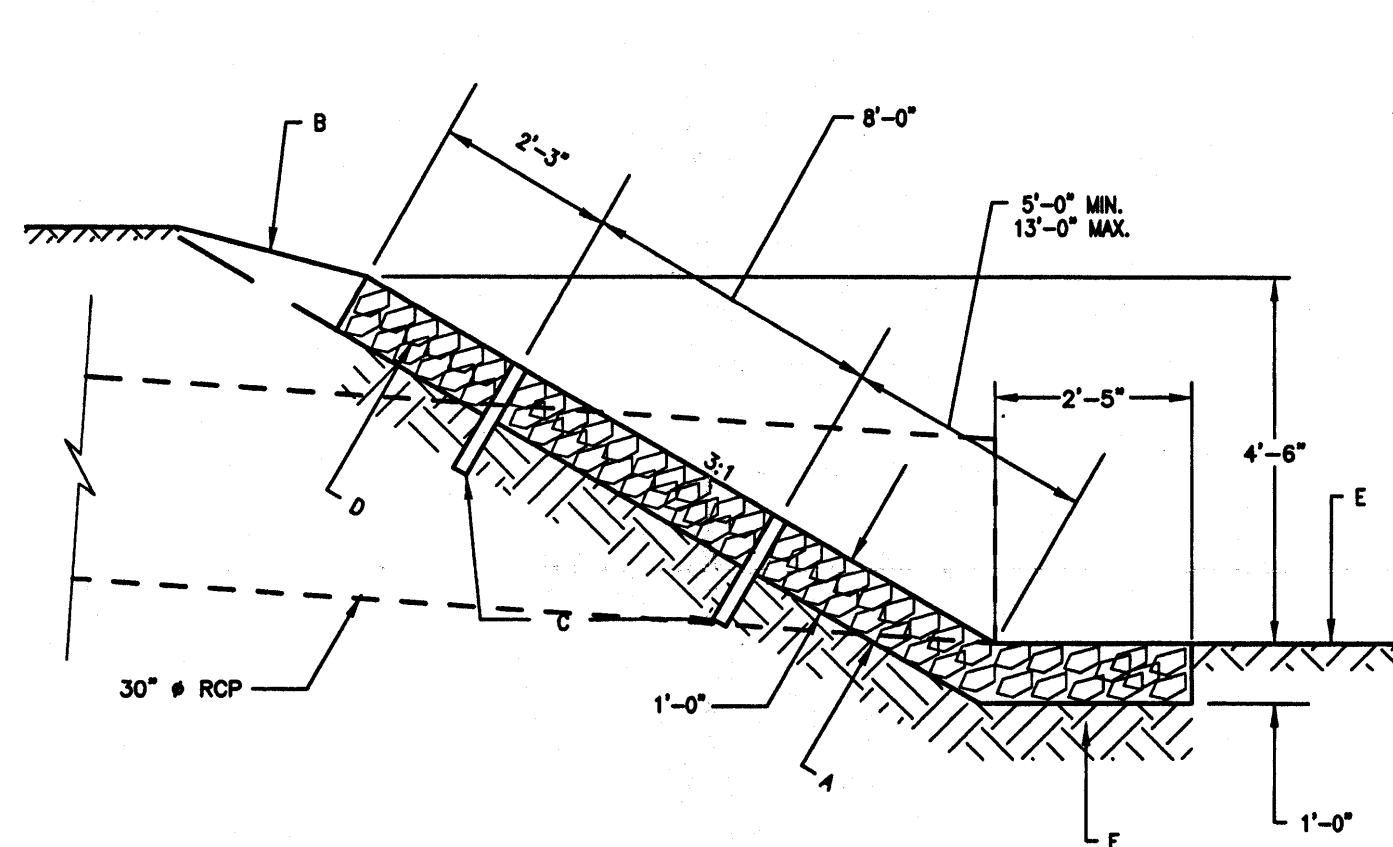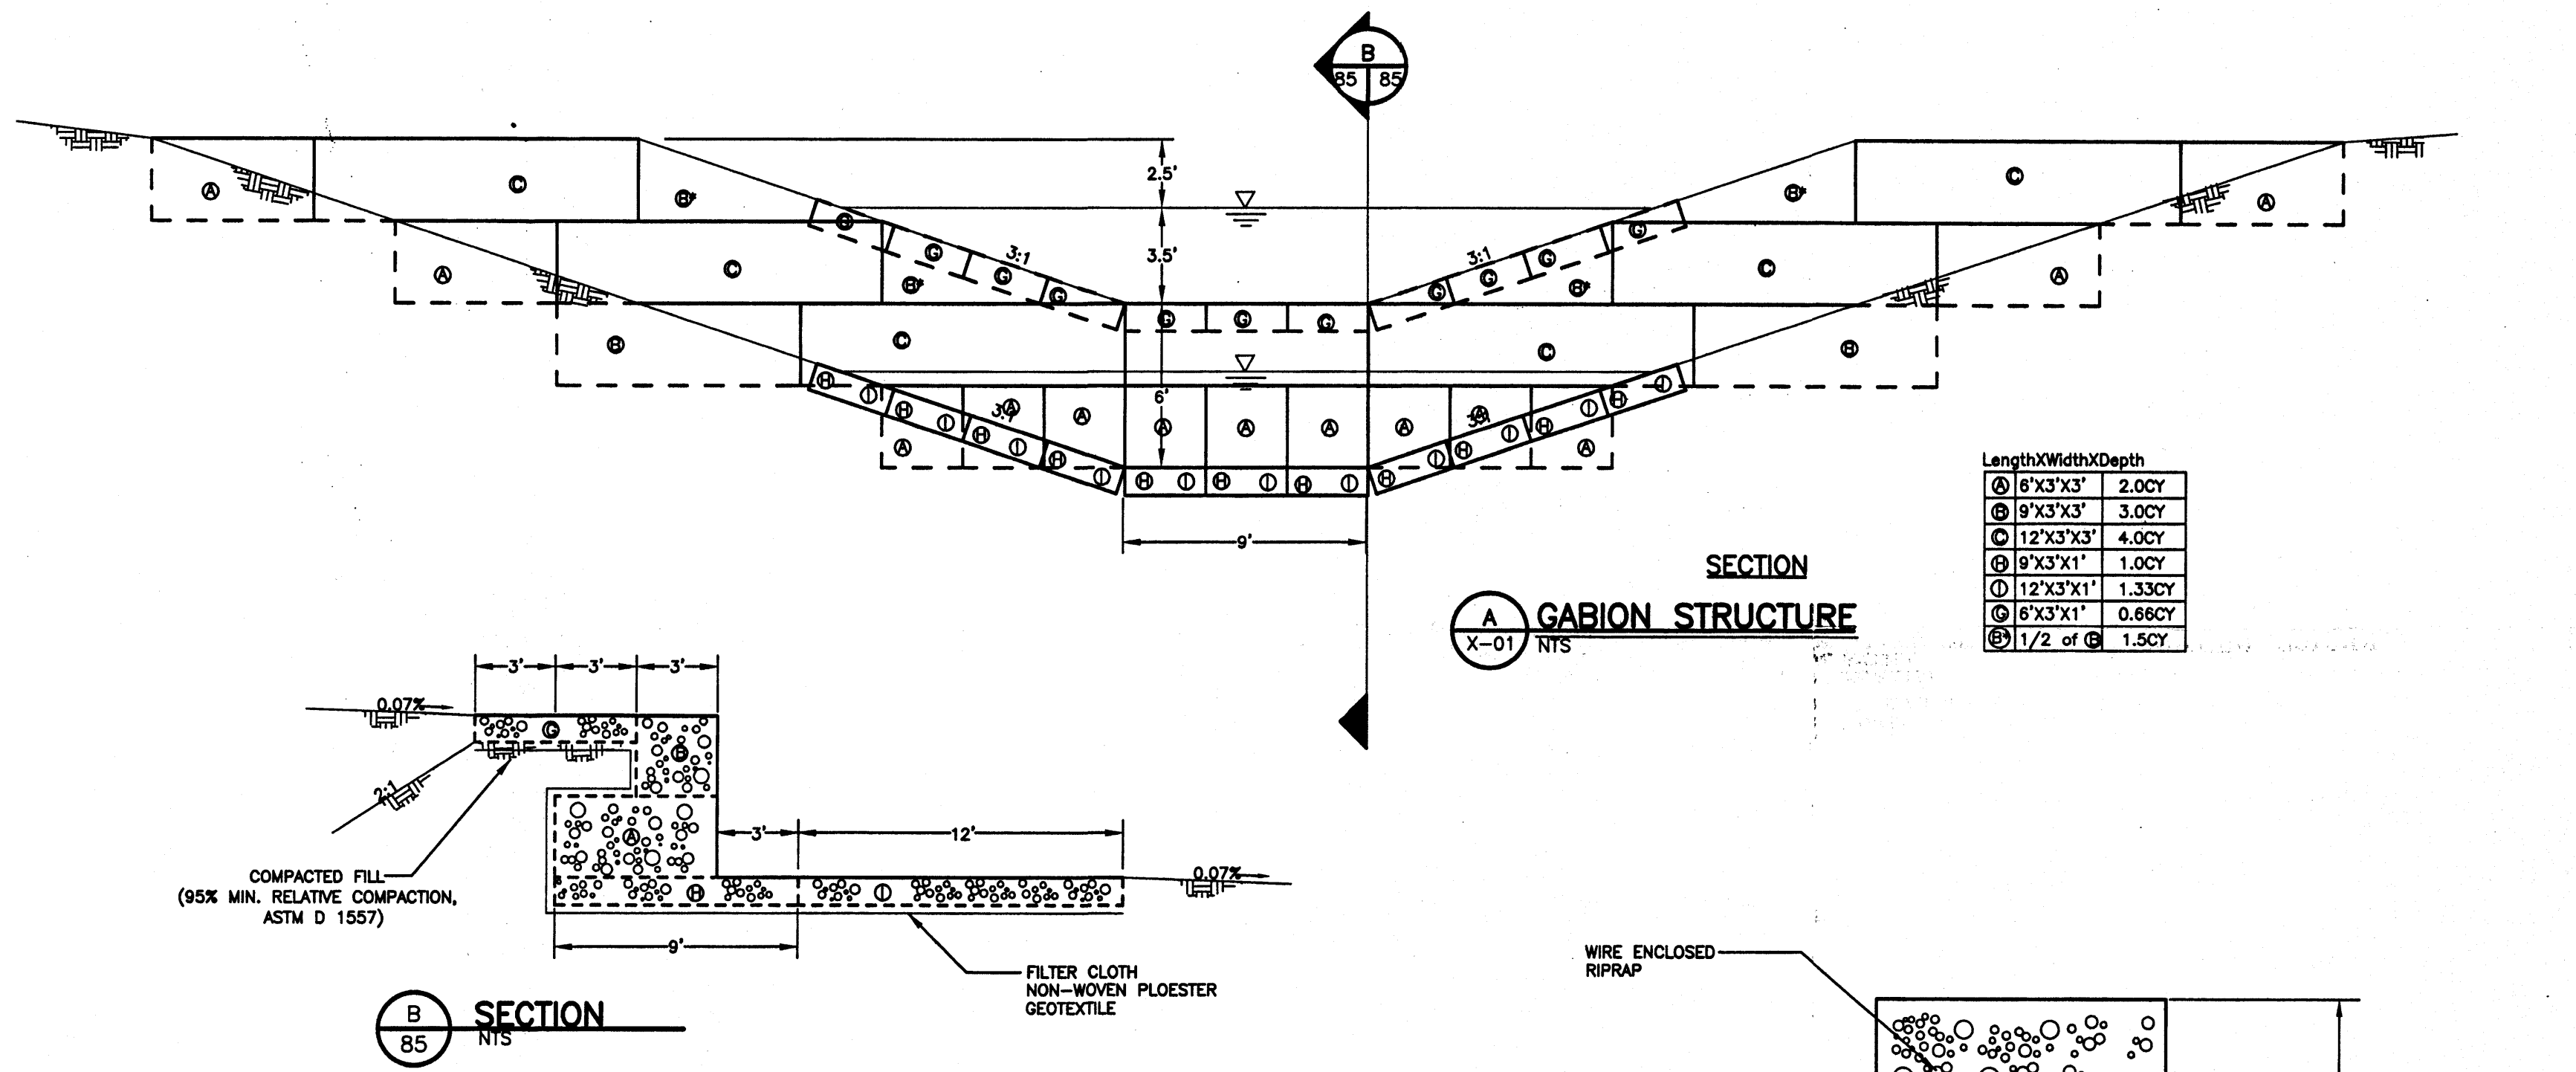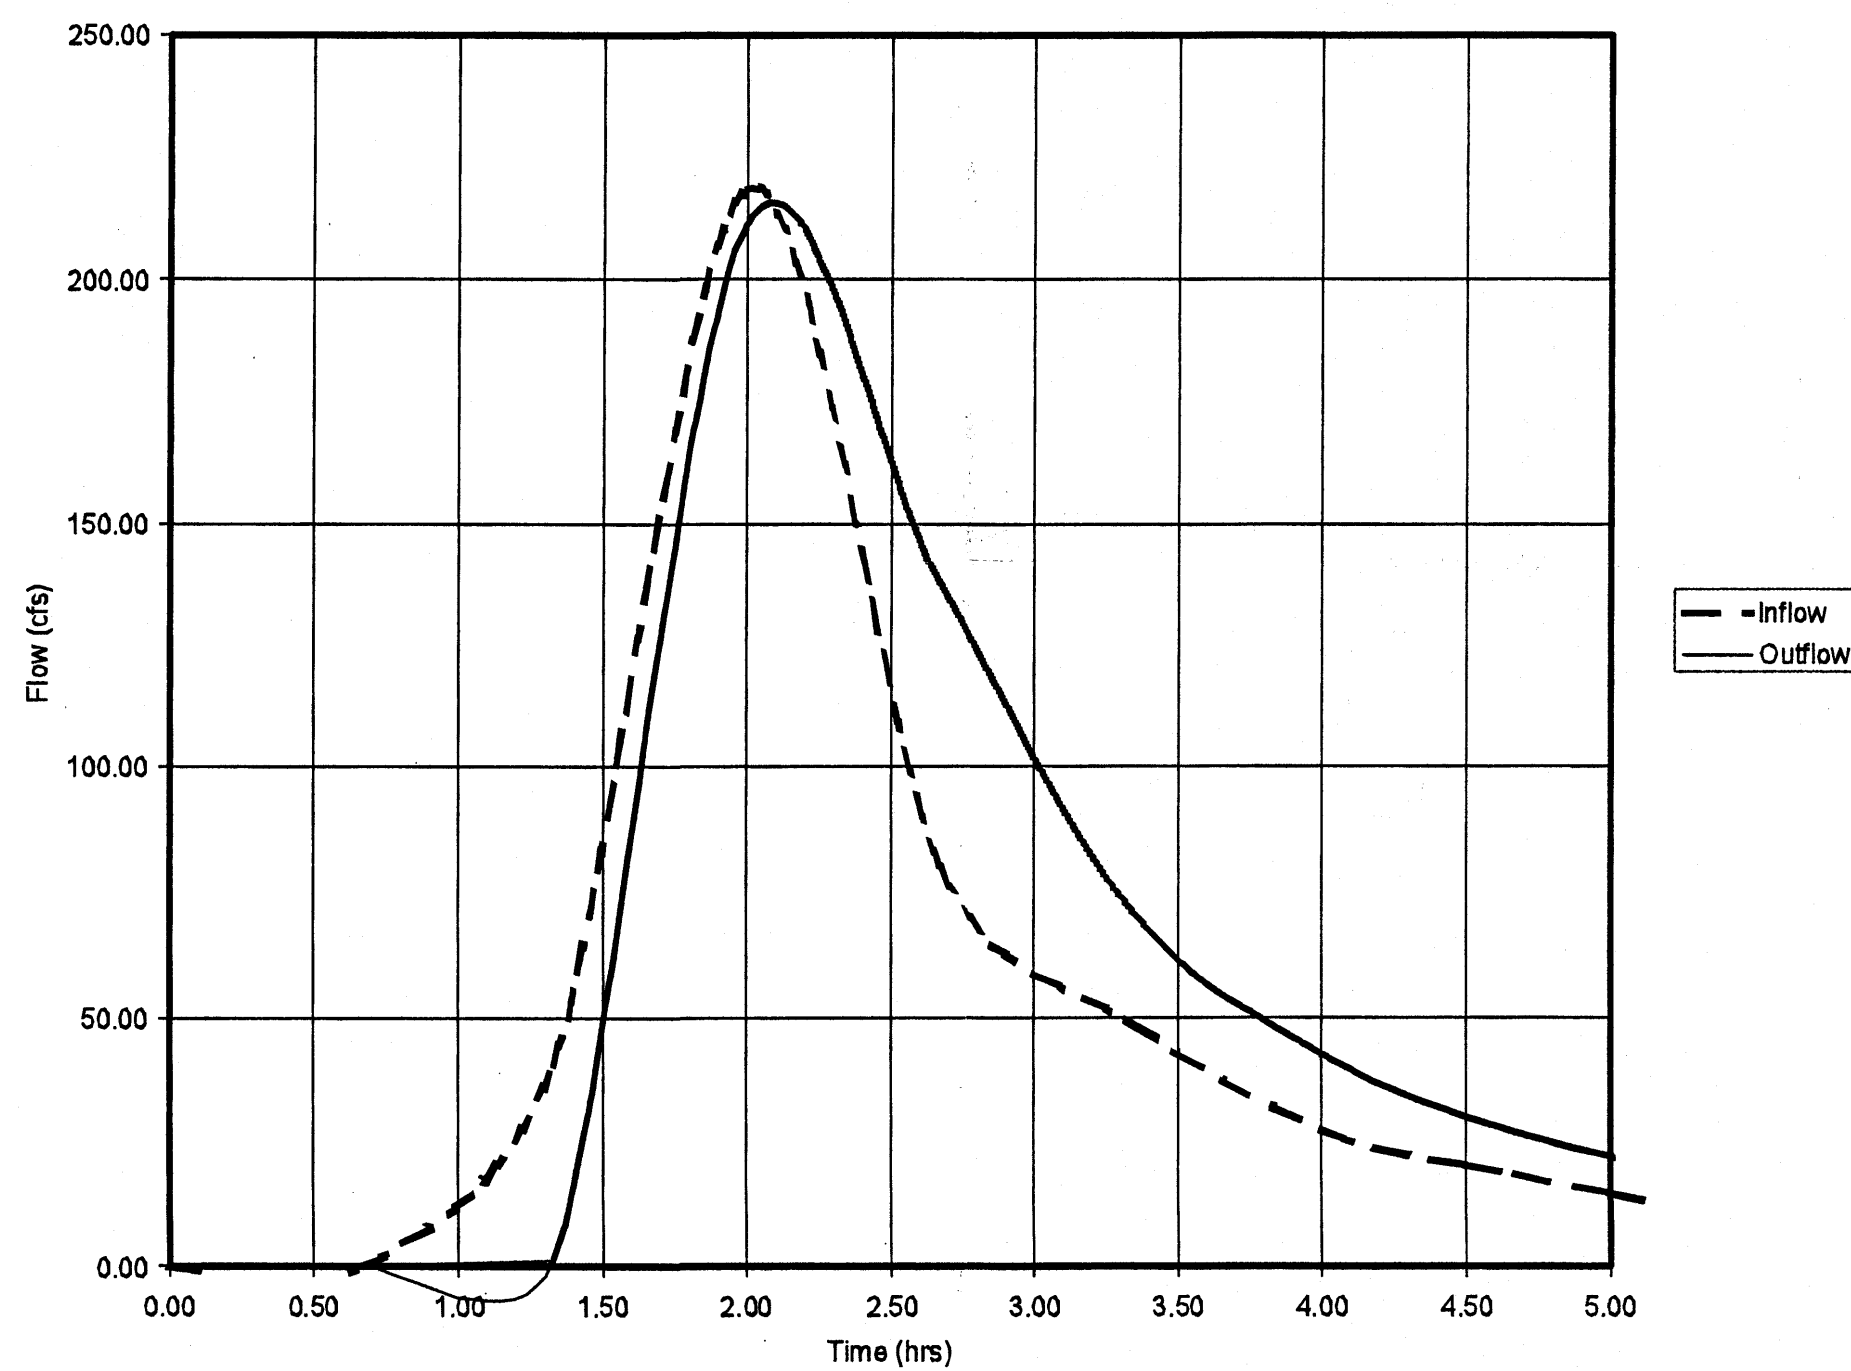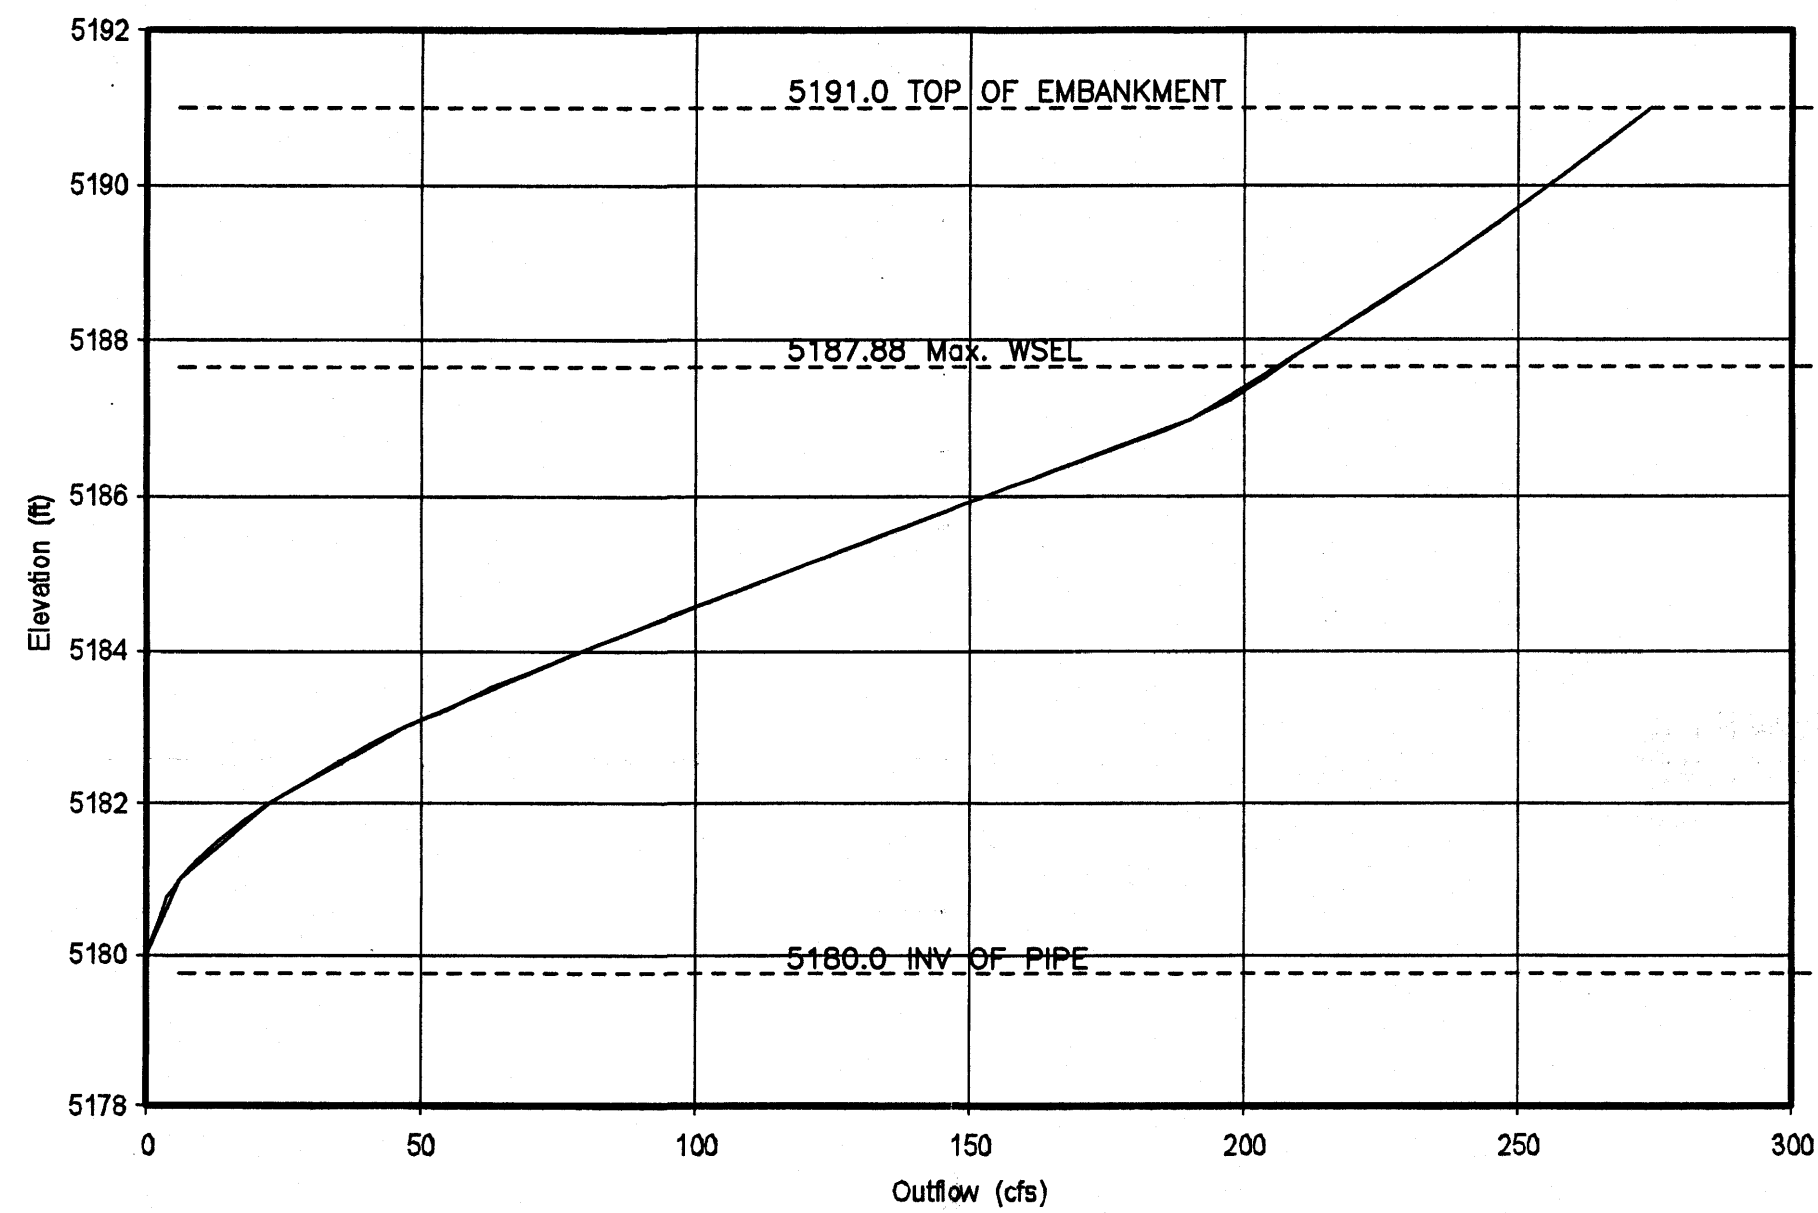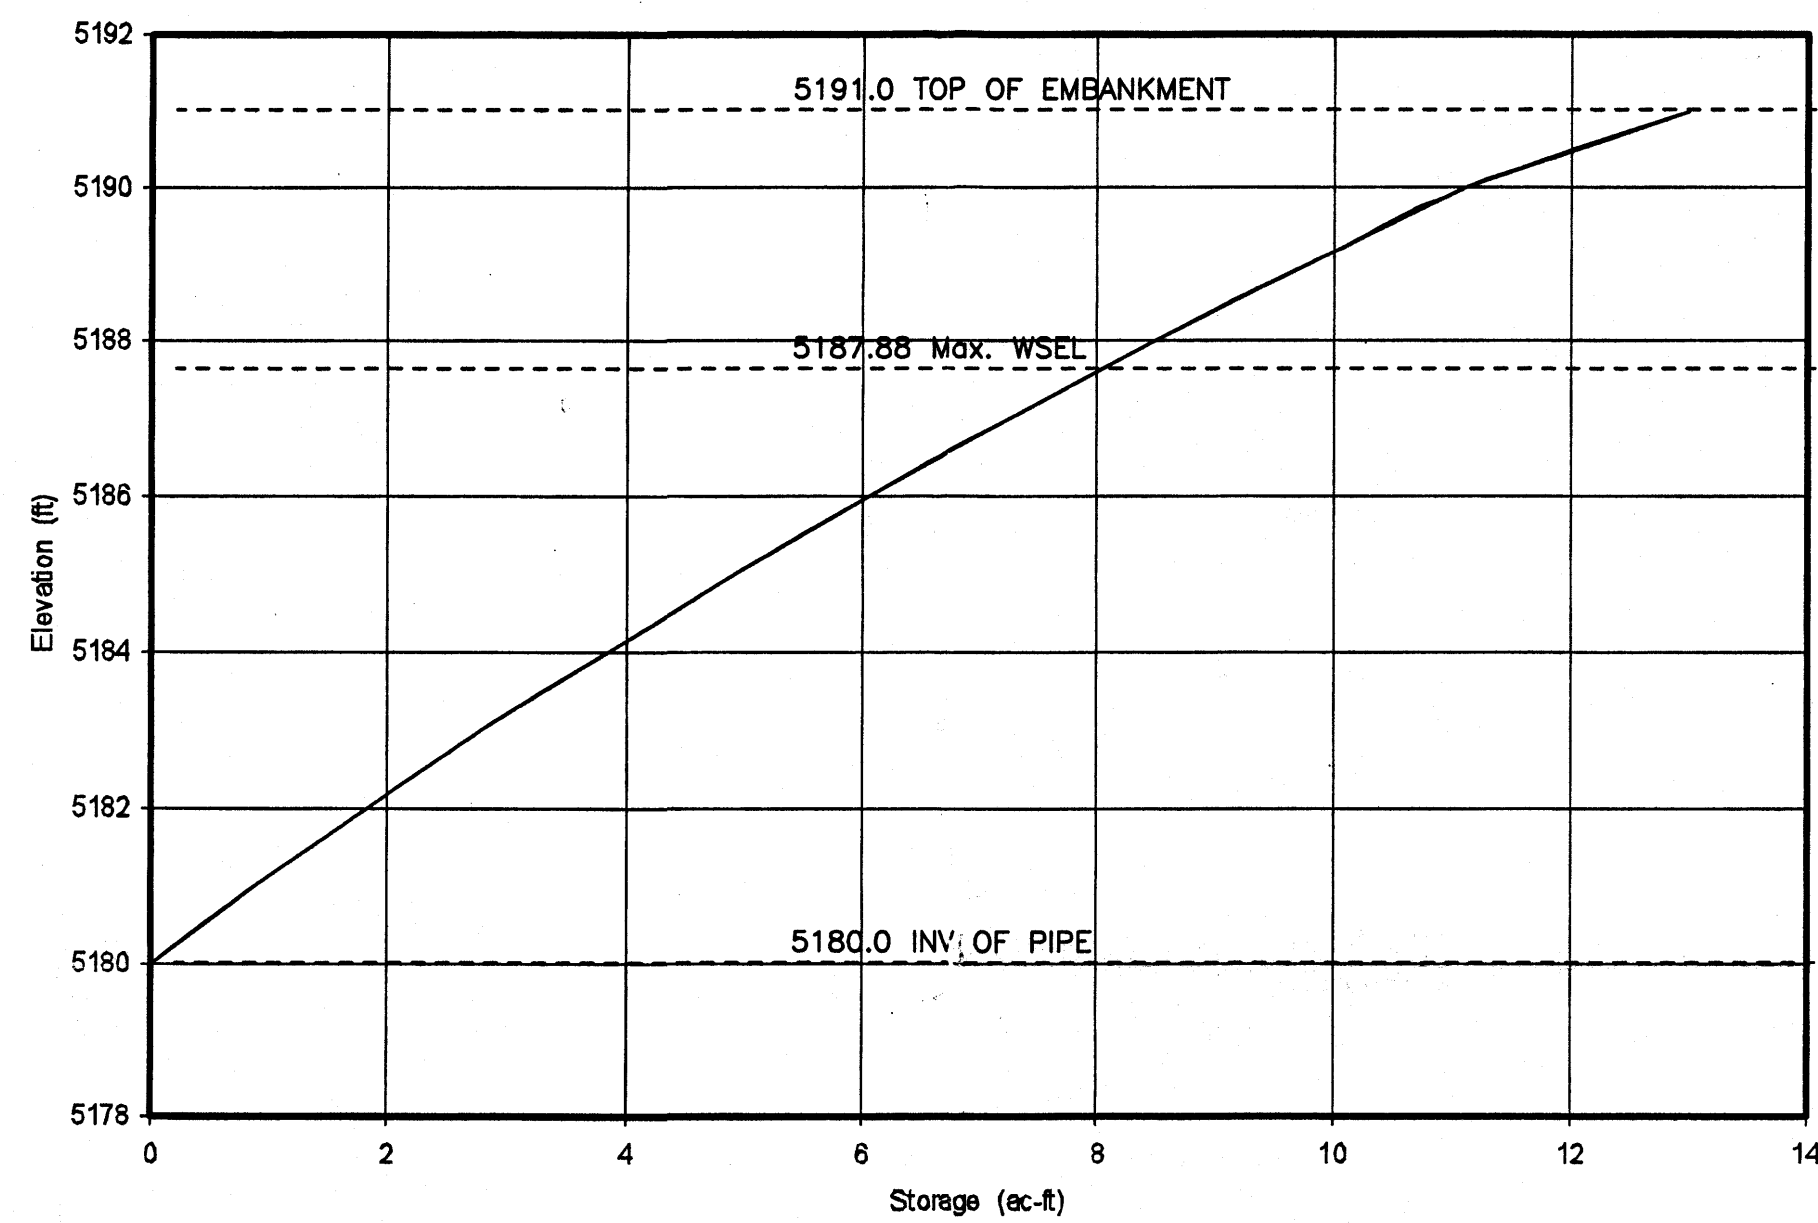


SECTION
WIRE ENCLOSED RIPRAP (TYPICAL)
NTS

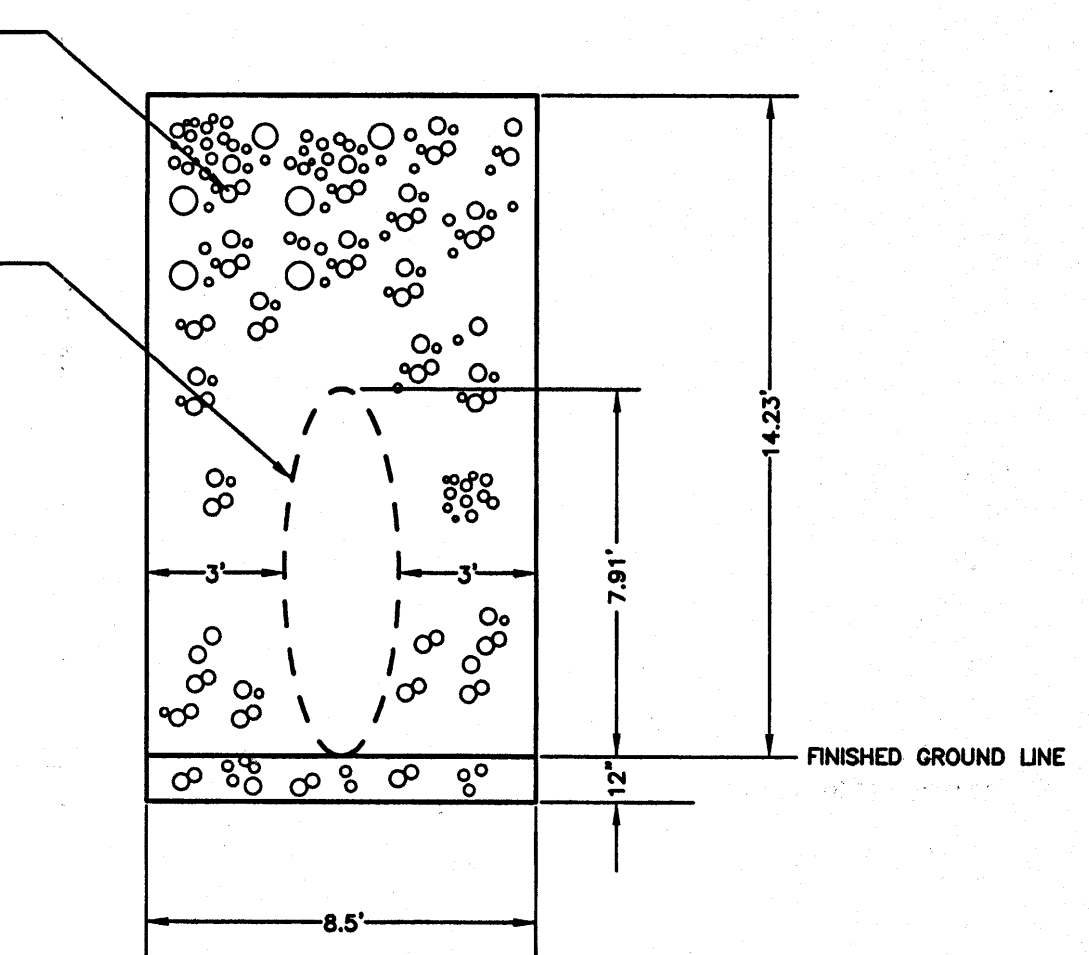

PLAN
WIRE ENCLOSED RIPRAP (TYPICAL)
NTS

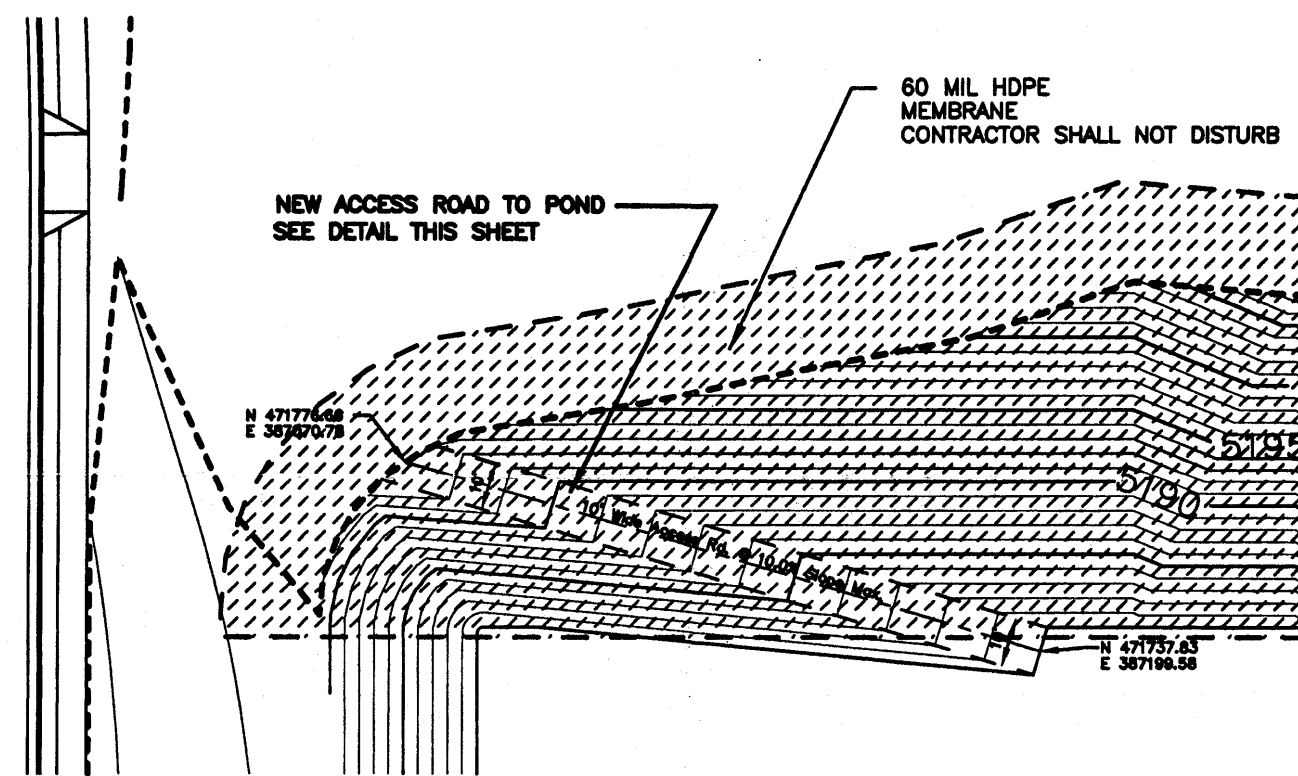


PLAN
ACCESS ROAD TO POND
NTS

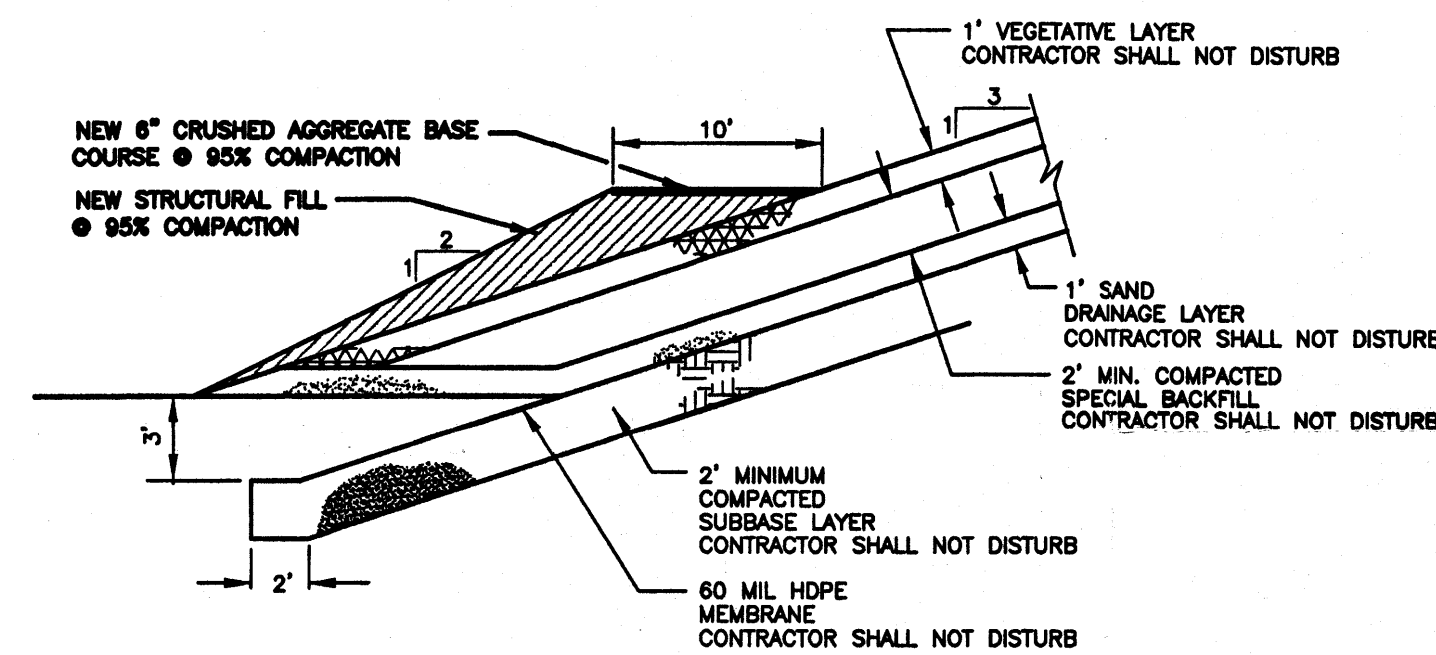

DETAIL
ACCESS ROAD TO POND
NTS

MOLZEN-CORBIN & Associates
ENGINEERS/ARCHITECTS/PLANNERS
Albuquerque • Las Cruces • Los Alamos
URS Greiner Woodward Clyde
5971 JEFFERSON BLVD. NE
SUITE 101
ALBUQUERQUE, NM 87109
(505) 345-3999

CITY OF ALBUQUERQUE PUBLIC WORKS DEPARTMENT ENGINEERING DEVELOPMENT GROUP										
TITLE: UNIVERSITY BOULEVARD/ACCESS ROAD B MISCELLANEOUS DETAILS (Plate 12)										
Design Review Committee	<table border="1"> <tr> <th>No.</th> <th>By</th> <th>Date</th> </tr> <tr> <td>1</td> <td>URS GREINER</td> <td>12/98</td> </tr> <tr> <td>2</td> <td>WOODWARD CLYDE</td> <td>2/99</td> </tr> </table>	No.	By	Date	1	URS GREINER	12/98	2	WOODWARD CLYDE	2/99
No.	By	Date								
1	URS GREINER	12/98								
2	WOODWARD CLYDE	2/99								
City Project No.	<table border="1"> <tr> <th>No.</th> <th>By</th> <th>Date</th> </tr> <tr> <td>1</td> <td>URS GREINER</td> <td>12/98</td> </tr> <tr> <td>2</td> <td>WOODWARD CLYDE</td> <td>2/99</td> </tr> </table>	No.	By	Date	1	URS GREINER	12/98	2	WOODWARD CLYDE	2/99
No.	By	Date								
1	URS GREINER	12/98								
2	WOODWARD CLYDE	2/99								
Zone Map No.	<table border="1"> <tr> <th>No.</th> <th>By</th> <th>Date</th> </tr> <tr> <td>1</td> <td>URS GREINER</td> <td>12/98</td> </tr> <tr> <td>2</td> <td>WOODWARD CLYDE</td> <td>2/99</td> </tr> </table>	No.	By	Date	1	URS GREINER	12/98	2	WOODWARD CLYDE	2/99
No.	By	Date								
1	URS GREINER	12/98								
2	WOODWARD CLYDE	2/99								
Sheet	<table border="1"> <tr> <th>No.</th> <th>By</th> <th>Date</th> </tr> <tr> <td>1</td> <td>URS GREINER</td> <td>12/98</td> </tr> <tr> <td>2</td> <td>WOODWARD CLYDE</td> <td>2/99</td> </tr> </table>	No.	By	Date	1	URS GREINER	12/98	2	WOODWARD CLYDE	2/99
No.	By	Date								
1	URS GREINER	12/98								
2	WOODWARD CLYDE	2/99								
Of	<table border="1"> <tr> <th>No.</th> <th>By</th> <th>Date</th> </tr> <tr> <td>1</td> <td>URS GREINER</td> <td>12/98</td> </tr> <tr> <td>2</td> <td>WOODWARD CLYDE</td> <td>2/99</td> </tr> </table>	No.	By	Date	1	URS GREINER	12/98	2	WOODWARD CLYDE	2/99
No.	By	Date								
1	URS GREINER	12/98								
2	WOODWARD CLYDE	2/99								

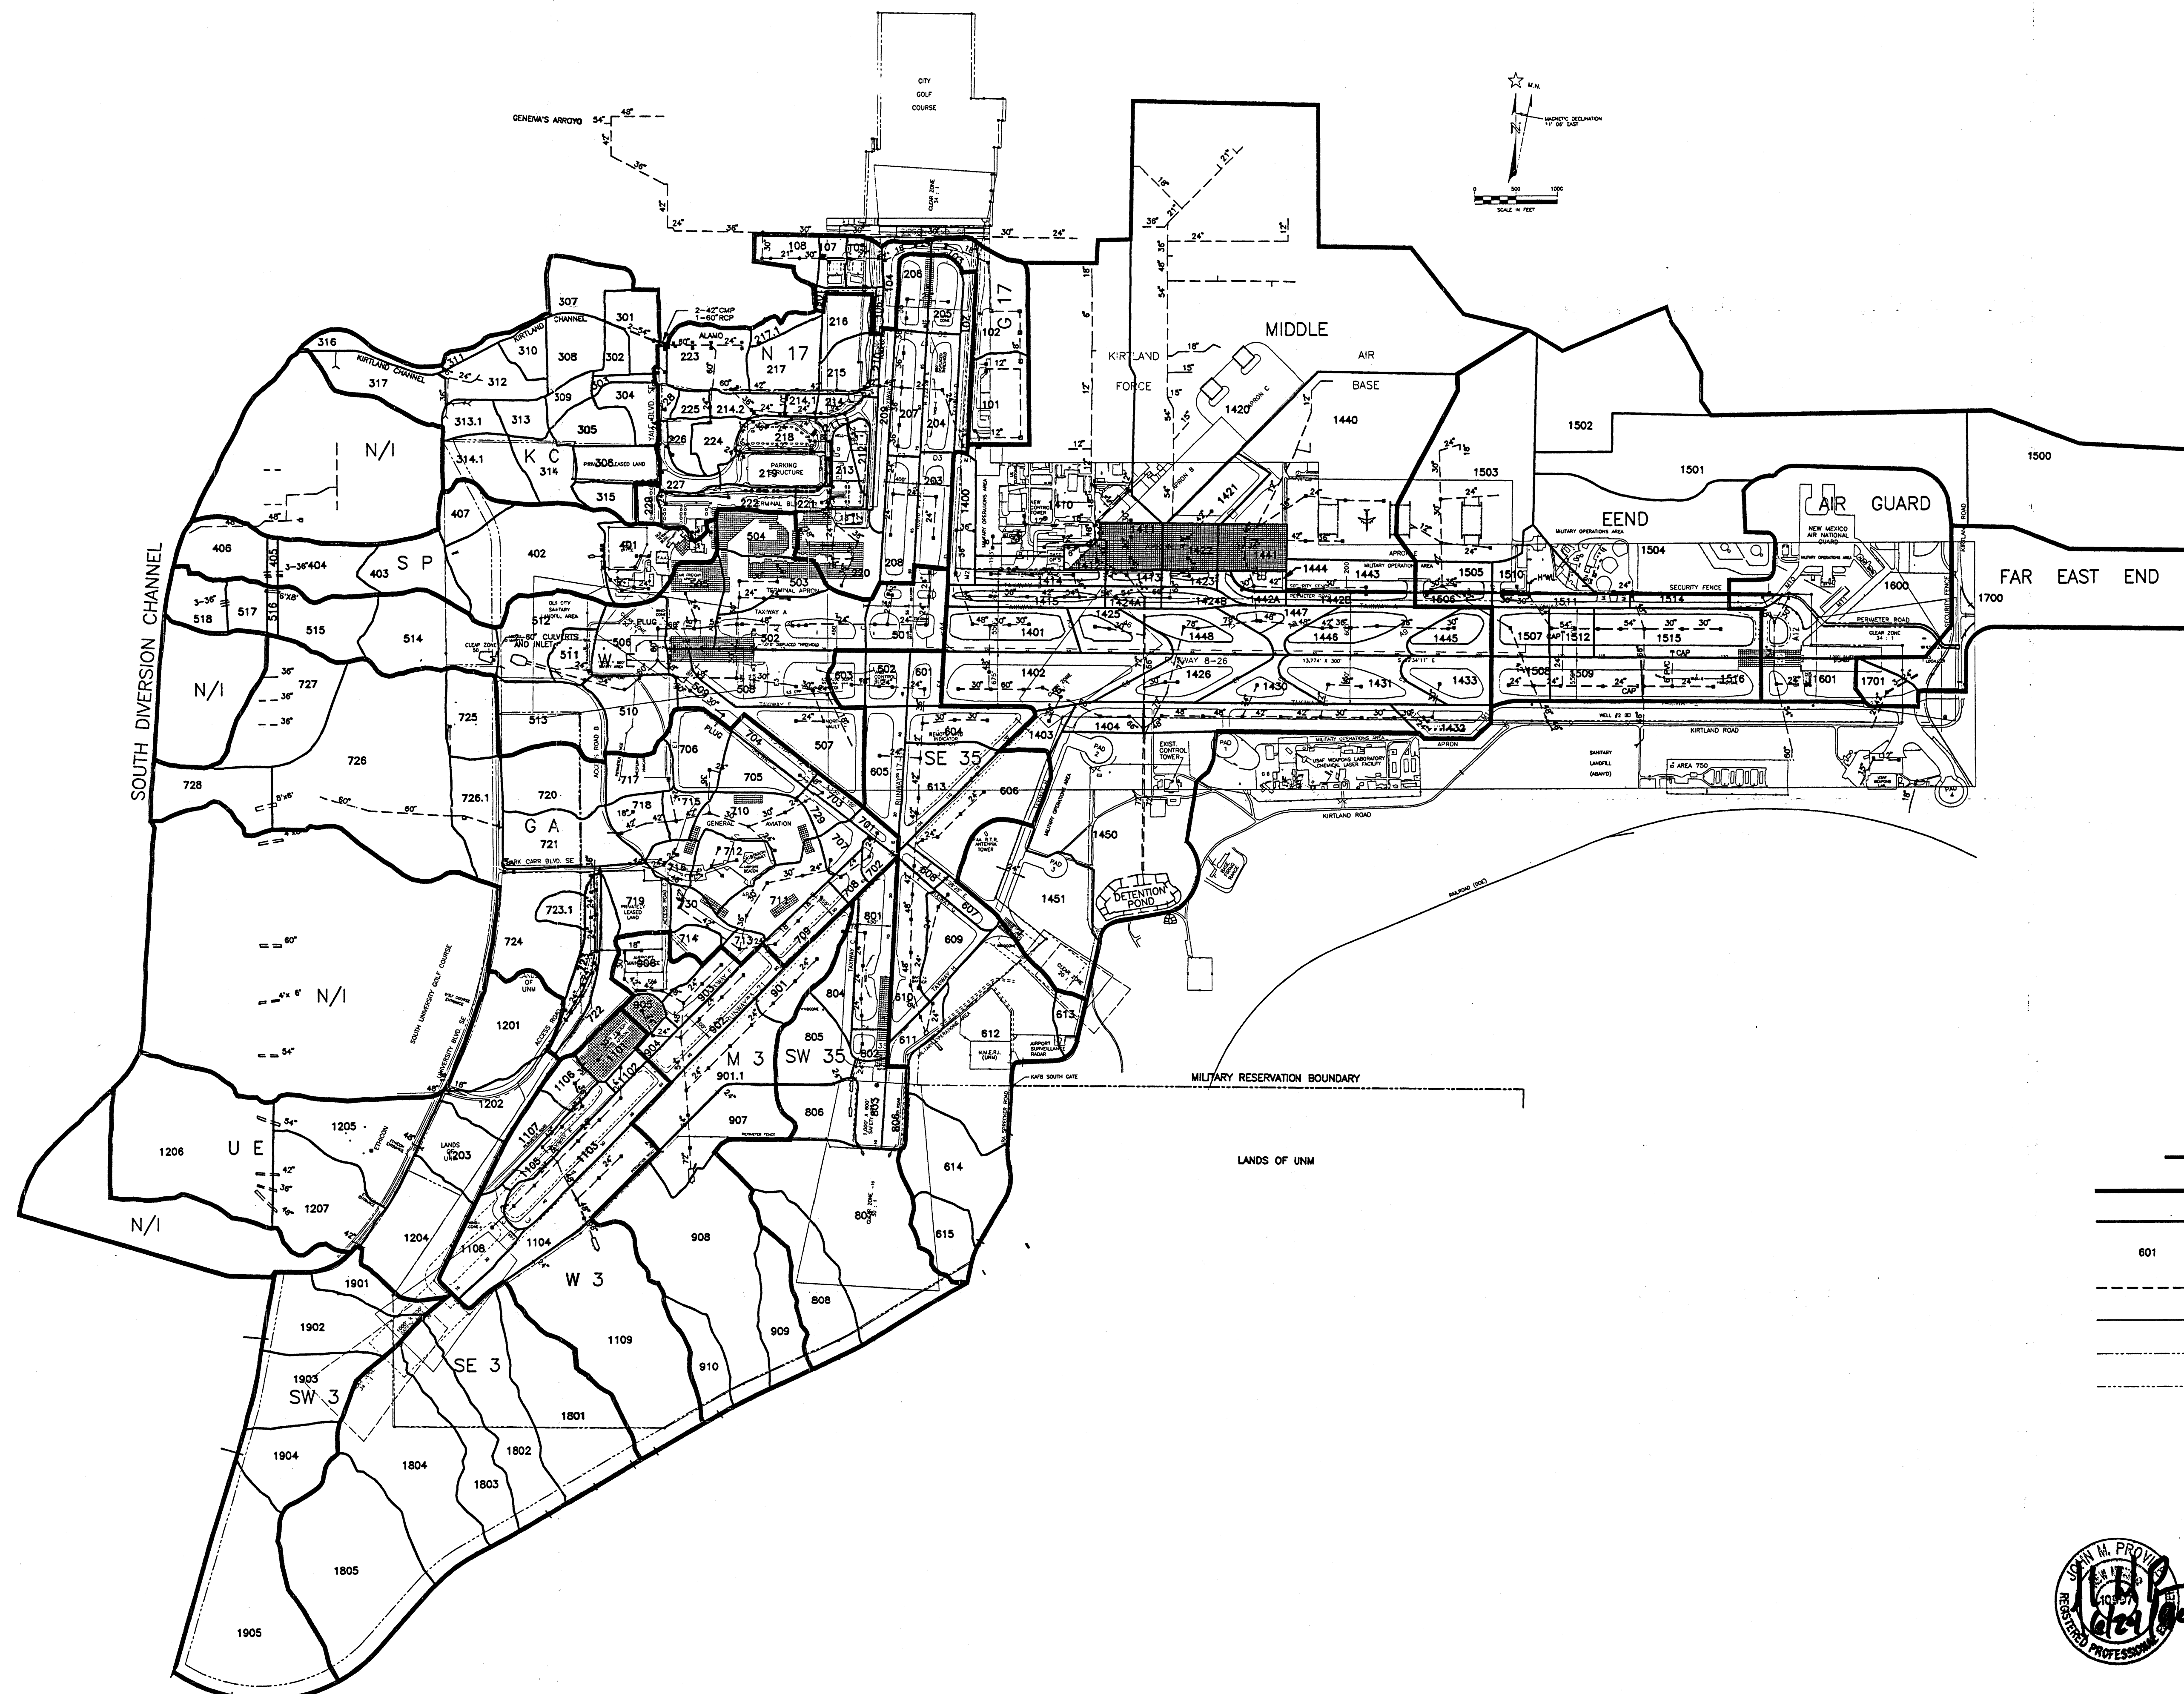




LEGEND

- MAJOR DRAINAGE BASIN
- DRAINAGE SUB-BASIN
- DRAINAGE SUB-BASIN NUMBER
- EXISTING STORM DRAINS
- TAXIWAY A RECONSTRUCTION
- AIRPORT BOUNDARY
- PROPOSED PROPERTY ACQUISITIONS



CITY OF ALBUQUERQUE		NEW MEXICO	
DRAINAGE BASIN MAP EXISTING CONDITIONS			
ALBUQUERQUE INTERNATIONAL AIRPORT			
MOLZEN-CORBIN & Associates			
ENGINEERS/PLANNERS/CONSULTANTS Albuquerque • New Mexico • Las Cruces			
Designed	Drawn HC-A	Checked JMP	Sheet of
Date JUNE 1994			PLATE 2

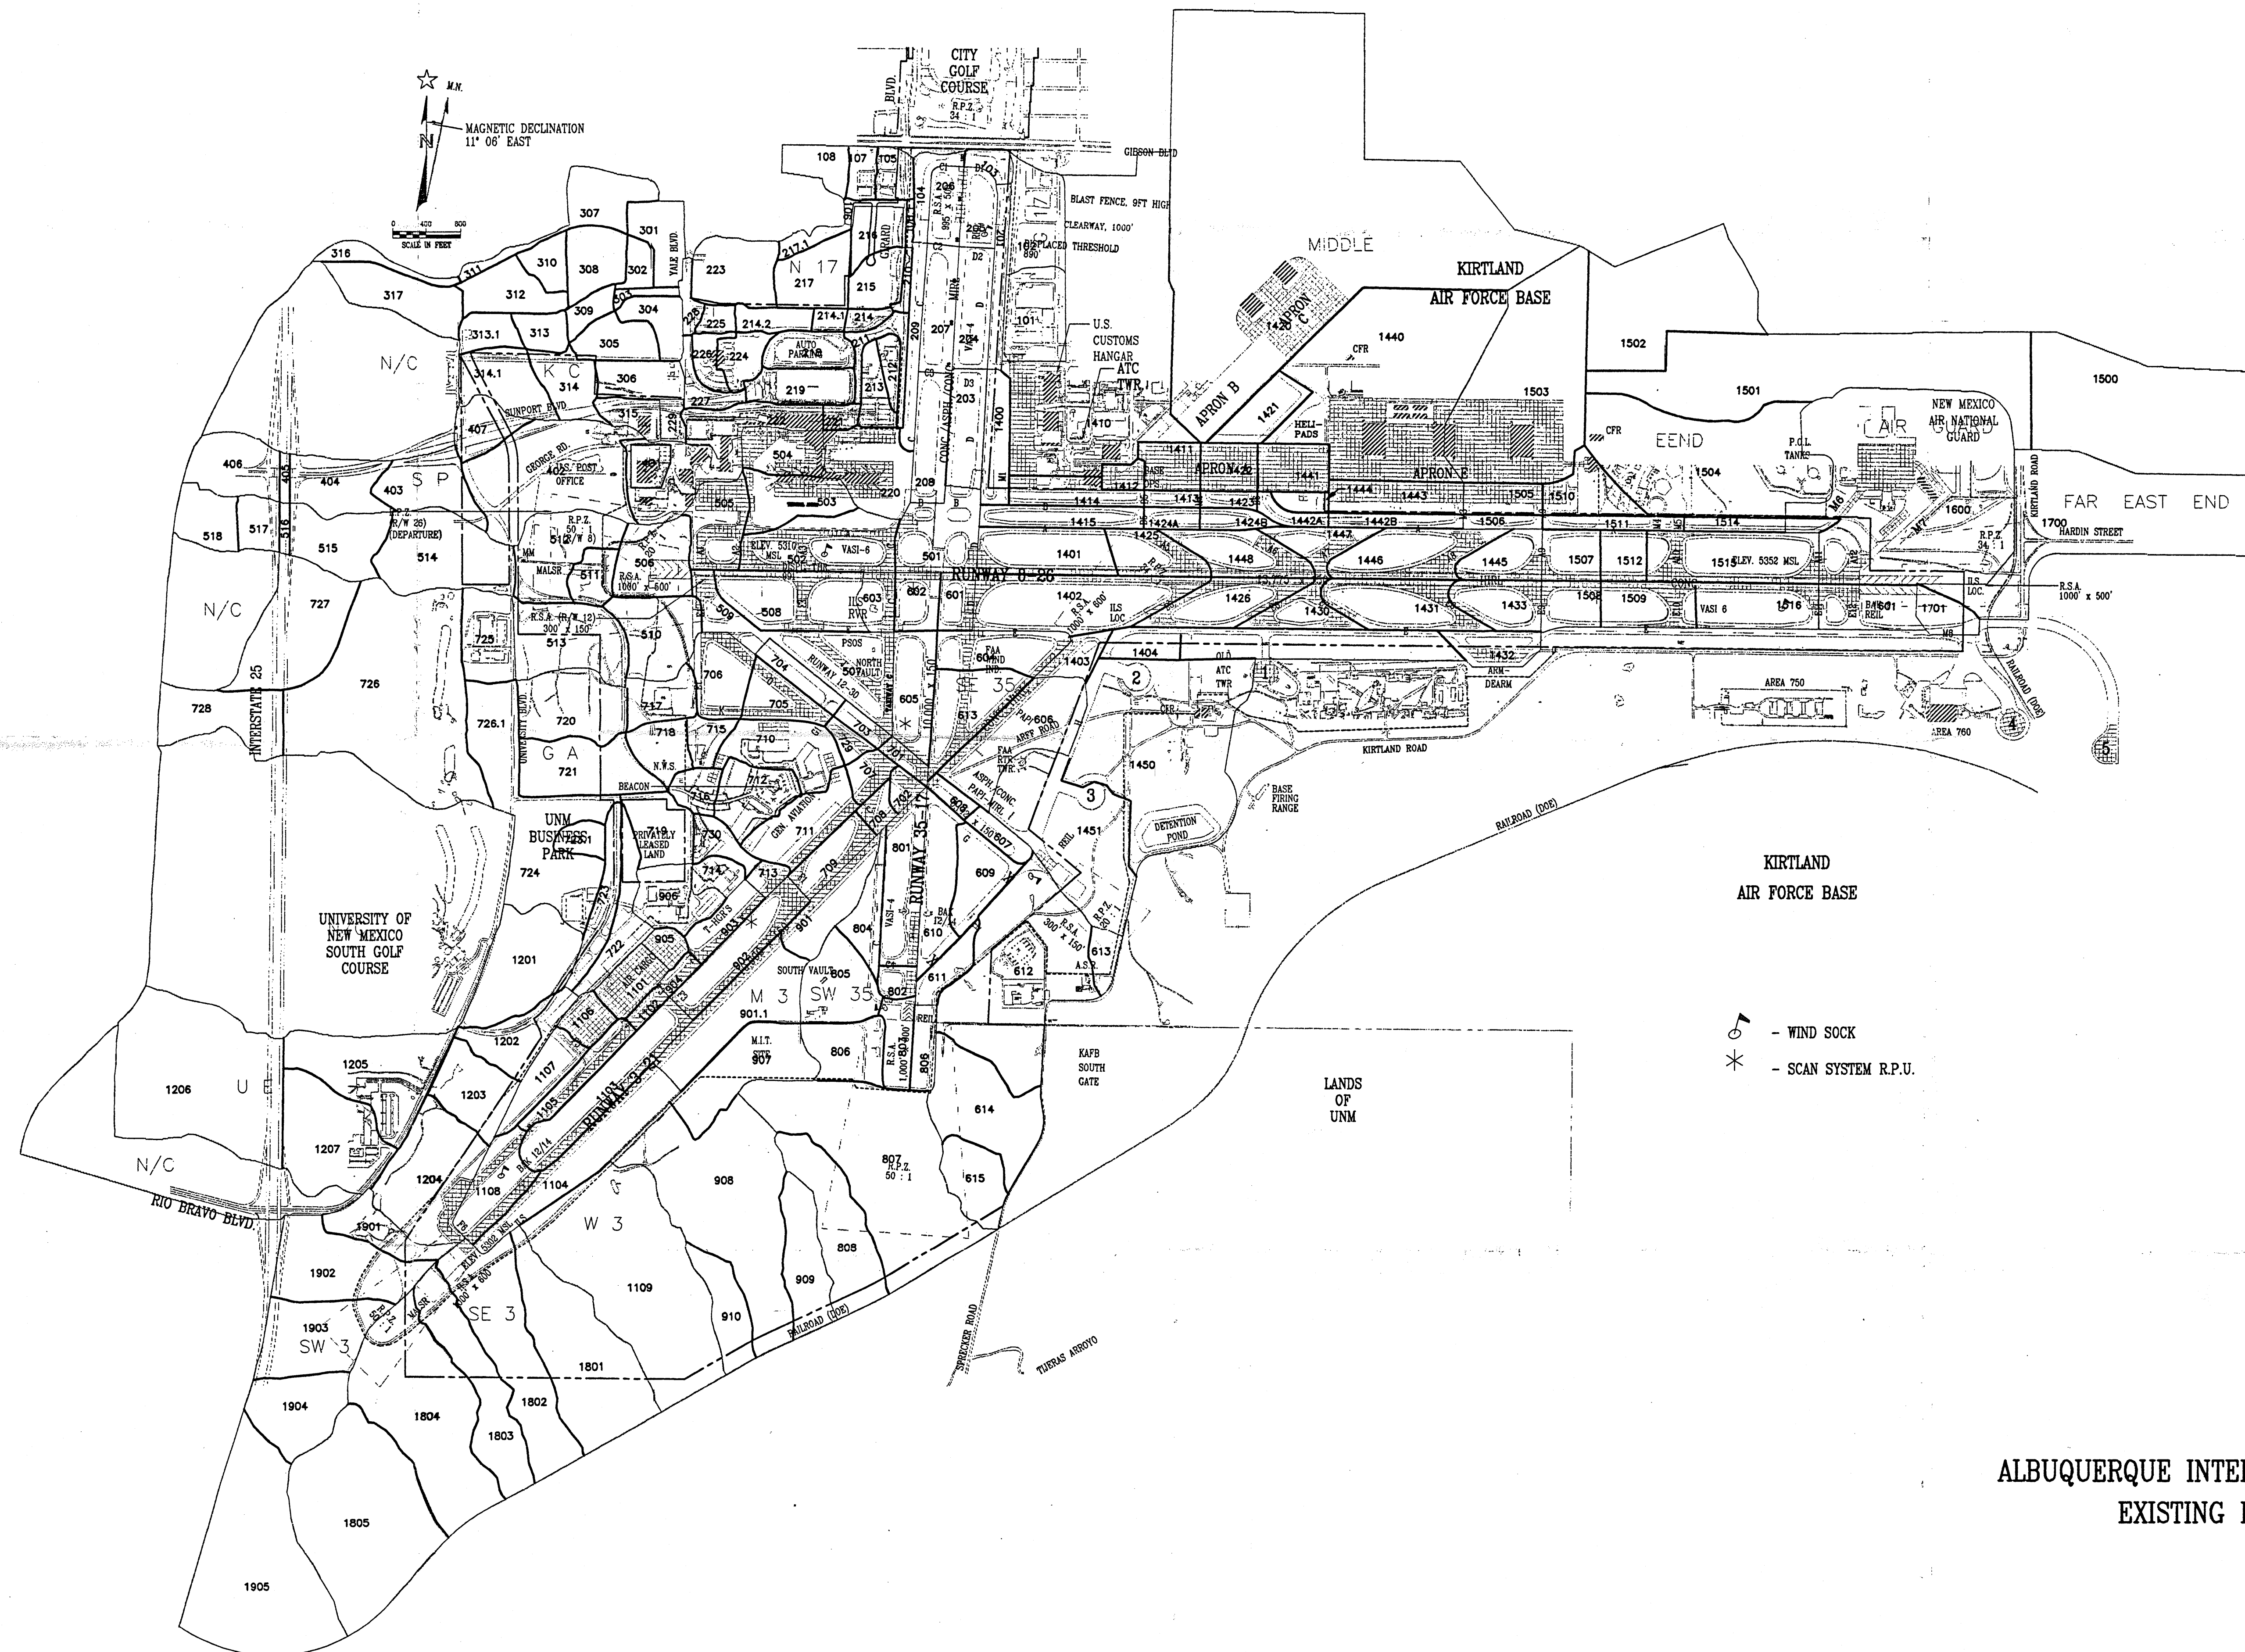

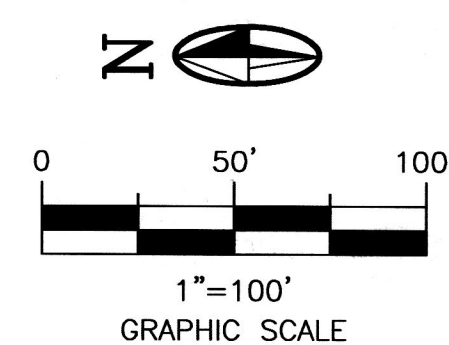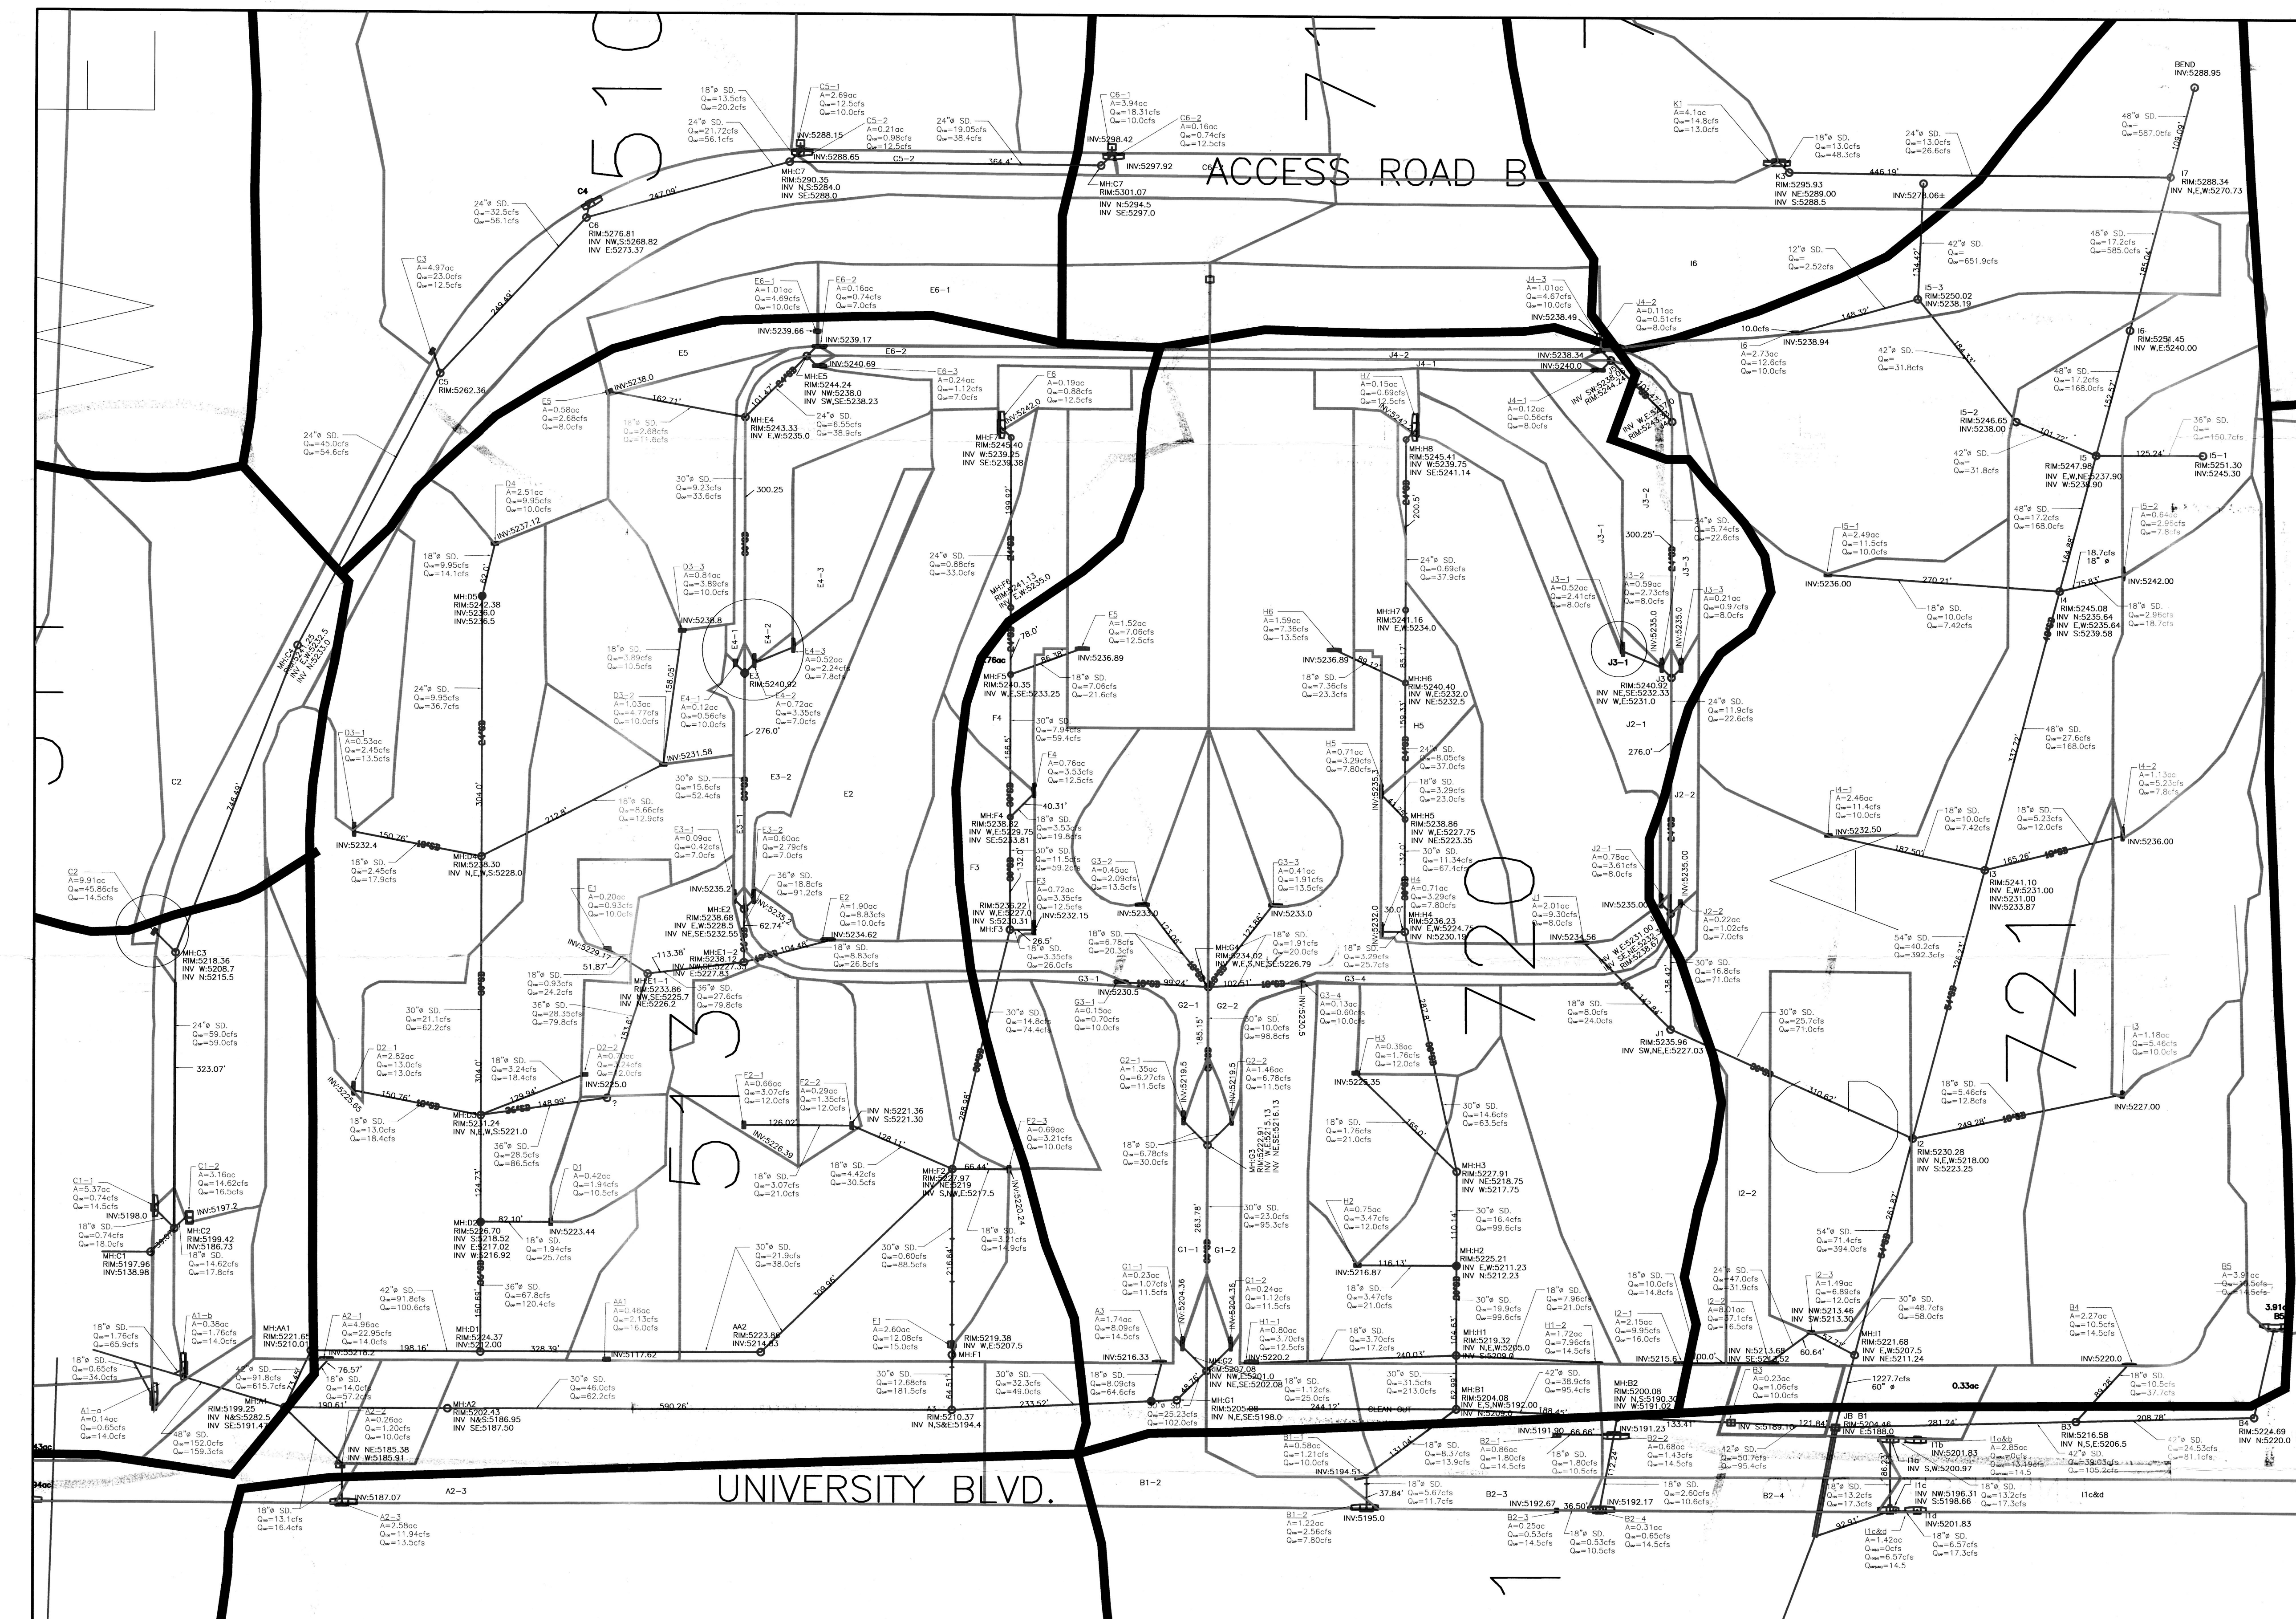

LEGEND

- PROPOSED S.D. MANHOLE
 □ PROPOSED TYPE "D" DROP INLET
 PROPOSED TYPE "A" DROP INLET
 STORM DRAINAGE MASTER PLAN WATERSHED BOUNDARIES
 — SUB BASIN BOUNDARY
 — PROPOSED STORM DRAIN SYSTEM

NOTE:
ALL DROP INLETS ARE TYPE
"A" OR TYPE "D" UNLESS
OTHERWISE NOTED ON THE
LAYOUT PLAN

[illegible]

MOLZEN-CORBIN 
& Associates
ENGINEERS/ARCHITECTS/DIAGNOSTICS

BPLW
Architects & Engineers, Inc.
6200 Uptown Blvd. NE
Suite 400
Albuquerque, New Mexico 87110
(505) 881-2759
Designing to Stay

CITY OF ALBUQUERQUE PUBLIC WORKS DEPARTMENT ENGINEERING DEVELOPMENT GROUP			
TITLE: Remote Car Rental Facility Revised Composite Drainage Plan (Plate 9)			
Design Review Committee	City Engineer Approval	Lost Design Update	No./Day/Yr.
			No./Day/Yr.
			No./Day/Yr.
			No./Day/Yr.
			No./Day/Yr.
			No./Day/Yr.
City Project No.	Zone Map No.	Sheet	Of
		XX	XX

TITLE: Remote Car Rental Facility
Revised Composite Drainage Plan (Plate 9)

Design Review Committee	City Engineer Approval	Last Design Update	Mo./Day/Yr.	Mo./Day/Yr.
City Project No.	Zone Map No.	Sheet	Of	
		XX	XX	