


FOR CONTINUATION SEE SHEET 5 & 6

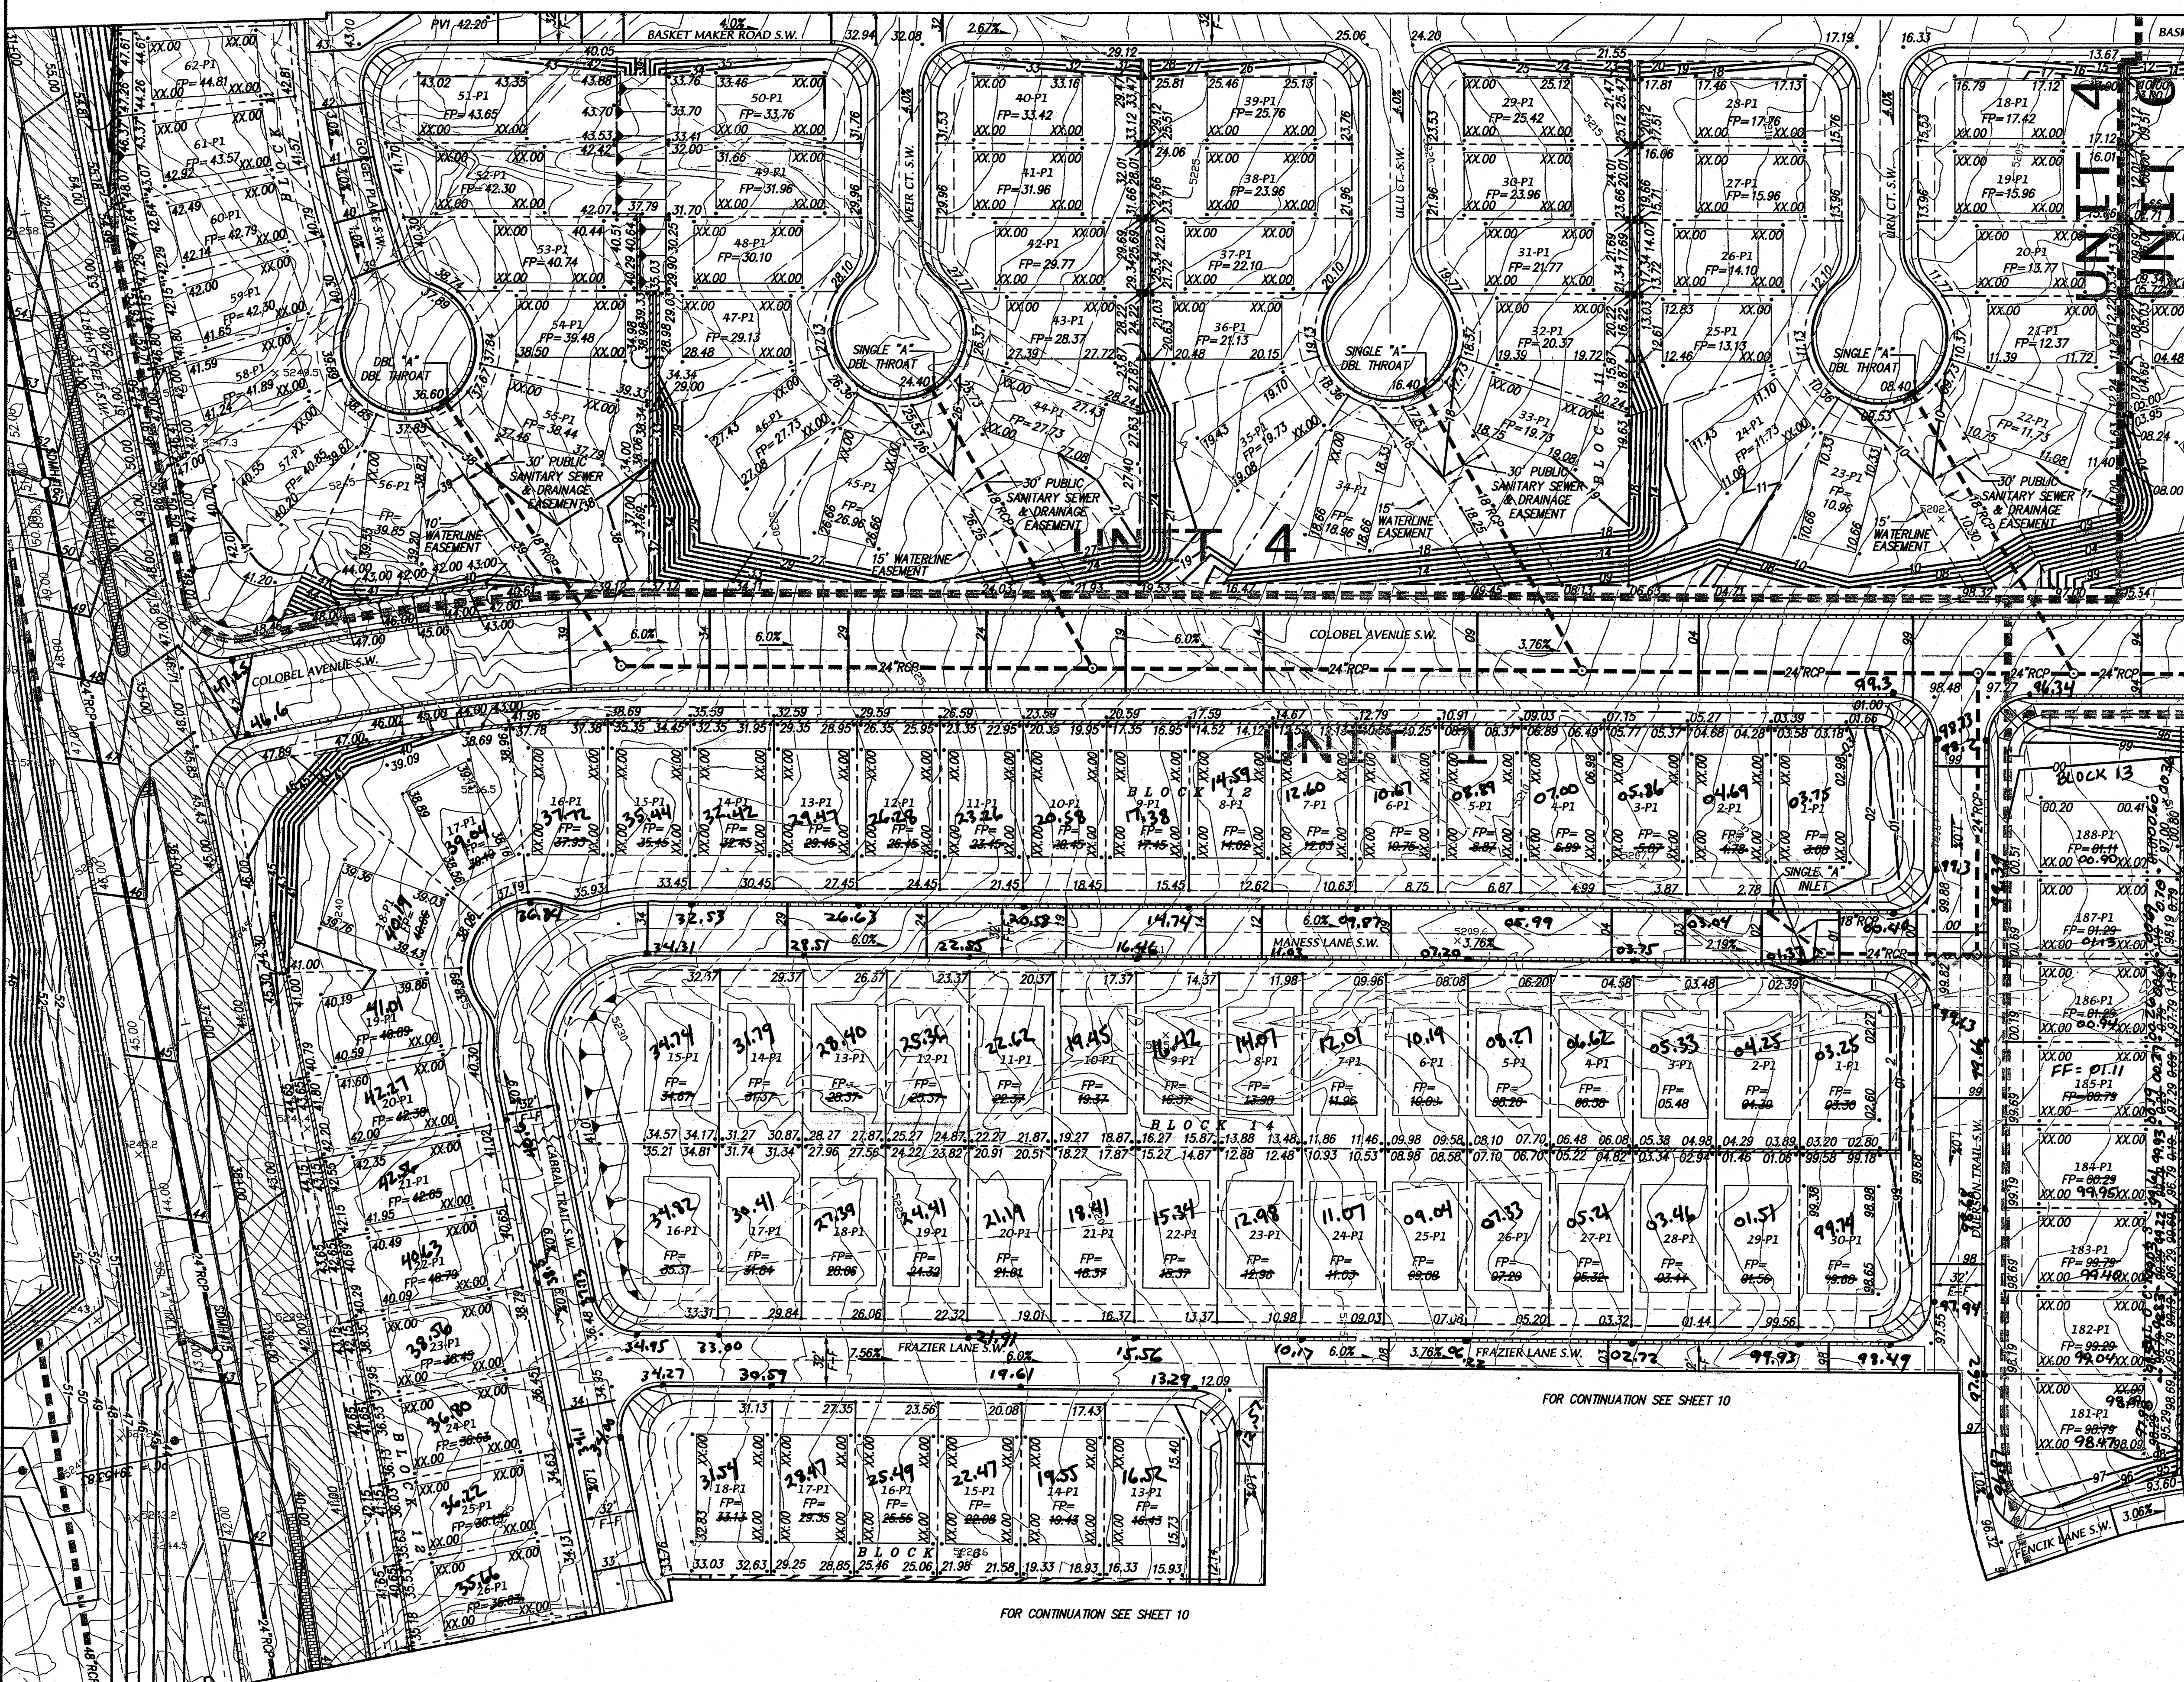

FOR CONTINUATION SEE SHEET 10


FOR CONTINUATION SEE SHEET 10

DRAINAGE CERTIFICATION

I, GREGORY J. KRENK, NMPE 11929, OF THE FIRM MARK GOODWIN & ASSOCIATES, P.A. HEREBY CERTIFY THAT THIS PROJECT HAS BEEN GRADED AND WILL DRAIN IN SUBSTANTIAL COMPLIANCE WITH AND IN ACCORDANCE WITH THE DESIGN INTENT OF THE APPROVED PLAN DATED 4/27/2008. THE RECORD INFORMATION EDITED ON THE ORIGINAL DESIGN DOCUMENT HAS BEEN OBTAINED BY WILL PLOTNER, JR., NMPS 14271, OF THE FIRM CARTESIAN SURVEYS. I FURTHER CERTIFY THAT I HAVE PERSONALLY VISITED THE PROJECT SITE ON 10/11/2008, AND HAVE DETERMINED BY VISUAL INSPECTION THAT THE SURVEY DATA PROVIDED IS REPRESENTATIVE OF ACTUAL SITE CONDITIONS AND IS TRUE AND CORRECT TO THE BEST OF MY KNOWLEDGE AND BELIEF. THIS CERTIFICATION IS SUBMITTED IN SUPPORT OF A REQUEST FOR GRADING CERTIFICATION APPROVAL.

THE RECORD INFORMATION PRESENTED HEREON IS NOT NECESSARILY COMPLETE AND INTENDED ONLY TO VERIFY SUBSTANTIAL COMPLIANCE OF THE GRADING AND DRAINAGE ASPECTS OF THIS PROJECT. THOSE RELYING ON THIS RECORD DOCUMENT ARE ADVISED TO OBTAIN INDEPENDENT VERIFICATION OF THE ACCURACY BEFORE USING IT FOR ANY OTHER PURPOSE.

GREGORY J. KRENK NMPE 11929 DATE 9-22-09

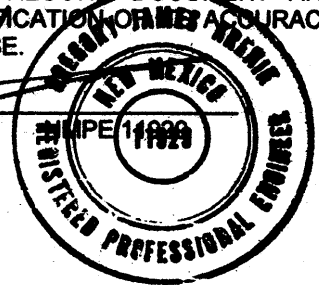

AS BUILT INFORMATION	
CONTRACTOR	DATE
WORK	DATE
STATION	DATE
FIELD	DATE
REVISIONS	DATE
DRAWINGS	DATE
CORRECTIONS	DATE
RECORDED BY	DATE

BENCH MARKS	
STATION	DATE
TO REACH STATION FROM INT. OF CORRS AND DENNIS CHAVEZ BLVD	DATE
(FORMERLY RIO BRAVO), GO. S. ON CORRS BLVD. 0.82 MI. TO THE	DATE
STATION WHICH IS ON AN EARTHEN BERM 0.82 MI. WEST OF THE	DATE
CENTERLINE OF CORRS BLVD. THE STATION IS A STANDARD ACS	DATE
3 1/4" ALUMINUM CAP RIVETED TO A PIPE 0.25' ABOVE THE GROUND	DATE
AND IS STAMPED "3-P10, 1998"	DATE
X=807335.56, Y=462437.48 (NAD 27), ELEV=4935.735 (SD 29)	DATE

SURVEY INFORMATION	
FIELD NOTES	DATE
NO.	DATE
BY	DATE

ENGINEER'S SEAL	
DATE	DATE
BY	DATE

REVISIONS	
NO.	DATE
DATE	DATE
DATE	DATE
DATE	DATE

LEGEND

01.51 AS BUILT FINISH PAD

04.56 AS BUILT FLOWLINE ELEV

02.72

02.72


02.72

02.72

02.72

02.72

02.72

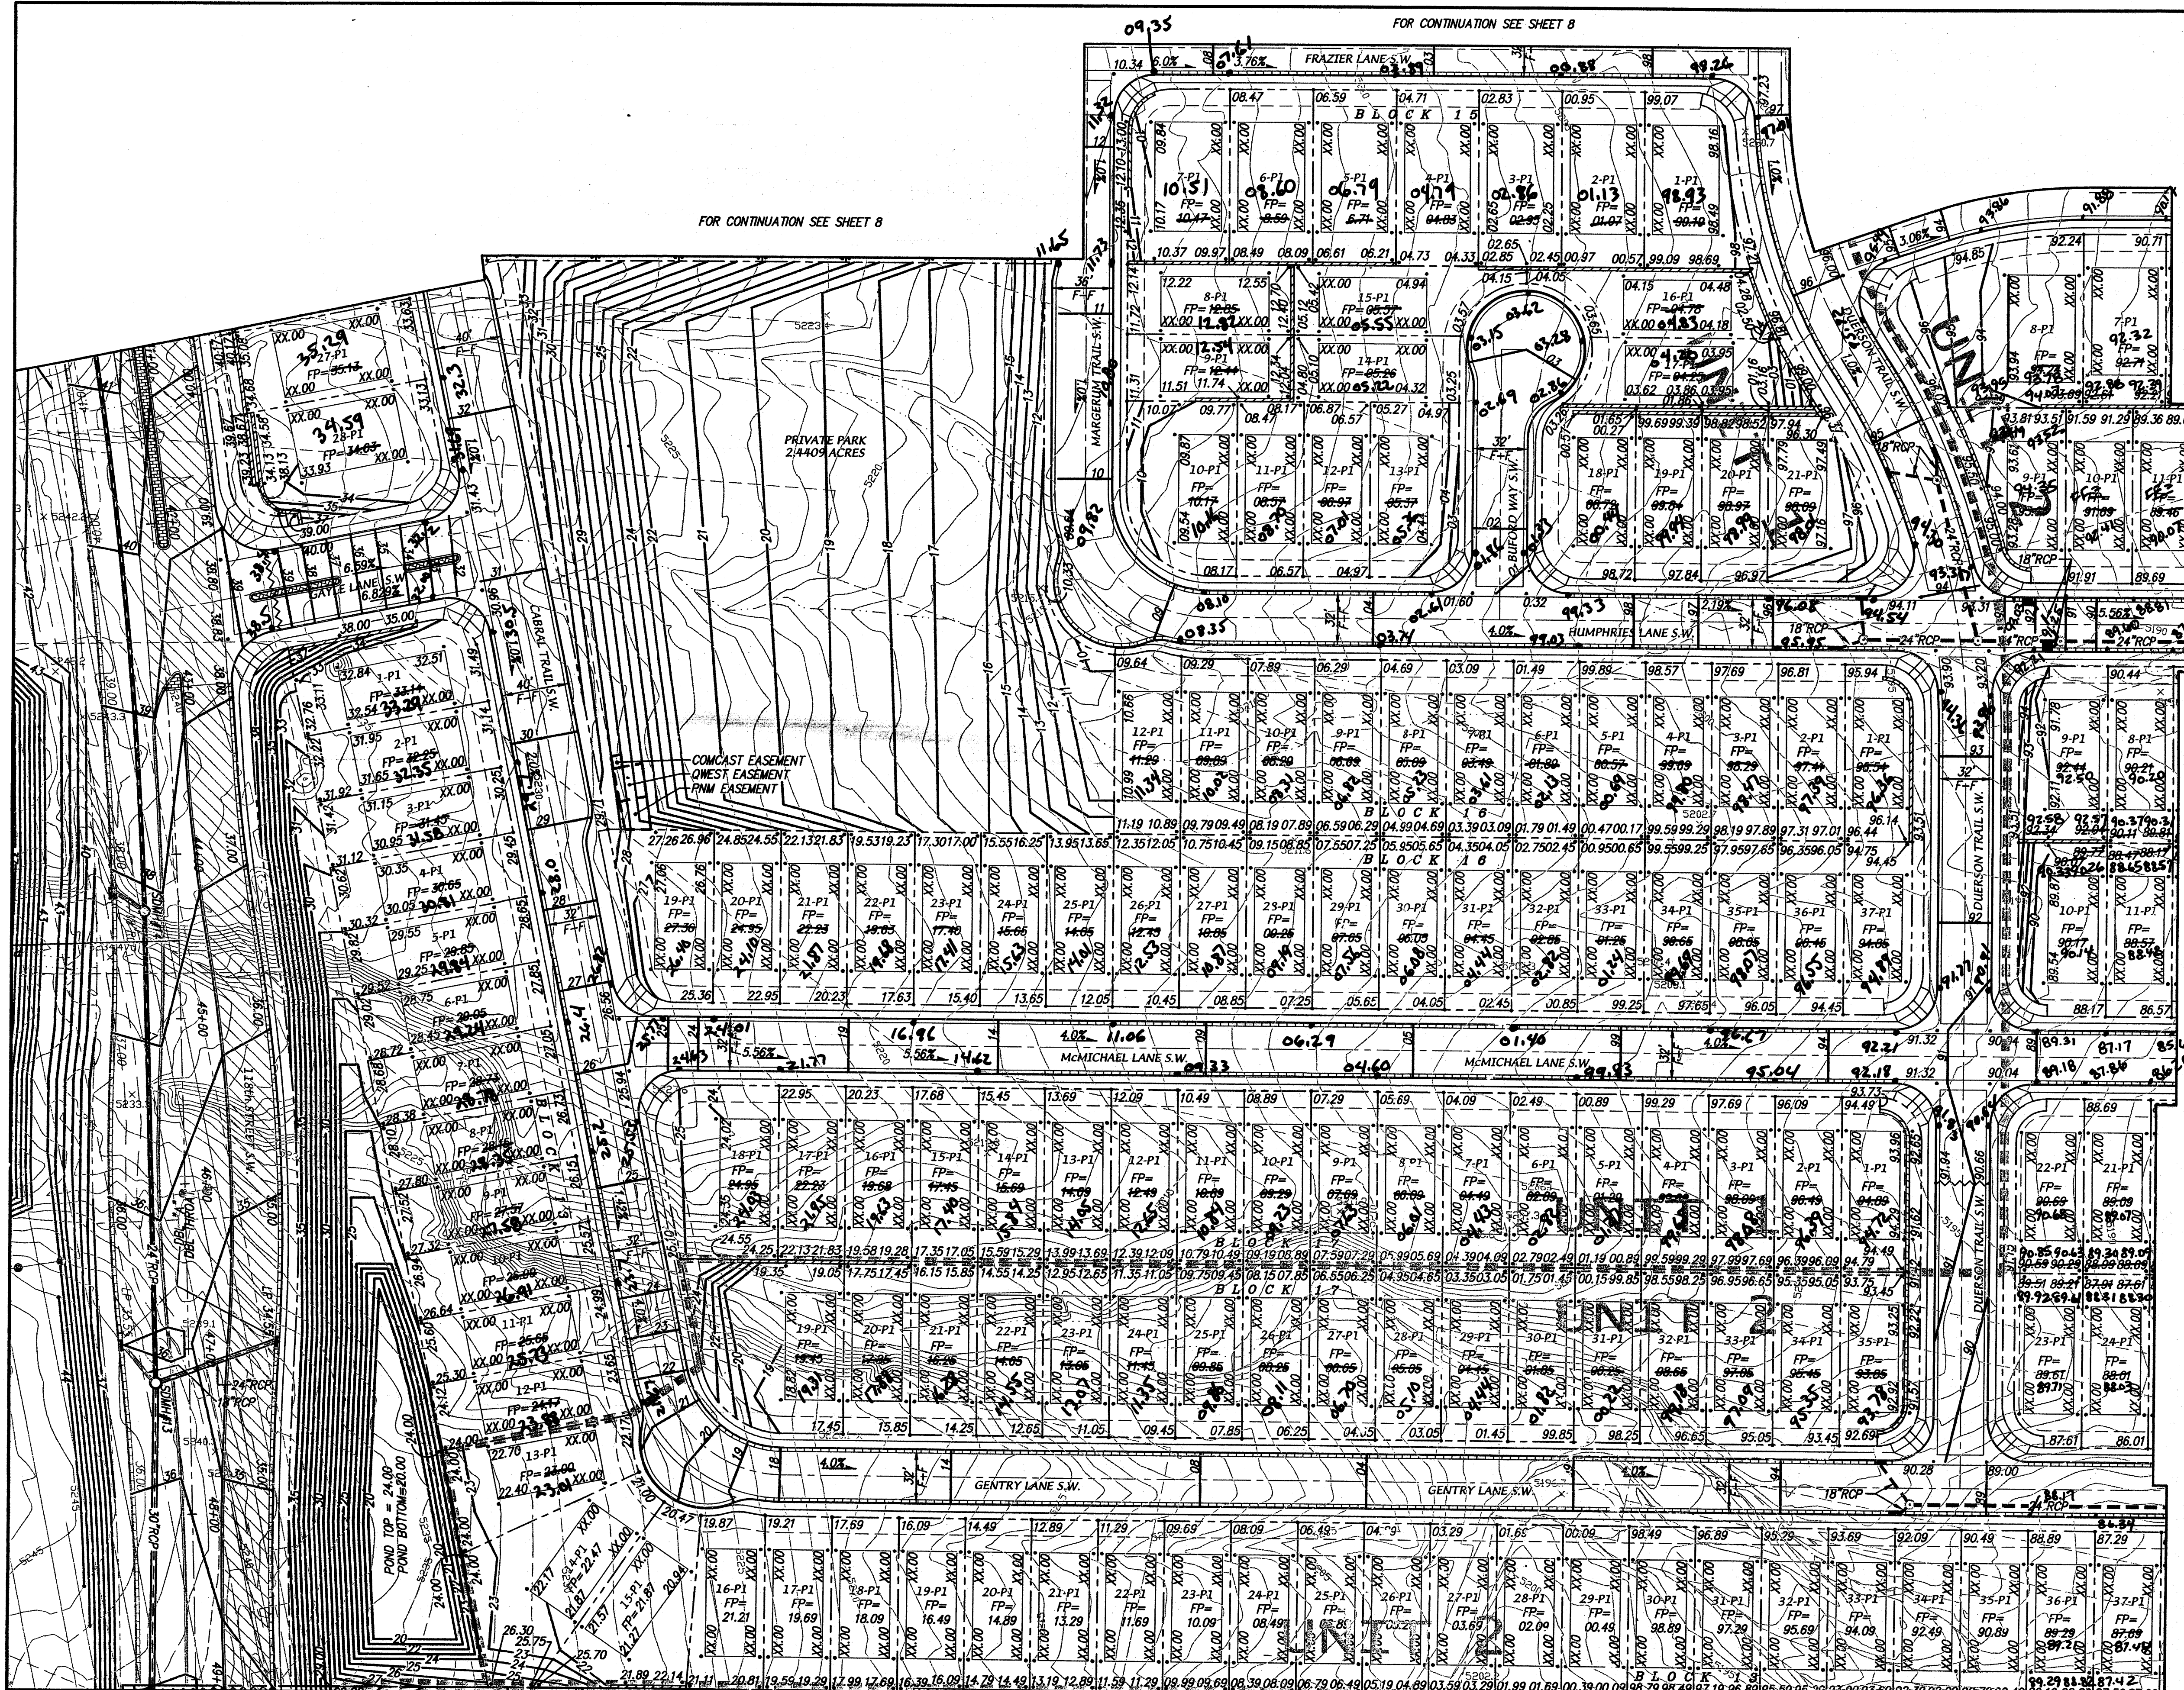

FOR CONTINUATION SEE SHEET 8

FOR CONTINUATION SEE SHEET 8

FOR CONTINUATION SEE SHEET 11

FOR CONTINUATION SEE SHEET 12

DRAINAGE CERTIFICATION

I, GREGORY J. KRENK, NMPE 11928, OF THE FIRM MARK GOODWIN & ASSOCIATES, P.A. HEREBY CERTIFY THAT THIS PROJECT HAS BEEN GRADED AND WILL DRAIN IN SUBSTANTIAL COMPLIANCE WITH AND IN ACCORDANCE WITH THE DESIGN INTENT OF THE APPROVED PLAN DATED 4/27/2005. THE RECORD INFORMATION EDITED ONTO THE ORIGINAL DESIGN DOCUMENT HAS BEEN OBTAINED BY WILL PLOTNER, JR., NMPS 14271, OF THE FIRM CARTESIAN SURVEYS. I FURTHER CERTIFY THAT I HAVE PERSONALLY VISITED THE PROJECT SITE ON 10/11/2005, AND HAVE DETERMINED BY VISUAL INSPECTION THAT THE SURVEY DATA PROVIDED IS REPRESENTATIVE OF ACTUAL SITE CONDITIONS AND IS TRUE AND CORRECT TO THE BEST OF MY KNOWLEDGE AND BELIEF. THIS CERTIFICATION IS SUBMITTED IN SUPPORT OF A REQUEST FOR GRADING CERTIFICATION APPROVAL.

THE RECORD INFORMATION PRESENTED HEREON IS NOT NECESSARILY COMPLETE AND INTENDED ONLY TO VERIFY SUBSTANTIAL COMPLIANCE OF THE GRADING AND DRAINAGE ASPECTS OF THIS PROJECT. THOSE RELYING ON THIS RECORD DOCUMENT ARE ADVISED TO OBTAIN INDEPENDENT VERIFICATION OF THE ACCURACY BEFORE USING IT FOR ANY OTHER PURPOSE.

GREGORY J. KRENK
REGISTERED PROFESSIONAL ENGINEER
9-22-09
DATE

LEGEND

01.51 AS BUILT FINISH PAD

01.56 AS BUILT FLOWLINE ELEV

02.72

50' 25' 0 50' 100'
SCALE: 1" = 50'

ENGINEER'S SEAL

MARK GOODWIN & ASSOCIATES, P.A.
CONSULTING ENGINEERS
P.O. BOX 90606
ALBUQUERQUE, NEW MEXICO 87199
(505) 828-2200, FAX (505) 797-9539

CITY OF ALBUQUERQUE
PUBLIC WORKS DEPARTMENT

TITLE: **ASBUILTS FOR UNIT 1 ONLY**
ANDERSON HEIGHTS
GRADING AND DRAINAGE PLAN

DESIGN REVIEW COMMITTEE CITY ENGINEER APPROVAL

CITY PROJECT NO. **753981** ZONE MAP NO. **N-8/P-8** SHEET **10** OF **83**

DESIGNED BY **GJK** DATE **02/04**
DRAWN BY **MJR** DATE **02/04**
CHECKED BY **DMG** DATE **02/04**

RECEIVED
SEP 23 2009
HYDROLOGY SECTION

AS BUILT INFORMATION

CONTRACTOR	DATE
STATION 3+100 TO REACH STATION FROM INT. OF COOPS AND DENNIS CHAVEZ BLVD.	
INSPECTOR	DATE
WORK INSPECTED BY	
ACCEPTANCE BY	
DATE	DATE
STATION WHICH IS ON AN EARTHEN BERM 162.2' WEST OF THE CENTERLINE OF COOPS BLVD. THE STATION IS A STANDARD ACS	
3 1/4" ALUMINUM CAP RIVETED TO A PIPE 0.25' ABOVE THE GROUND	
AND IS STAMPED "3+100, 1998"	
NO.	

\\A03J08S1\A3080AH\grade n drain\3080GD-50-REVA-temp.dwg, 4/28/2005 11:53:07 AM, chris.
Designdwg 1050C by HP (temporary)5163.pcs