


PLAN	DATE	BY
SURVEYED		
PLOTTED		
CHECKED		
BY		
NO.		

MADE REPRODUCTION BY
MOORE & POLS ENGINEERING
2334 COMANCHE N.E., ALBUQUERQUE, N.M. 87106

PROFILE	DATE	BY
SURVEYED		
PLOTTED		
CHECKED		
BY		
NO.		

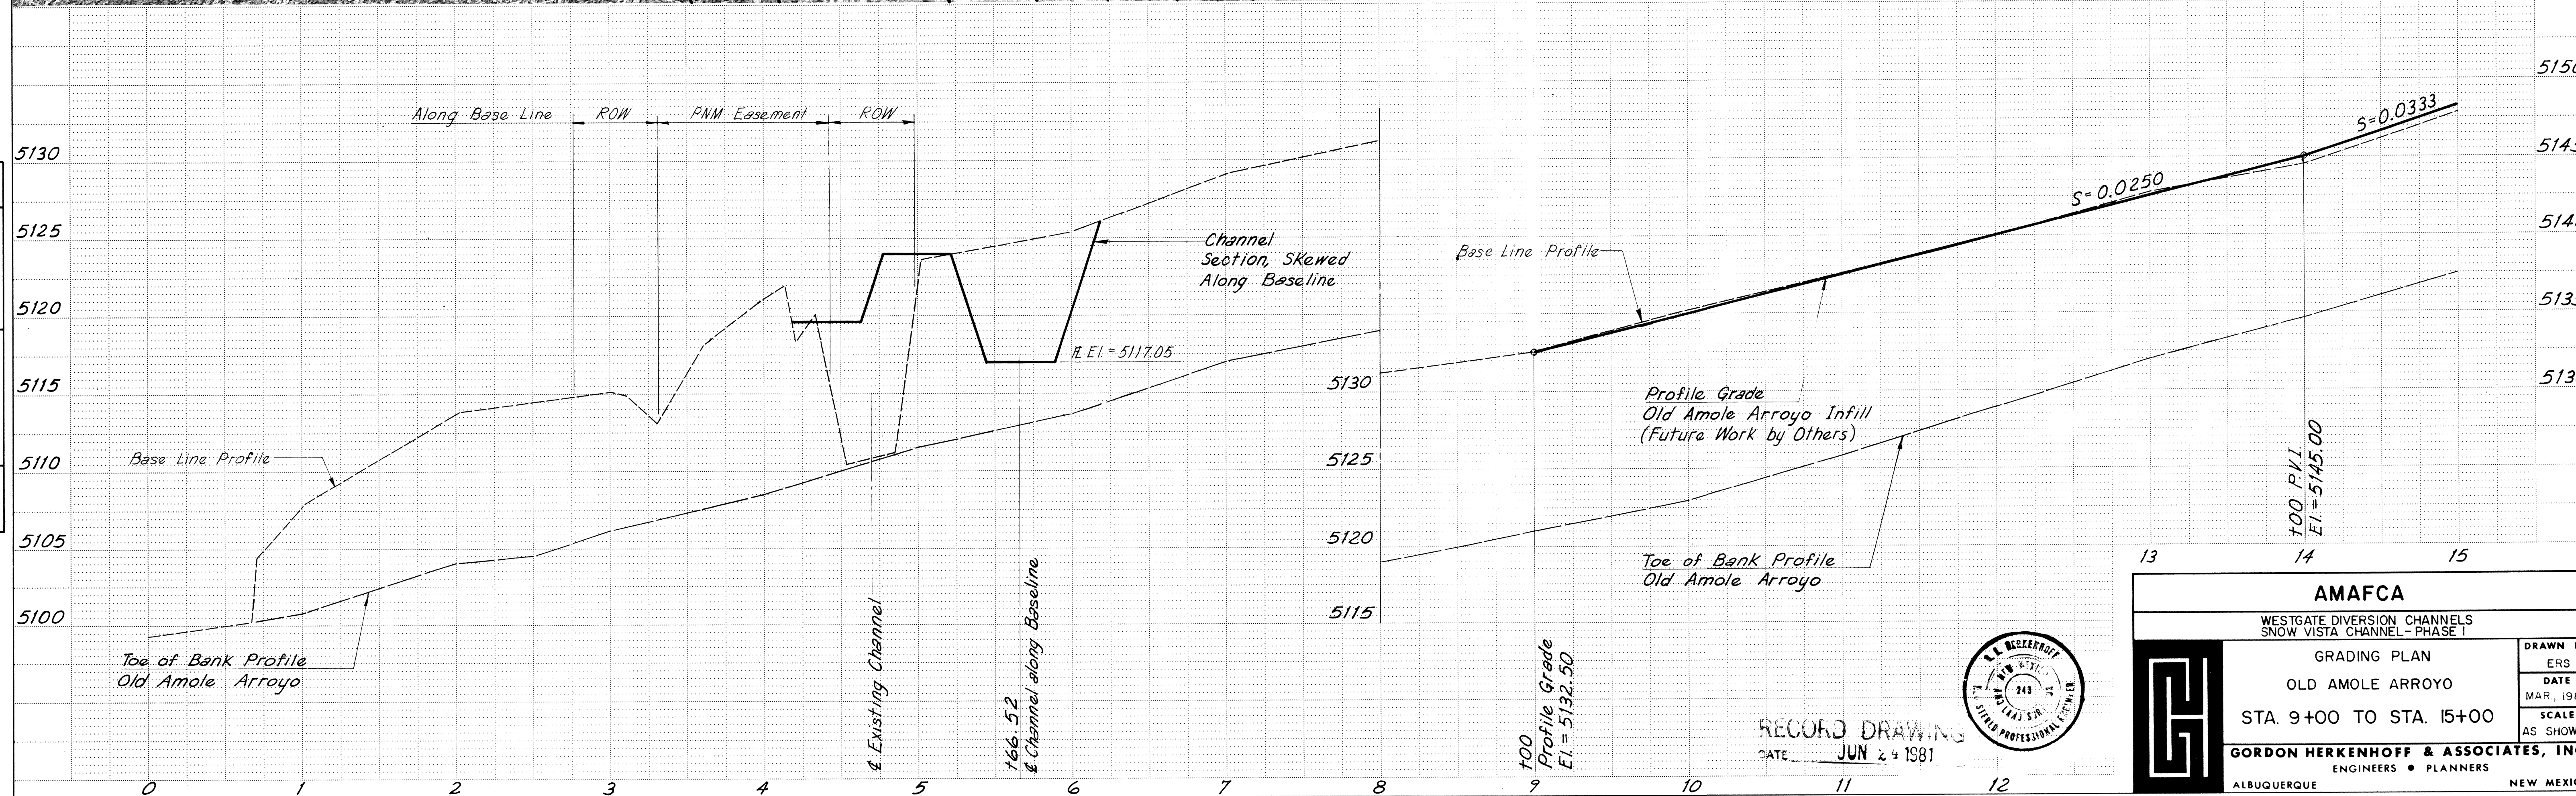

AMAFCA	
WESTGATE DIVERSION CHANNELS SNOW VISTA CHANNEL - PHASE I	
GRADING PLAN OLD AMOLE ARROYO STA. 9+00 TO STA. 15+00	DRAWN BY ERS DATE MAR, 1981 SCALE AS SHOWN
GORDON HERKENHOFF & ASSOCIATES, INC. ALBUQUERQUE ENGINEERS • PLANNERS NEW MEXICO	