
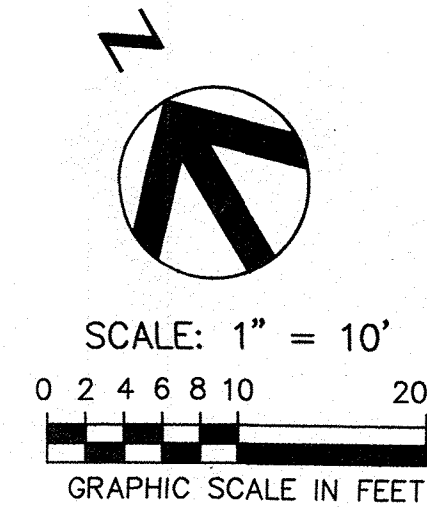


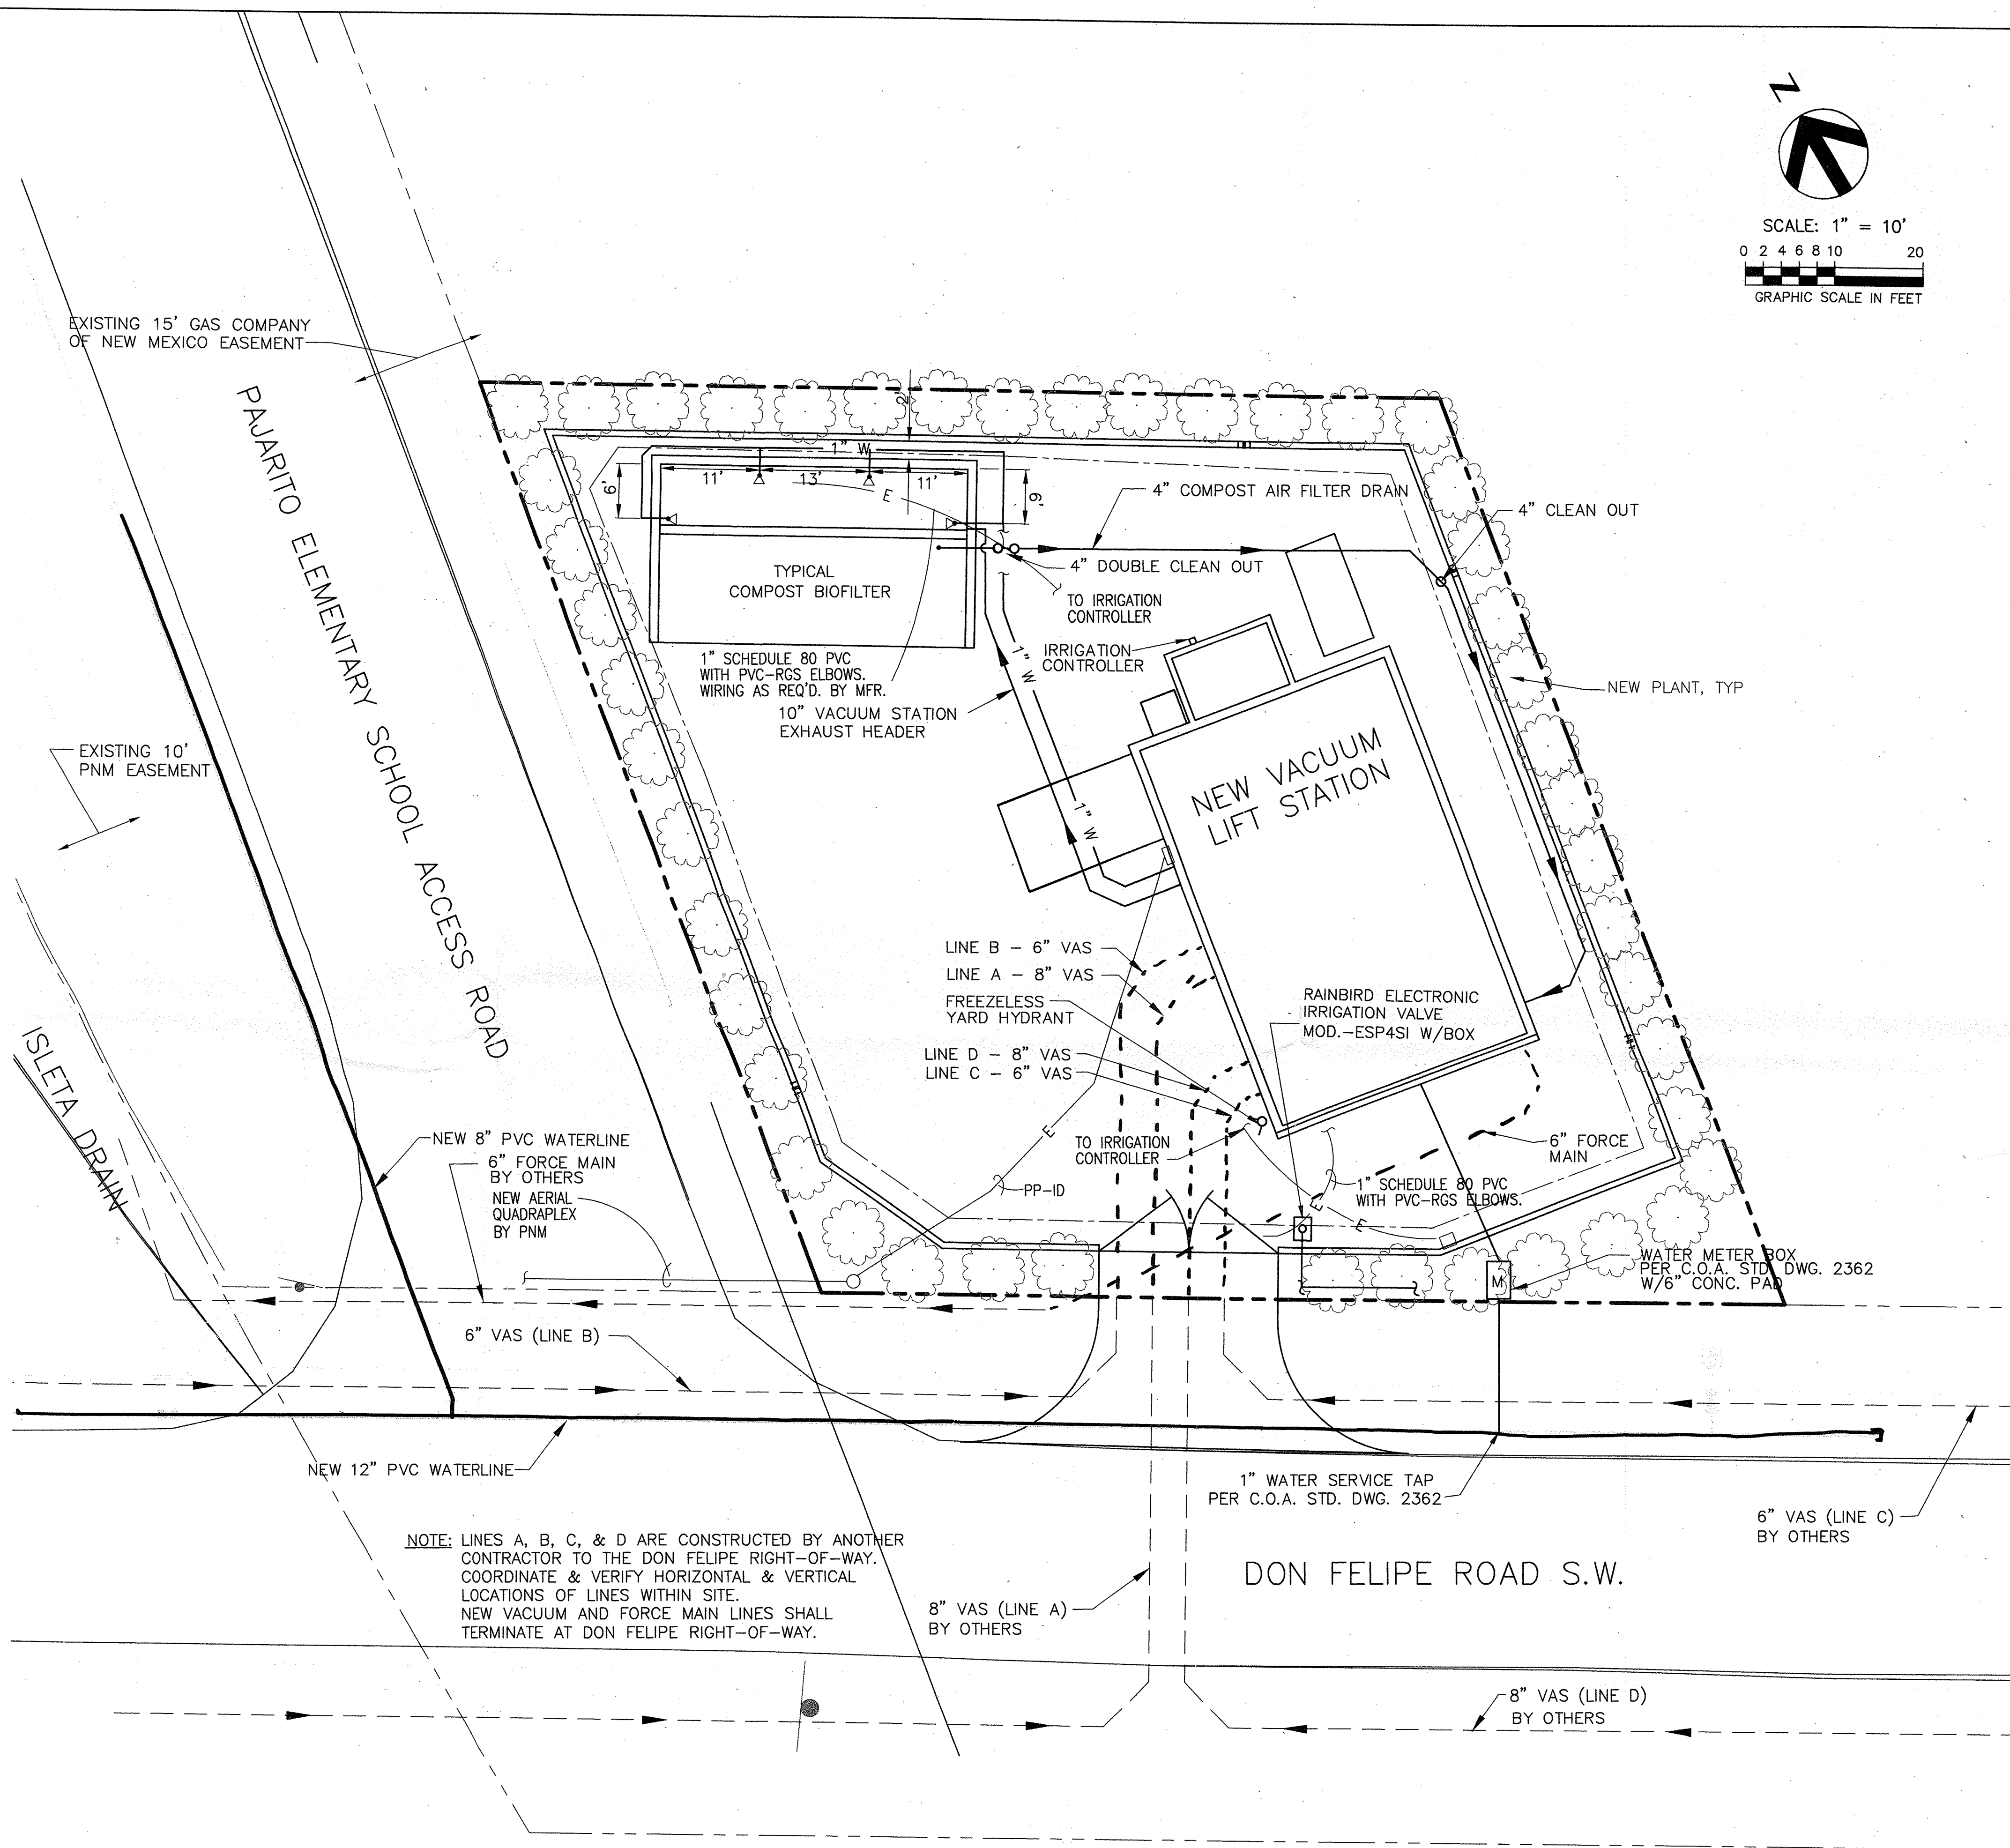

NOTES:

1. ALL UNDERGROUND UTILITIES SHOWN ON THIS PLAN ARE APPROXIMATE LOCATIONS. VERIFY LOCATION OF ALL UNDERGROUND UTILITIES BEFORE COMMENCING WORK.
2. VACUUM STATION & ASSOCIATED PIPING CONNECTING TO SEWER LINES CONSTRUCTED BY OTHERS AND ARE ASSUMED TO BE COMPLETE PRIOR TO CONSTRUCTION OF THIS PROJECT. PROTECT PLUGGED PIPES UNTIL FINAL CONNECTION IS MADE.
3. NOT USED
4. NOT USED
5. TRENCHING, BACKFILL, COMPACTION, AND PAVEMENT REPLACEMENT ARE TO BE PER CITY OF ALBUQUERQUE STANDARD DETAILS AND SPECIFICATIONS.

HDR


HDR Engineering, Inc.

BERNALILLO COUNTY
PUBLIC WORKS DIVISION


TITLE: PAJARITO AREA VACUUM STATION
UTILITY PLAN

Design Review Committee	City Engineer Approval	Last Design Update	Mc/By/yr	Mc/By/yr
PROJECT NO.	TS - 01 - 13 COA - 647291	MAP NO. Q-10, R-10	SHEET OF	
			C-02 2	


SURVEY INFORMATION		ENGINEER'S SEAL		REVISIONS		AS BUILT INFORMATION	
FIELD NOTES				DESIGN			
NO.	BY	DATE	REMARKS	NO.	DATE	CONTRACTOR	DATE
						ACS Aluminum Cap, "2R-10", Don Felipe Road SW	
						NM (HPGN) Central Zone, NAD83 (Us.ft.)	
						N= 1 454 487.97, E= 1 502 103.18	
						(Converted from NAD27 using Corpcon V.5.11.05)	
						Elevation= 4918.05 NAVD88 (Us.Ft.)	
						[4918.05 (NAVD88) - 2.61 = 4915.44 (NGVD29)]	
						RECORDED BY	DATE
						NO.	

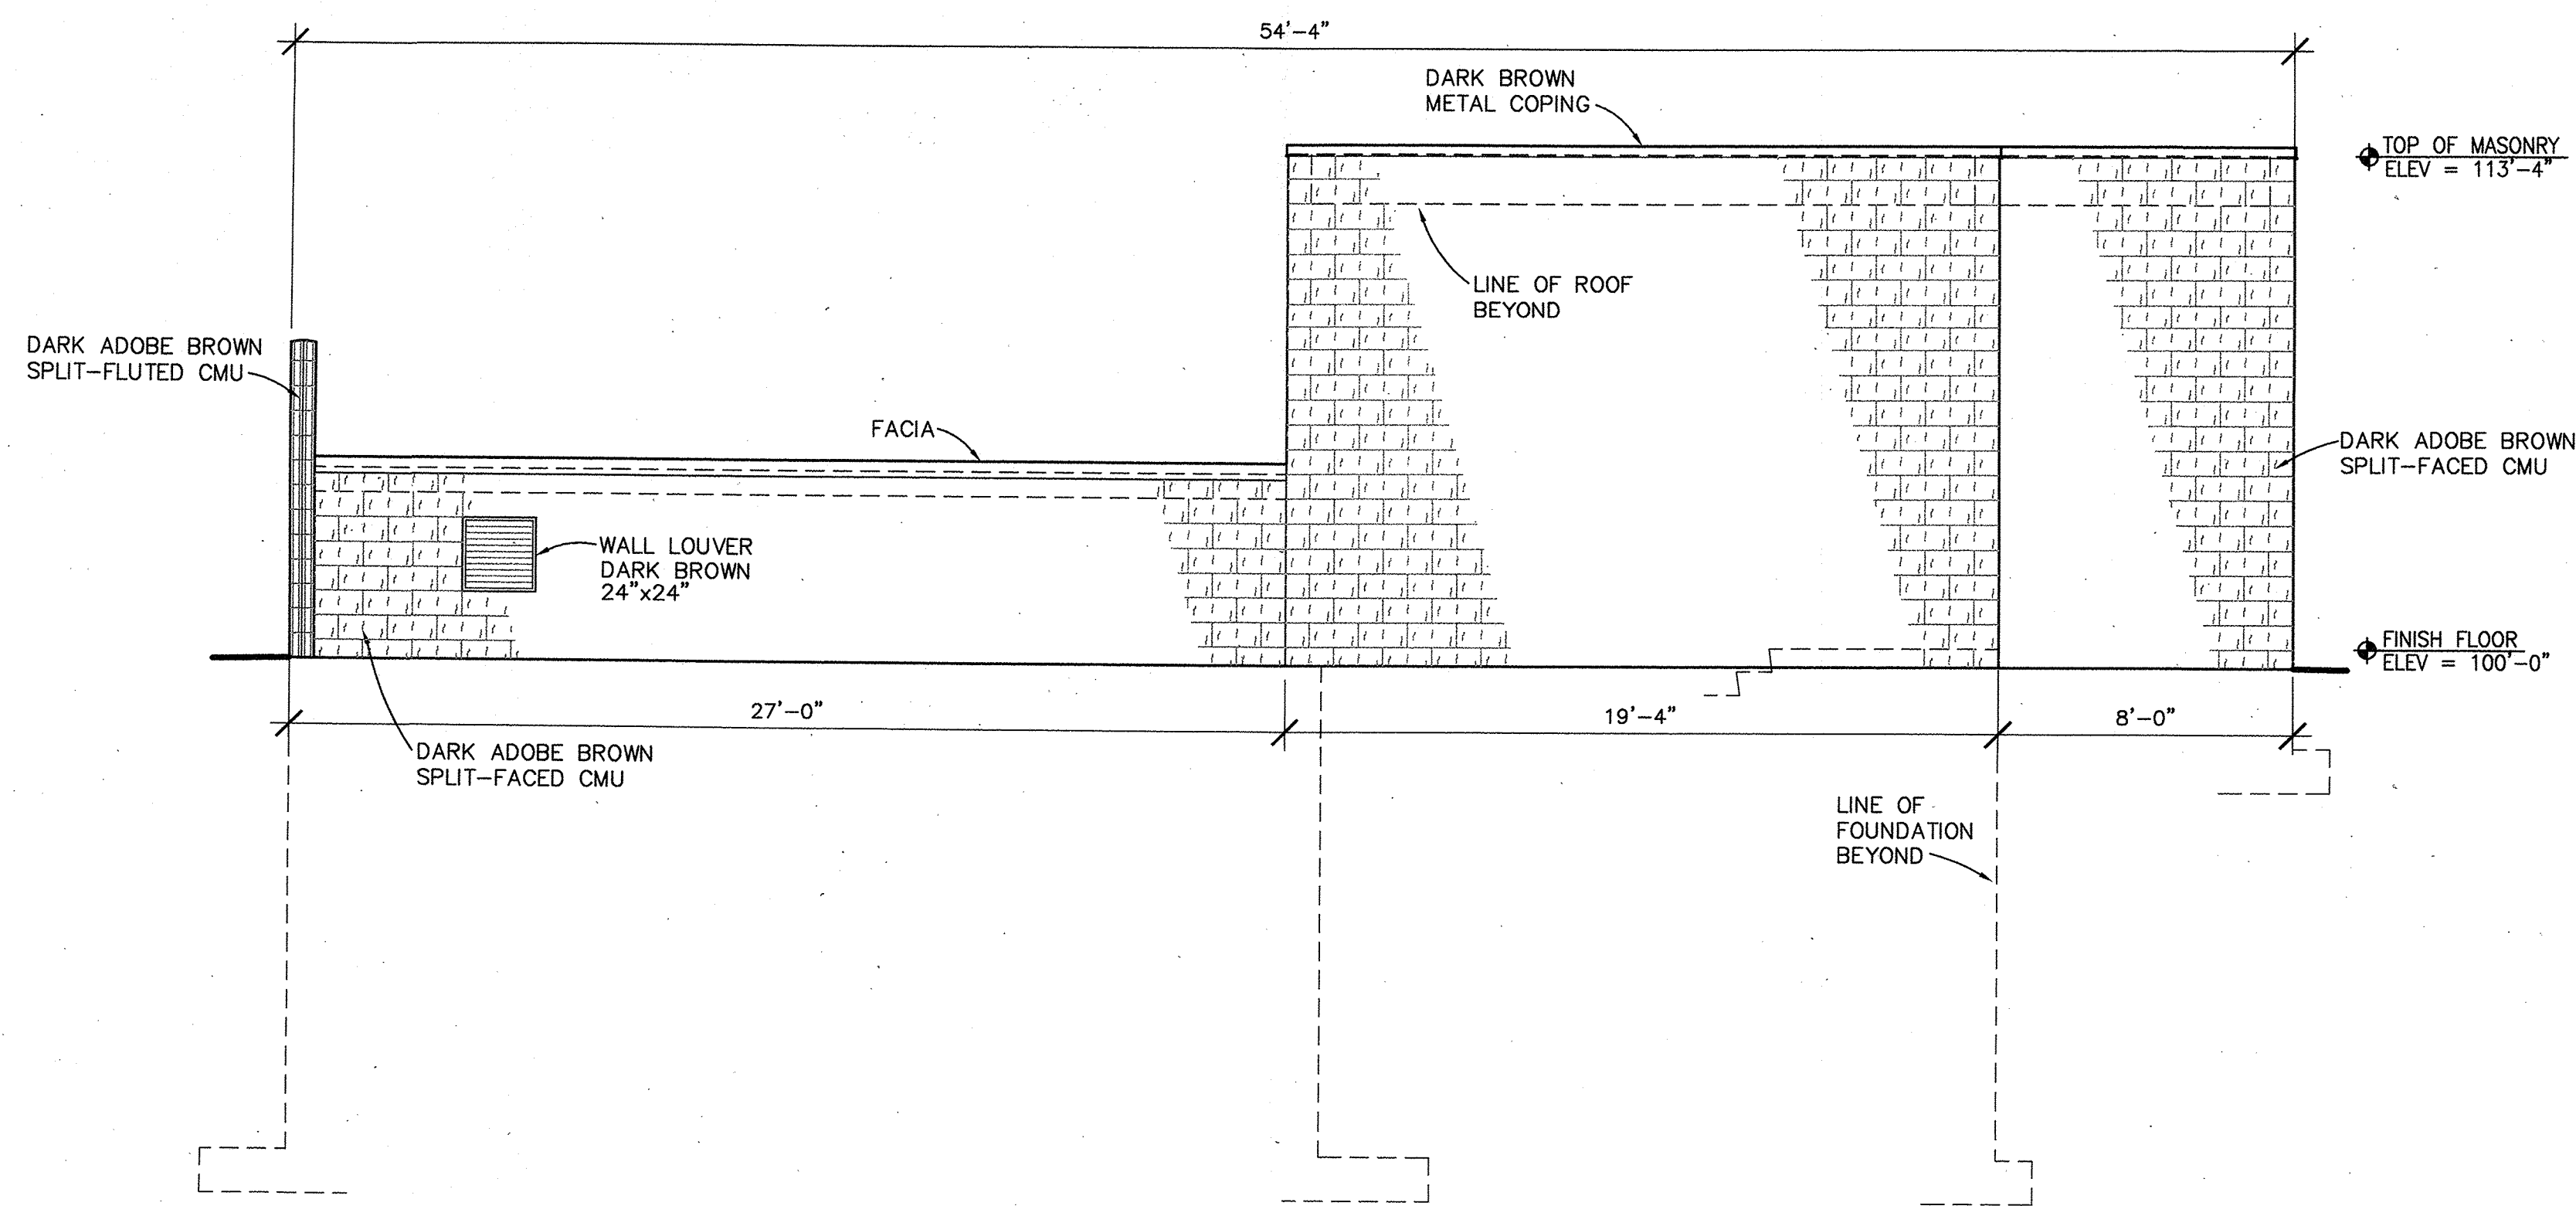

EAST ELEVATION
1/4"=1'-0"

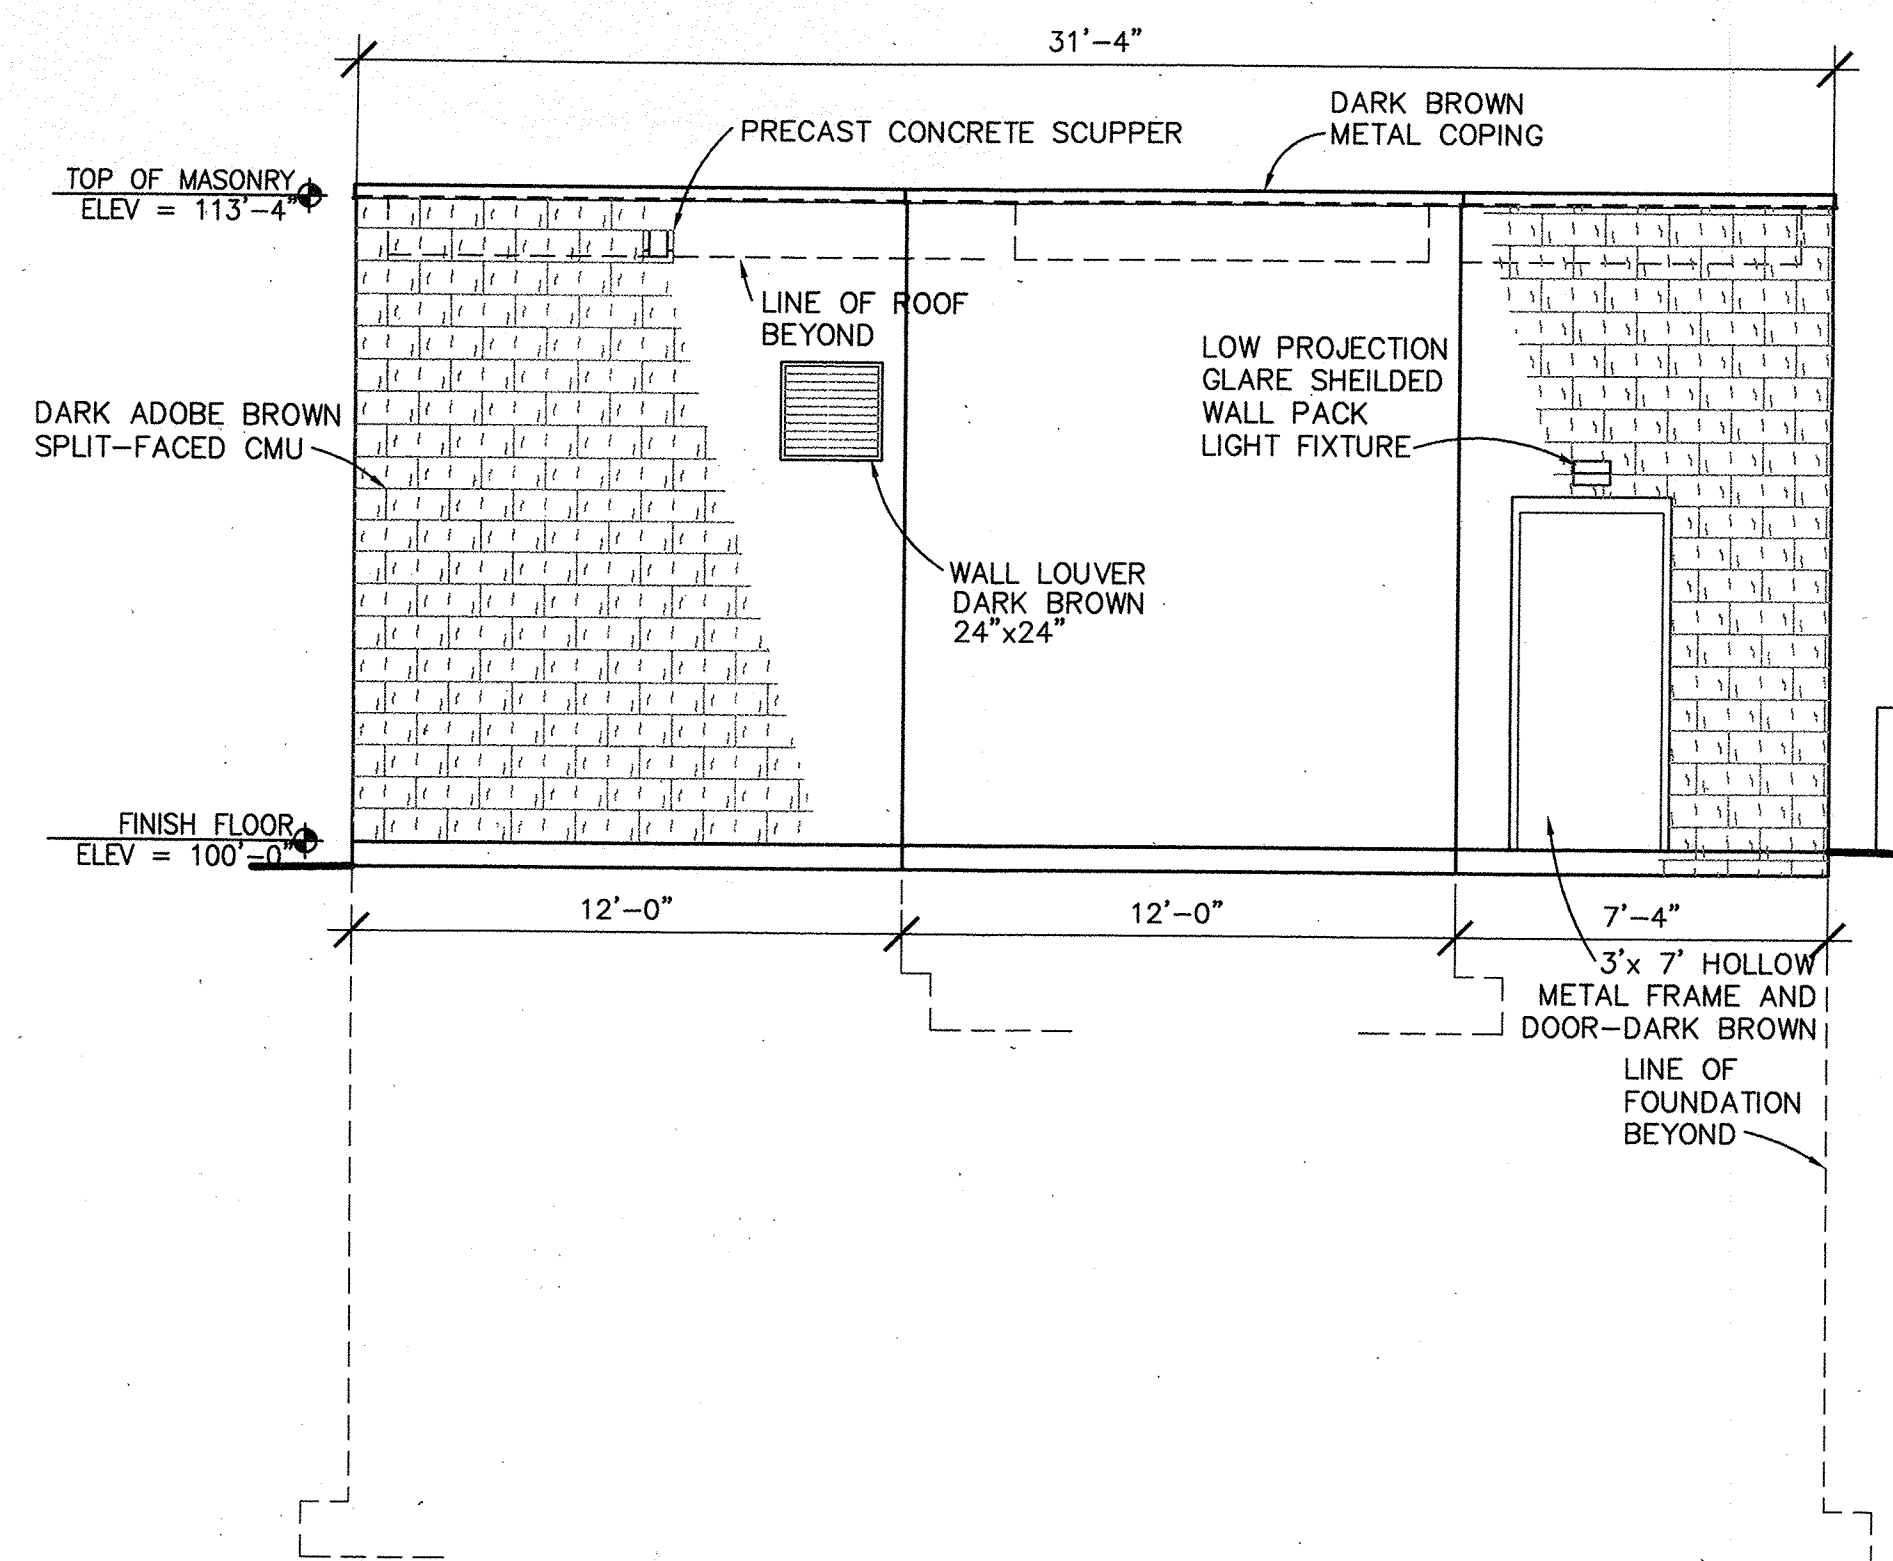


NORTH ELEVATION
1/4"=1'-0"

 


ARCHITECTURE SHEET A-1 OF 3 REV. NO. 0	PAJARITO AREA VACUUM PUMP STATION ELEVATIONS		DATE: NOVEMBER 2000	
	COUNTY OF BERNALILLO ENVIRONMENTAL HEALTH AND PUBLIC WORKS DEPARTMENTS		CITY PROJECT NO. 0	
	PROJECT NO. FILE NAME: PLOT DATE: DRAWN BY: DESIGNED BY: CHECKED BY:		NO. DESCRIPTION REV. BY CD. BY DATE	


HDR
 HDR ENGINEERING, INC.
 2155 LOUISIANA BLVD. NE
 SUITE 850
 ALBUQUERQUE, NM. 87110

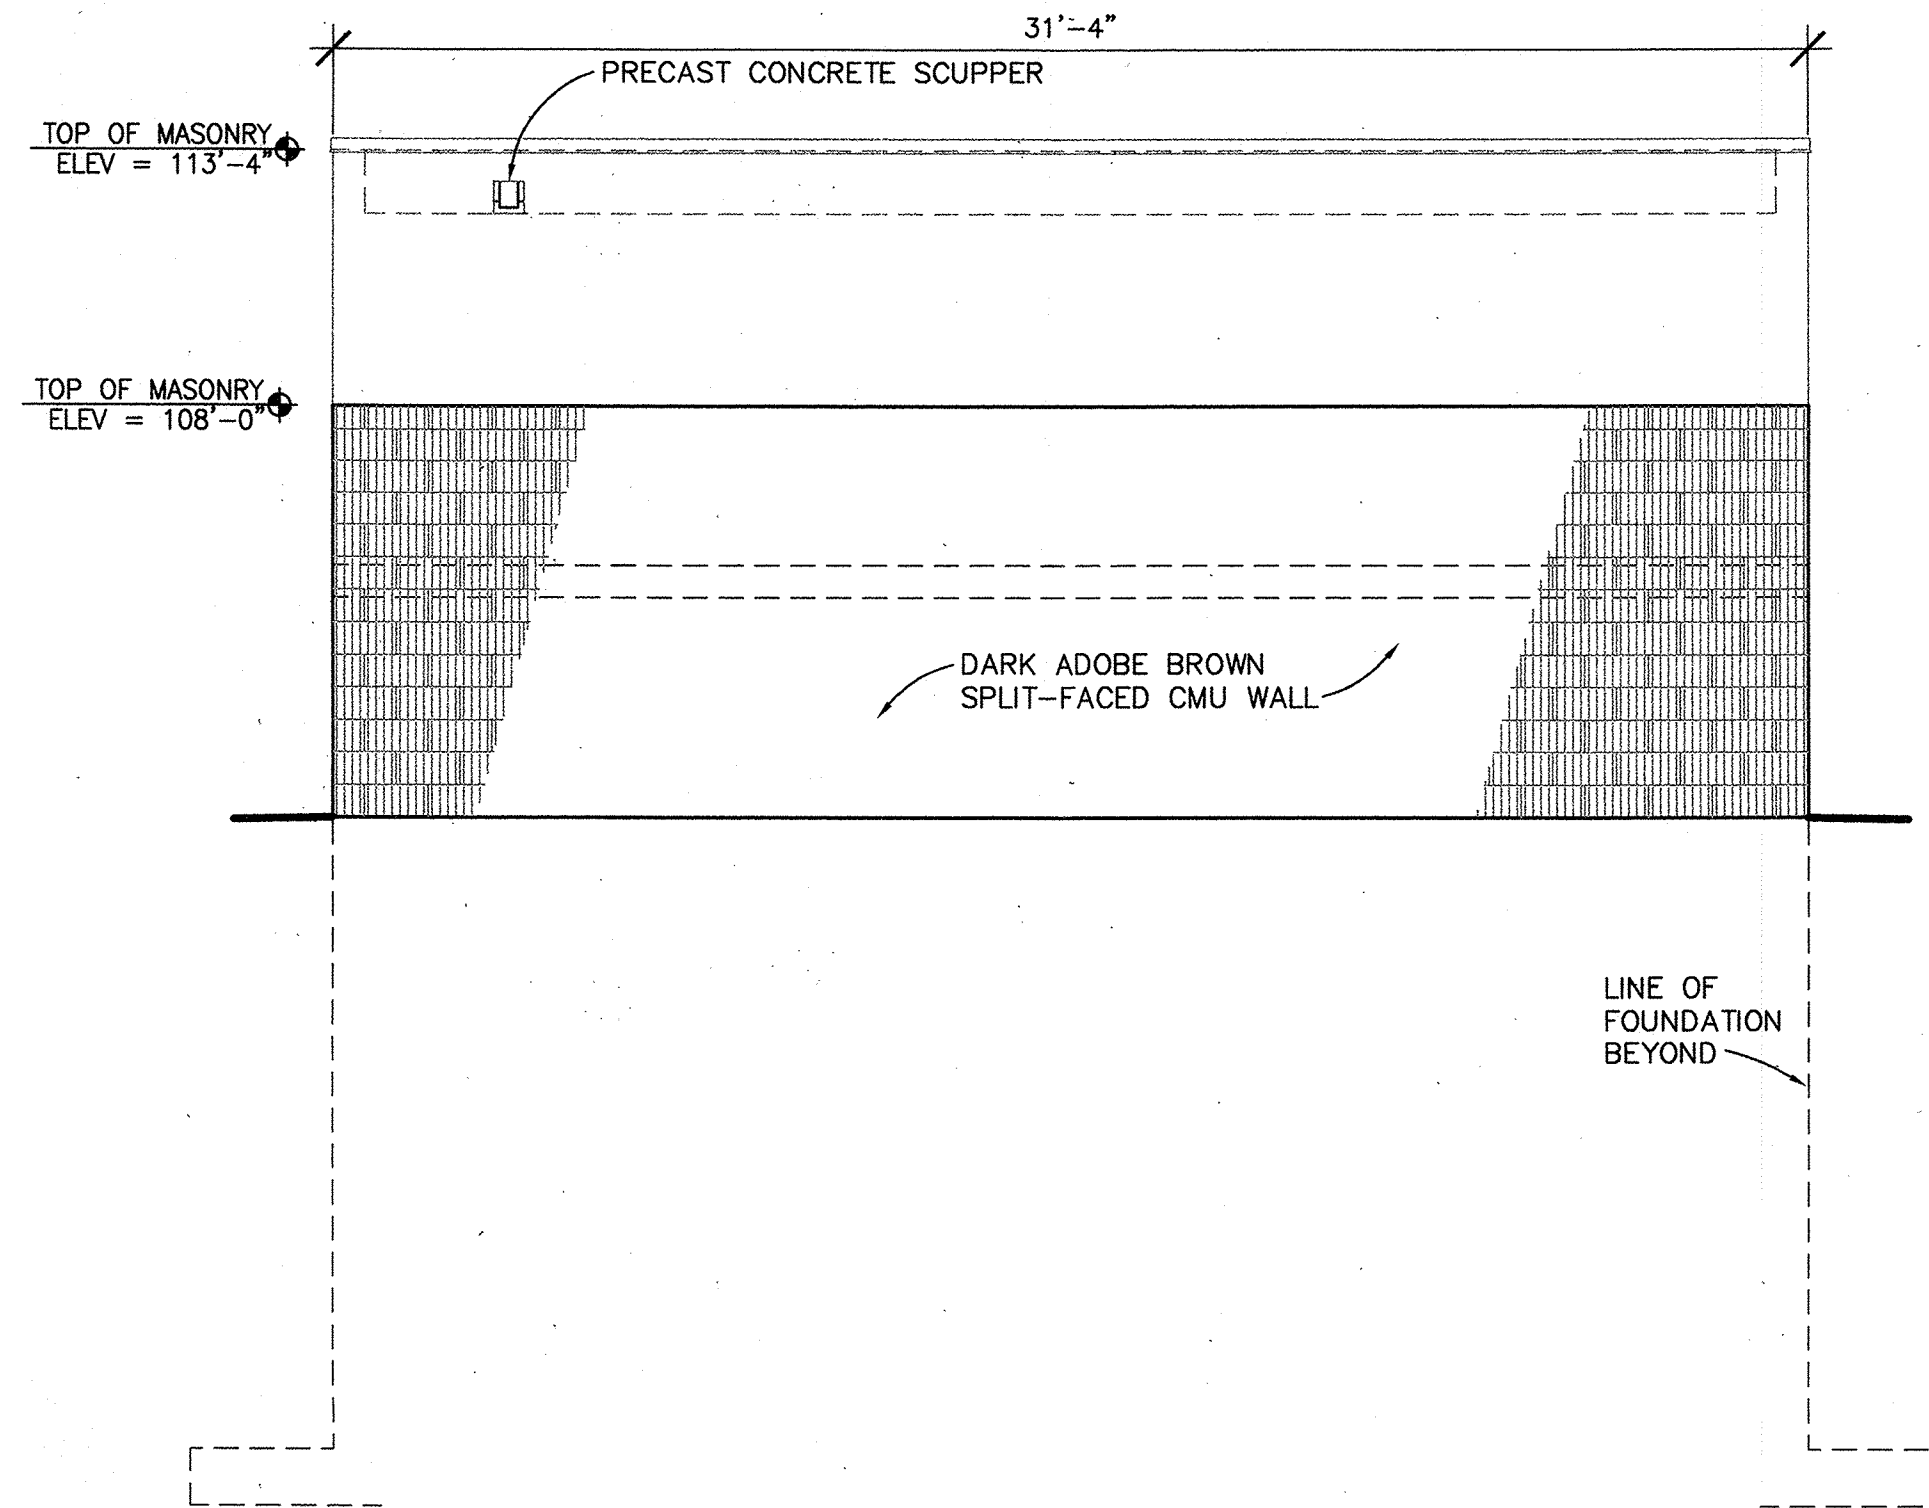


SOUTH ELEVATION
1/4"=1'-0"

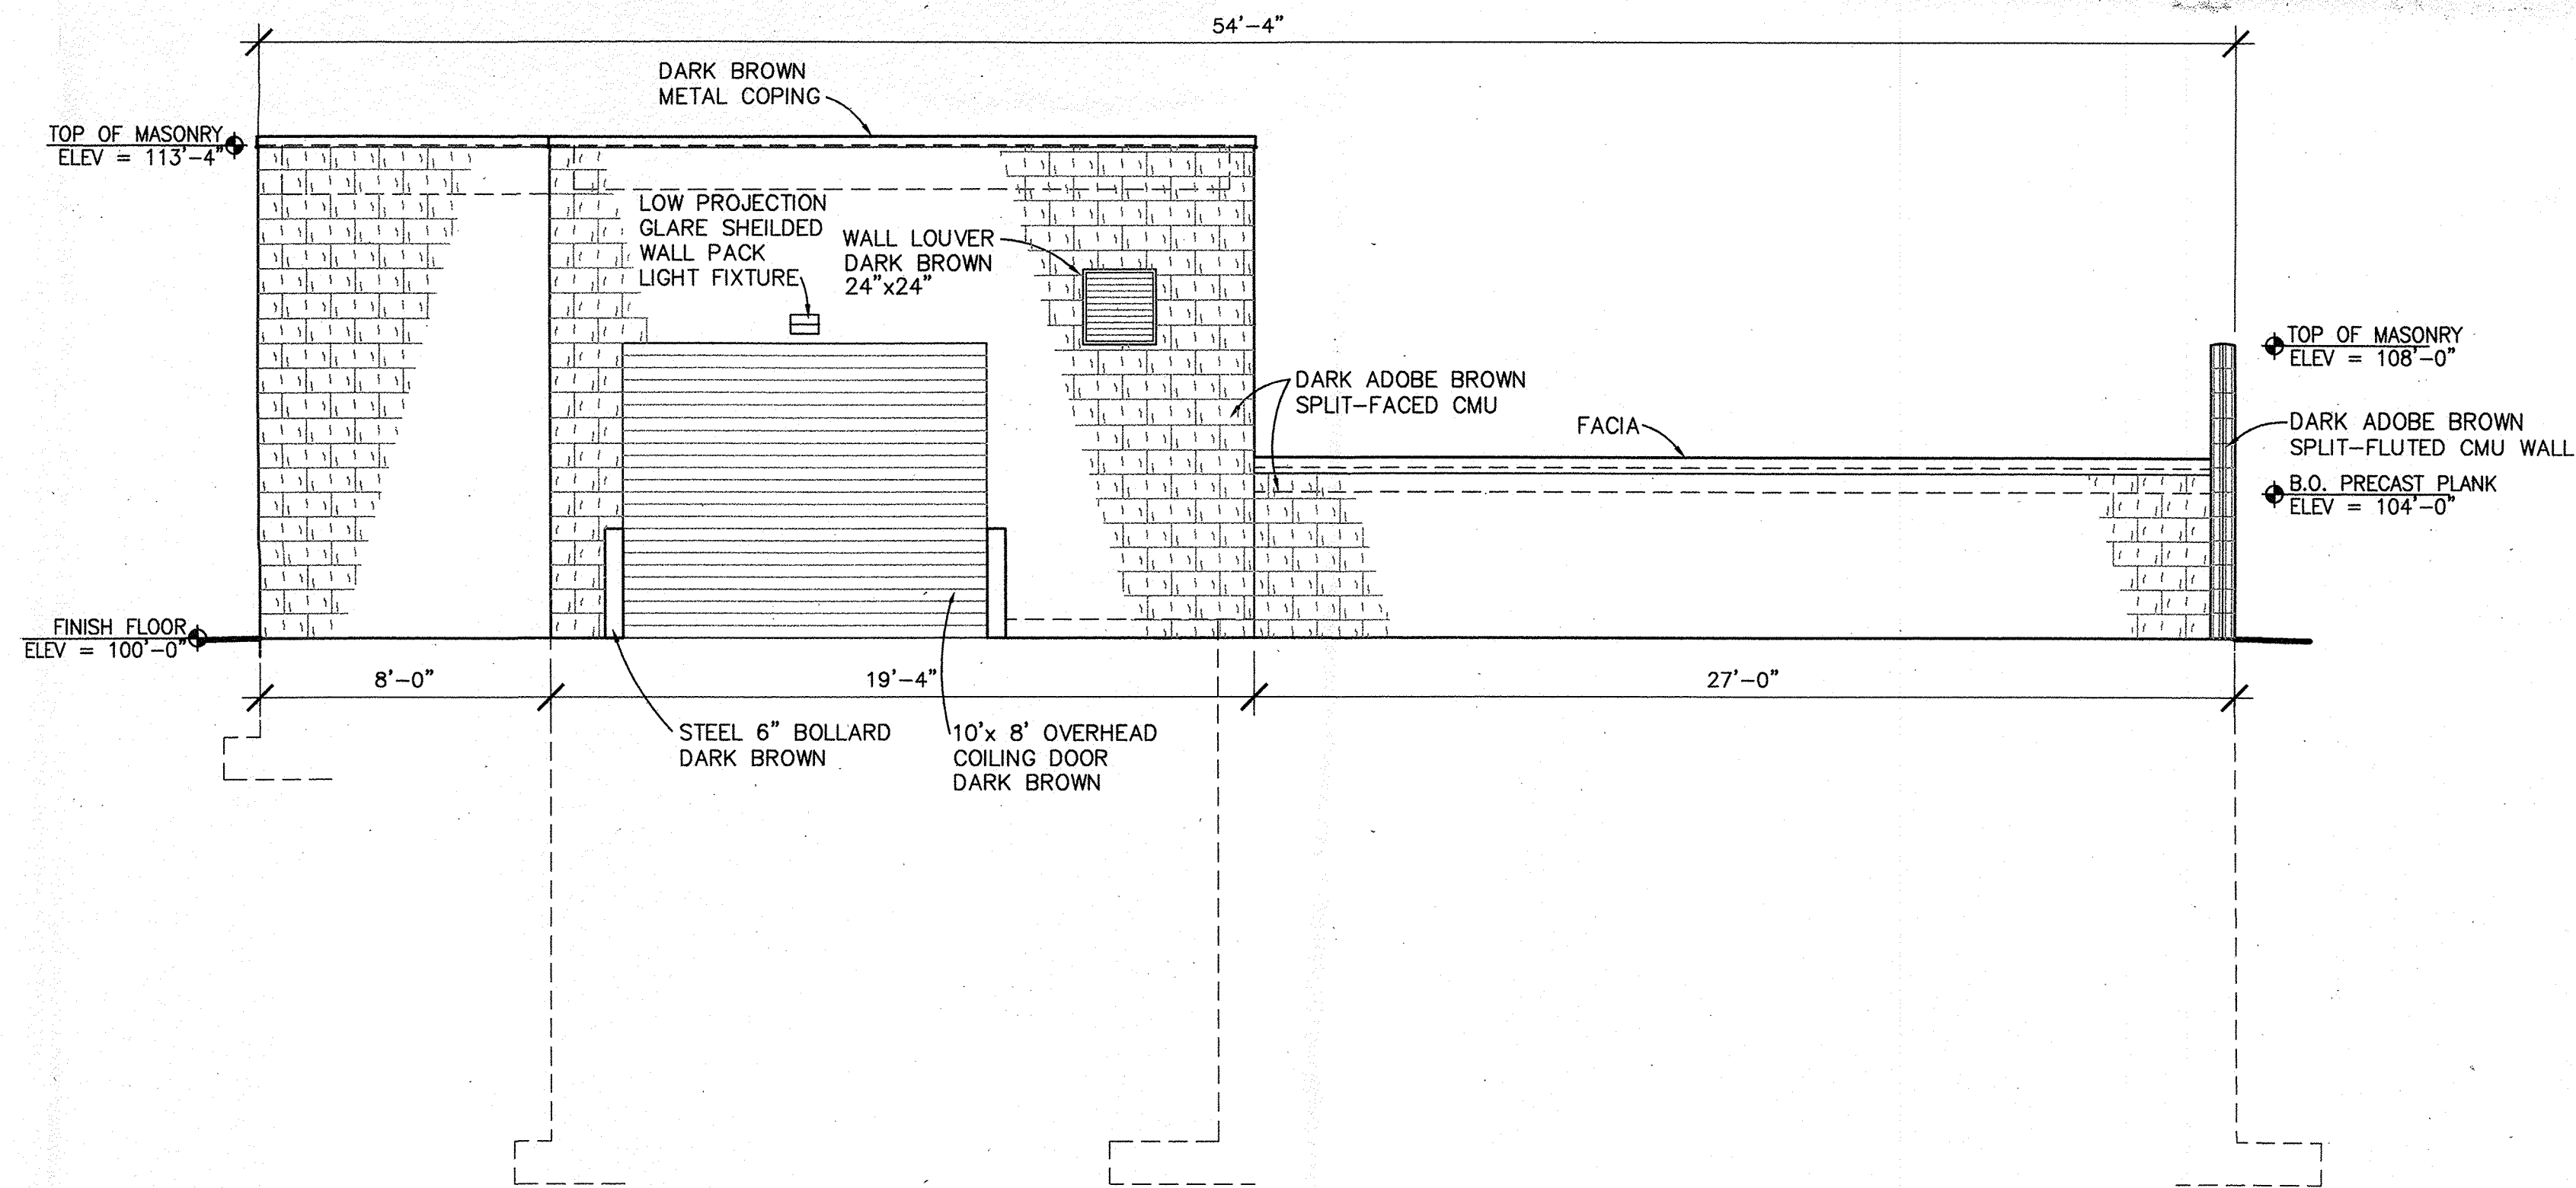

WEST ELEVATION
1/4"=1'-0"

 

 ARCHITECTURE SHEET A-2		PAJARITO AREA VACUUM PUMP STATION ELEVATIONS				COUNTY OF BERNALILLO ENVIRONMENTAL HEALTH AND PUBLIC WORKS DEPARTMENTS		PROJECT NO. FILE NAME PLOT DATE DRAWN BY DESIGNED BY CHECKED BY		 HDR ENGINEERING, INC. 2155 LOUISIANA BLVD. NE ALBUQUERQUE, NM. 87110		REVISIONS TO DRAWINGS	
NO.	OF	CITY PROJECT NO.	DATE:									NO. DESCRIPTION REV. BY OKD. BY DATE	
2	3	0	NOVEMBER 2000										