


NOTE: THIS SHEET IS FOR POND CONSTRUCTION ONLY.
PLEASE SEE SHEETS C101-C104 FOR ONSITE CONSTRUCTION
DETAIL.

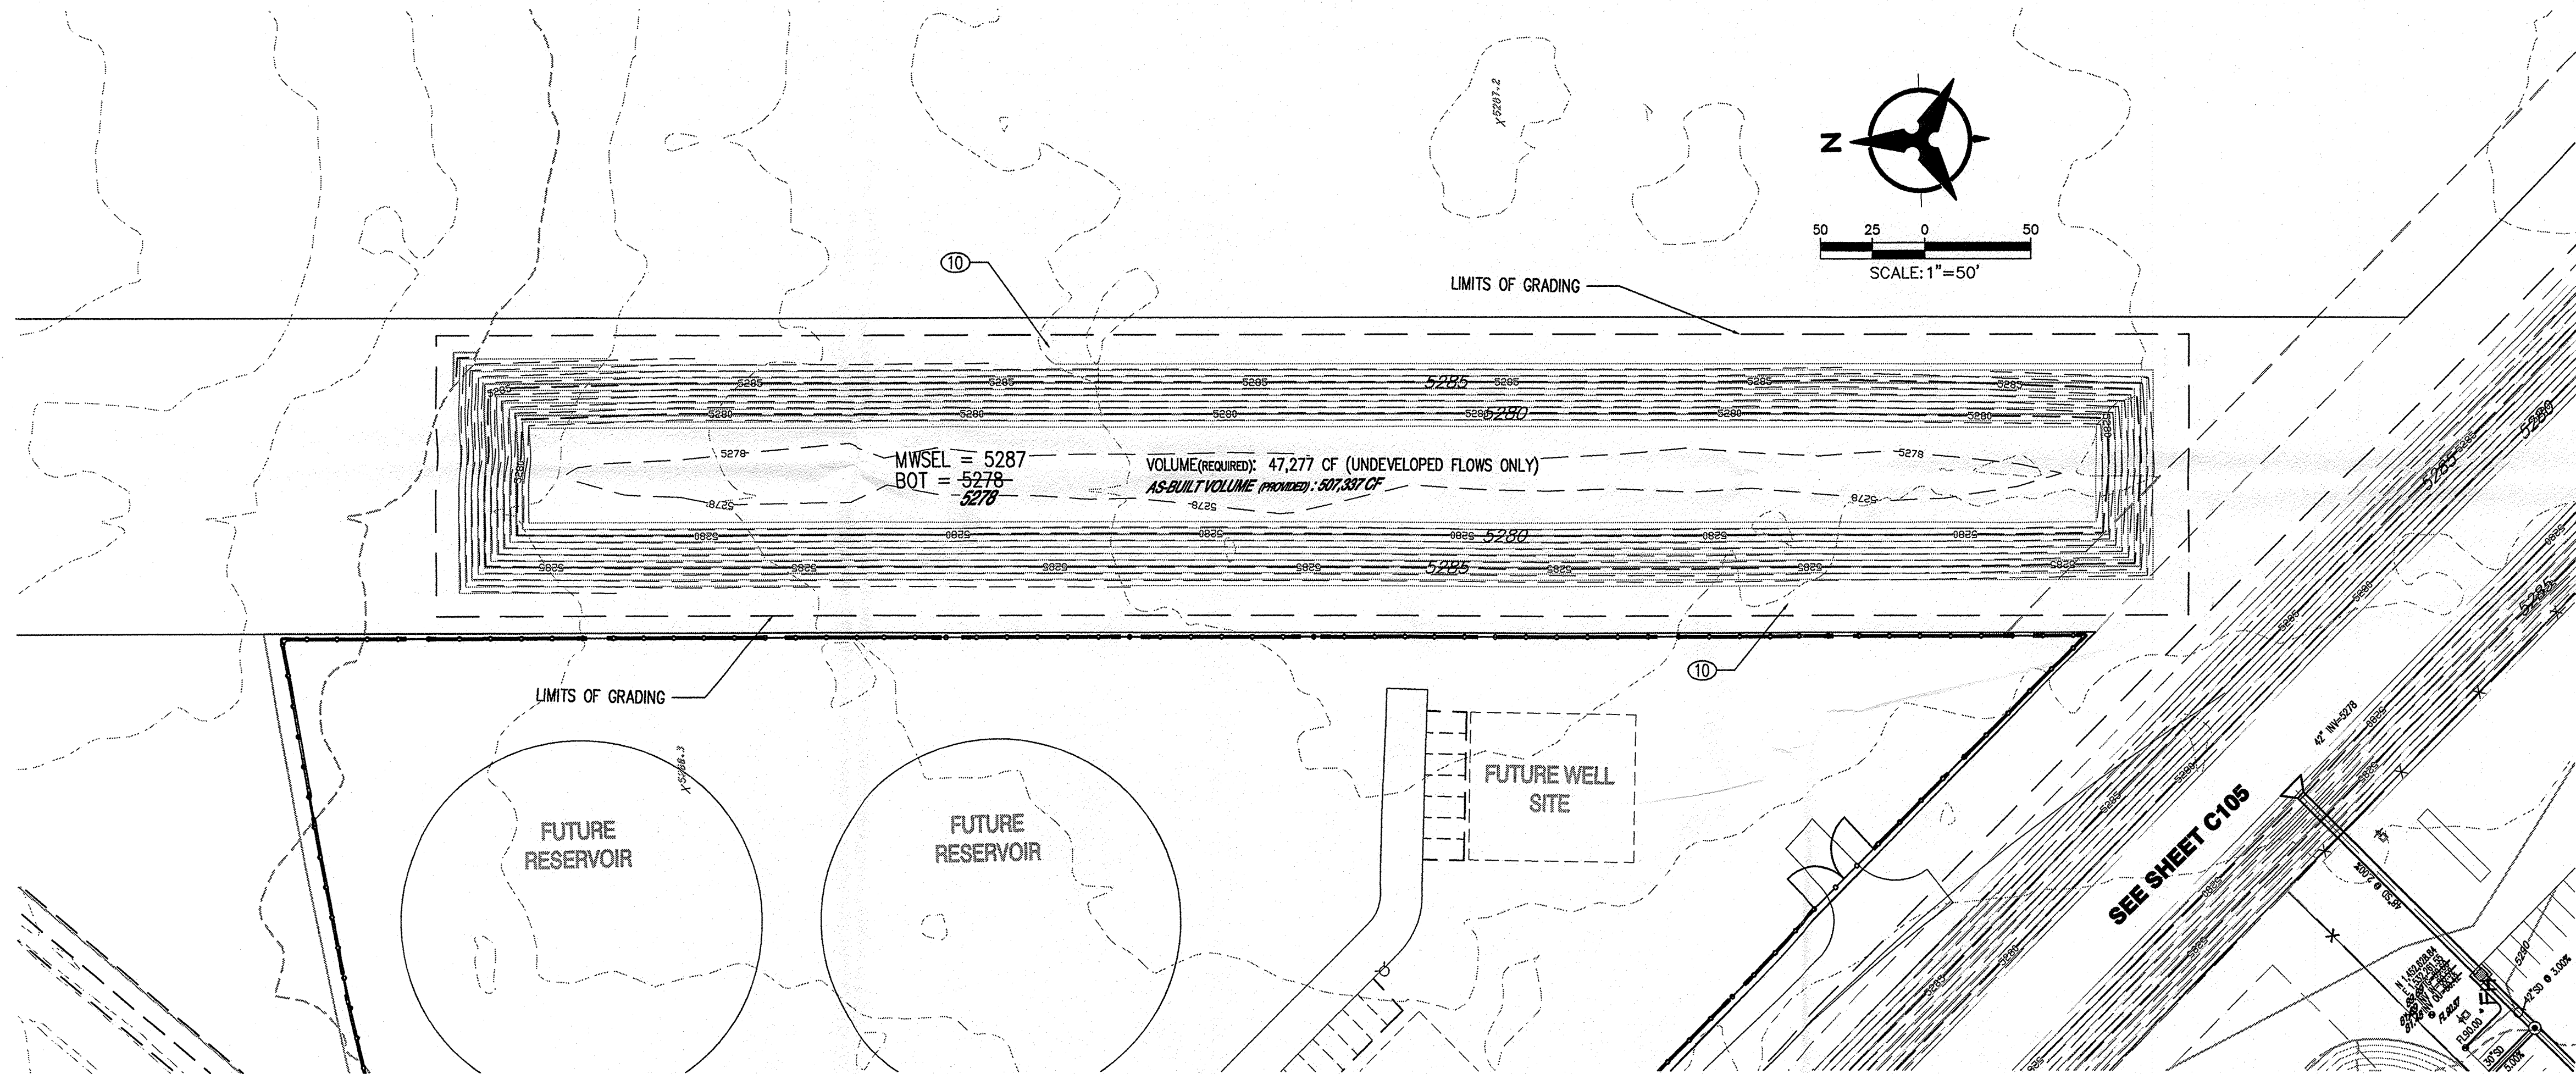

CONSTRUCTION KEYED NOTES

1. INSTALL STORM DRAIN INLET TYPE "D", PER COA STD DWG 2206; OR NYOPLAST ROAD AND HIGHWAY DRAINAGE INLET STRUCTURE W/ 2'X3' STEEL BAR GRATE (261.2 SQ. IN. APPROXIMATE DRAIN AREA) H-25 RATED GRATE (OR APPROVED EQUAL).
2. INSTALL HDPE STORM DRAIN PIPE (ADS N-12 OR APPROVED EQUAL) SIZE PER PLAN
3. INSTALL CMP FLARED END SECTION. (CONTECH OR APPROVED EQUAL), SIZE PER PLAN
4. INSTALL 2" CURB OPENING FOR DRAINAGE, PER DETAIL, SHEET C101.
5. CONSTRUCT 24" SIDEWALK CULVERT PER COA STD DWG 2236.
6. INSTALL 6" DIA TYPE "C" SD MANHOLE PER COA STD DWG 2101
7. VALLEY GUTTER PER DETAIL, SHEET C101.
8. CONSTRUCT STORM DRAIN (SEE PLAN FOR SIZE) TO WITHIN 5' OF BUILDING. SEE PLUMBING PLANS FOR CONTINUATION.
9. INSTALL PRE FABRICATED DRAINAGE FITTING (NYPLAST, OR APPROVED EQUAL), OR INSERT-A-TEE. SEE PLANS FOR SIZES.
10. TIE BACK TO EXISTING GRADE MAX SLOPE 4:1.
11. PROVIDE 18" OPENING IN WALL. SEE PLANS FOR INVERT.

LEGEND

---	PROPERTY LINE
---5.301---	EXISTING CONTOURS
X 5.301.15	EXISTING GROUND SPOT ELEVATION
●	EXISTING ELECTRICAL POLE
● 65.23	PROPOSED SPOT ELEVATION TC=TOP OF CURB, FL=FLOW LINE TW=TOP OF WALL, BW=BOTTOM OF WALL EX=EXISTING, TO=TOP OF GRATE
S=2.0%	PROPOSED DIRECTION OF FLOW
~~~~~	GRADE BREAK
=====	PROPOSED RETAINING WALL
---5.305---	PROPOSED INDEX CONTOURS
---	PROPOSED INTER CONTOURS
---5.305---	ASBUILT POND INDEX CONTOURS
---	ASBUILT POND INTER CONTOURS
=====	PROPOSED CURB & GUTTER
---	EASEMENT
☼	EXISTING TREE
⬢	PROPOSED LIGHTING
=====	PROPOSED STORM DRAIN LINE
○	PROPOSED STORM DRAIN MANHOLE
■	PROPOSED STORM DRAIN INLET
⊙	EXISTING STORM DRAIN MANHOLE
● 55.23 94.90 93.67	ASBUILT ELEVATION

#### DRAINAGE CERTIFICATION

BUILDINGS 1,2,3, & 6

I, JEFFREY L. MULBERRY, NMPE 16858, OF THE FIRM BOHANNAN HUSTON INC., HEREBY CERTIFY THAT THIS PROJECT HAS BEEN GRADED AND WILL DRAIN IN SUBSTANTIAL COMPLIANCE WITH AND IN ACCORDANCE WITH THE DESIGN INTENT OF THE APPROVED PLAN DATED 08-29-06. THE RECORD INFORMATION EDITED ONTO THE ORIGINAL DESIGN DOCUMENT HAS BEEN OBTAINED BY ROBERT GROMATZKY, NMPS 16469, OF THE FIRM BOHANNAN HUSTON. I FURTHER CERTIFY THAT I HAVE PERSONALLY VISITED THE PROJECT SITE ON 01-11-08 AND HAVE DETERMINED BY VISUAL INSPECTION THAT THE SURVEY DATA PROVIDED IS REPRESENTATIVE OF ACTUAL SITE CONDITIONS AND IS TRUE AND CORRECT TO THE BEST OF MY KNOWLEDGE AND BELIEF. THIS CERTIFICATION IS SUBMITTED IN SUPPORT OF A REQUEST FOR PERMANENT CERTIFICATE OF OCCUPANCY. THE RECORD INFORMATION PRESENTED HEREON IS NOT NECESSARILY COMPLETE AND INTENDED ONLY TO VERIFY SUBSTANTIAL COMPLIANCE OF THE GRADING AND DRAINAGE ASPECTS OF THIS PROJECT. THOSE RELYING ON THIS RECORD DOCUMENT ARE ADVISED TO OBTAIN INDEPENDENT VERIFICATION OF ITS ACCURACY BEFORE USING IT FOR ANY OTHER PURPOSE.

4/10/08  
JEFFREY L. MULBERRY, NMPE 16858



RECEIVED

APR 01 2008

HYDROLOGY  
SECTION

**Bohannon & Huston**

Courtyard 1 7500 Jefferson St. NE Albuquerque, NM 87109-4335  
ENGINEERING & SPATIAL DATA & ADVANCED TECHNOLOGIES

architecture  
interiors  
planning  
engineering

**Dekker  
Perich  
Sabatini**

8801 Jefferson NE  
Suite 100  
Albuquerque, NM 87109  
505 761-9700  
fax 761-4222  
dps@dpsabq.com

ARCHITECT

ENGINEER



PROJECT

**Mesa Del Sol  
Film Studio**  
Albuquerque, New Mexico

REVISIONS

△  
△  
△  
△

DRAWN BY	CM
REVIEWED BY	JLM
DATE	08/24/06
PROJECT NO.	06023
DRAWING NAME	

**GRADING AND  
DRAINAGE  
PLAN**

SHEET NO.

**C106**

OF

